



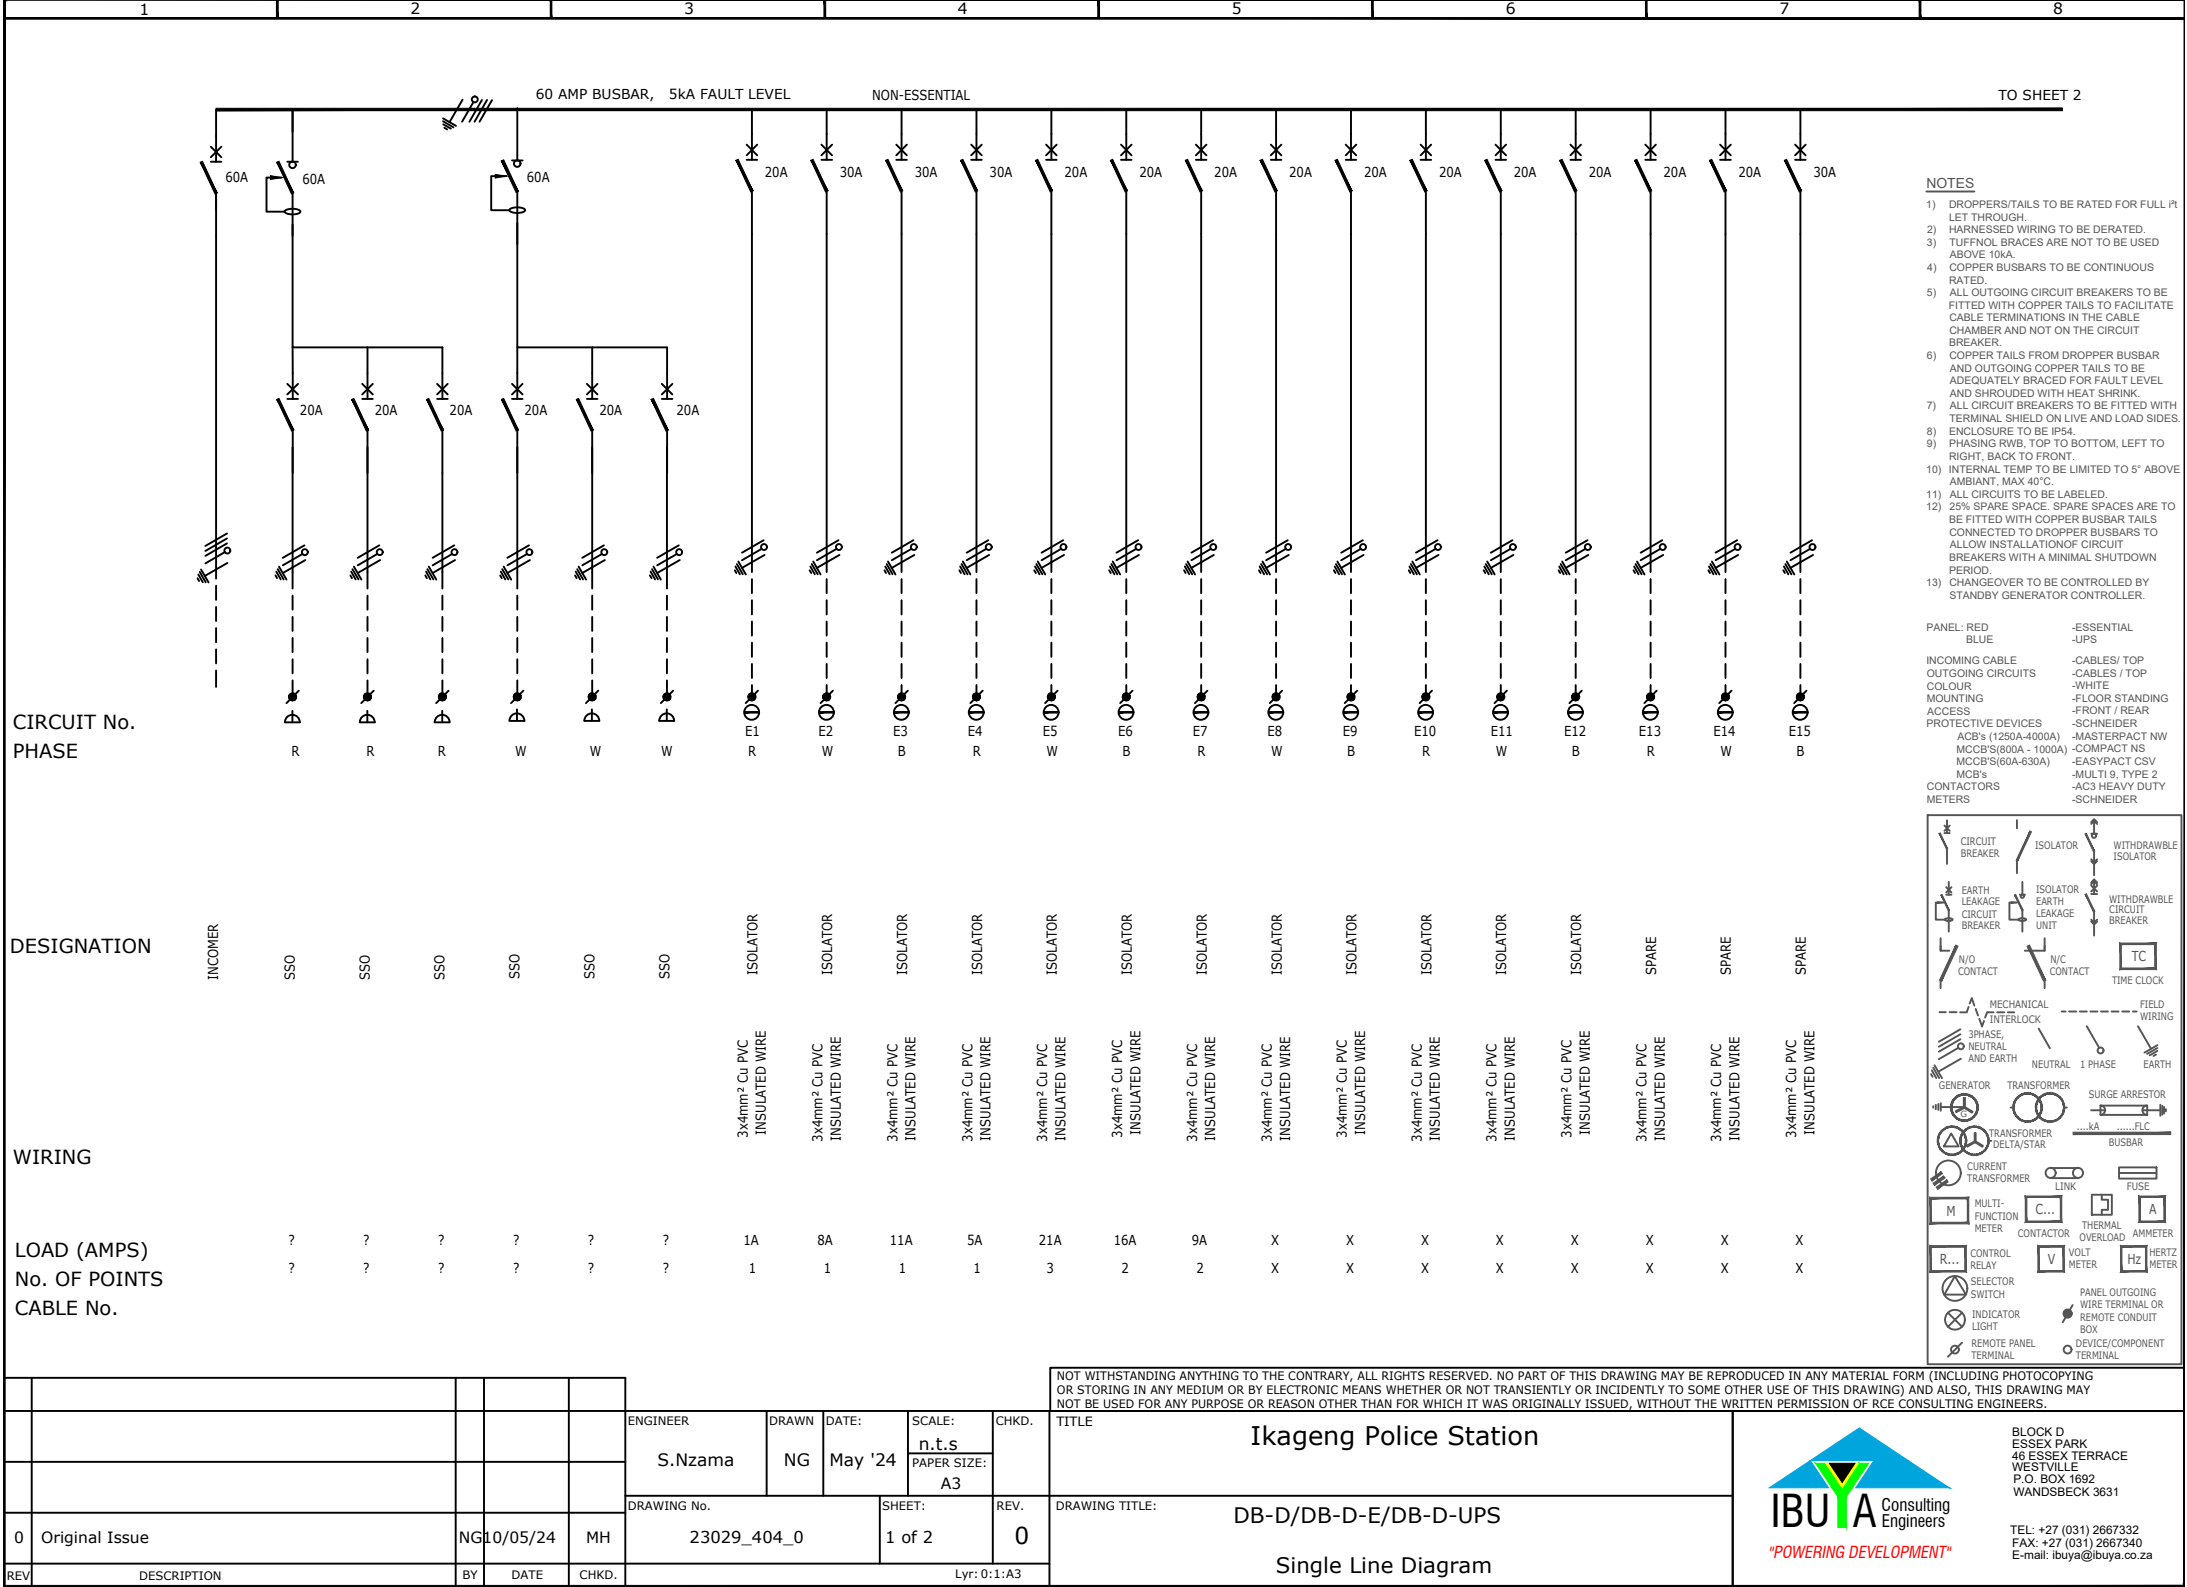

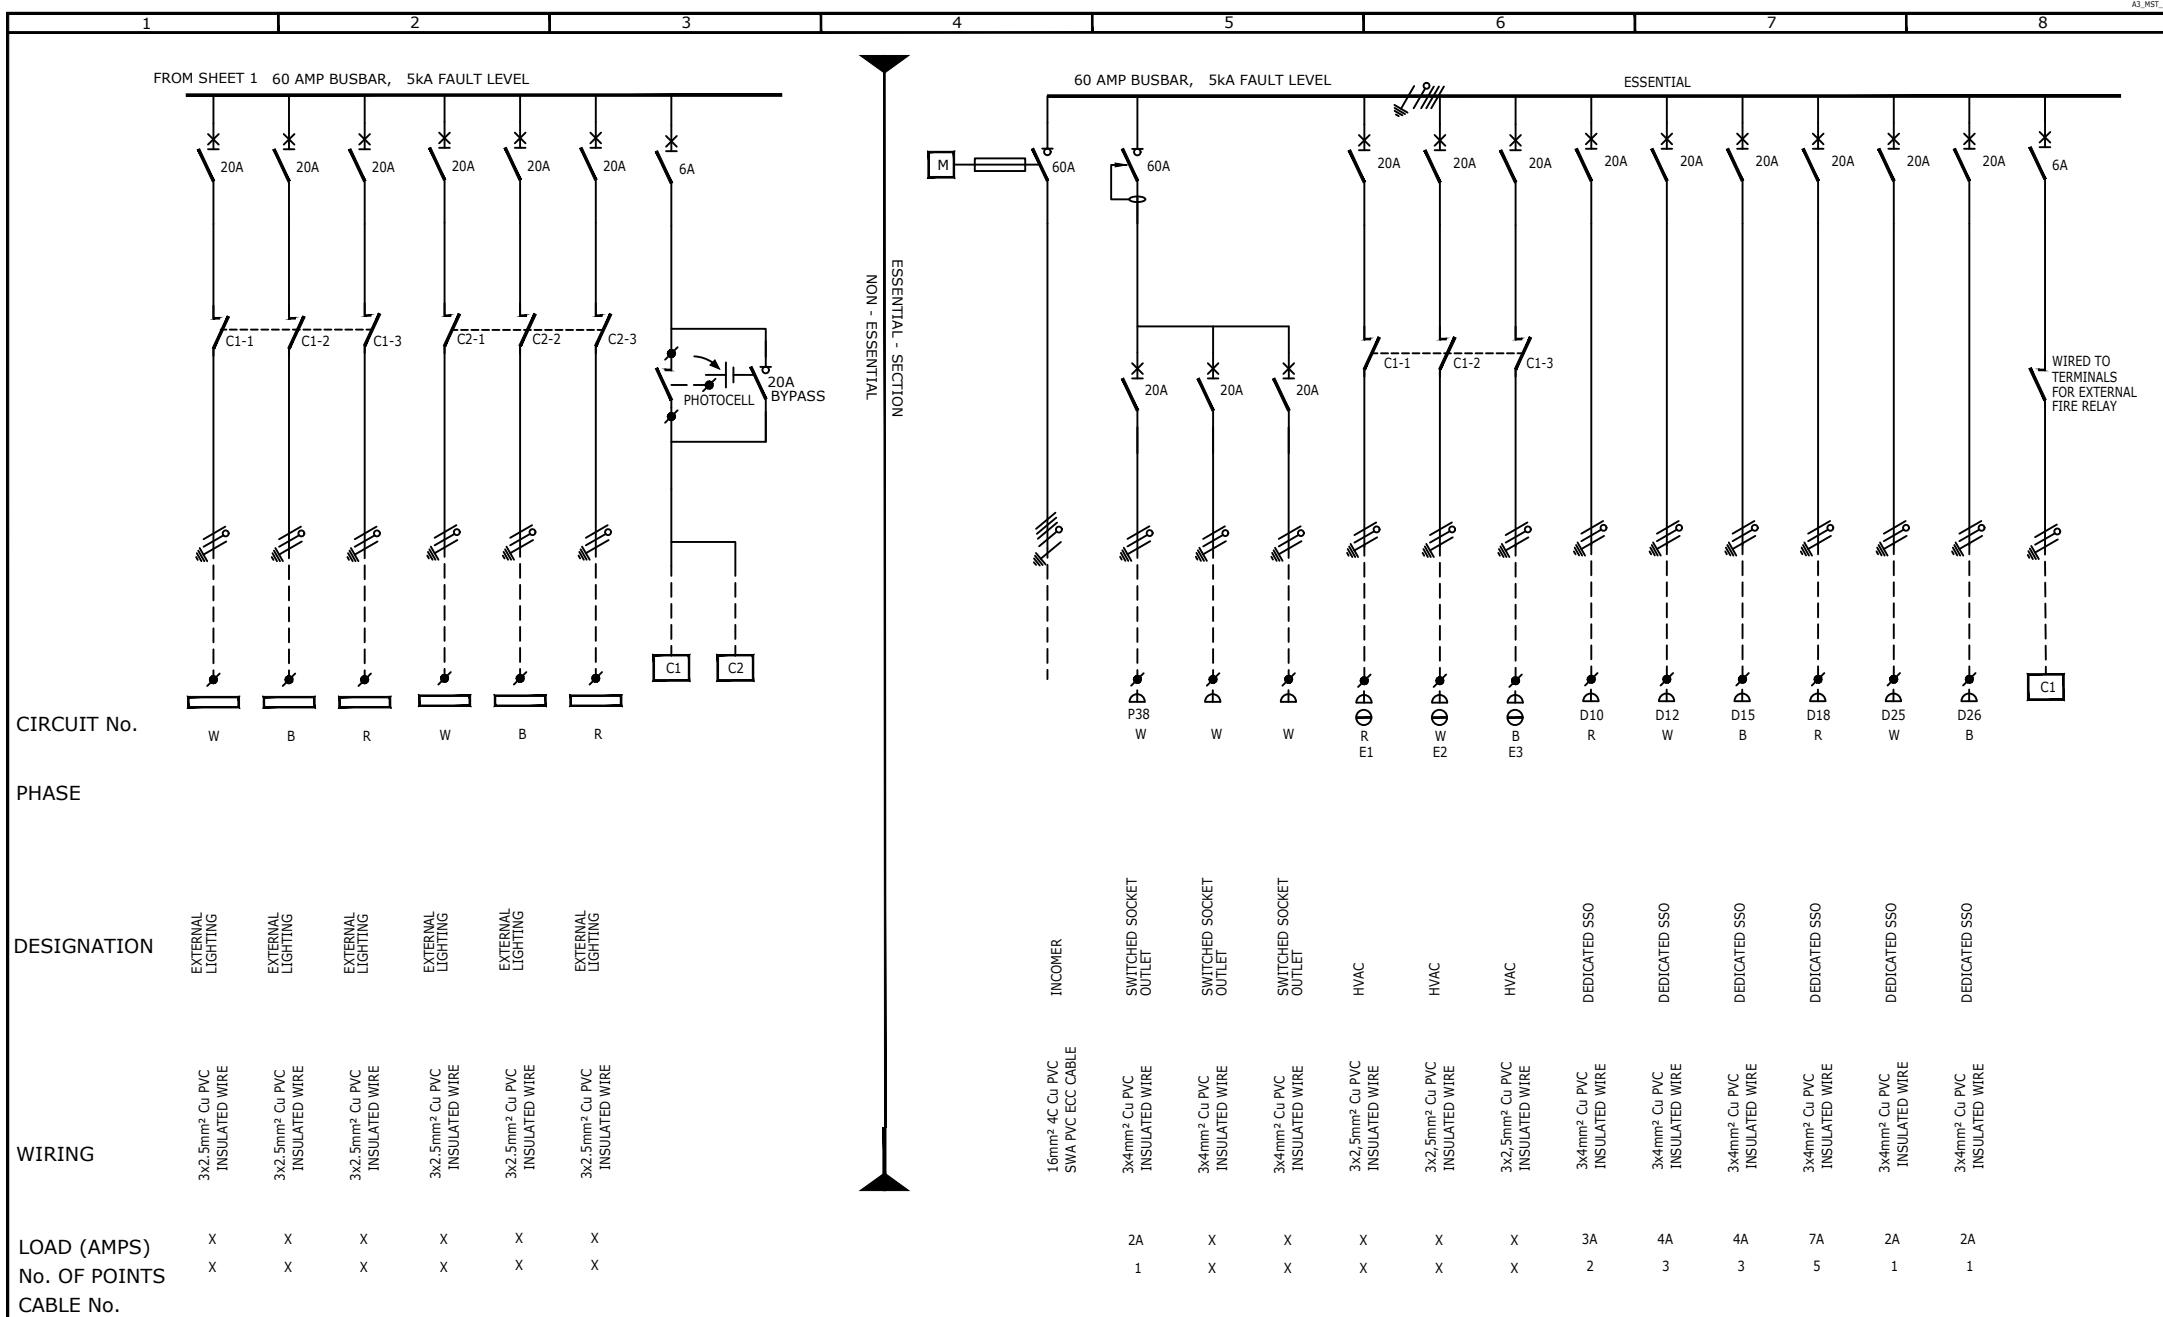

										NOT WITHSTANDING ANYTHING TO THE CONTRARY, ALL RIGHTS RESERVED. NO PART OF THIS DRAWING MAY BE REPRODUCED IN ANY MATERIAL FORM (INCLUDING PHOTOCOPYING OR STORING IN ANY MEDIUM OR BY ELECTRONIC MEANS WHETHER OR NOT TRANSIENTLY OR INCIDENTALLY TO SOME OTHER USE OF THIS DRAWING) AND ALSO, THIS DRAWING MAY NOT BE USED FOR ANY PURPOSE OR REASON OTHER THAN FOR WHICH IT WAS ORIGINALLY ISSUED, WITHOUT THE WRITTEN PERMISSION OF RCE CONSULTING ENGINEERS.													
							ENGINEER	DRAWN	DATE:	SCALE:	CHKD.	TITLE Ikageng Police Station											
							S.Nzama	NG	May '24	n.t.s													
									PAPER SIZE:	A3													
							DRAWING No.				SHEET:		REV.	DRAWING TITLE: DB-D/DB-D-E/DB-D-UPS									
0	Original Issue					NG	10/05/24	MH	23029_404_0				2 of 2										
REV	DESCRIPTION				BY	DATE	CHKD.	Lyr: 0:1:A3				Single Line Diagram											
										 IBUYA Consulting Engineers "POWERING DEVELOPMENT" BLOCK D ESSEX PARK 46 ESSEX TERRACE WESTVILLE P.O. BOX 1692 WANDSBECK 3631 TEL: +27 (031) 2667332 FAX: +27 (031) 2667340 E-mail: ibuya@ibuya.co.za													