


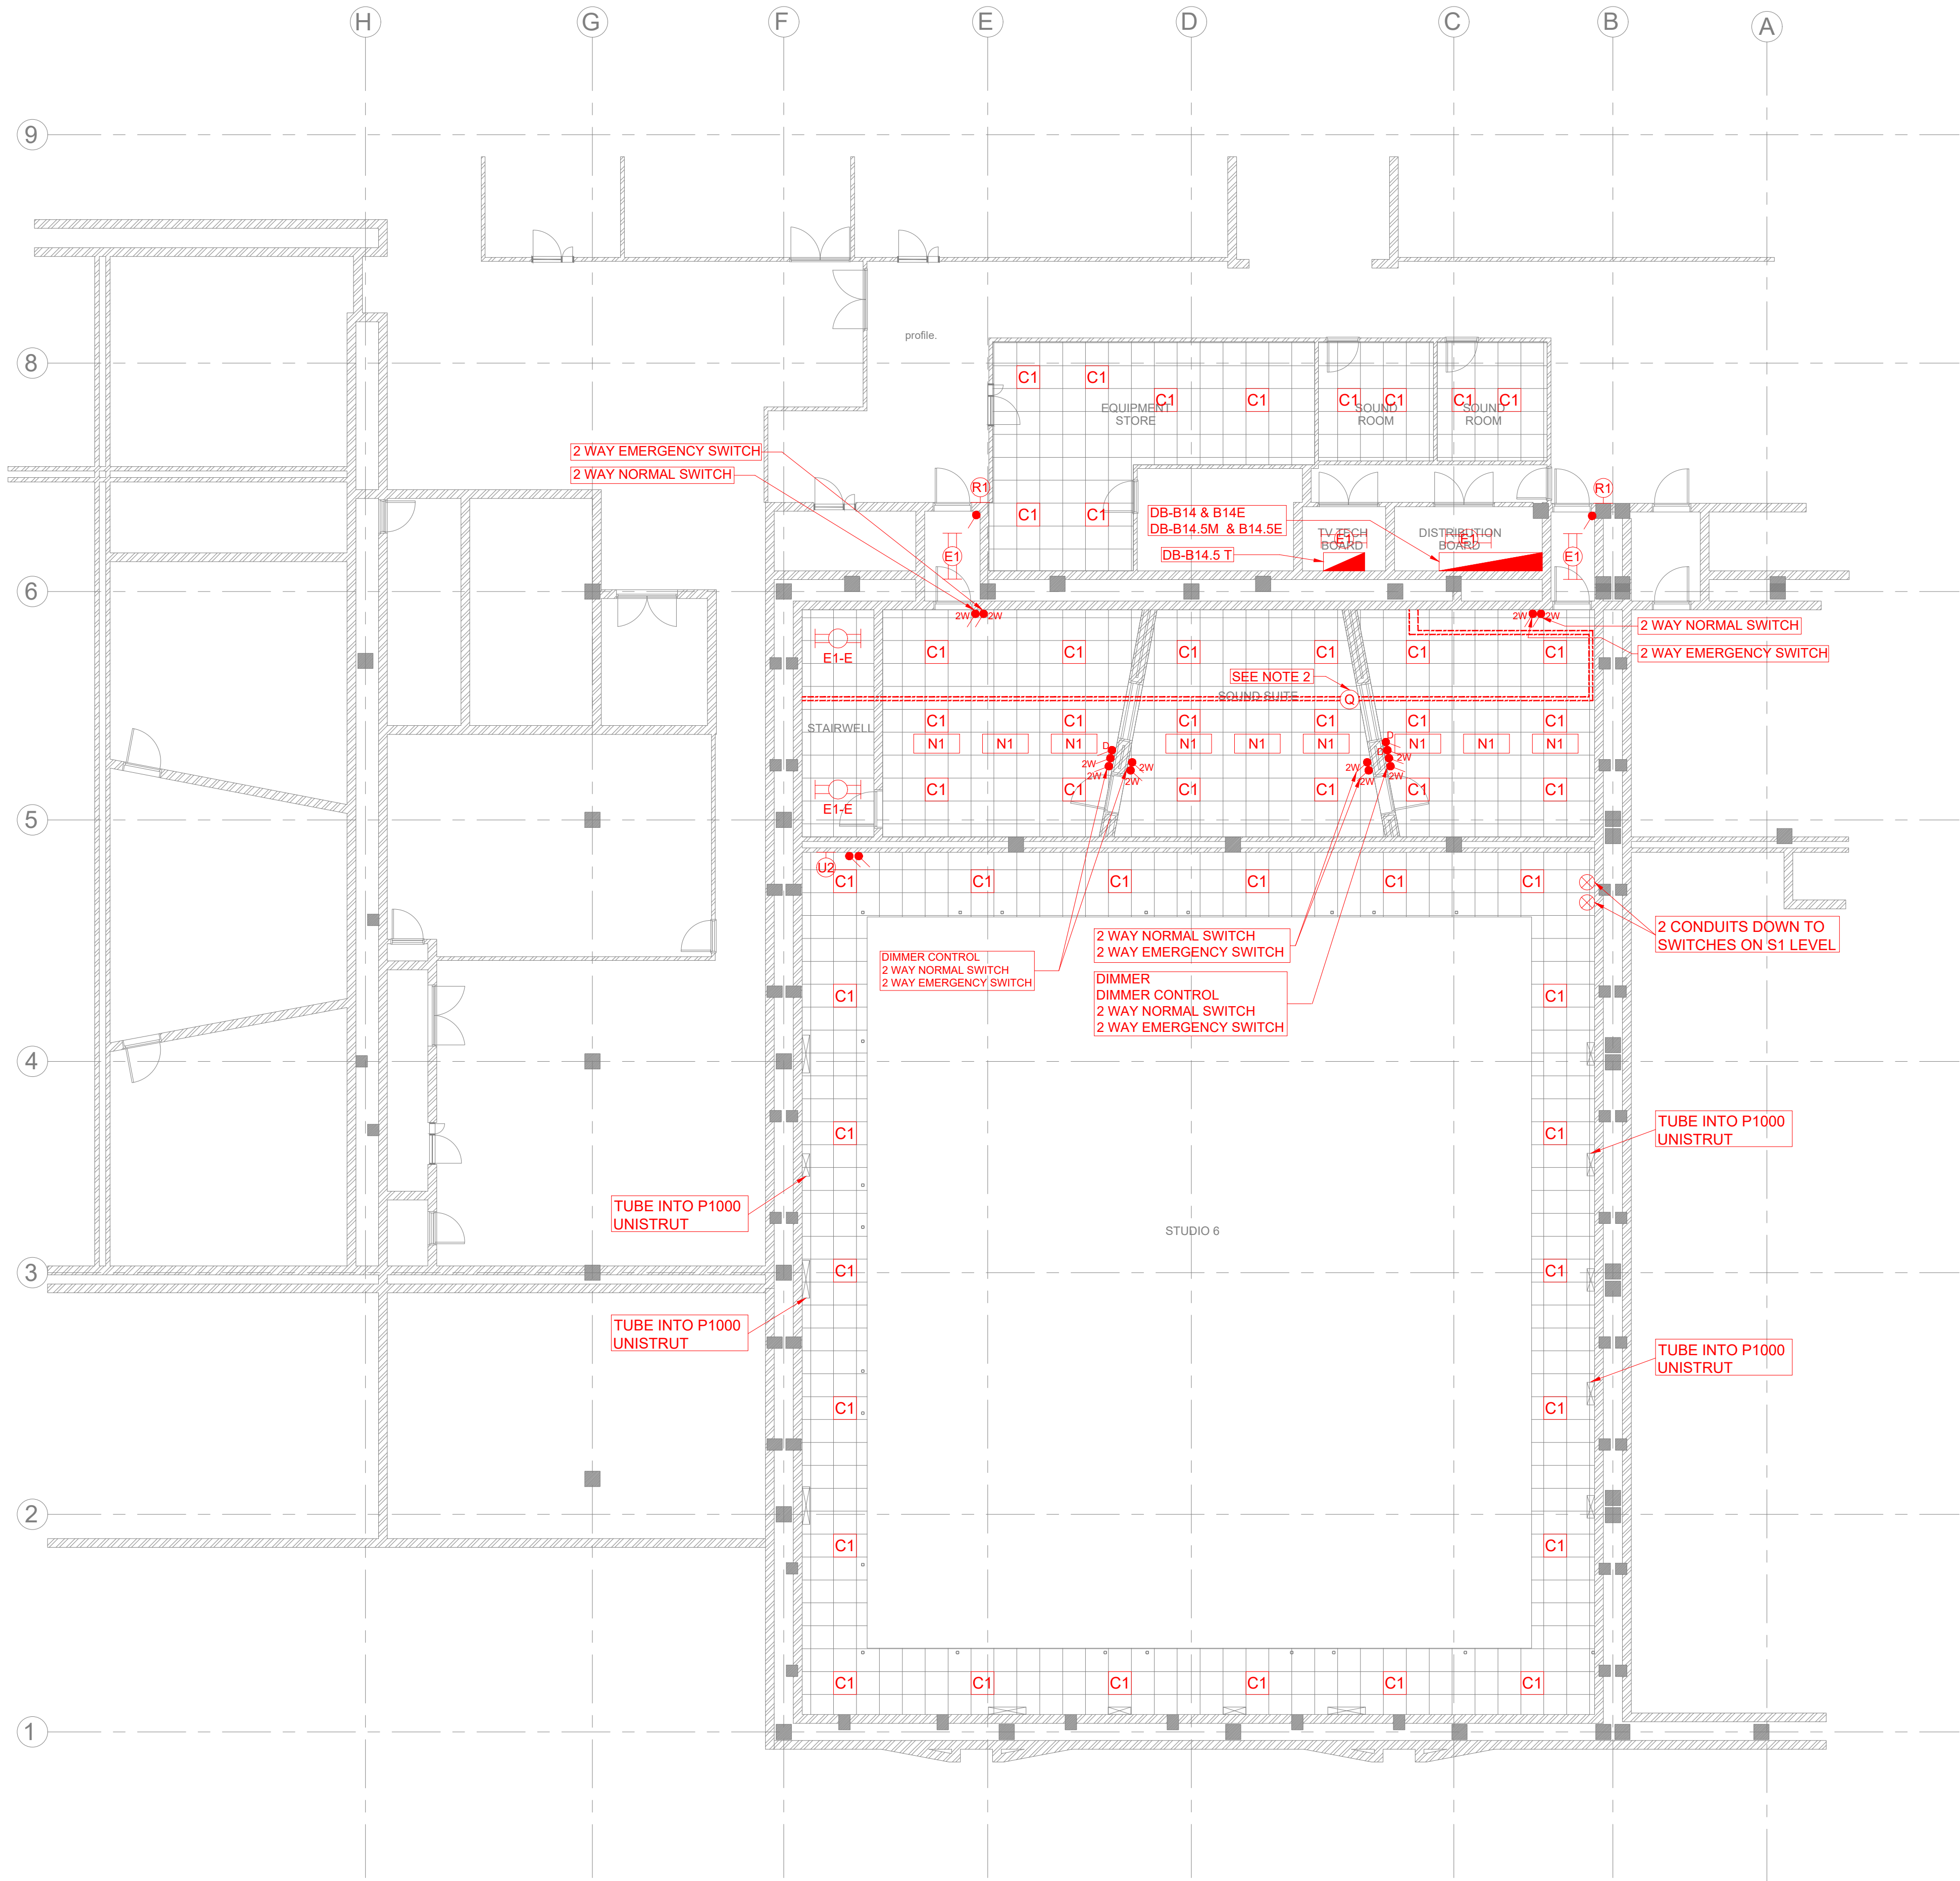

- NOTES**
- UNISTRUT & CONDUITS TO BE FIXED TO SLAB.
 - ALL FITTINGS TO BE SUPPORTED FROM SLAB EXCEPT 'Q' FITTINGS.
 - 'N1' & 'E1' TYPE FITTINGS TO BE SURFACE MOUNTED.

copyright

In accordance with the relevant clauses of the Copyright Act 1978 (Act 98 of 1978) relating to assignment, all documents prepared by SABC in connection with the project remain the property and copyright of SABC, subject to their use by the client for the particular project to which this document relates, and the client shall not be entitled, either directly or indirectly, to make use of the document(s) for the carrying out of any additional or similar works or publish the same except with the prior consent from SABC.

general notes

- All work is to be done in accordance with the National Building Regulations.
- All materials and workmanship are to comply with the relevant S.A.N.S. codes.
- This drawing is not to be scaled. Figured dimensions to be used.
- This drawing must be read in conjunction with all the relevant drawings and specifications issued by qualified architects, engineers, and other consultants.
- All dimensions and levels must be checked on site by the contractor before putting work in hand.

LEGEND

C1	600x600 LED PANEL LIGHT, 37W, DIMMABLE, WHITE TRIM, WITH 3m CHORD & 5A FLUGTOP
E1-E	DUST & MOISTURE PROOF FLUORESCENT - TYPE FITTING, LED, 37W, 1200mm
E1-E	DUST & MOISTURE PROOF FLUORESCENT - TYPE FITTING, LED, 37W, 1200mm WITH INTEGRATED 30 MINUTES BATTERY BACKUP
E2	DUST & MOISTURE PROOF FLUORESCENT - TYPE FITTING, LED, 37W, 1200mm, DIMMABLE
E3	DUST & MOISTURE PROOF FLUORESCENT - TYPE FITTING, LED, 54W, 1200mm, DIMMABLE
F	BULKHEAD, LED, 12W, SURFACE MOUNT, ROUND, WHITE TRIM
NT	DIRECTIONAL LIGHT FITTING, LED, SURFACE MOUNT, 1200mm, DIMMABLE, WITH 3m CHORD & 5A FLUGTOP, BLACK TRIM
Q	RECESSED WALL LIGHT, LED, 4W, WITH GRID SQUARE SILVER FINISH, MOUNTED @575mm A.F.F.L. NEXT TO DIMMER BOX
R1	BULKHEAD, LED, SURFACE MOUNT, BLACK TRIM
U	ILLUMINATED EXIT/DIRECTIONAL SIGNAGEL LED, SURFACE MOUNT
U2	ILLUMINATED EXIT/DIRECTIONAL SIGNAGEL LED, SURFACE MOUNT
V	ILLUMINATED EXIT/DIRECTIONAL SIGNAGEL LED, SURFACE MOUNT
W	BULKHEAD, LED, 12W, SURFACE MOUNT, ROUND, BLACK TRIM
	LIGHT SWITCH
	2 WAY LIGHT SWITCH
	DIMMER OUTLET BOX

FOR TENDER

NO	DATE	REVISION	DRAWN
00	14/10/21	ISSUED FOR INFORMATION	N.T
01	17/11/21	ISSUED FOR TENDER	N.T

CLIENT



TECHNICAL CONSULTANT



DESIGNED	NAME	SIGNATURE	DATE	SHEET SIZE
DRAWN	NT			A1
VERIFIED	WN			
VALIDATED				SCALE
				1:100
				STATUS LEGEND
				Information
				Tender
				Construction
				As-built

IMPLEMENTING AGENT

PROJECT:
REFURBISHMENT OF TV STUDIO 6 IN
TV CENTRE ON ERF 2
UITSAASENTRUM

DRAWING TITLE:

SECOND FLOOR
LIGHTING LAYOUT

DRG No:EL-LI300-REV-01-SK