


SYMBOL	DESCRIPTION	QTY	MAKE
Z1	SUITABLE ZONE 1 EX LED LUMINAIRE	10	TBC
Z2	SUITABLE ZONE 2 EX LED LUMINAIRE	15	TBC
RM	RAIL MOUNT	9	
FM	FLOOR MOUNT	4	
BM	BUND MOUNT	12	
	PROPOSED CABLE ROUTE		
	EXISTING CABLE		

- SPECIAL NOTES:
- MINIMUM REQUIRED LIGHTING LUX LEVELS
AS PER PL 682 SPEC
- NOTES:
- 1.RACKING TO COMPLY WITH TPL SPECIFICATION PL727.
 - 2.RACKING MATERIAL: GALVANISED STEEL LADDER RACK.
 - 3.RACKING TO BE INSTALLED 300mm CLEAR OF FLANGES (TO ALLOW FOR FLOGGING ACCESS).
 - 4.INSTRUMENT AND ELECTRICAL RACKS TO CROSS AT 90 DEGREES.
 - 5.DOUBLE BANKING OF CABLES ON RACKS IS PERMITTED.
 - 6.ONLY MAIN RACKING RETICULATION ROUTES ARE SHOWN, SECONDARY RACKING AND ANGLE IRON DROPPERS TO BE SITE RUN.

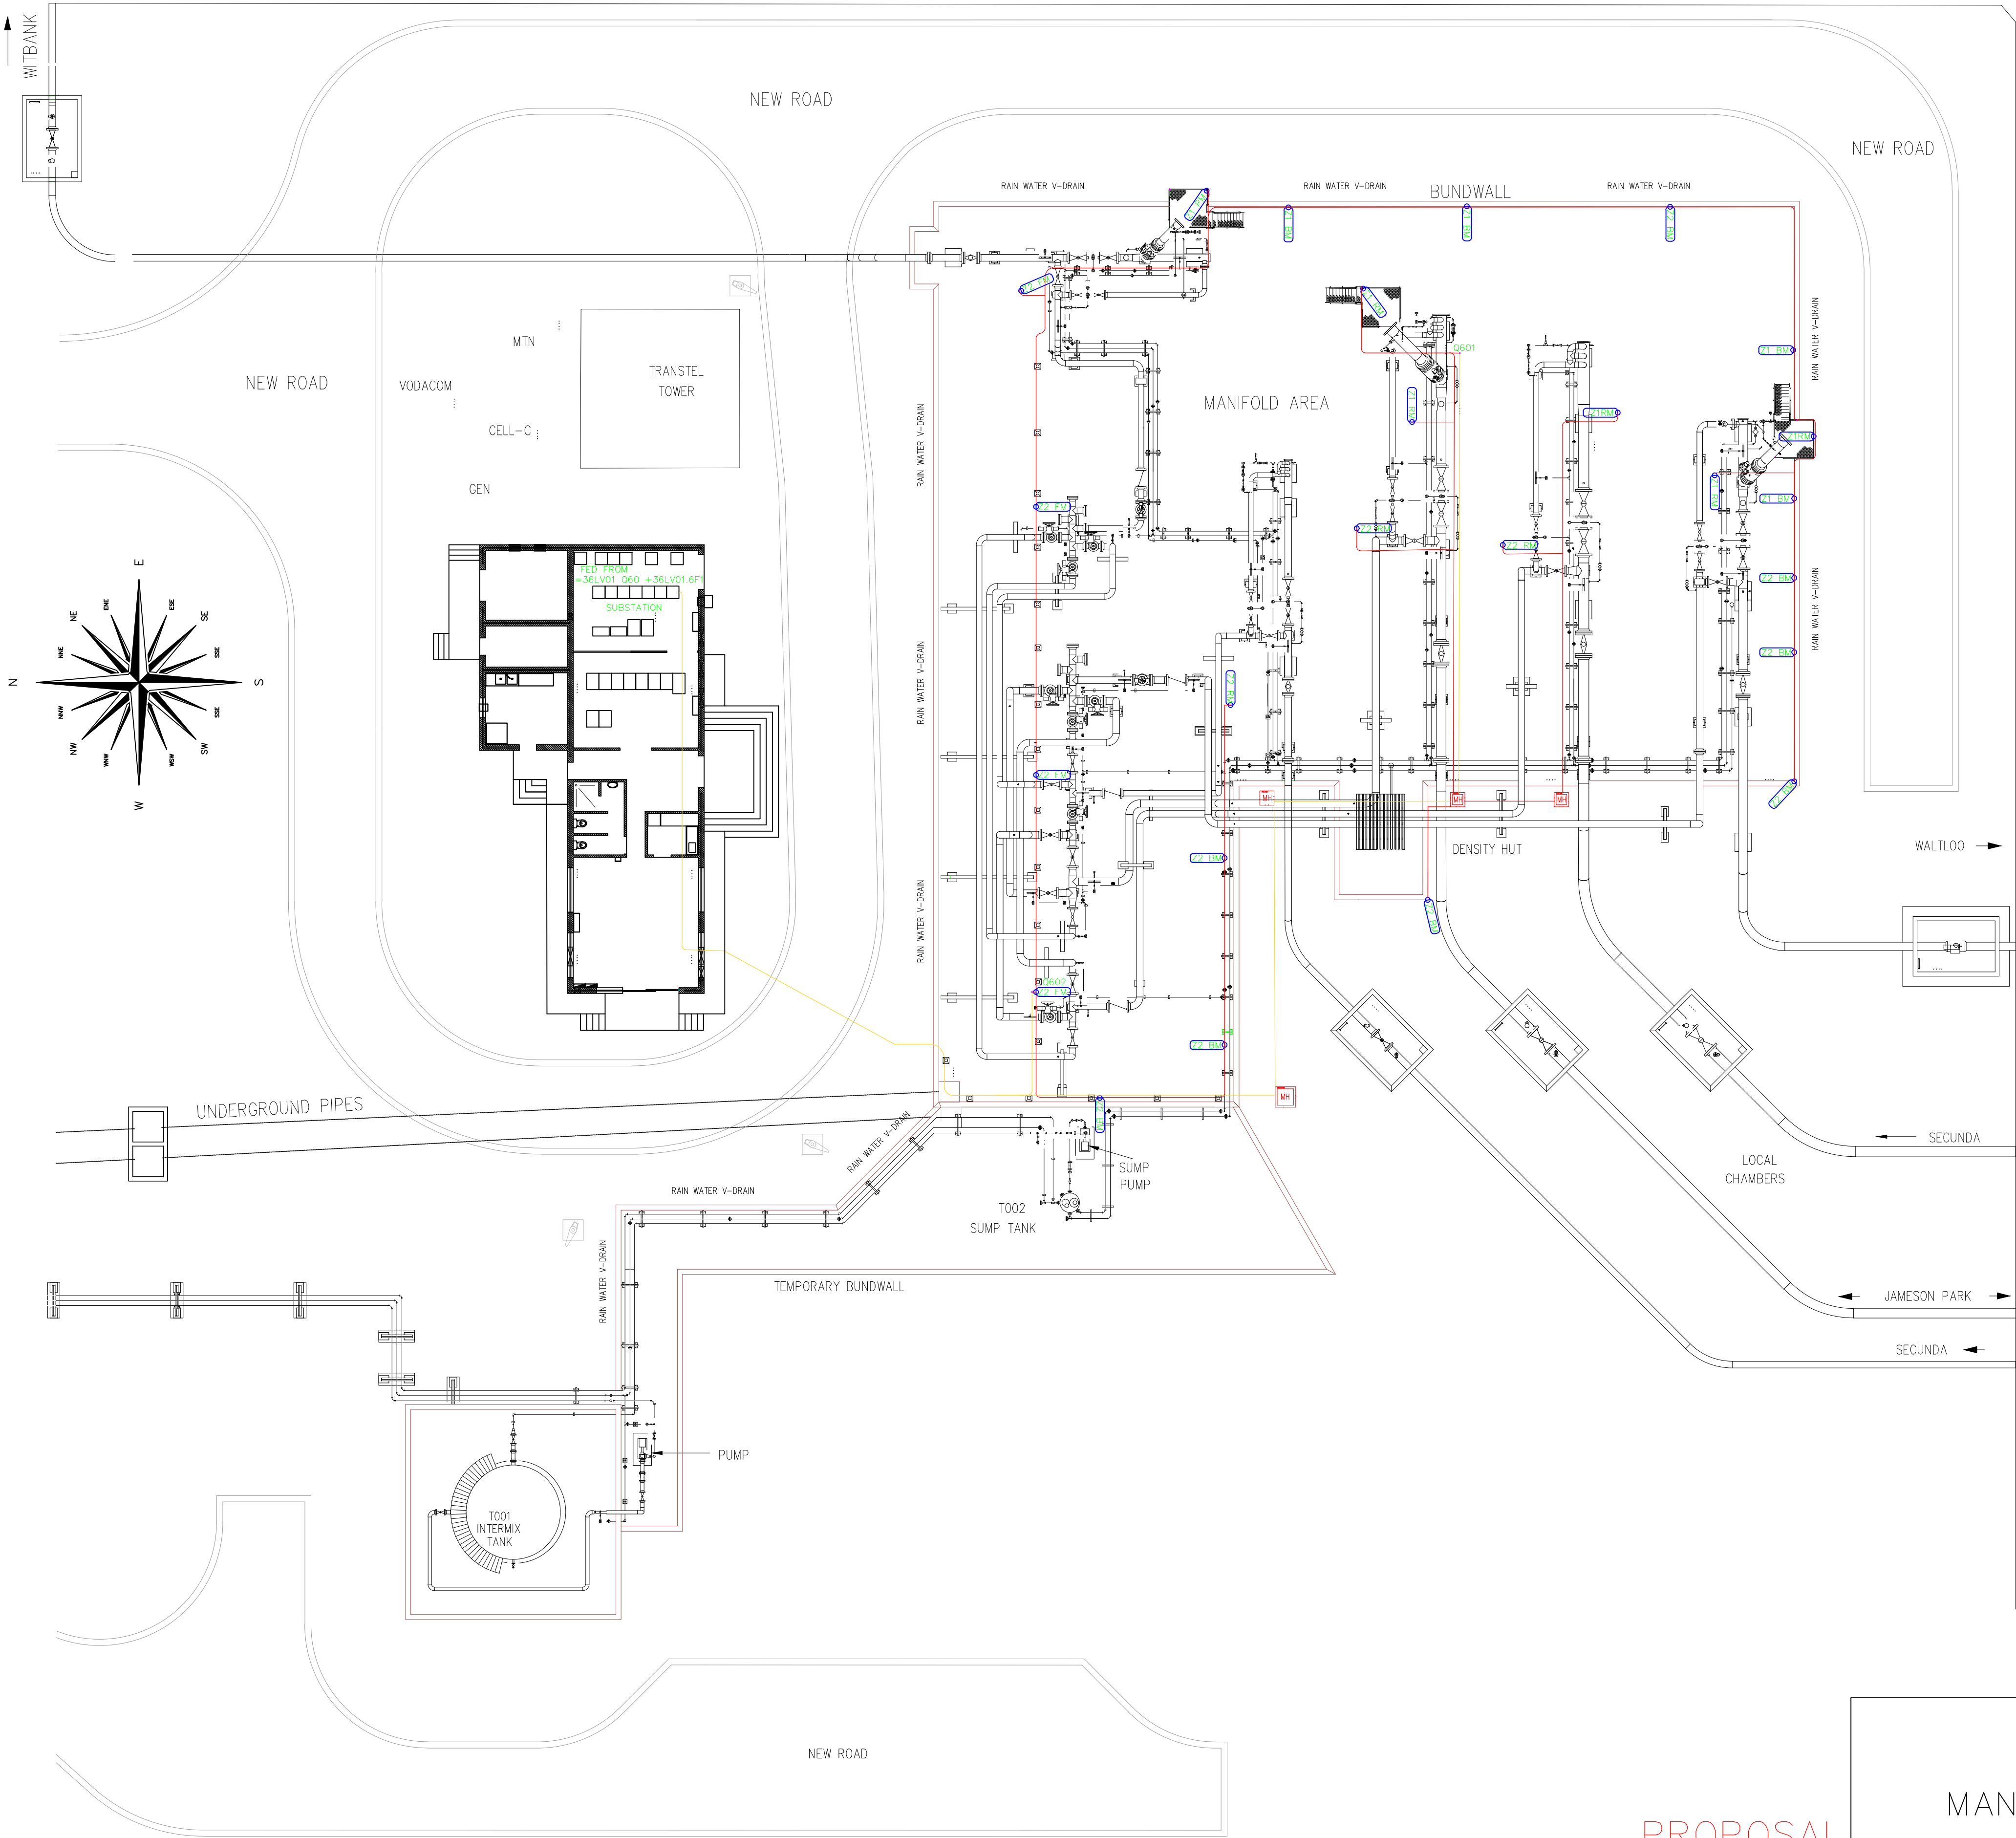

PROPOSAL



MANIFOLD LIGHTING LAYOUT
KENDAL DEPOT

REVISIONS			
PROJECT NAME			
LIGHTING UPGRADE			
DRAWN	W.D	REF.	
TRACED	CAD	DATE	25.05.21
CHECKED	K.N	APPROVED	Z.M
SCALE	NTS		
DRAWING No.			REV
PL121583			