




2 (3D) Copy 1 Copy 1

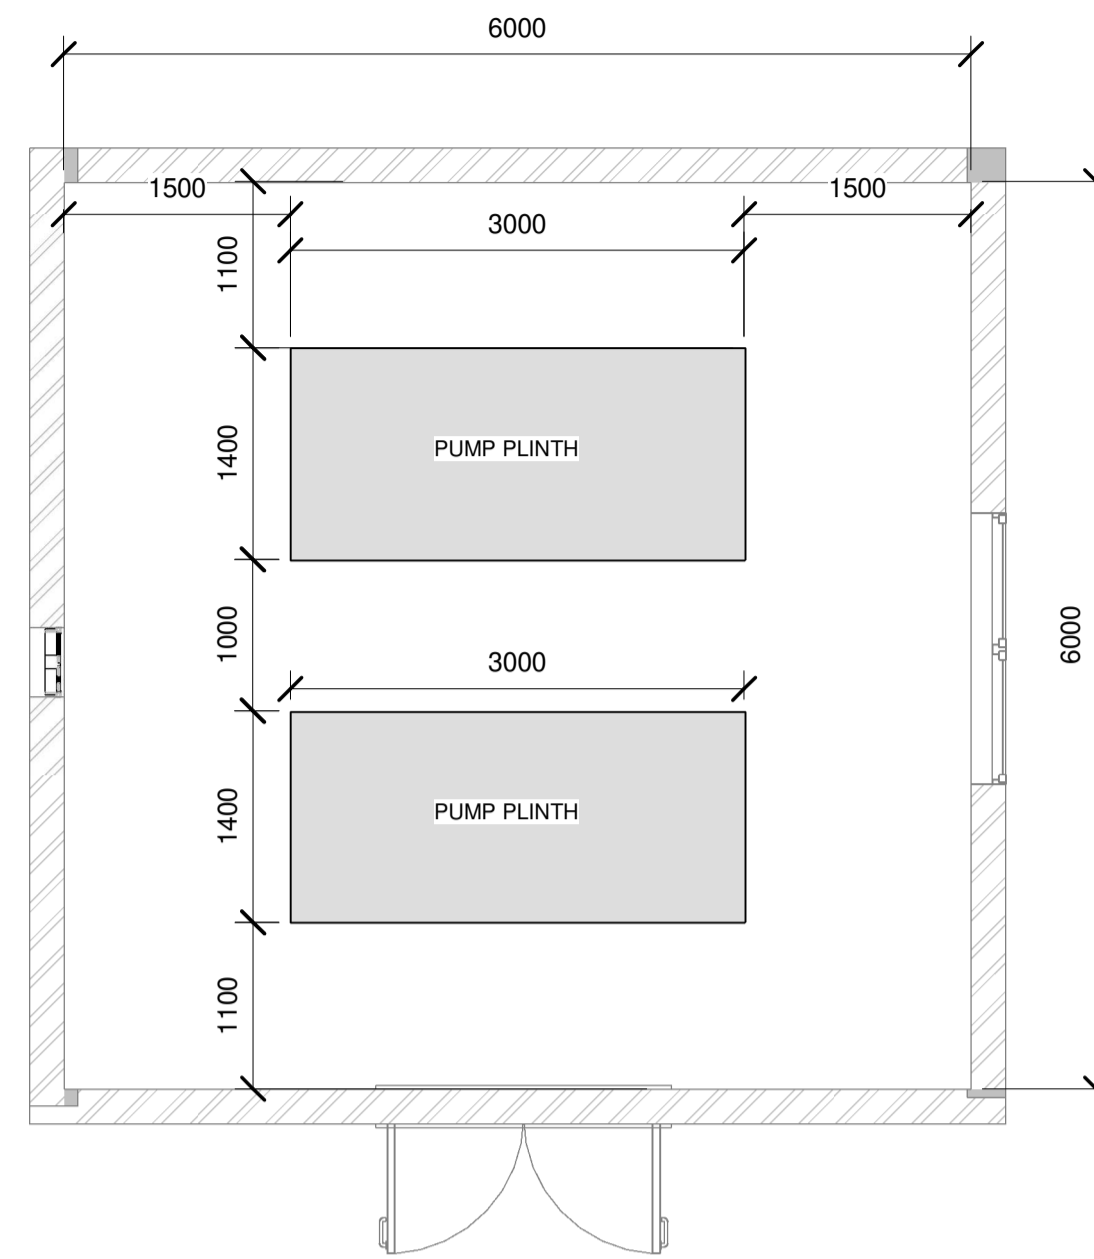


3 PUMP ROOM DETAIL
1 : 50

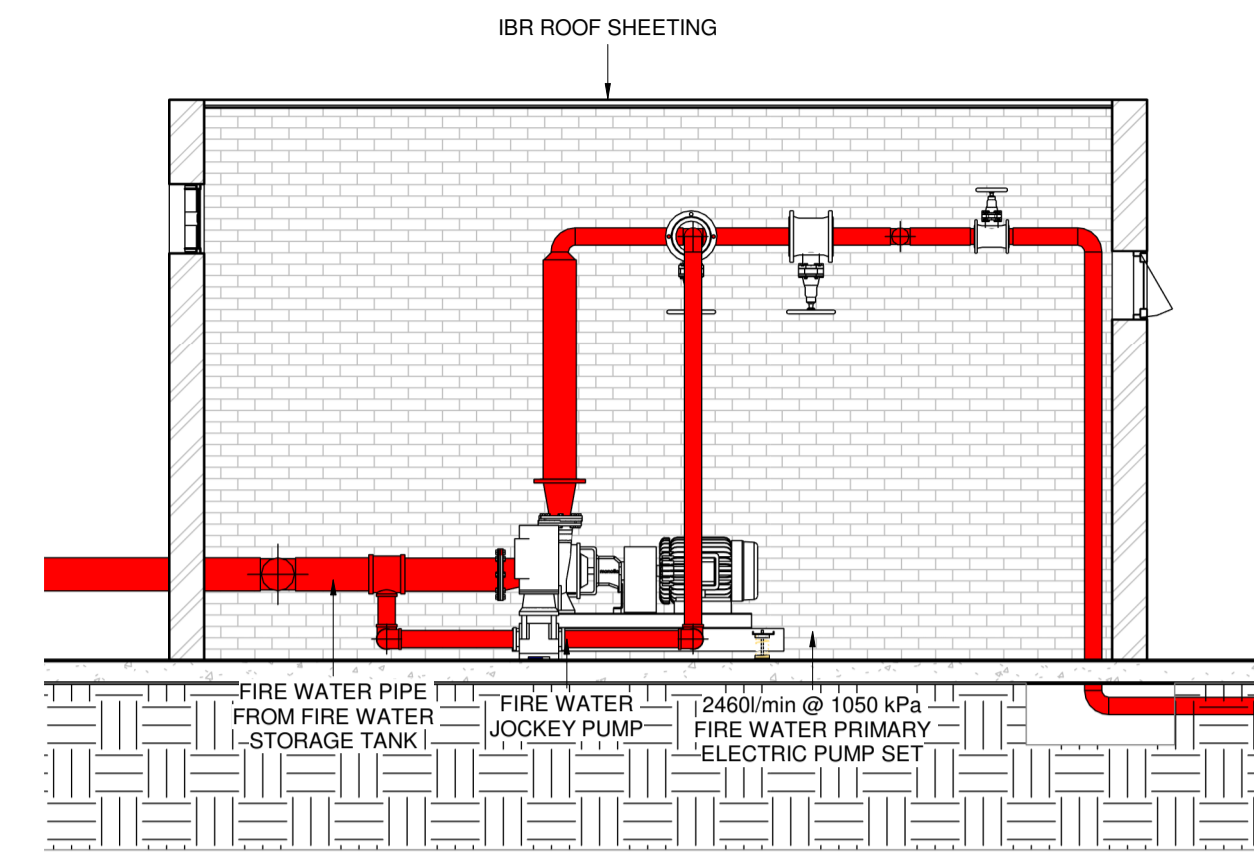



A PUMP HOUSE SECTION A
1 : 50

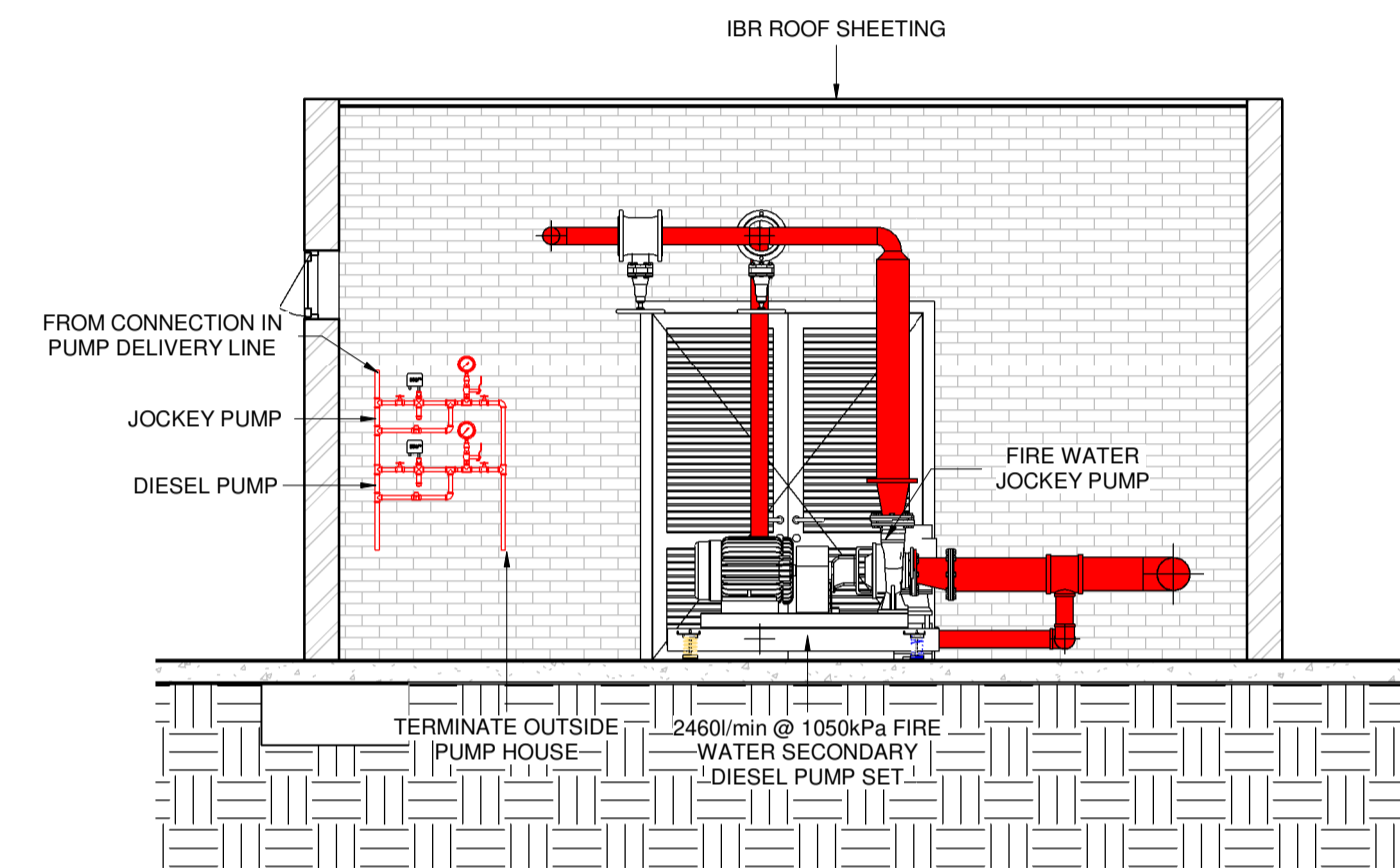


B PUMP HOUSE SECTION B
1 : 50

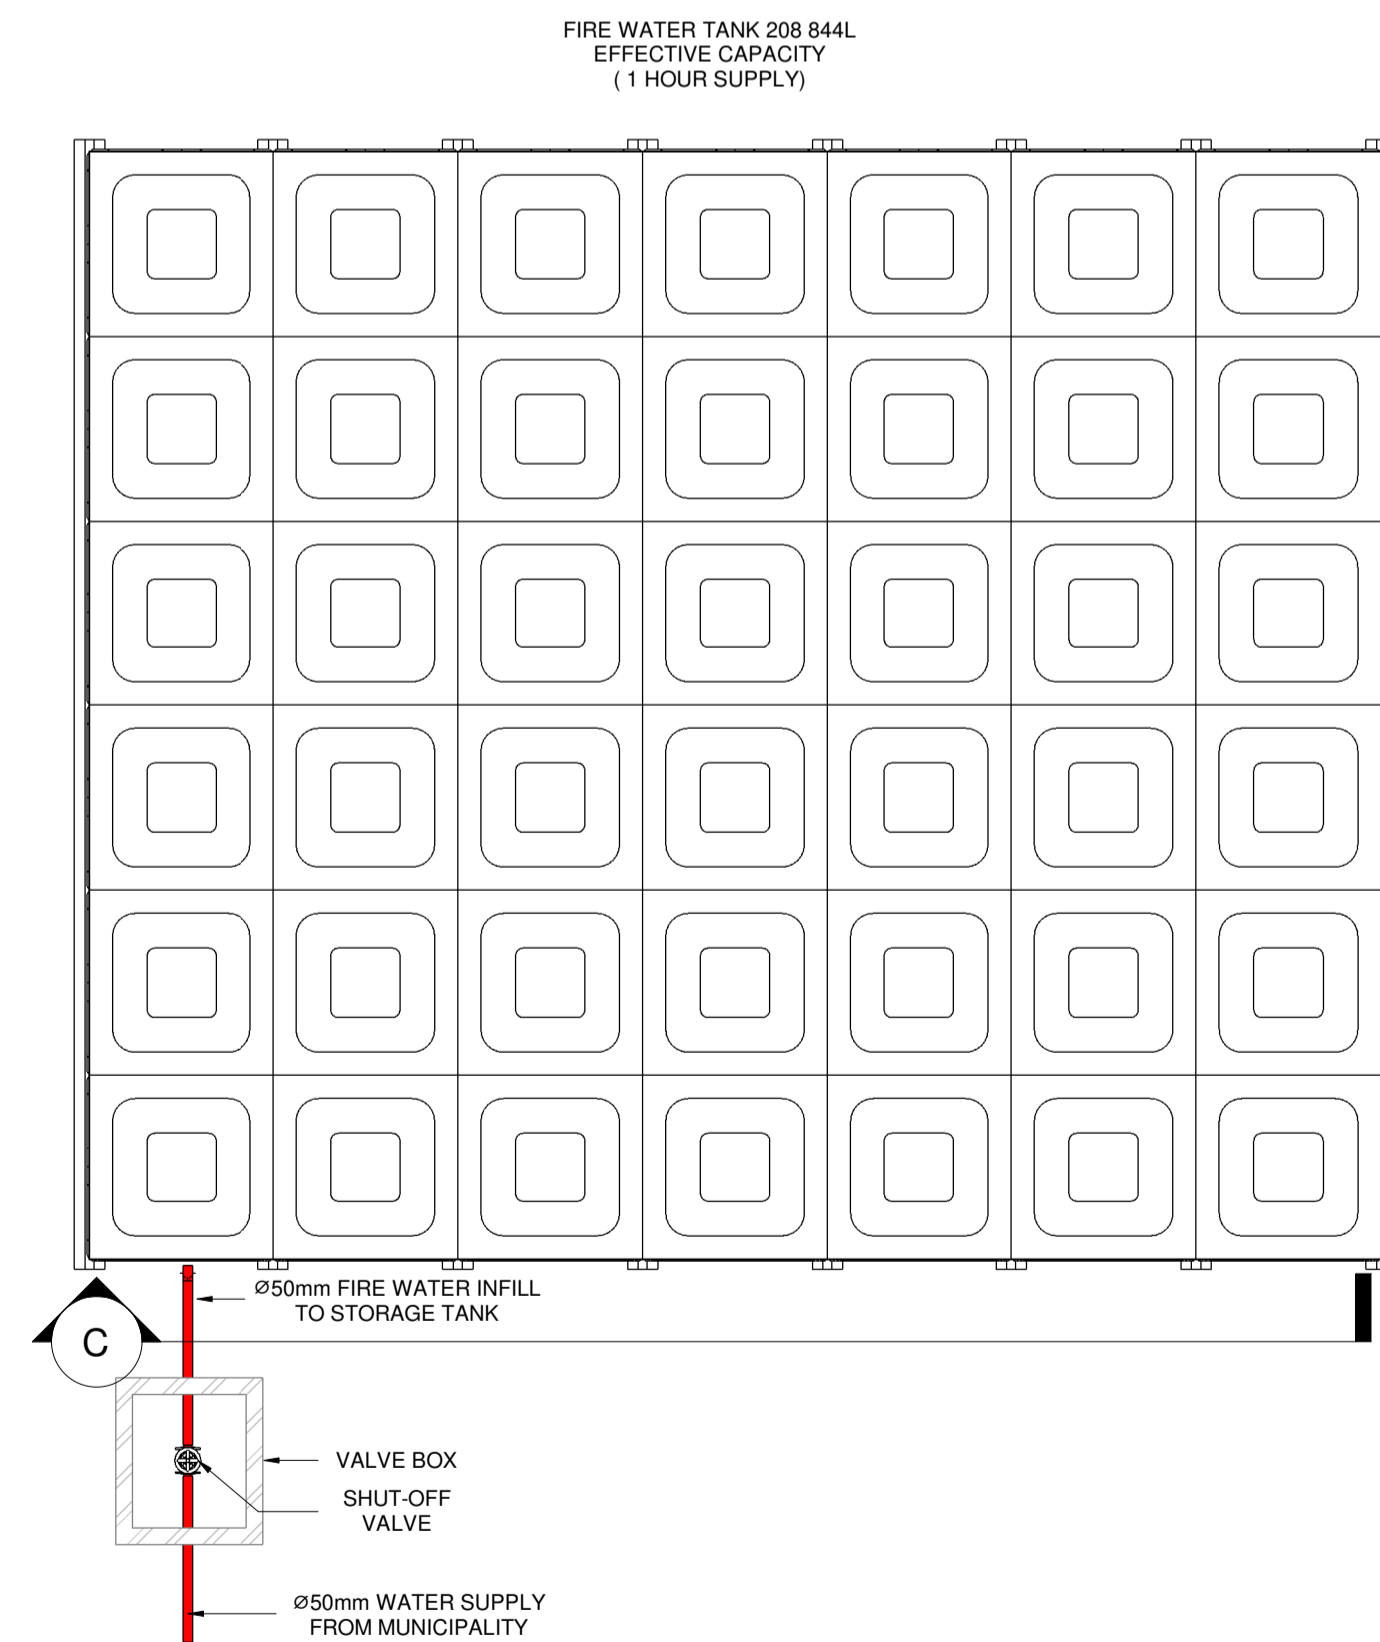

1 FIRE WATER STORAGE TANK AND PUMP HOUSE
1 : 50

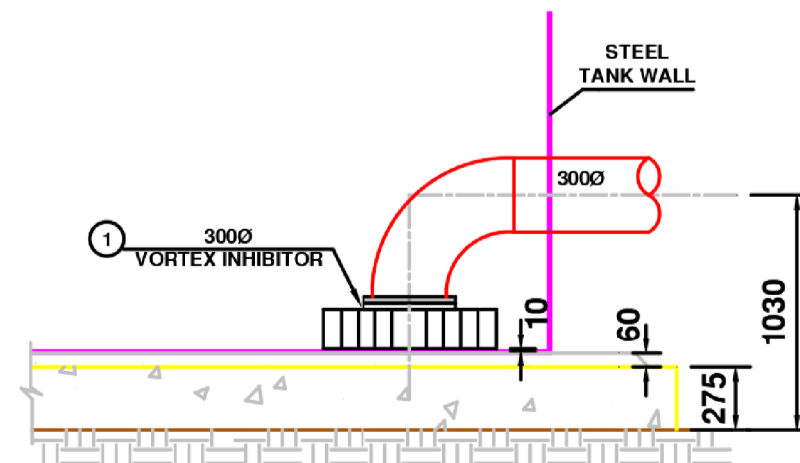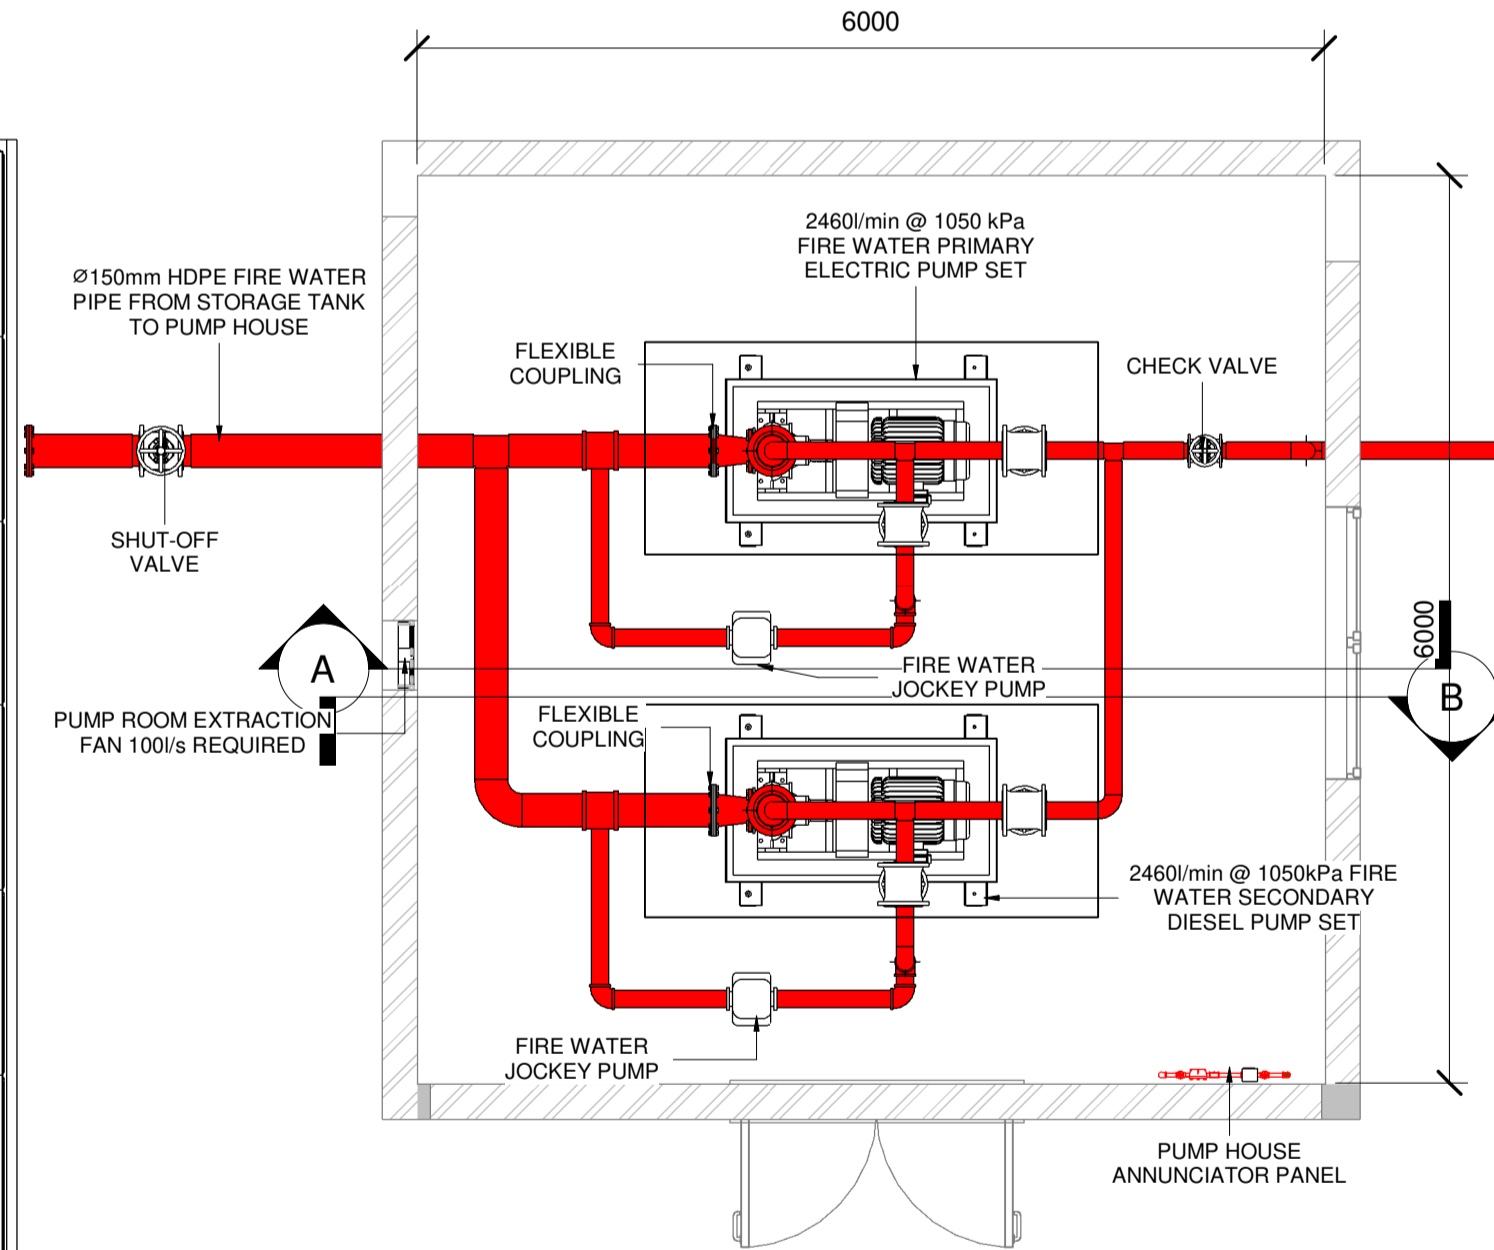

SECTIONAL ELEVATION ON VORTEX INHIBITOR

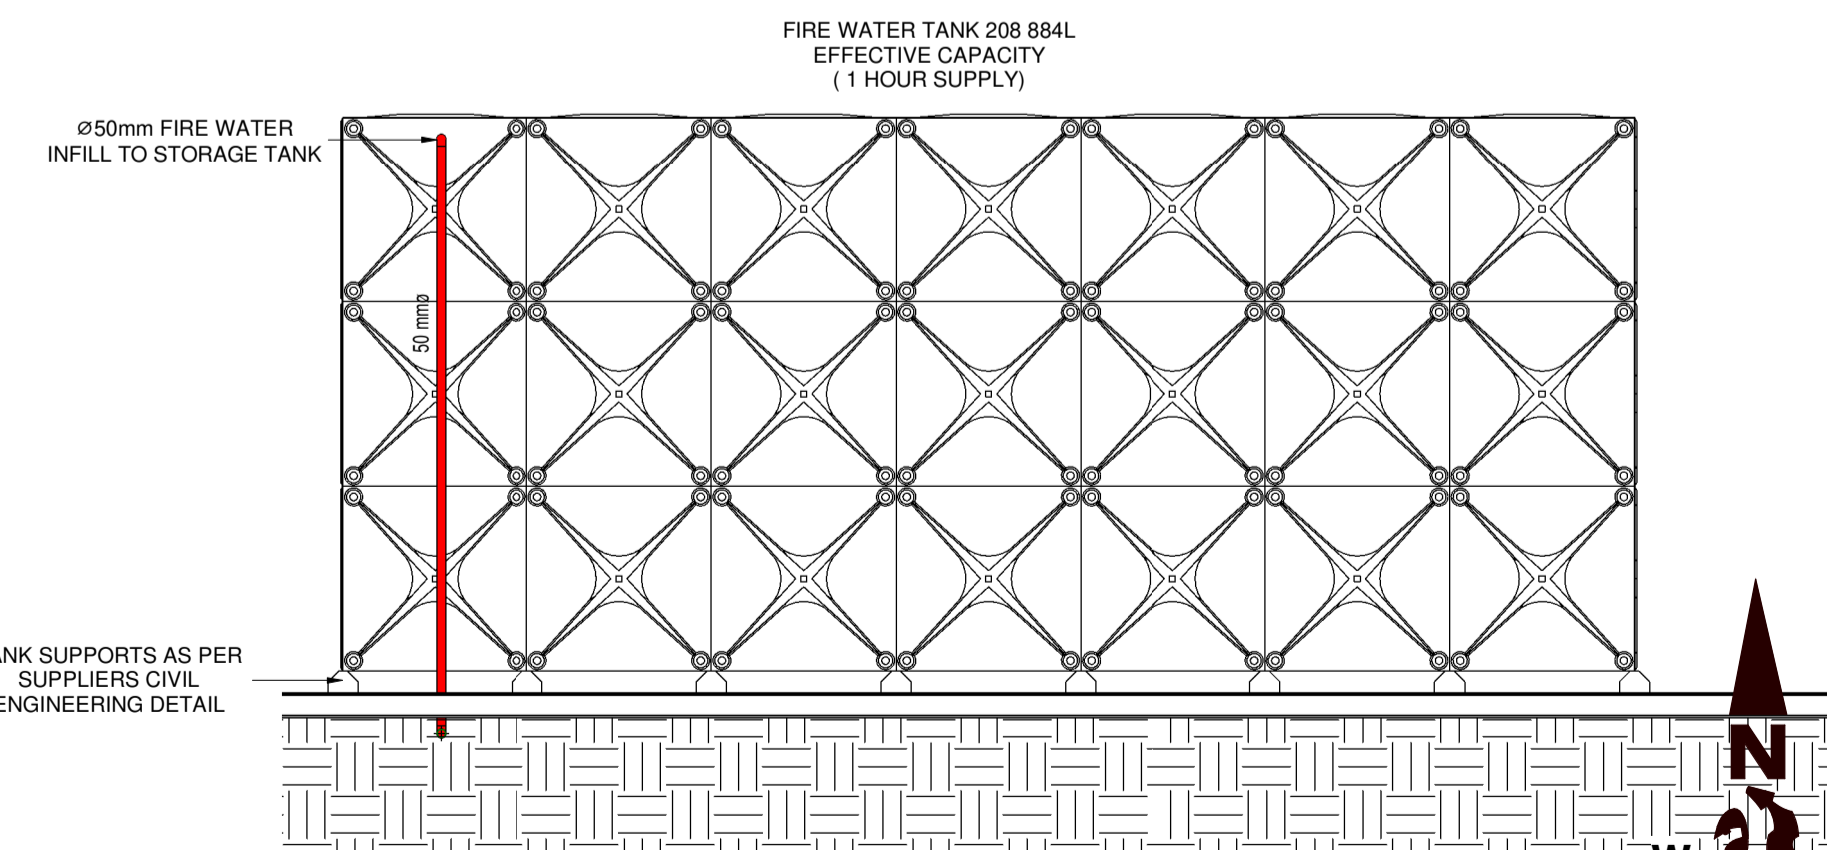

C FIRE WATER STORAGE TANK SOUTH ELEVATION
1 : 50

APPROVED
NAME _____ SIGNATURE _____
PR. NO. _____ DATE _____

NOTES
FIRE NOTES:
• FIRE WATER PIPING TO BE CLASS 16 HDPE UNDERGROUND AND CLASS 16 GALVANIZED ABOVE GROUND
• ALL WORK TO COMPLY WITH SANS 10400 PART T & W AND LOCAL MUNICIPAL BYLAWS

LEGEND

PRELIMINARY

REVISIONS				
REV	DATE	DESCRIPTION	BY	TM
TN	2024-02-19	ISSUED FOR TENDER		

CLIENT ARCHITECT

SABS
South African Bureau of Standards

CONSULTANT

ADQ
AFRICAN DYNAMIC QUALITY
ENGINEERING PROJECTS

info@adqengineering.co.za
Tel: 012 030 0355
www.adqengineering.co.za

PROJECT DESCRIPTION
SABS GROENKLOOF FIRE WATER

DRAWING TITLE
FIRE WATER STORAGE TANK AND PUMP HOUSE LAYOUT

DATE	2024-02-01	DRAWN BY	T.MOLA
CHECKED BY	J.JOUBERT	DESIGNED BY	J.JOUBERT
DRAWING SIZE	A1	SCALE	1 : 50
DRAWING NUMBER	P23076-TN-FIR-102	REV	TN

ISSUED FOR TENDER