



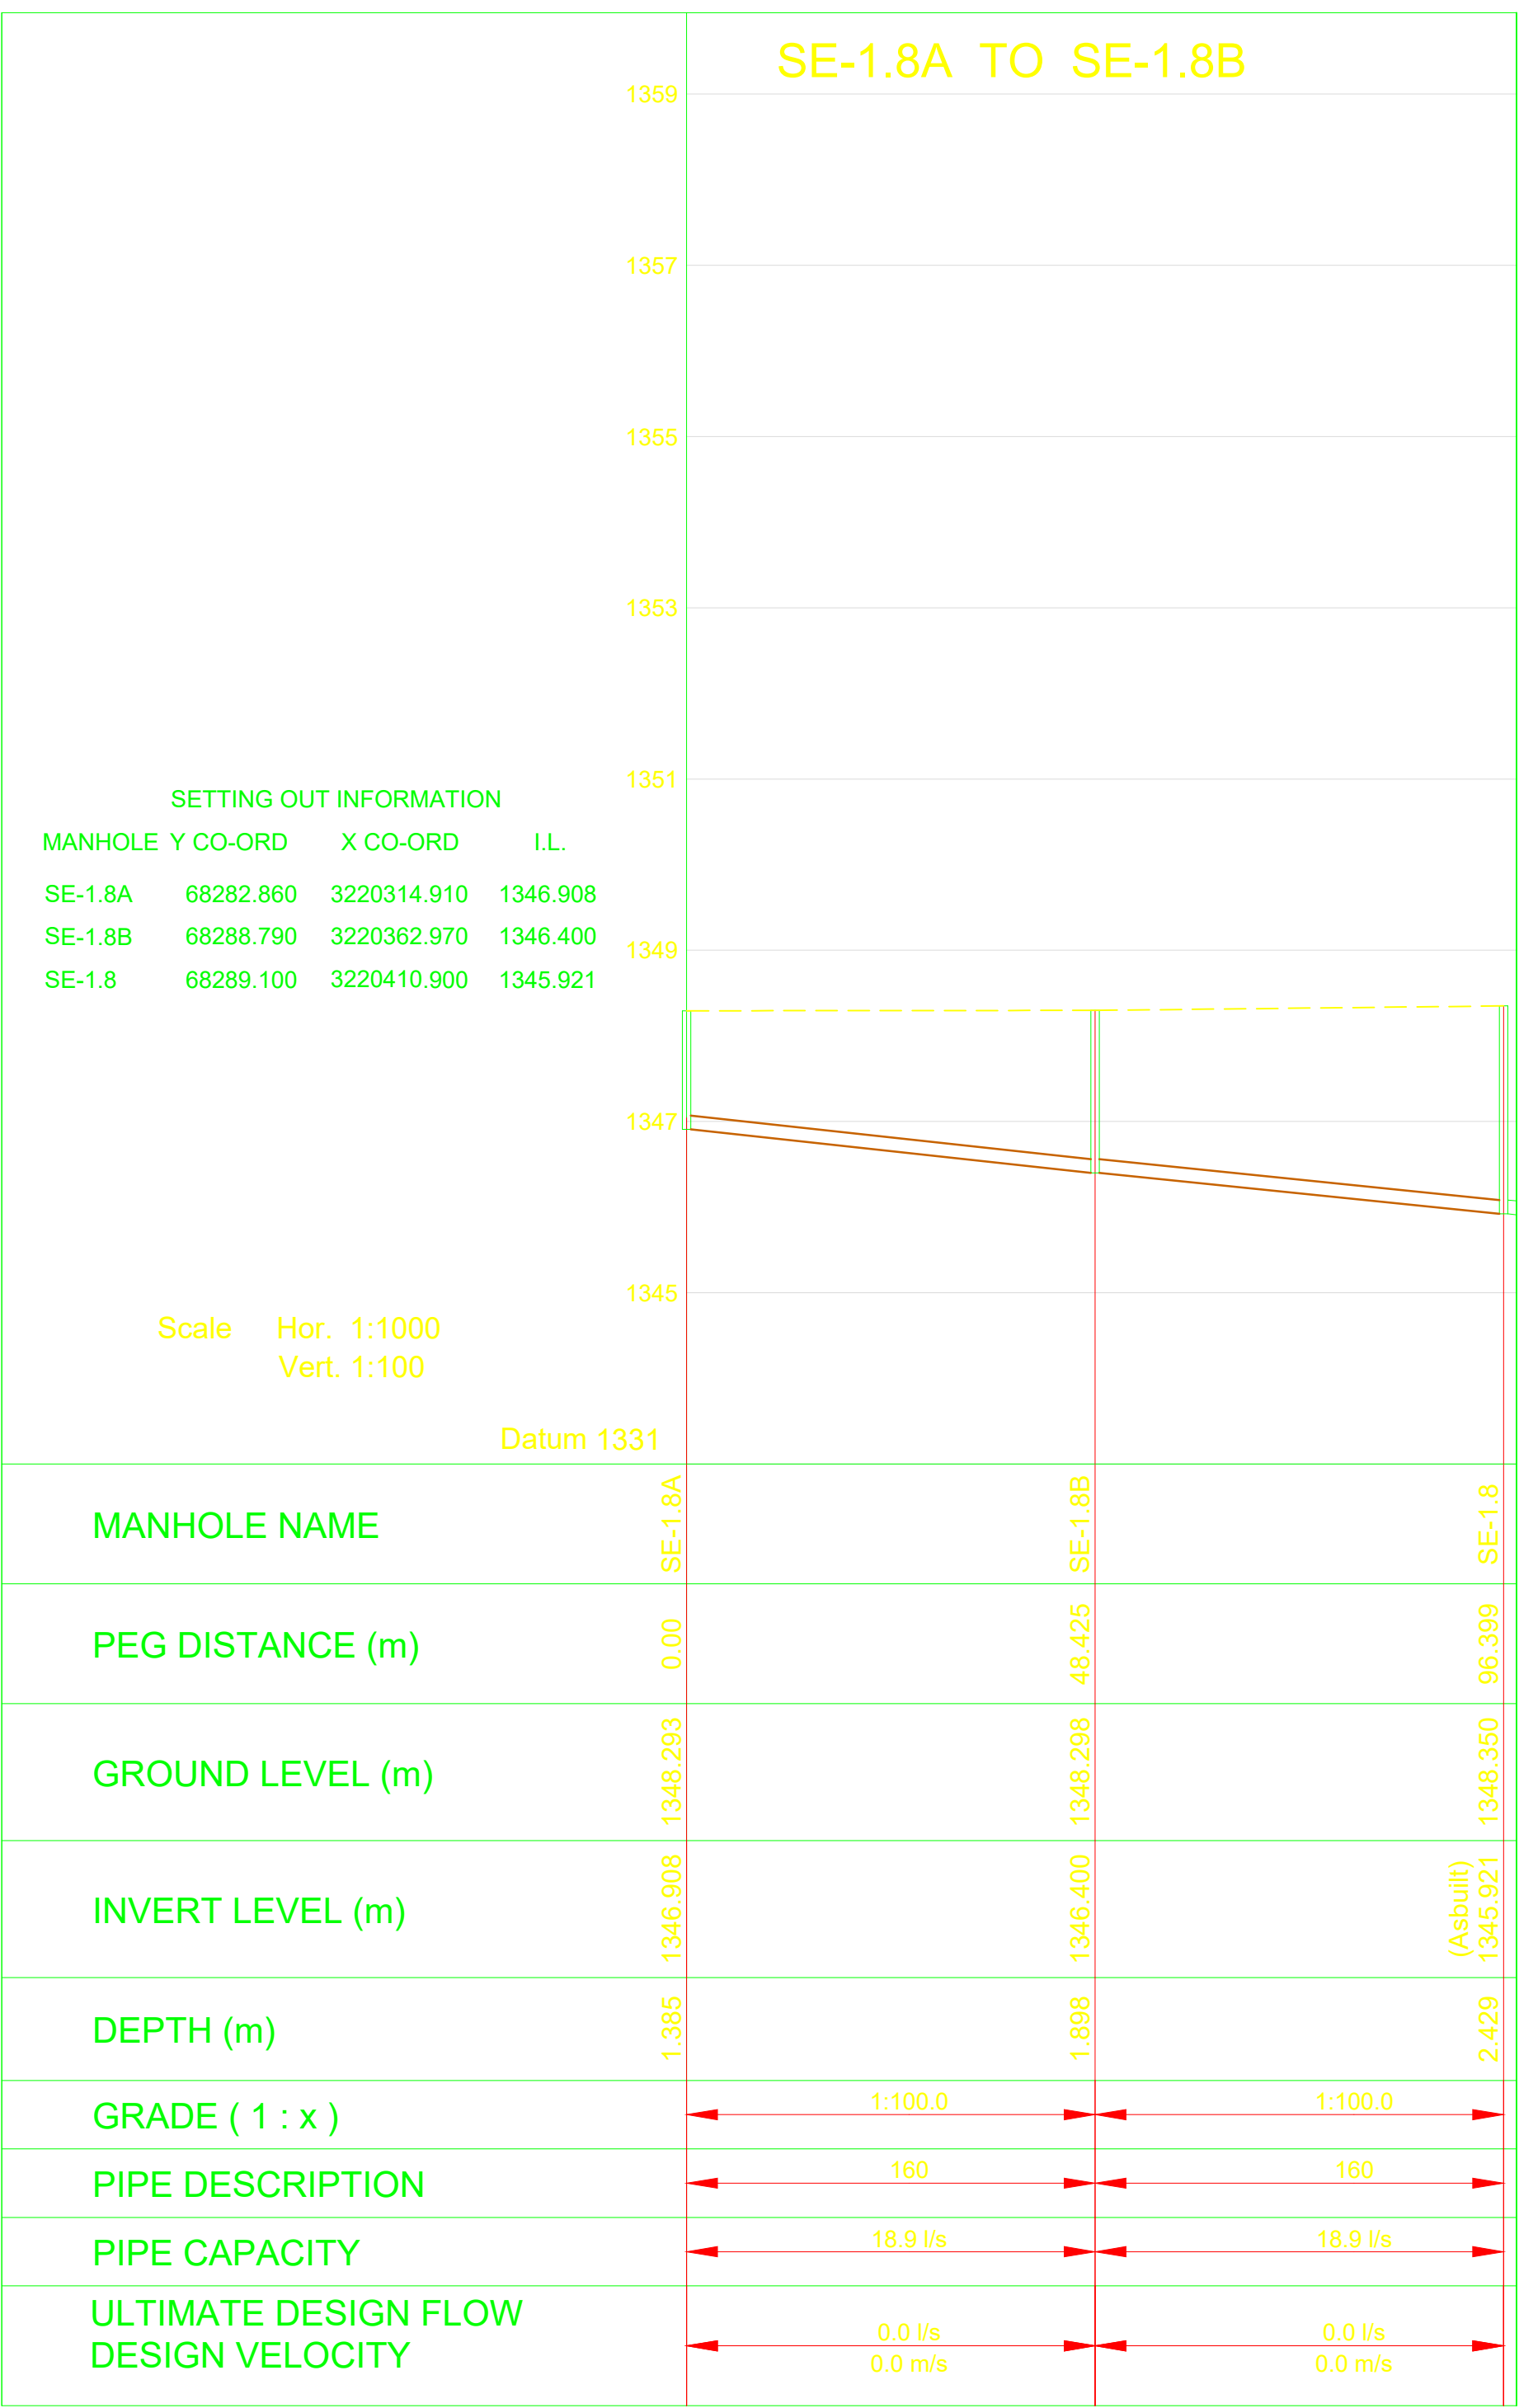

No.	DATE	REVISION	CONSULT. ENG.
1	13/5/2014	ISSUED FOR TENDER PURPOSES	THUSO CONSULTING
2	27/5/2015	ISSUED FOR CONSTRUCTION	

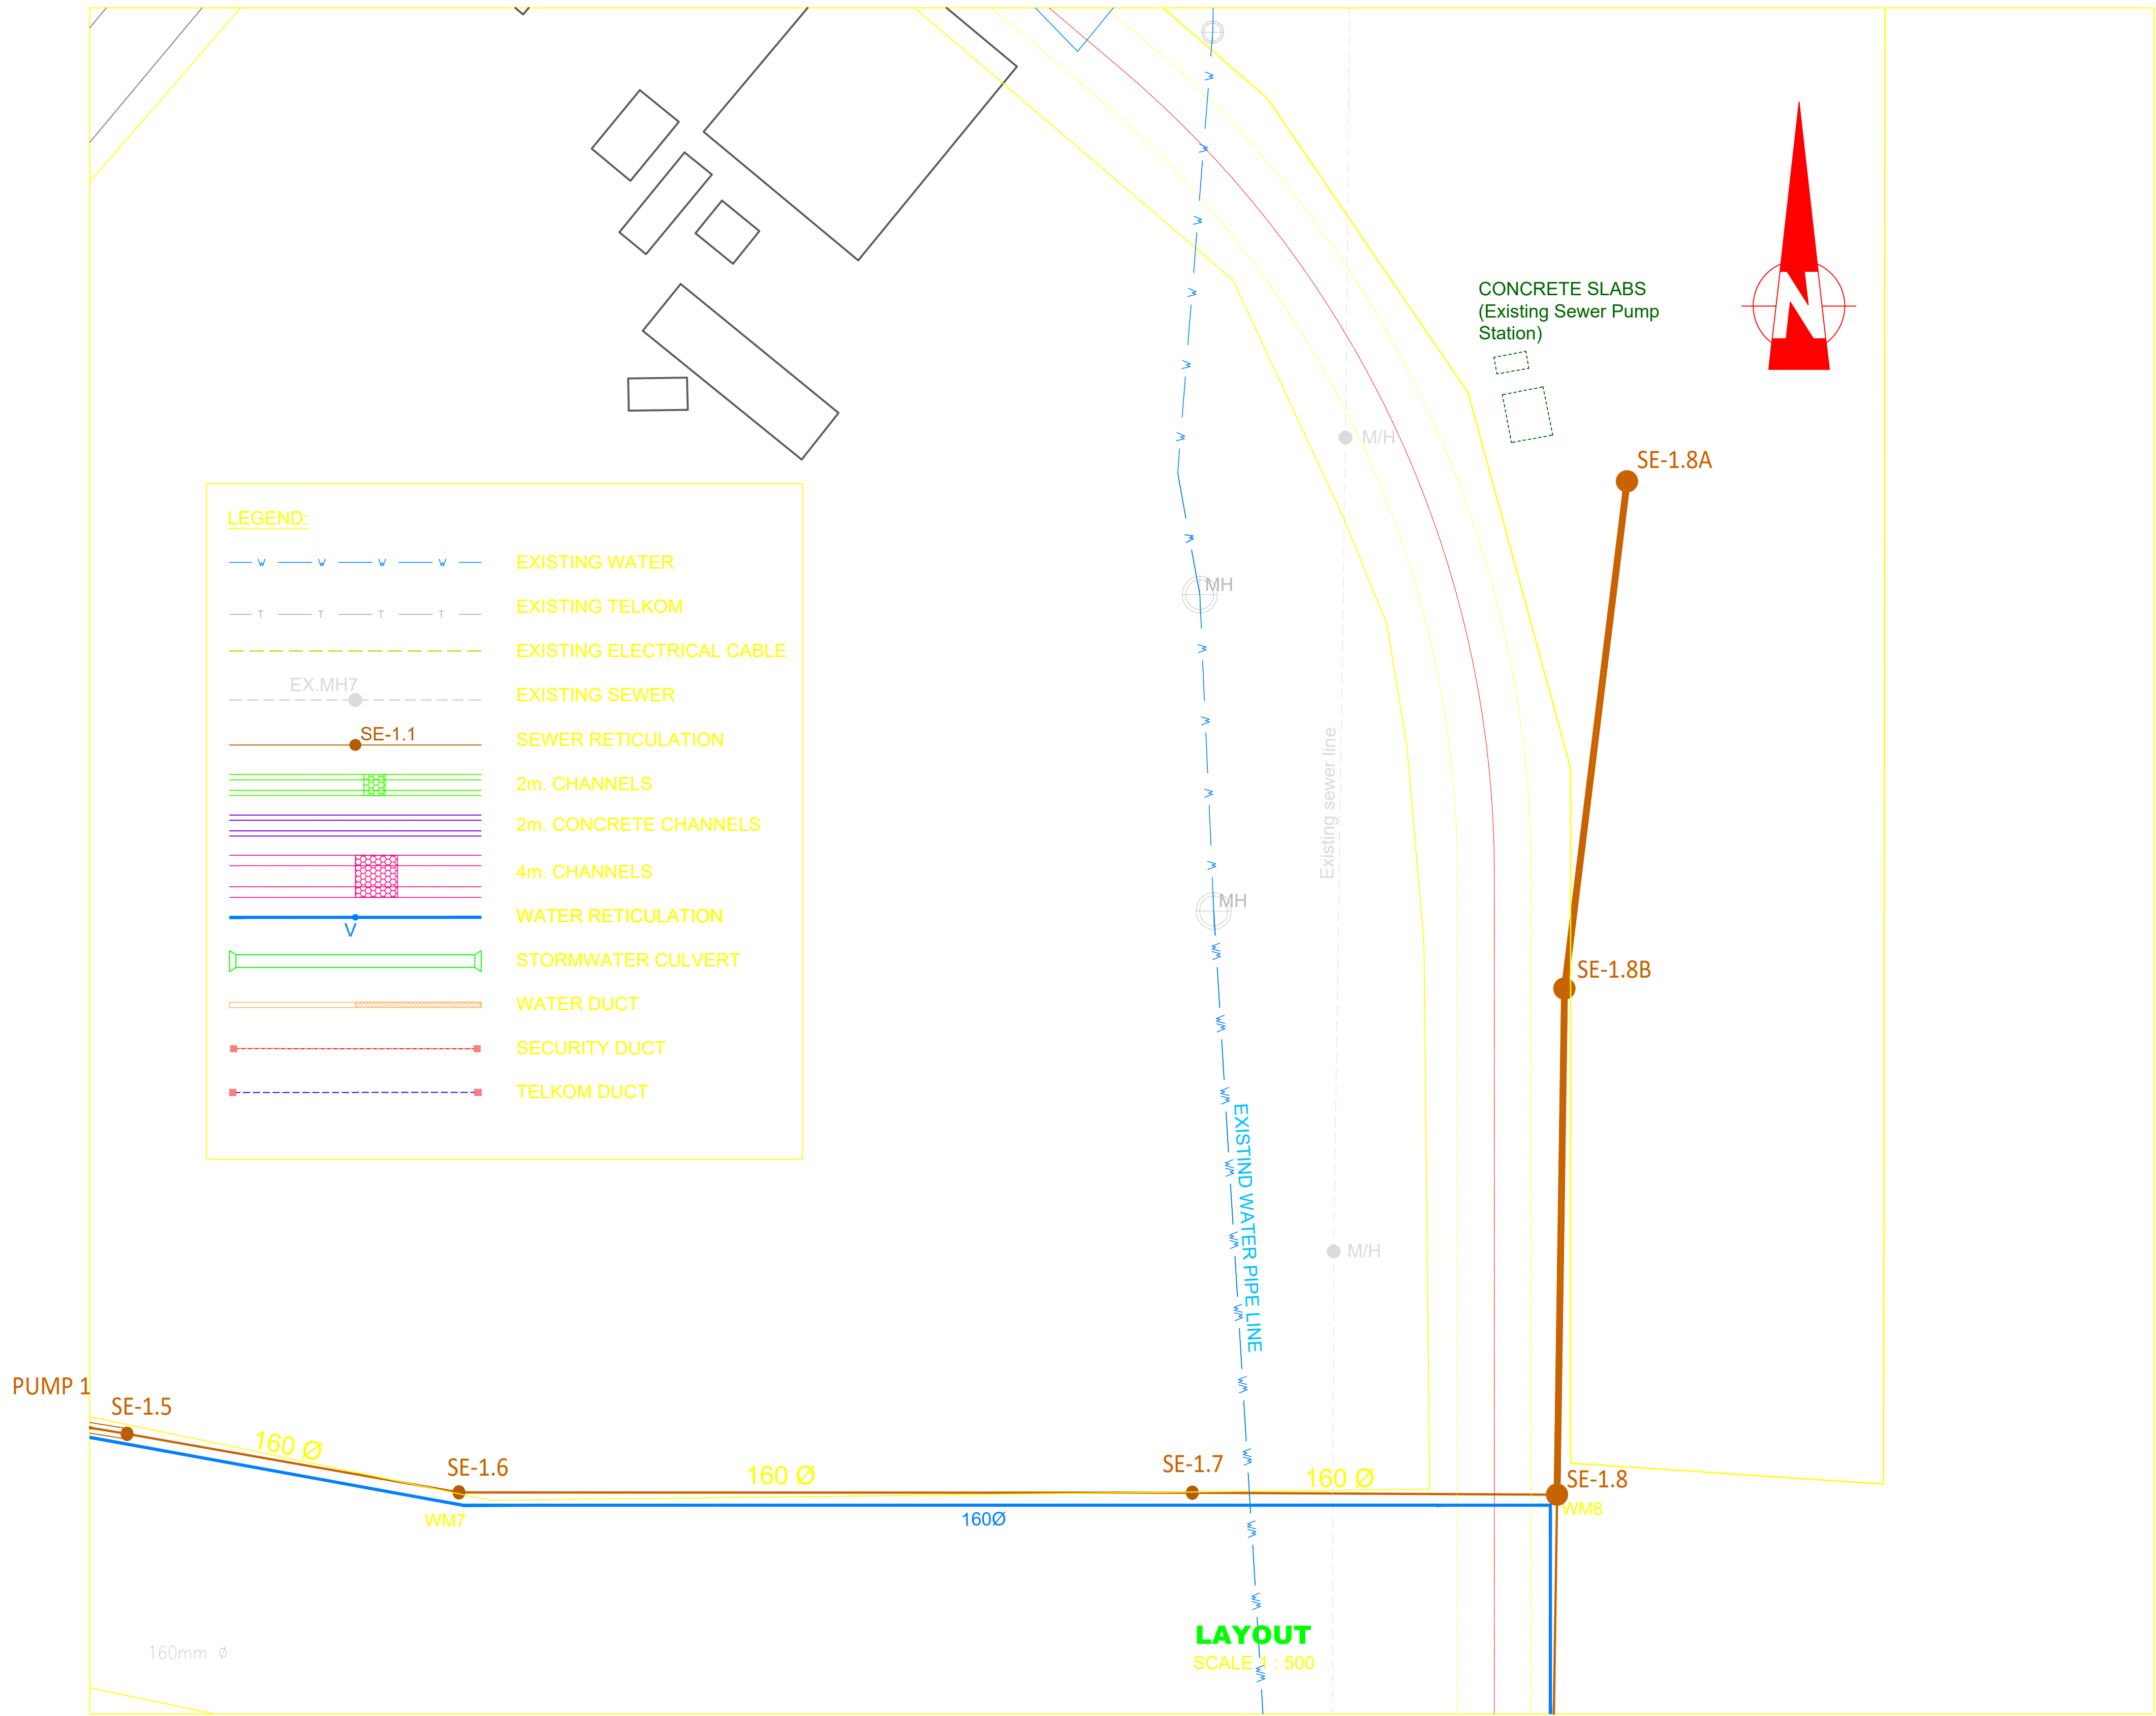

DESIGNED BY
SSI ENGINEERS AND ENVIRONMENTAL CONSULTANTS (Pty) Ltd TRADING AS ROYAL HASKONINGDHV
P.O. BOX 12071
BRANDROF
9324
BLOEMFONTEIN
TEL: (051) 400 7200
FAX: (051) 430 8220

DESIGNED BY	ADDRESS
DRAWN BY	Name : DOMINIC COLLETT Prof. Reg. No. : 200170067 Date : MAY 2013 CONSTRUCTION RECORD DRAWING
CHECKED BY	Name : Prof. Reg. No. : Date :



ACCEPTANCE
THIS ACCEPTANCE IS FOR PROCEDURAL AND ADMINISTRATIVE REVIEW PURPOSES ONLY AND DOES NOT ATTRACT LEGAL LIABILITY OR LIABILITY OF ANY KIND FROM WHATSOEVER CAUSE OR HOWEVER ARISING
AIRPORTS COMPANY SOUTH AFRICA Date:

PROJECT DESCRIPTION
CONSTRUCTION OF NEW WATER AND DRAINAGE SERVICES AT BLOEMFONTEIN AIRPORT
SCALE : AS SHOWN

DRAWING DESCRIPTION
ADDITIONAL SEWER LINE TO EXISTING PUMP STATION
SHEET OF

CONTRACT NUMBER		BL13/29/AU/02	
DRAWING LOCATION DATA	START	END	
ROUTE	—	—	
SECTION	—	—	
DRAWING km DISTANCE	—	—	
DRAWING TYPE	WATER RELATED		
DRAWING NUMBER	TBFN 90/DP/05/S		REV. 