


DRAWING STATUS:  
FOR CONSTRUCTION

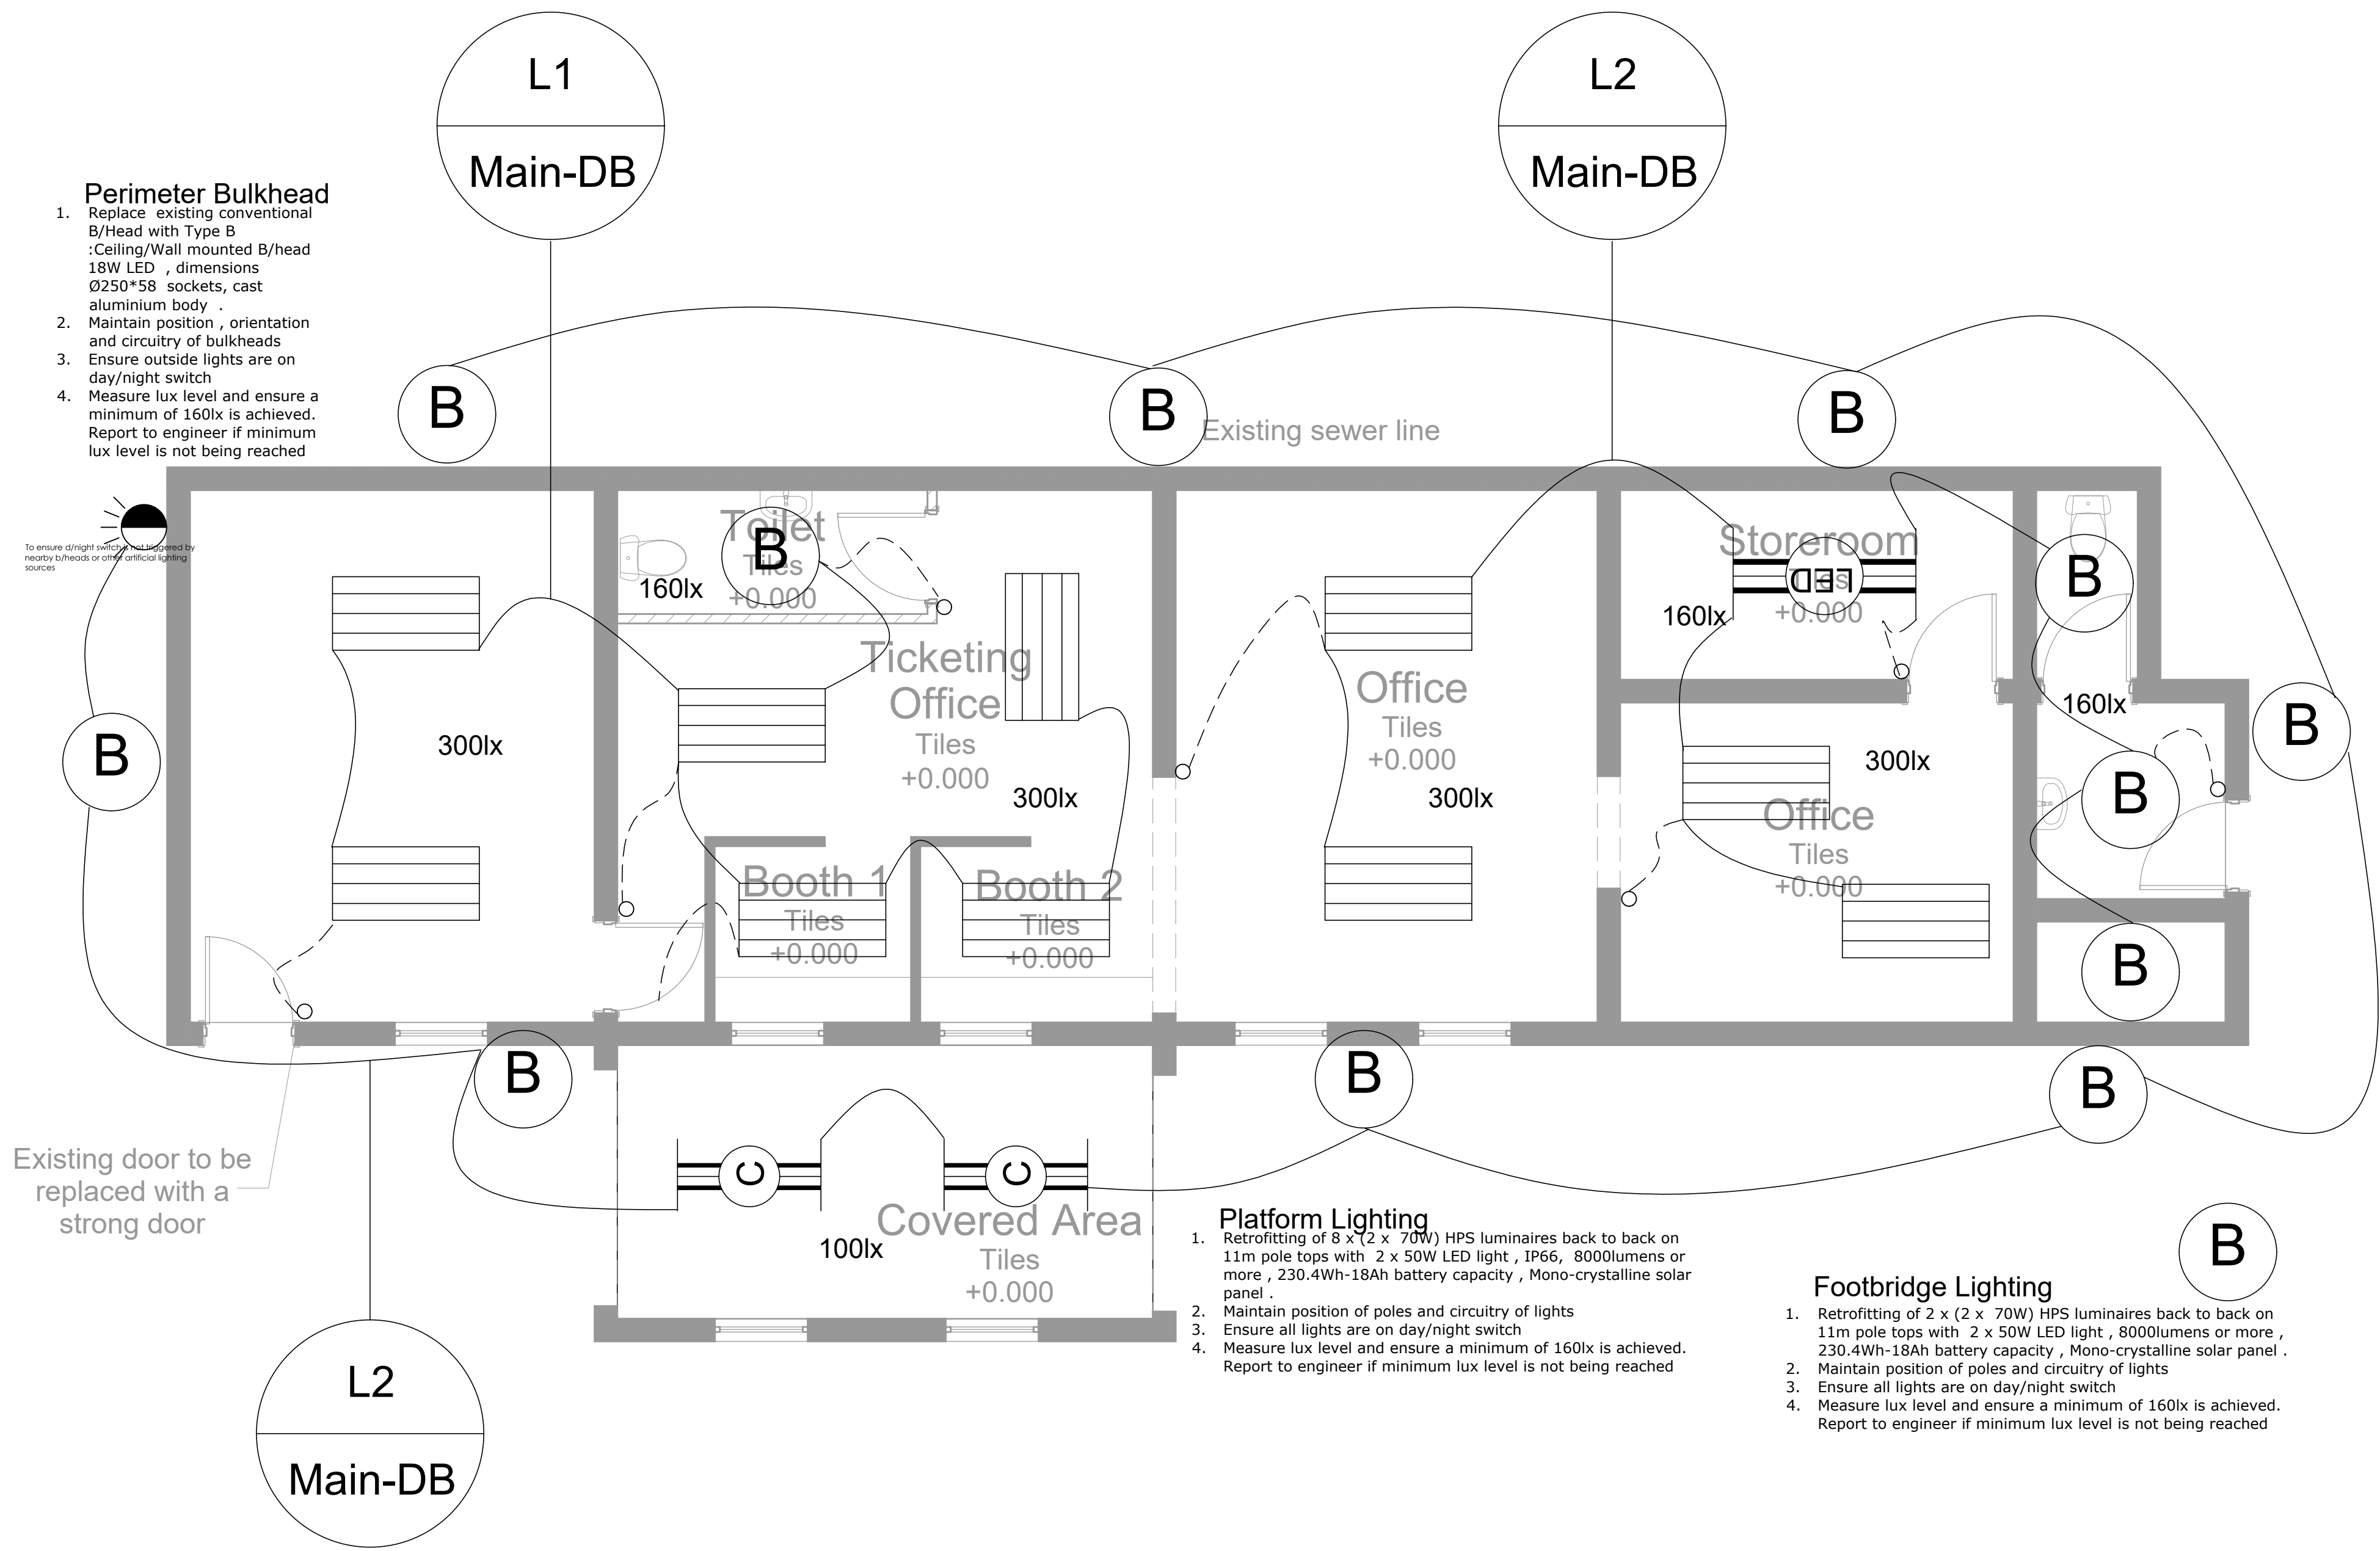

LIGHTING (INTERNAL & EXTERNAL) LAYOUT (CONSTRUCTION INSTRUCTIONS)  
(To be read and implemented in line with Specifications provided)

REV			DRAWINGS TITLE			CHK APP			REV			DESCRIPTION			DATE			CHK APP		
			REFERENCE DRAWINGS									REVISIONS								

PROFESSIONAL SERVICE PROVIDER				CLIENT APPROVAL				CLIENT				PROJECT / DRAWING TITLE				SCALE:			
												STATION DEVELOPMENT FOR SYDENHAM, PORT ELIZABETH				NTS			
30 Long Reach Street Dorchester Heights East London 6241 Tel: 074 661 0248 Fax: 086 218 6529 email: admin@aesconsulting.co.za				8 Station St East London CBD East London 5200 Tel: 079 343 0765 Fax: - email: lwando.kran@prasa.com								LIGHTING LAYOUT				CONTRACT No. -			
																PROJECT No. -			
																DRAWING No. AES-PRASA-EE01-SYD-001			