

No.	Description	Date	By
A	Information only	17.02.2016	SG
A	For purpose of discussion	22.02.2016	SG
B	Adjusted railing wall to be 70mm inclusive of finish. Passage door positions revised.	24.02.2016	SG
C	Increased size of basement parking. Adjusted DB positions. Increased size of lift.	15.03.2016	SG
D	Updated Structure	30.05.2016	SG

HEALTH DEPARTMENT SIGNATURES

FACILITY STAMP

FACILITY MANAGER

INFRASTRUCTURE MANAGER

GENERAL MANAGER

CHECKED BY PROFESSIONAL CONSULTANT

Name Titim Nini

TJNEL 30 September 2023

Signature

Date

CONSULTING ENGINEERS TJNEL

T J NEL

CONSULTING ELECTRICAL ENGINEERS

P O BOX 169

PORT EDWARD

4295

CELL: 083 - 2659623



Department:
Public Works
PROVINCE OF KWAZULU-NATAL
SOUTHERN REGION


Project
WIMS NO: 044044 SOUTHERN REGION
PORT SHEPSTONE DEPARTMENT OF HEALTH
PORT SHEPSTONE PROVINCIAL HOSPITAL
NEW PSYCHIATRIC WARD

Drawing Description
SITE PLAN
FIRE DETECTION
and
EVACUATION INSTALLATIONS

Drawing TJN Date: 12 November 2023
Scale: 1:10 metres
Consultants Drawing number SL 231 - FESPI

DOPW Drawing number

Stamped by Plans Approval Committee

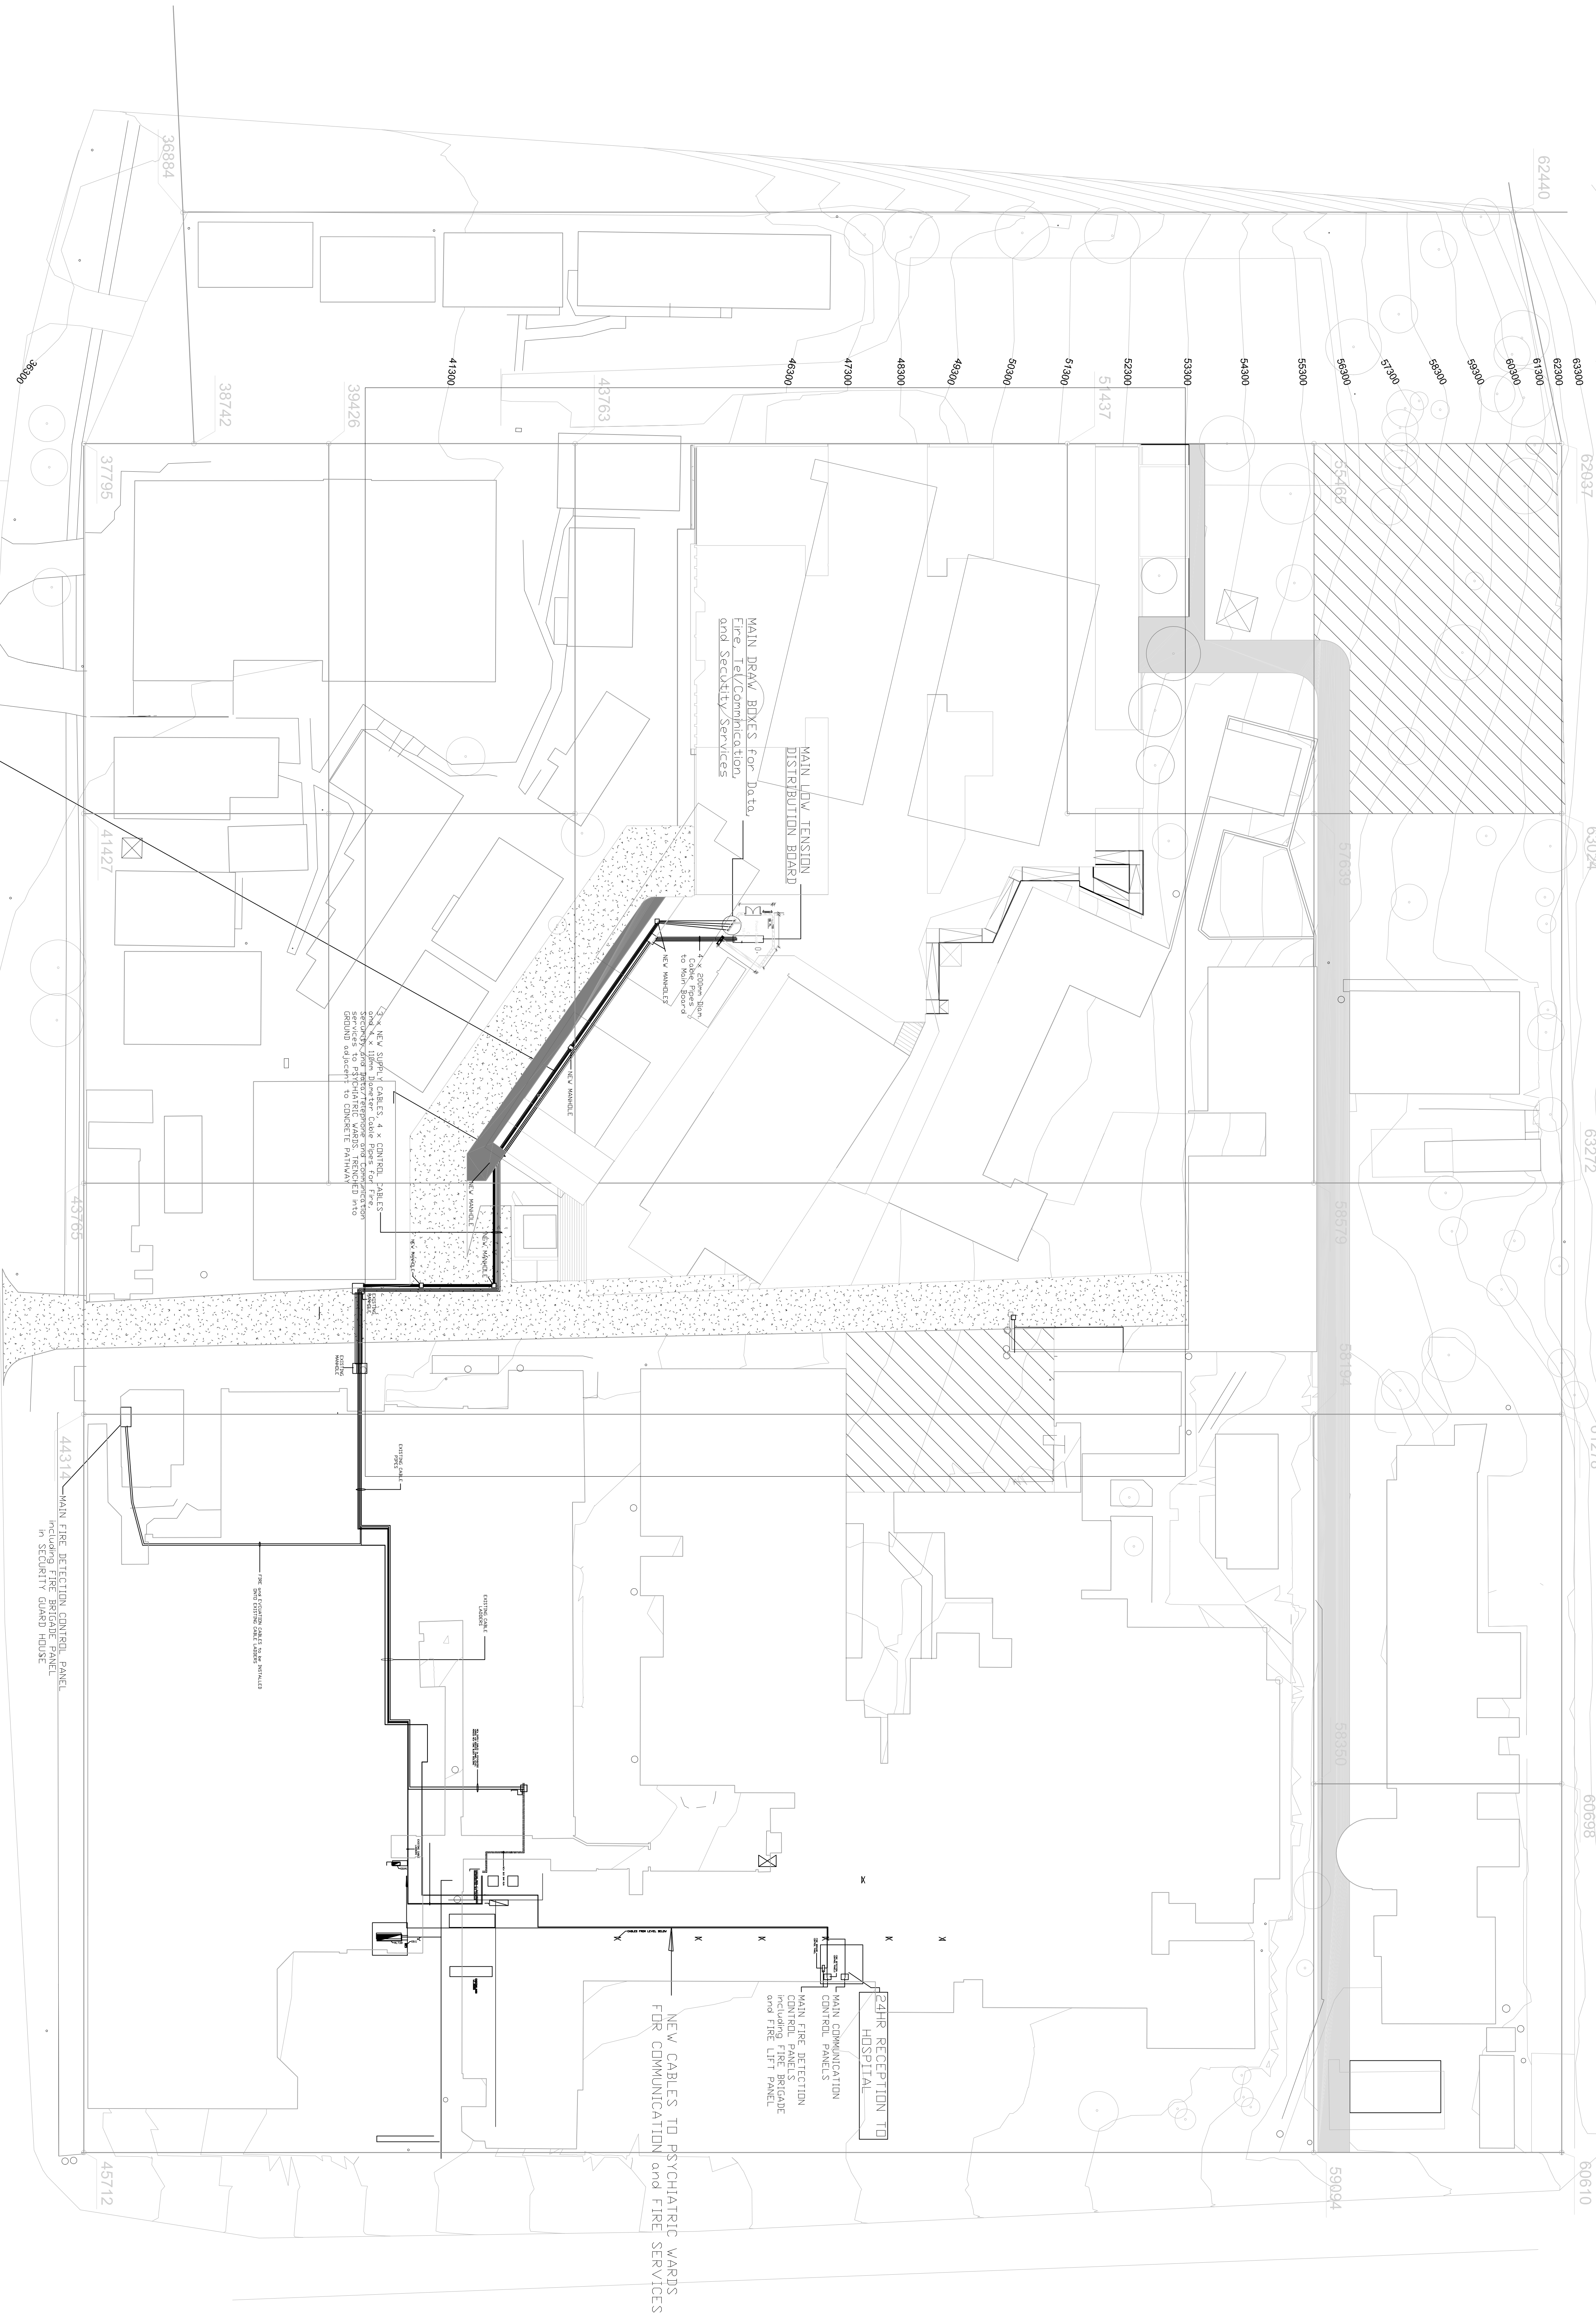

C O L L E Y S T R E E T

NEW CABLES FOR SUPPLY TO MAIN DISTRIBUTION BOARD
IN PSYCHIATRIC WARDS

plus

4 x 110mm Diam. CABLE PIPES for COMMUNICATION and FIRE SERVICES

FIRE DETECTION and EVACUATION
INSTALLATIONS