
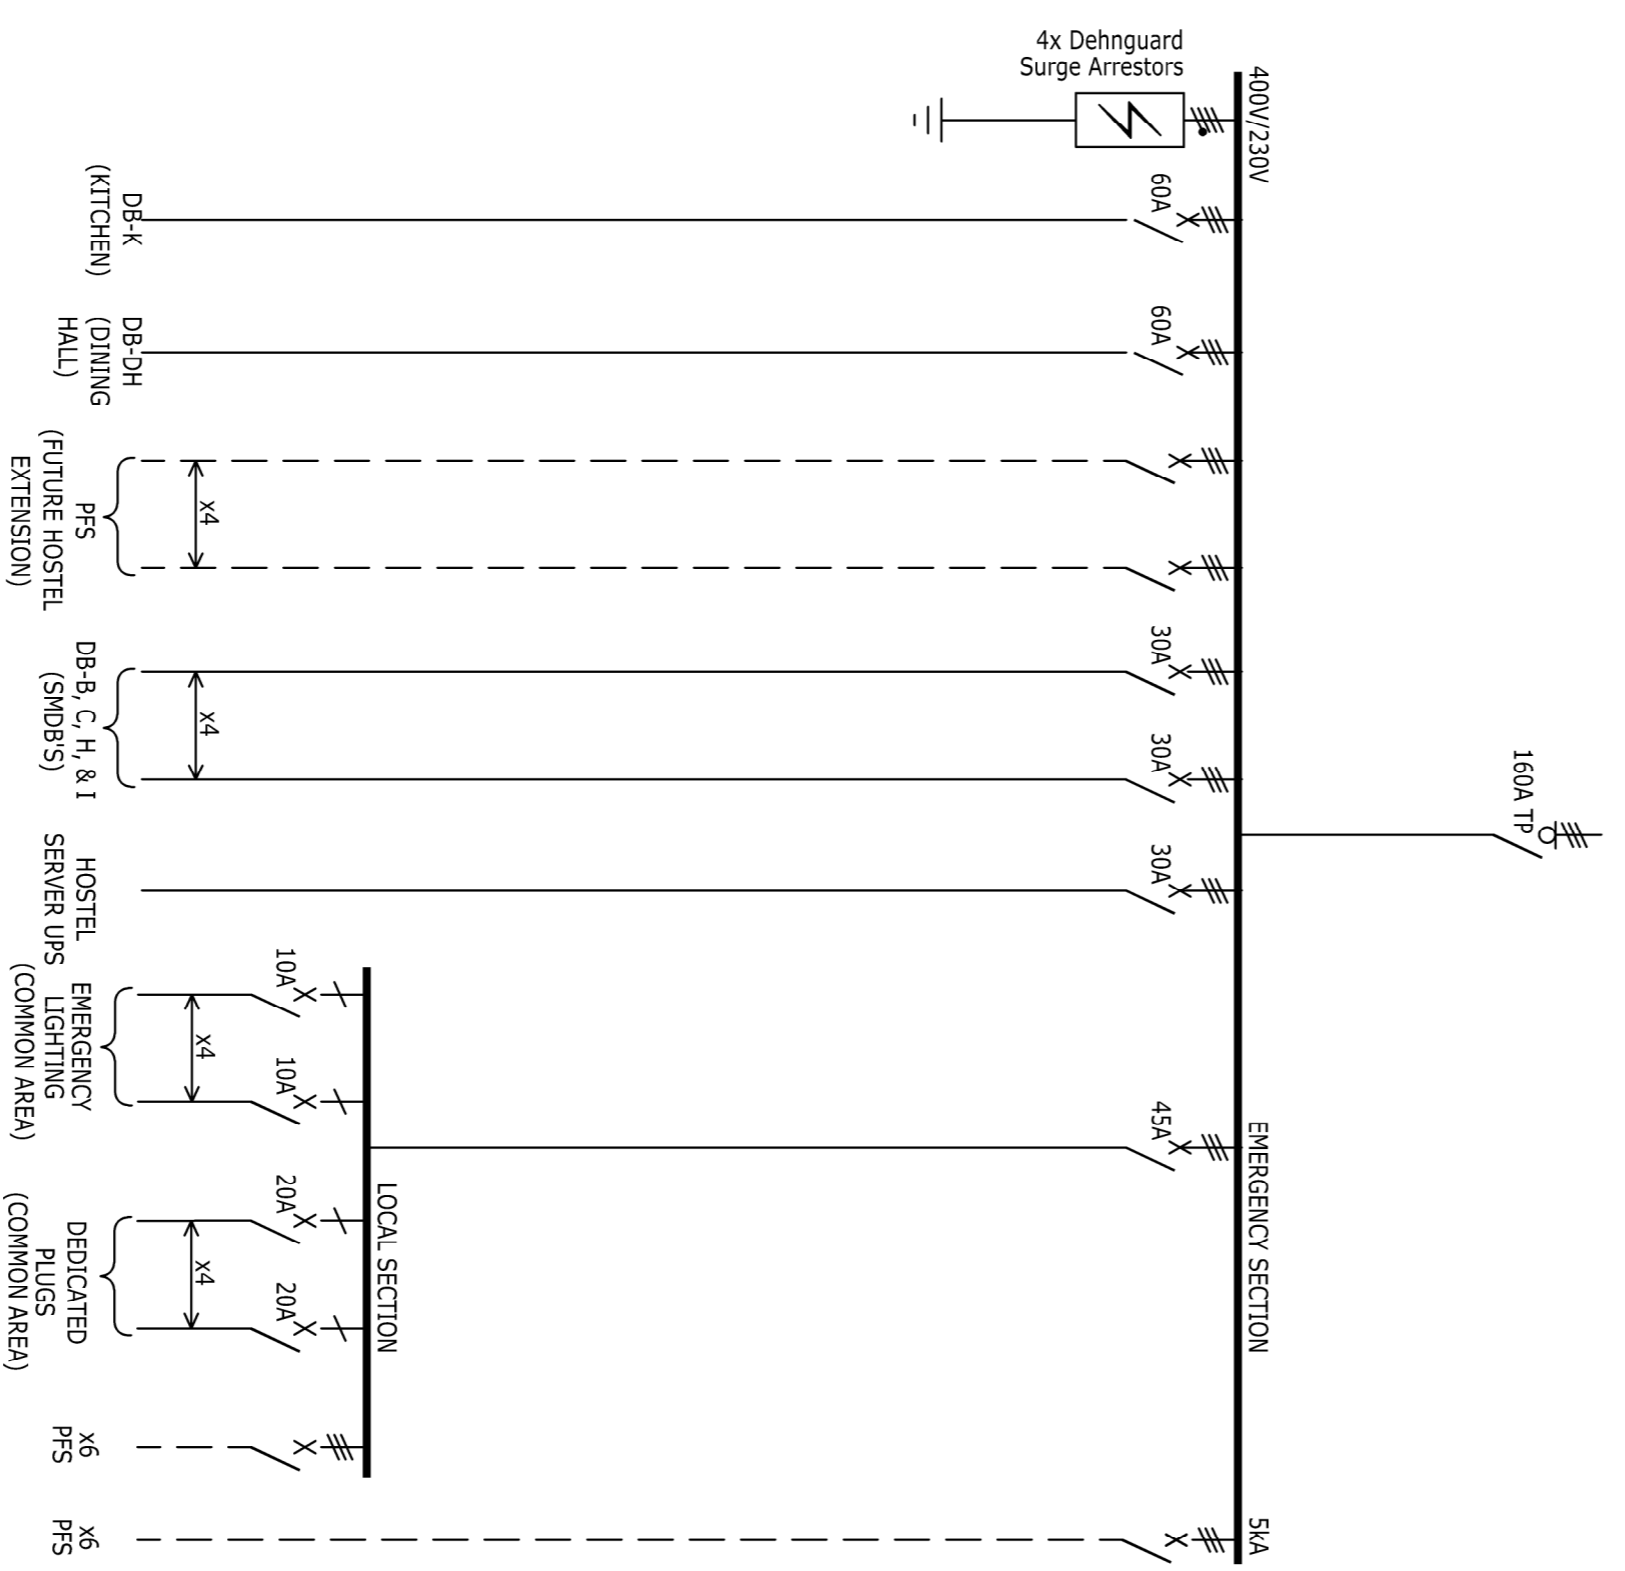


MDB & DB-A HOSTEL BUILDING			
BUS RATING	As Noted	5KA	
FAULT LEVEL	5KA		
TYPE	Floor Standing	Surface Mounted	Recessed
ACCESS	Front	Back	Both
CABLE ENTRY	Top	Bottom	Both
CABLE EXIT	Top	Bottom	Both
CONSTRUCTION	With Doors	No Doors	Lockable Doors
LIMITING DIMS			
COLOUR	Frame	Normal Panel	WHITE
	UPS Panels	BLUE	
		Emergency Panel	RED
PROTECTION	Cascading		Cascading Warning Label
SPARE SPACE	30%		
ADDITIONAL REQUIREMENTS: EXTERIOR WEATHERPROOF AND PLINTH MOUNTED			

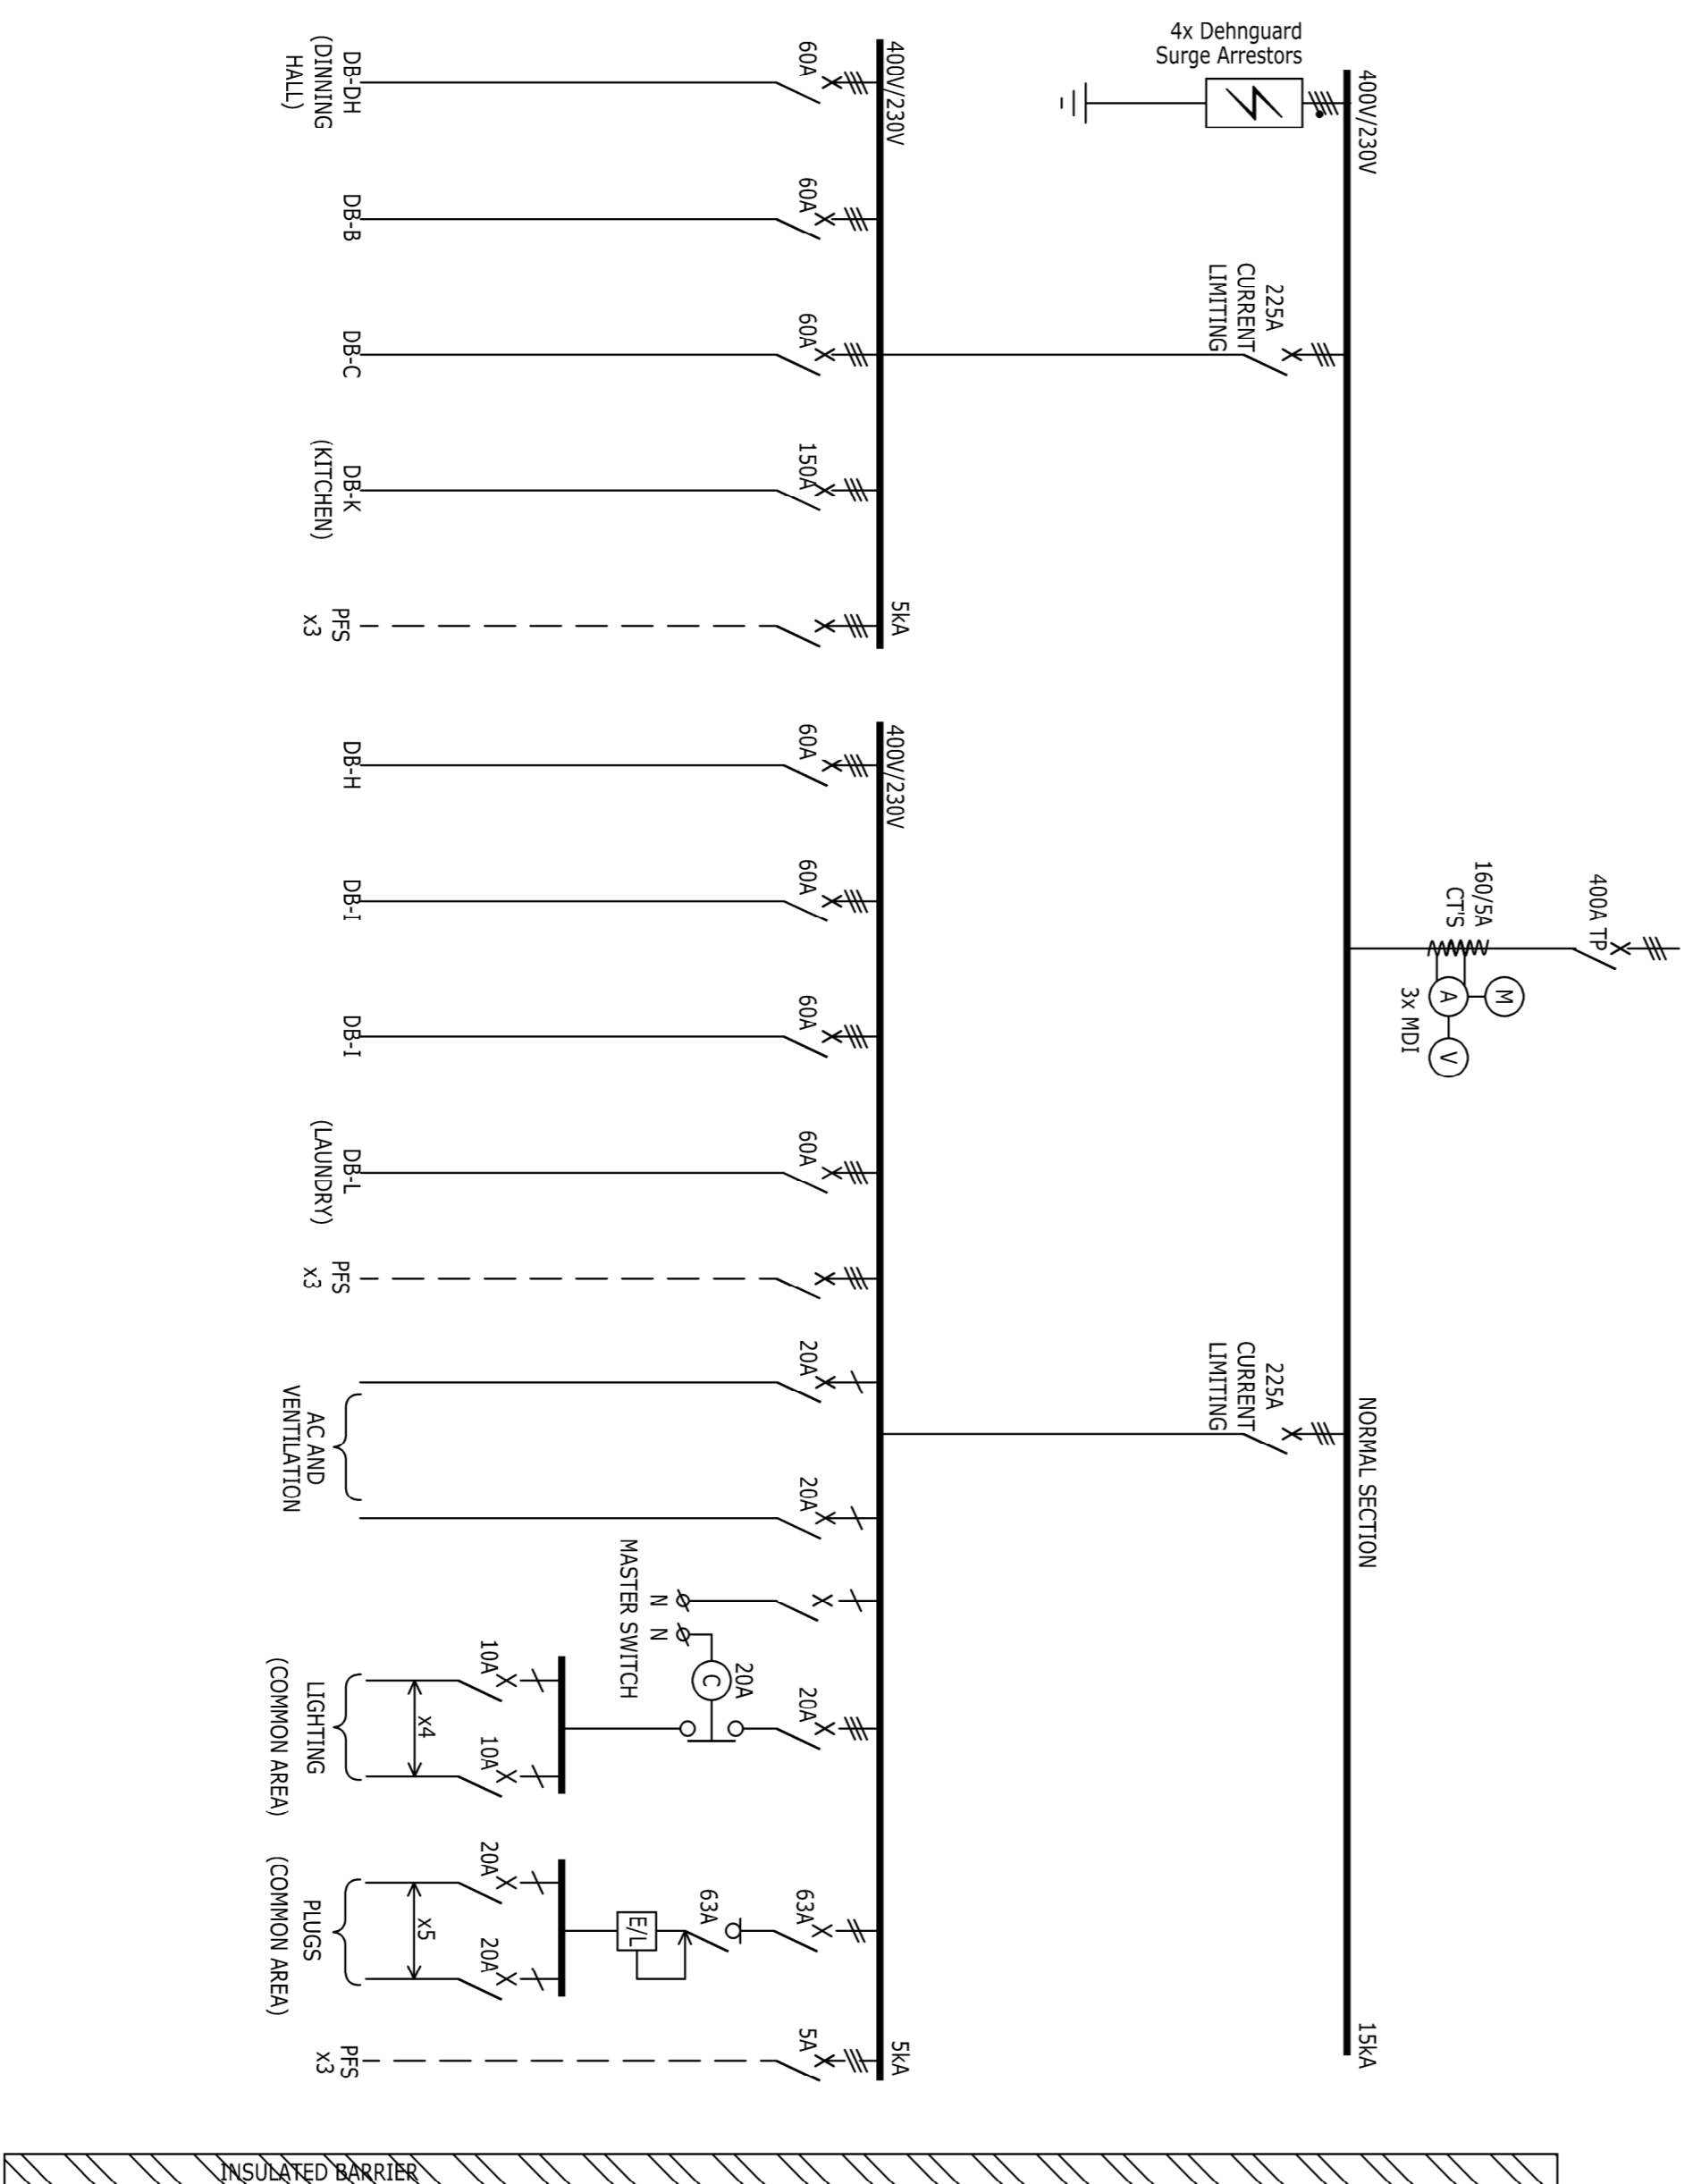

LEGEND:	
	CIRCUIT BREAKER
	AIR CIRCUIT BREAKER OR M.V. CIRCUIT BREAKER
	ISOLATOR
	FUSE SWITCH
	SPARE SPACE
	TIME SWITCH
	FIREMANS SWITCH
	FIRE INTERFACE
	PHOTOCELL
	KEY SWITCH
	MASTER SWITCH
	STOP/START SWITCH
	MAXIMUM DEMAND METER/KVA METER
	CONTACTOR
	RELAY
	BYPASS SWITCH
	EARTH LEAKAGE
	GENERATOR
	TRANSFORMER 11kV / 400V
	DEMAND INDICATING AMMETERS
	DEMAND INDICATING AMMETERS
	PRETTITTED SPACE
	KWH METER

TENDER

No.	DATE	AMENDMENT
A	2021/08/24	ISSUED FOR TENDER
		DA

Copyright vests in the Department of Public Works

certified as-built drawings as per Centralised Drawing Archive AS-BUILT DRAWING REQUIREMENTS

name: _____


date: _____

professional registration no.: _____

as-built drawings

cad file name: E6(14)(F)

page type: A 1

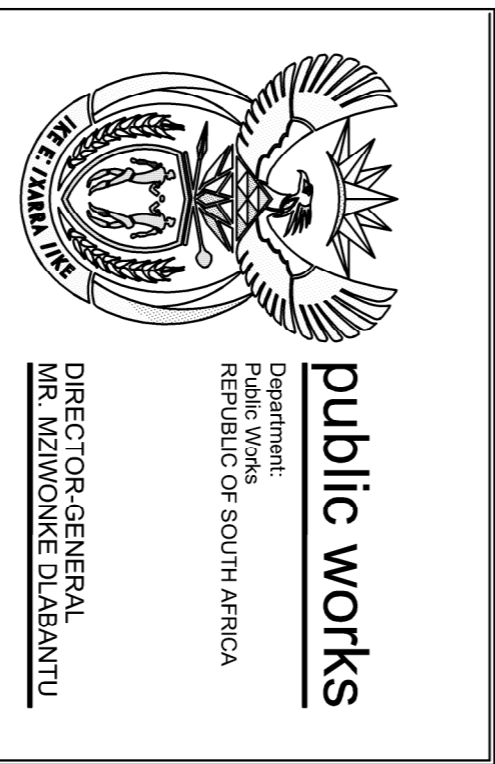

consultant

discipline: ELECTRICAL

service: TROMPSBURG SPECIAL NEEDS SCHOOL ELECTRICAL AND ELECTRONIC

WCS number: EDIT

drawing title: DISTRIBUTION BOARD HOSTEL MAIN DISTRIBUTION BOARD (MDB & DB-A) SINGLE LINE DIAGRAM HOSTEL BUILDING

ref.no: EDIT

scale: NTS

date: 2018.11.02

Designd: K.NEL

drawn: D.ALBIN

checked: K.NEL

DPW drawing number: E6(14)(F)