


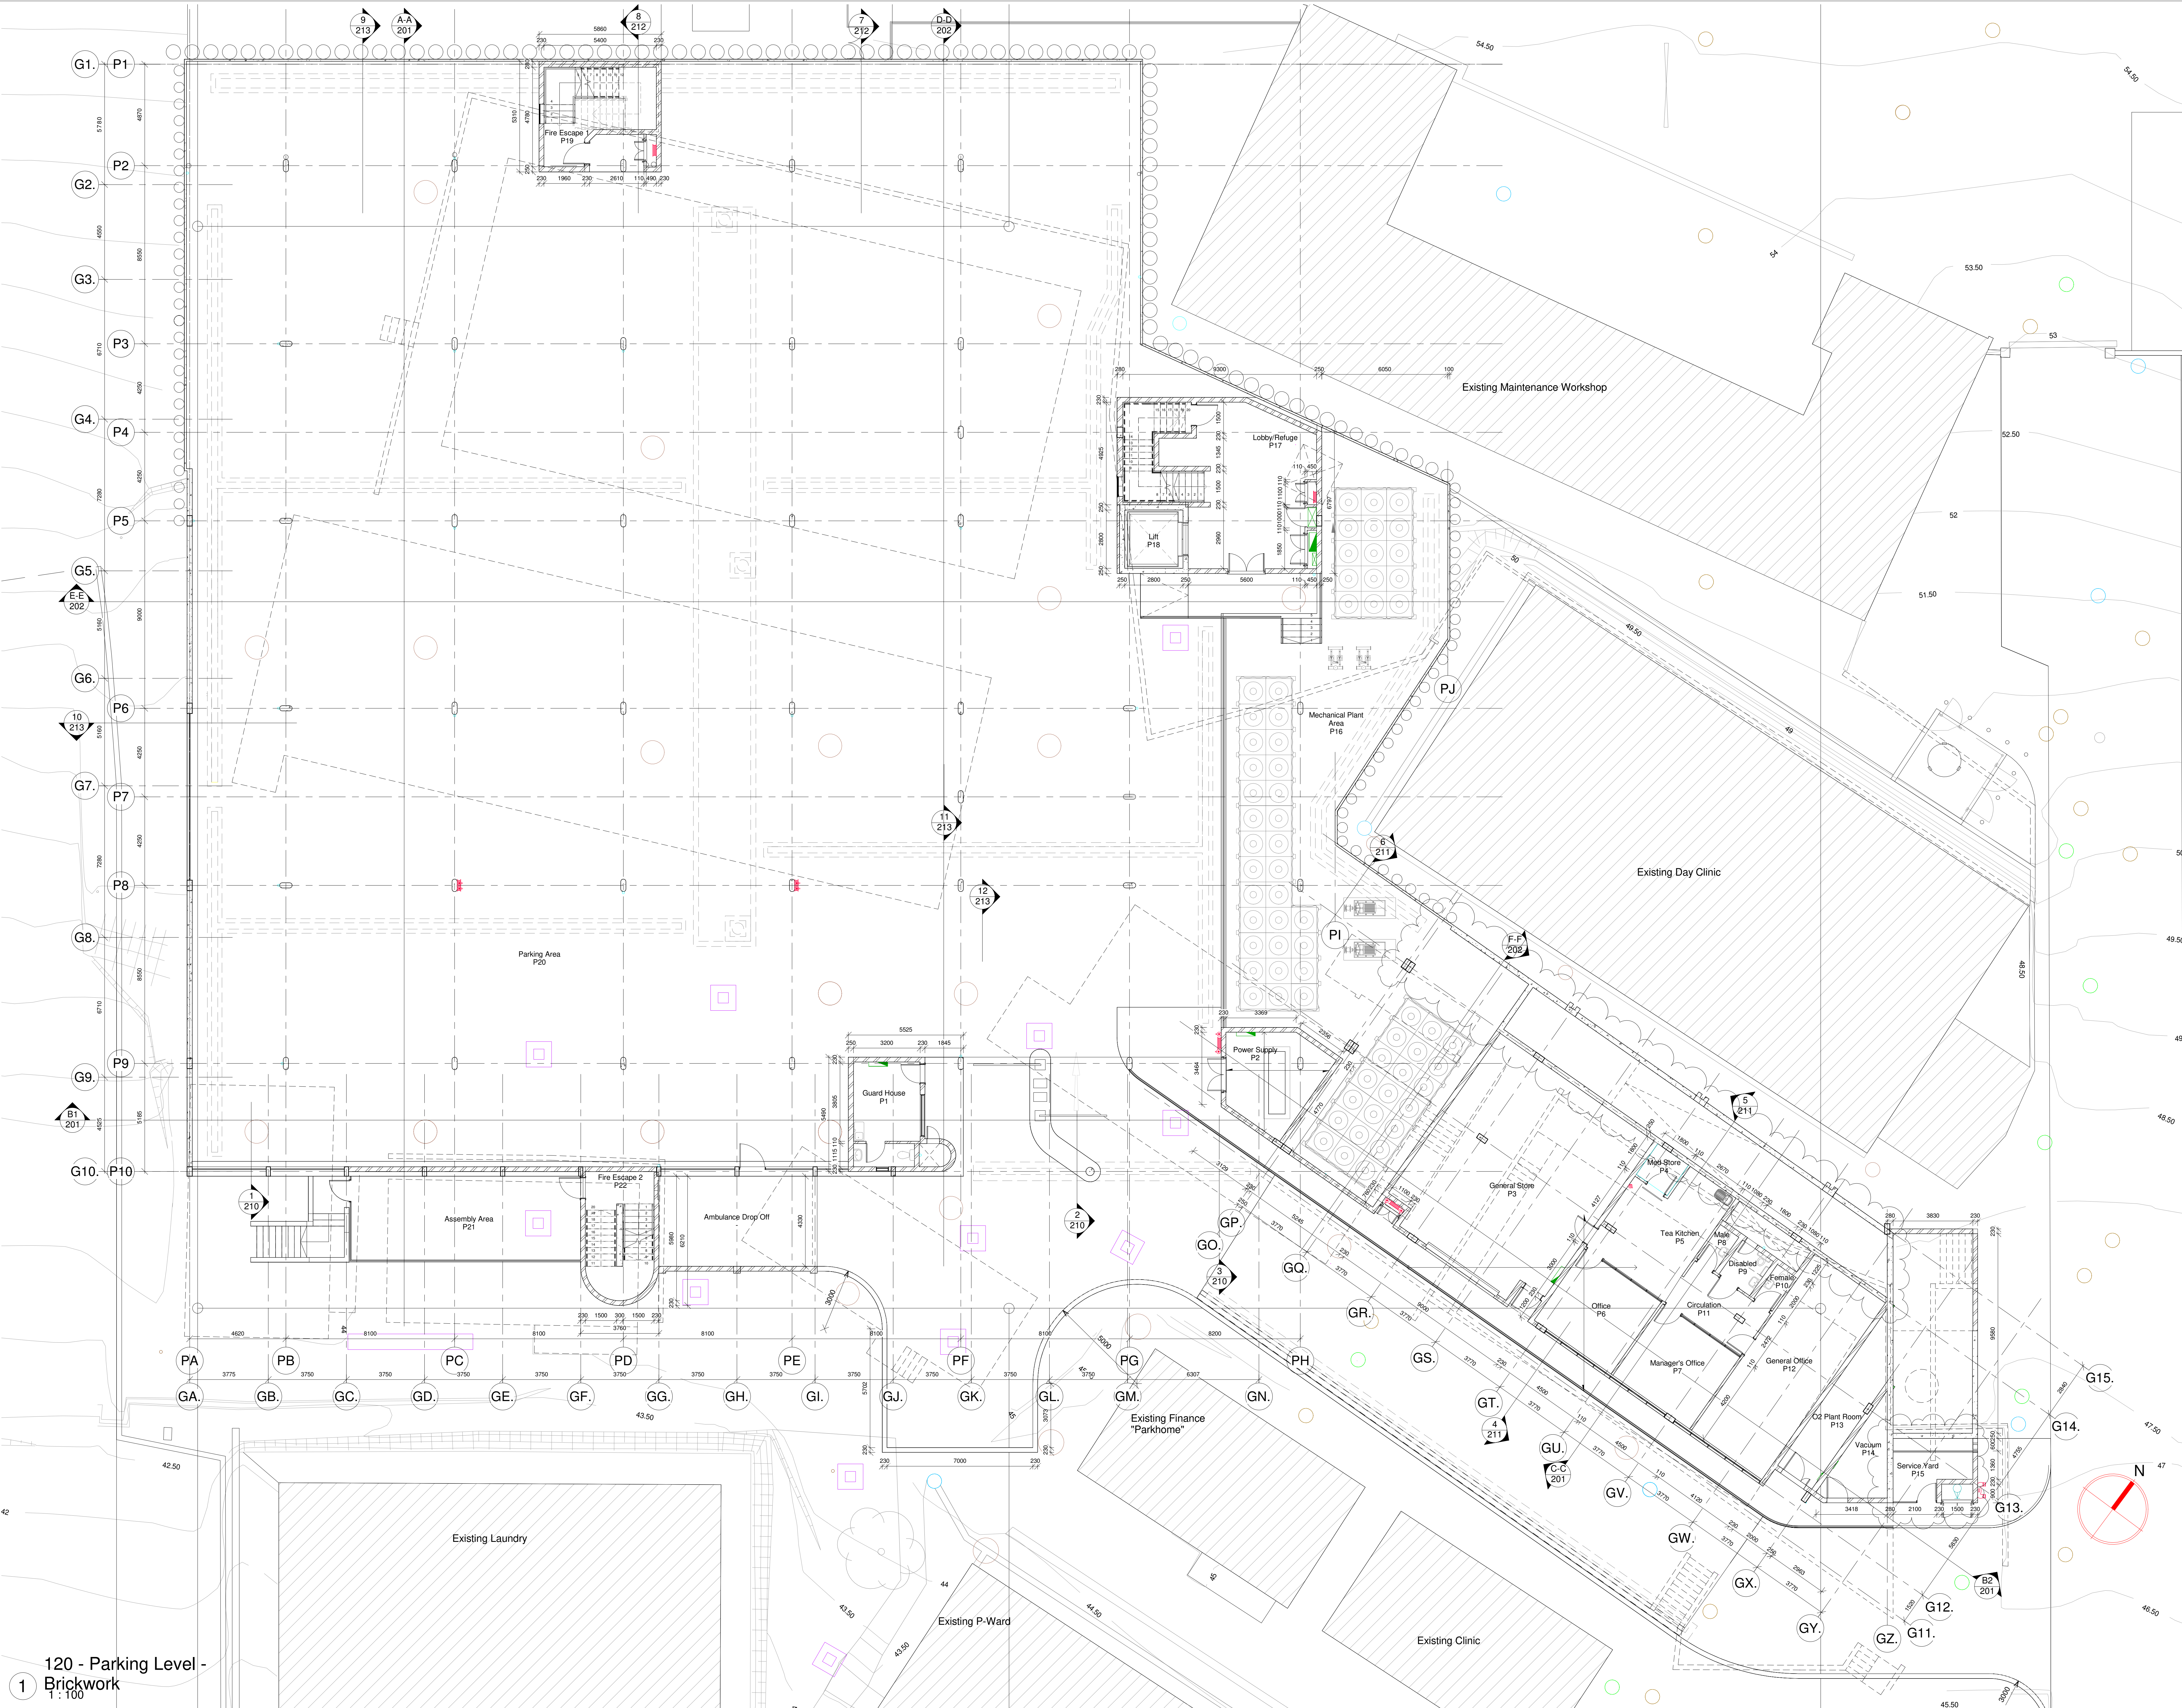

REVISIONS			
No.	Description	Date	By
G	Lift & staircases repositioned. Stores added on grid L to Q. Security office & additional parking bays added at front. Water tank & pump room extended. Mechanical plant area converted to Ambulance drop off zone.	22.06.2021	WP
A1	Minor changes as per NDOH	09.09.2021	SG
A2	Minor changes as per NDOH	20.09.2021	SG
A3	3 no. parking bays added. Columns moved to Grid 3B. Oxygen store added on Grid Q. Issued to NDOH	27.09.2021	SG
A4	Expansion joint added on grid M.	28.09.2021	WP
A5	Stores converted to Office space.	30.09.2021	WP
A6	Med Store relocated to General Store. General Office & O2 Plant Room extended.	12.10.2021	WP
A7	Office & Manager's Office reduced. General Office extended. Tea Kitchen & General Store extended. Columns on Grid 12 from N-Q omitted. Assembly area added.	05.11.2021	WP
A8	Lift Lobby & staircase reconfigured. Fire escape staircase reconfigured. Parking bays updated. Issued to consultants.	16.11.2021	WP
A9	External fire escape staircase repositioned. Ramp added at entrance to Lift Lobby.	15.02.2022	WP
A10	New position of O2 tank added. DB duct updated in Lift Lobby. Road Access & retaining wall updated. Assembly updated with fence added.	14.03.2022	WP
A11	Structural grid updated. SE staircase updated. Pedestrian walkway widened in front of Vacuum & O2 Plant room. Service yard added under ramp. Fire hose reels & fire extinguishers added.	18.03.2022	WP
A12	Duct added behind Guard House WC. Ducts above indicated. Ambulance drop off zone and Assembly area repositioned. Entrance Road widened.	21.06.2022	WP
A13	Column & parking layout updated. Building footprint updated.	03.06.2022	WP
A14	Parking bay added above Grid G6. Plant area increased for tanks. Column moved from H13 to H9. Sprinkler valve cupboard relocated outside Entrance ramp.	11.08.2023	WP
A15	Offices made smaller & columns in passage rotated. Structural grid & column positions updated. Window added to Guard house WC. Furniture layouts updated in stores. Access doors added to ducts. High level clerestory glazing added to Office & Manager's office.	06.09.2023	WP
A16	West entrance to Parking omitted. Ground Storey column grid added. Columns on grid P4/PB, P7/PA & P7/PB omitted.	02.11.2023	WP
A17	Wall on grid PA changed to 250mm concrete wall. Sprinkler valve cupboard & booster pump relocated next to Service yard.	12.03.2024	WP
		24.07.2024	WP

THIS DRAWING IS TO BE READ IN CONJUNCTION WITH SPECIFICATION DOCUMENT 1518-500-00

HEALTH DEPARTMENT SIGNATURES
ACTING CHIEF DIRECTOR: DOH INFRASTRUCTURE
DISTRICT MANAGER
CEO / MANAGER OF THE FACILITY
DOH PROJECT MANAGER
IMPLEMENTING AGENT PROJECT MANAGER
PROFESSIONAL SERVICE PROVIDER
NAME: MR. S.M. GOVENDER P- Arch 5913 (SACAP)
SIGNATURE: DATE: 2024.03.20

ARCHITECT
ARTEK 4 ARCHITECTS (Pty) Ltd
Durban: 46 Lena Avenue Road, Glenwood, Durban 4003
tel: 031 201 0445 fax: 031 201 6600 email: admin@artek4.co.za
Port Shepstone: 19 Tradewinds, Marine Drive, Chaffy Beach
tel: 039 682 2447 fax: 039 682 2448 email: adminp@artek4.co.za



SOUTHERN REGION

Project
WIMS NO. 044044: SOUTHERN REGION: PORT SHEPSTONE: DEPARTMENT OF HEALTH: PORT SHEPSTONE: PORT SHEPSTONE HOSPITAL: NEW PSYCHIATRIC WARD

Drawing Description
Parking Level - Brickwork

Scale 1 : 100	Drawn SG/ WP	Date 01/17/22
Consultant Project No. 1518	Drawing No. 120	Rev. A17

DOW Drawing number
WIMS no. 044044
Stamped by Plans Approval Committee