


**W07399-0991-LEGEND**

	W0233-3236 CONCRETE SPOT
	W0233-3235 CEILING HEIGHT
	WATER SUPPLY
	SEWER
	W0233-3232 ELECTRICAL
	W0233-3235 STORMWATER

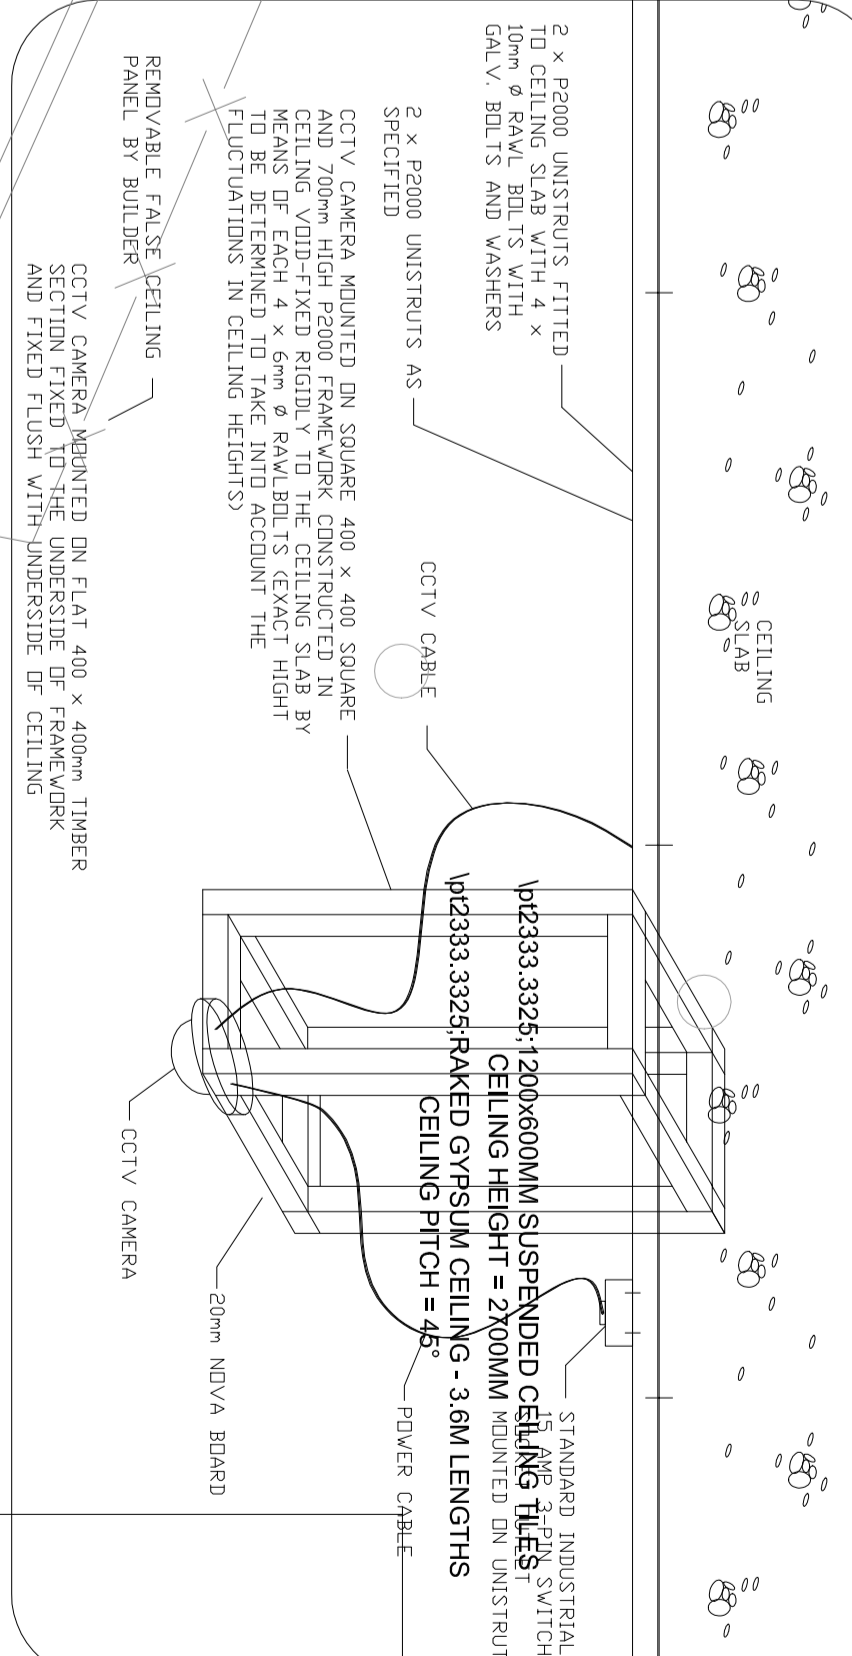

**LIST OF SYMBOLS FOR CCTV**

Symbol	Description
	CCTV SURVEILLANCE MONITORS
	CCTV CAMERAS
	25mm Diam. CCTV CONDUIT RUNS
	75mm Diam. CCTV OUTLET

- MONITORS 1, 2 and 3**
1. NURSES STATIONS ACCESS
  2. GENERAL SECURITY
  3. PARKING LEVEL MONITOR

**HEALTH DEPARTMENT SIGNATURES**

FACILITY STAMP \_\_\_\_\_

FACILITY MANAGER \_\_\_\_\_

INFRASTRUCTURE MANAGER \_\_\_\_\_

GENERAL MANAGER \_\_\_\_\_

CHECKED BY PROFESSIONAL CONSULTANT \_\_\_\_\_

Name: Timman Nhl

Signature: \_\_\_\_\_

Date: 30 September 2023

**CONSULTING ENGINEERS TJ NEL**

CONSULTING ELECTRICAL ENGINEERS

P. O. BOX 169

PORT EDWARD

4295

CELL: 083 - 2659623

**public works**

Department: **Public Works**

**PROVINCE OF KWAZULU-NATAL**

SOUTHERN REGION

**GROUND FLOOR**

**CCTV LAYOUT DRAWING**

Drawing Description

Drawn by: TJN Date: 12 November 2023

Scale: 5000mm Revised: UNSA/AB

Consultants Drawing number: SL 231 - CCTV 2

DCPW Drawing number: \_\_\_\_\_

Stamped by: Plans Approval Committee