


PG-001
 AIR COMPRESSOR PACKAGE
 CAPACITY: 281 NM³ D

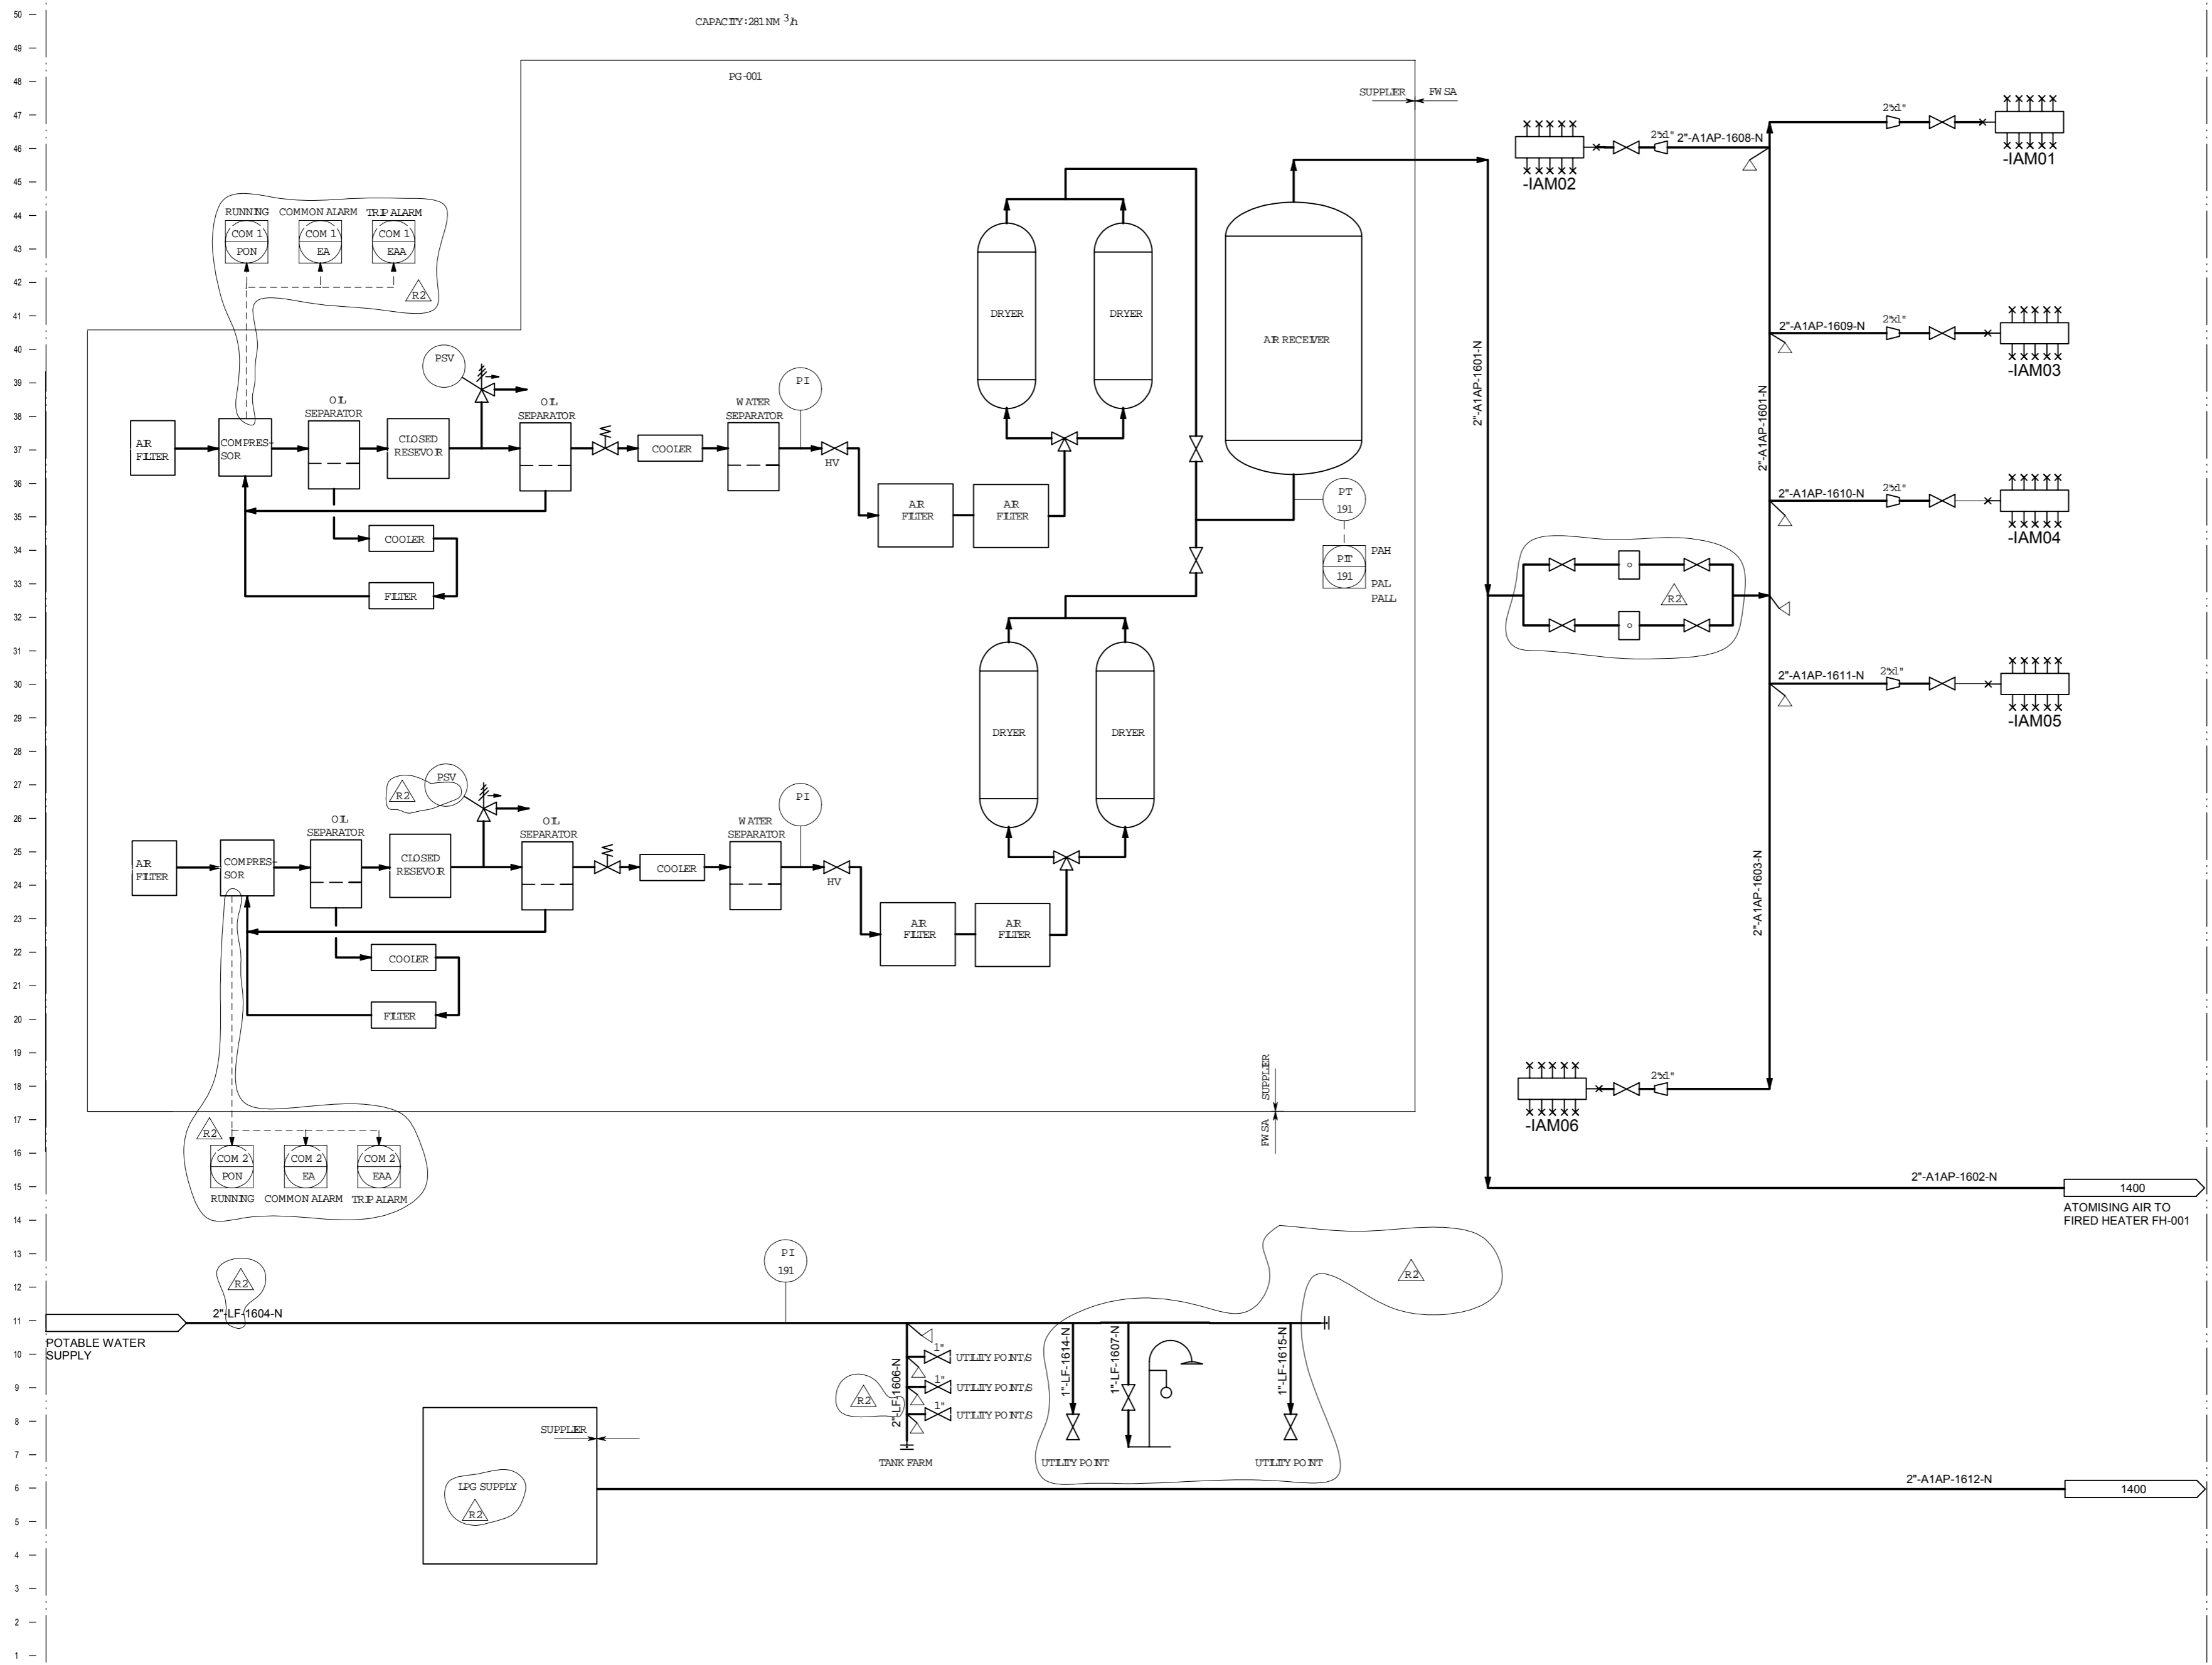

- HOLDS
 1. DELETED.
 2. DELETED.
 3. HOLD FOR POTABLE WATER TIE-IN DETAILS.
 4. HOLD FOR LPG SUPPLY DETAILS. R2

LAST LINE NO. 1615
 R2

R2	15.08.06	ISSUED FOR CONSTRUCTION WITH HOLDS	C.S.	G.J.L.	J.M.
R1	17.02.06	ISSUED FOR CONSTRUCTION WITH HOLDS	A.S.	G.J.L.	J.M.
A5	25.01.06	INSTRUMENT TAG UPDATE	A.S.	G.J.L.	J.M.
A4	30.09.05	RE-ISSUED FOR DESIGN	A.S.	S.M.	DEH.
A3	06.07.05	RE-ISSUED FOR DESIGN	A.S.	S.M.	DEH.
A2	17.03.05	RE-ISSUED FOR DESIGN	A.S.	S.M.	DEH.
A1	19.11.04	ISSUED FOR DESIGN	A.S.	S.M.	DEH.
H1	01.03.05	ISSUED FOR CLIENT HAZOP	A.S.	S.M.	J.M.
O1	15.10.04	ISSUED FOR COMMENT	A.S.	F.L.	DEH.

FW CONTRACT No.		DOCUMENT CLASS	
25913		DSN 000633	

FW FOSTER WHEELER SOUTH AFRICA (PTY) LTD
 THIS DRAWING IS LENT WITHOUT CONSIDERATION OTHER THAN THE BORROWER'S AGREEMENT THAT IT SHALL NOT BE REPRODUCED, COPIED, LENT, OR DISPOSED OF DIRECTLY OR INDIRECTLY NOR USED FOR ANY PURPOSE OTHER THAN THAT FOR WHICH IT IS SPECIFICALLY FORWARDED. THE APPARATUS SHOWN IN THE DRAWING IS COVERED BY PATENTS.



PIPING & INSTRUMENTATION DIAGRAM
INTERMIXTURE REFRACTIONATOR PROJECT
 AIR, POT WATER, NITROGEN UFD

DRAWING No.	25913-8820-25-1600	REV.	R2
-------------	--------------------	------	----

REVISION	R1	SIGN	J.M.	G.J.L.	J.D.L.	A.K.	DATE	17.02.06	17.02.06	17.02.06	17.02.06
REVISION	R2	SIGN	A.S.	J.M.	G.J.L.	R.P.H.	A.R.	DATE	11.08.06	15.08.06	15.08.06
REVISION	A2	SIGN	A.S.	DEH.	S.M.	J.D.L.	C.J.	DATE	01.07.05	01.07.05	01.07.05
REVISION	A1	SIGN	A.S.	DEH.	S.M.	J.D.L.	C.J.	DATE	06.07.05	06.07.05	06.07.05