



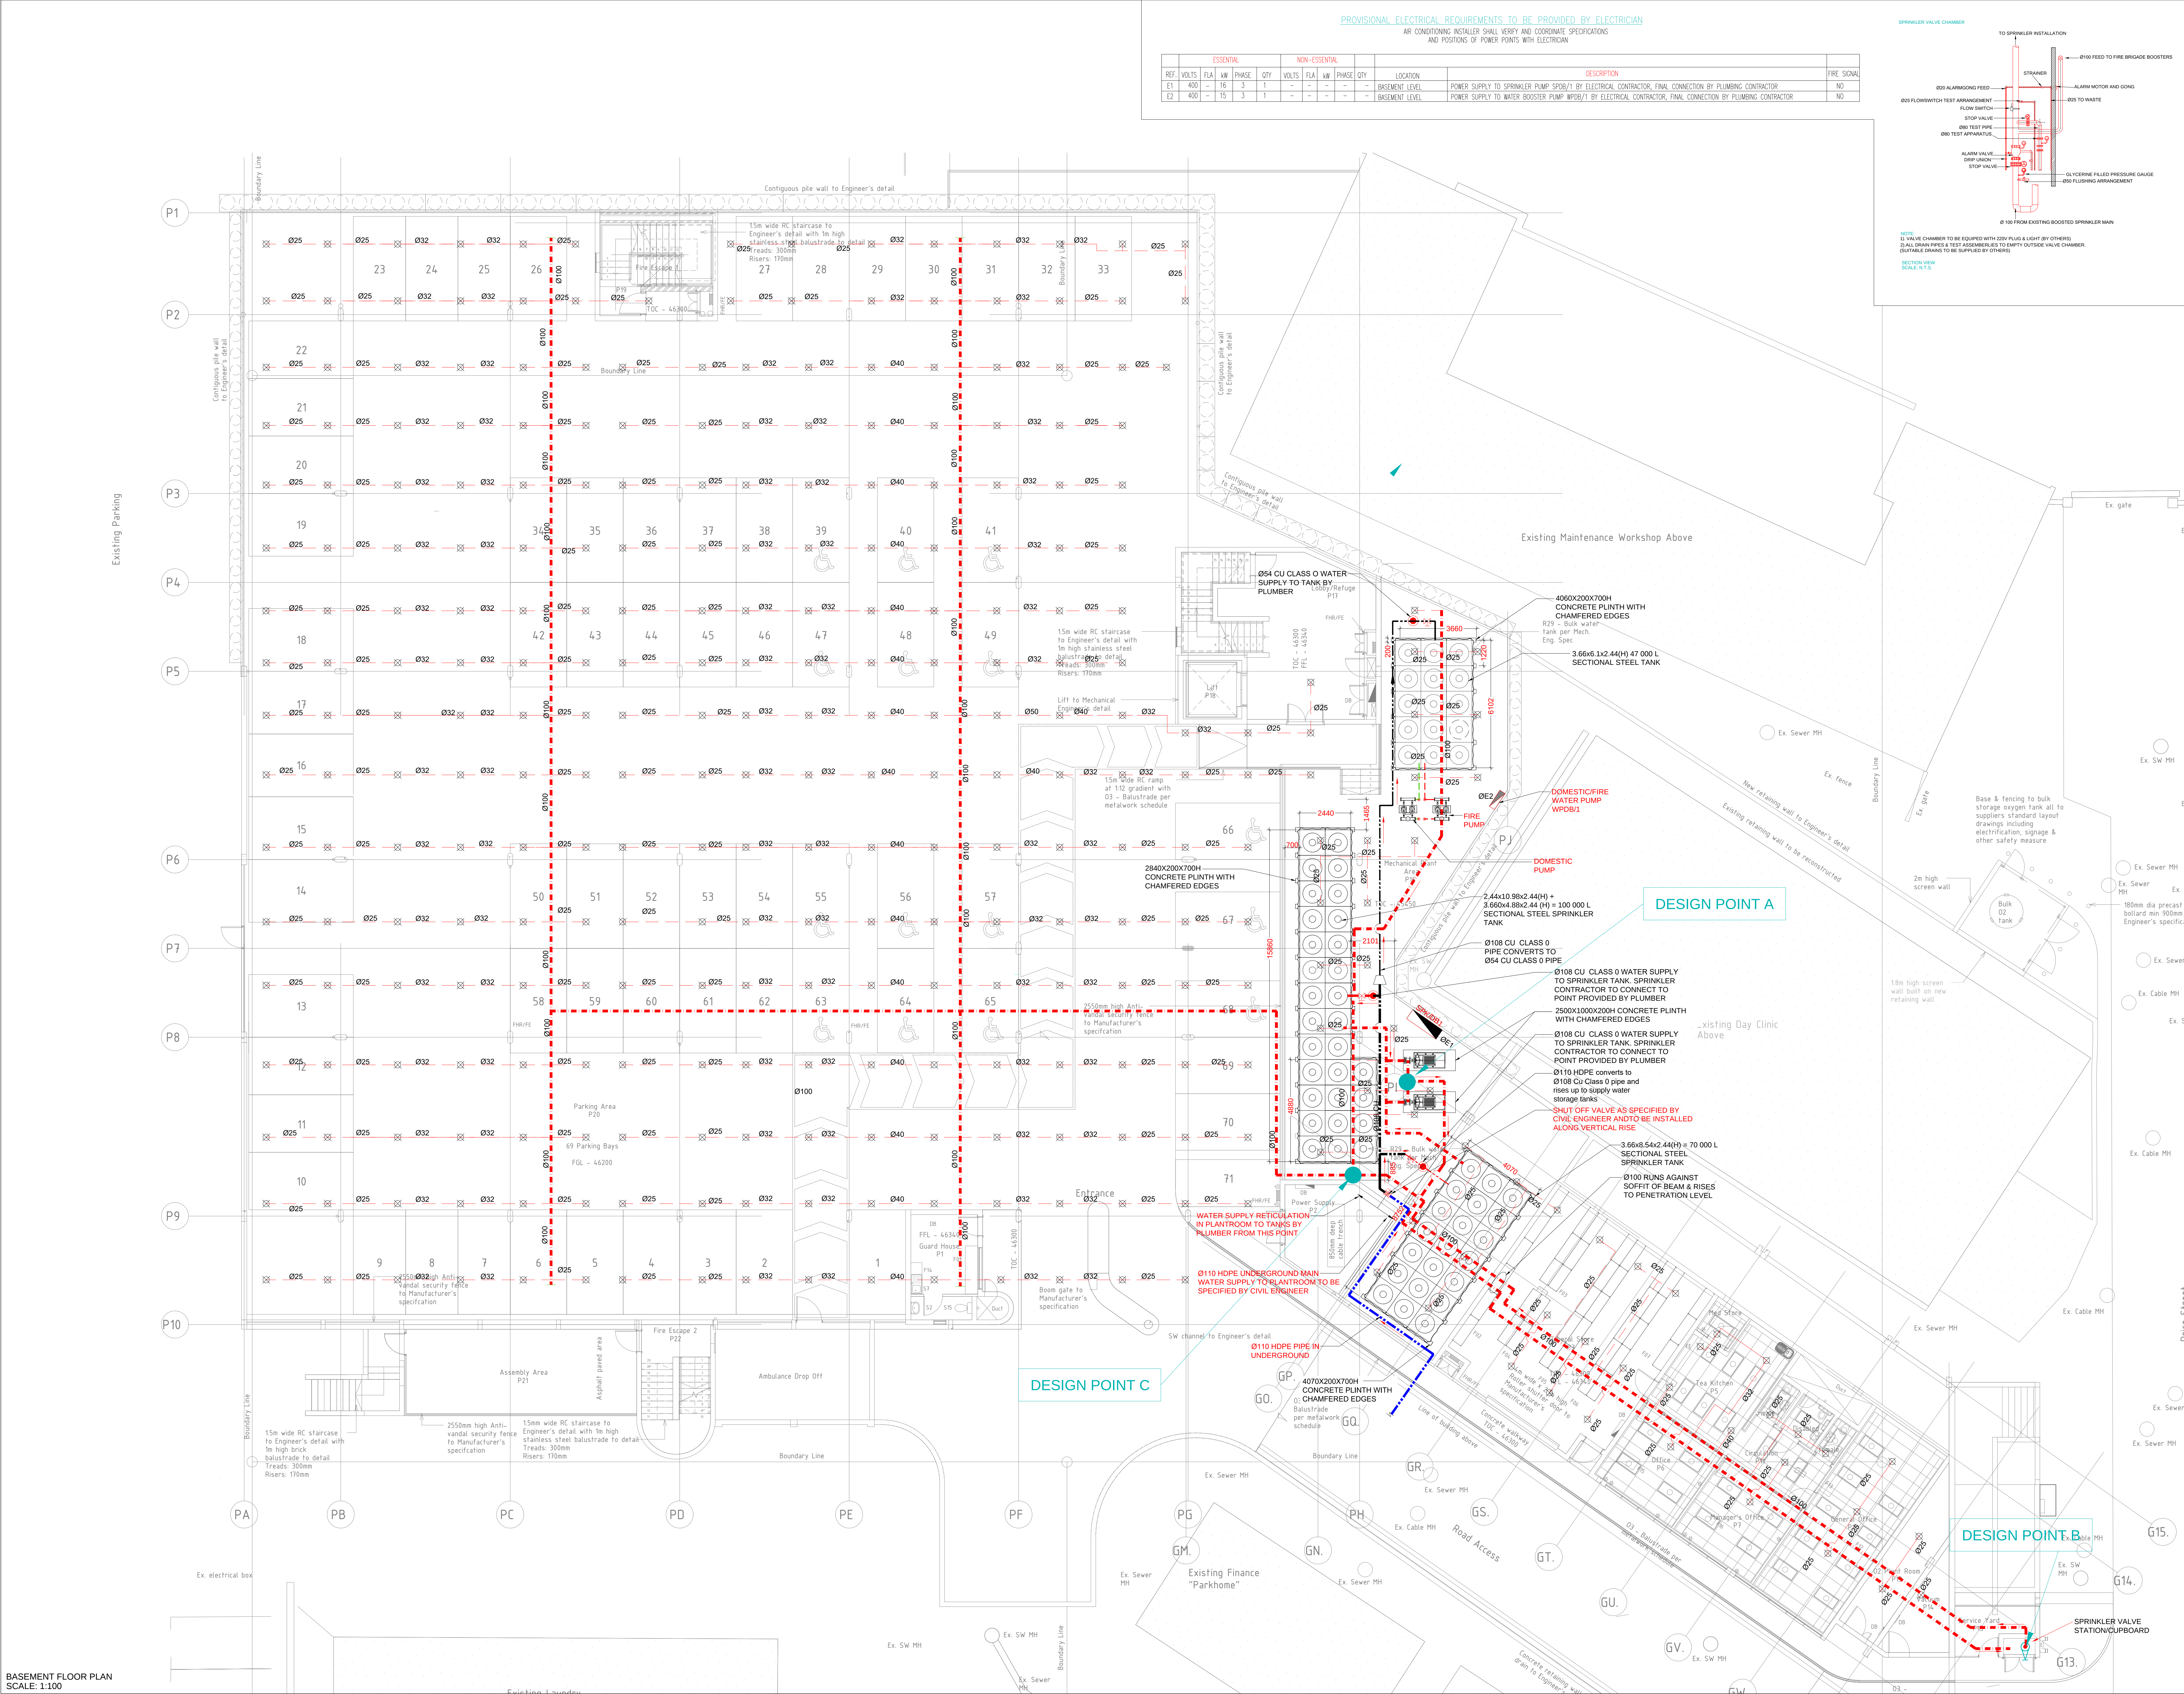

BASEMENT FLOOR PLAN
SCALE: 1:100

PROVISIONAL ELECTRICAL REQUIREMENTS TO BE PROVIDED BY ELECTRICIAN
AIR CONDITIONING INSTALLER SHALL VERIFY AND COORDINATE SPECIFICATIONS
AND POSITIONS OF POWER POINTS WITH ELECTRICIAN

ESSENTIAL						NON-ESSENTIAL							
REF.	VOLTS	FLA	KW	PHASE	QTY	VOLTS	FLA	KW	PHASE	QTY	LOCATION	DESCRIPTION	FIRE SIGNAL
E1	400	-	16	3	1	-	-	-	-	-	BASEMENT LEVEL	POWER SUPPLY TO SPRINKLER PUMP SP08/1 BY ELECTRICAL CONTRACTOR, FINAL CONNECTION BY PLUMBING CONTRACTOR	NO
E2	400	-	15	3	1	-	-	-	-	-	BASEMENT LEVEL	POWER SUPPLY TO WATER BOOSTER PUMP WP08/1 BY ELECTRICAL CONTRACTOR, FINAL CONNECTION BY PLUMBING CONTRACTOR	NO

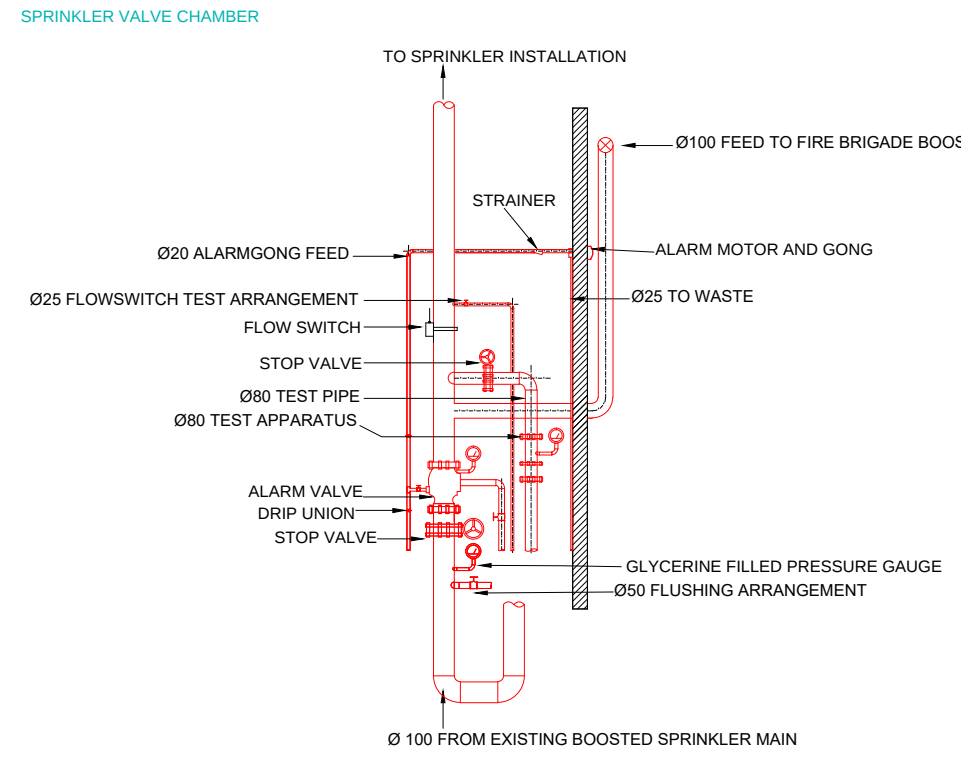

NOTE:
1) VALVE CHAMBER TO BE EQUIPPED WITH 220V FLUO & LIGHT BY OTHERS.
2) ALL DOWNPIPES & TEST APPARATUS TO EMPTY OUTSIDE VALVE CHAMBER.
(SUITABLE DRAWS TO BE SUPPLIED BY OTHERS)

SECTION VIEW
SCALE: 1:10

SPRINKLER PROTECTION

FOR TENDER

REV	DESCRIPTION	BY	DATE
0	ISSUED FOR TENDER	OM	11.07.2025
1	REVISION		

ARCHITECT:

ARTLEK 4 ARCHITECTS (Pty) Ltd
Durban: 46 Lena Avenue Road, Glenwood, Durban 4001
Tel: 031 201 0445 Fax: 031 201 0609 email: admin@artlek4.co.za
Port Shepstone: 19 Tradewinds, Marine Drive, Shep's Beach
Tel: 039 682 2447 Fax: 039 682 2446 email: adm@artlek4.co.za

CONSULTING MECHANICAL ENGINEERS:

MAHESH KHOOSAL & ASSOCIATES
Mechanical Consulting Engineers
PH: 031-536 8306
FAX: 031-536 8276

MCA

health
Department:
Health
PROVINCE OF KWAZULU-NATAL

KWAZULU-NATAL PROVINCE
PUBLIC WORKS
REPUBLIC OF SOUTH AFRICA

SOUTHERN REGION

Project

DEPARTMENT OF HEALTH INSTITUTION
NEW PSYCHIATRIC WARD PORT
SHEPSTONE HOSPITAL

Drawing Description

WET SERVICES : WATER SUPPLY
SPRINKLER BASEMENT PLAN LAYOUT

Drawn AS Date 27/09/2021

Scales 1:100

Consultant Drawing number
M652/SPK/01 Rev.0

DOPW Drawing number
WIMS NO/044044/A01

Stamped by Plans Approval Committee