


SYMBOL	DESCRIPTION	QTY	MAKE
Z1	SUITABLE ZONE 1 EX LED LUMINAIRE	0	TBC
Z2	SUITABLE ZONE 2 EX LED LUMINAIRE	5	TBC
RM	RAIL MOUNT	3	
FM	FLOOR MOUNT	1	
BM	BUND MOUNT	1	
	PROPOSED CABLE ROUTE		
	EXISTING CABLE		

SPECIAL NOTES:

MINIMUM REQUIRED LIGHTING LUX LEVELS AS PER PL 682 SPEC

NOTES:

1. RACKING TO COMPLY WITH TPL SPECIFICATION PL727.
2. RACKING MATERIAL: GALVANISED STEEL LADDER RACK.
3. RACKING TO BE INSTALLED 300mm CLEAR OF FLANGES (TO ALLOW FOR FLOGGING ACCESS).
4. INSTRUMENT AND ELECTRICAL RACKS TO CROSS AT 90 DEGREES.
5. DOUBLE BANKING OF CABLES ON RACKS IS PERMITTED.
6. ONLY MAIN RACKING RETICULATION ROUTES ARE SHOWN. SECONDARY RACKING AND ANGLE IRON DROPPERS TO BE SITE RUN.

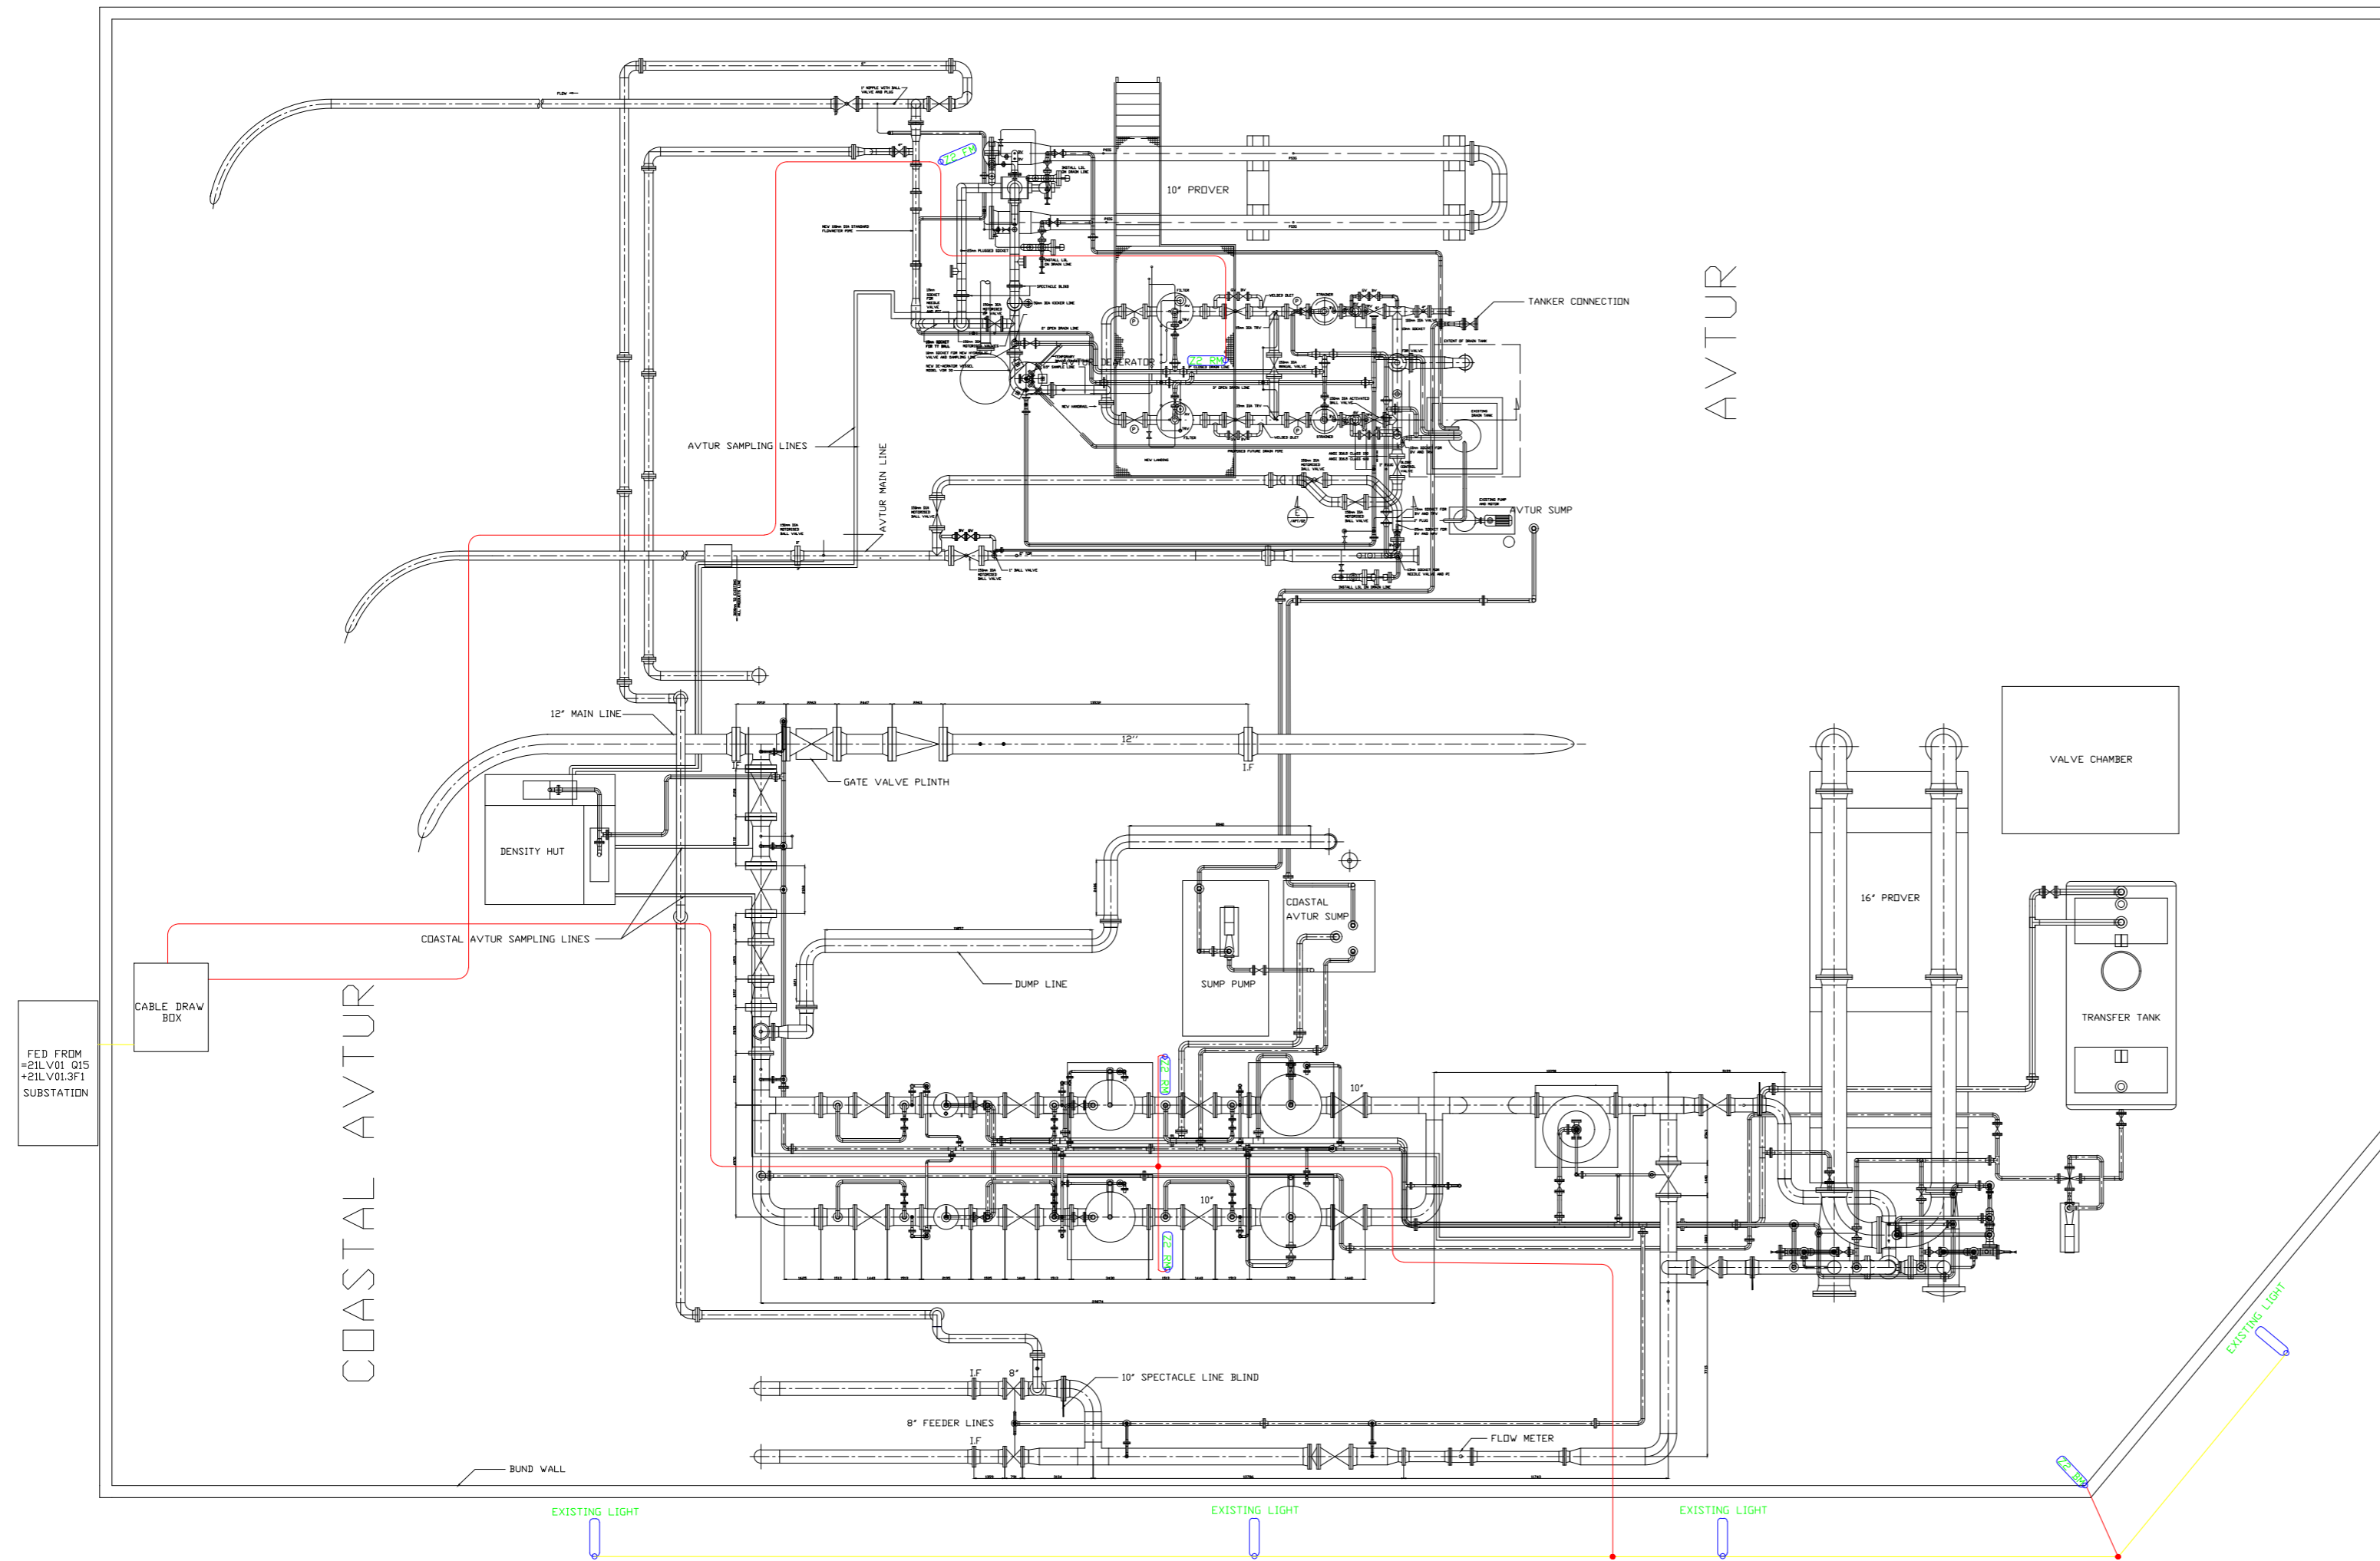

PROPOSAL

TRANSNET
pipelines
MANIFOLD LIGHTING LAYOUT
AIRPORT DEPOT

REVISIONS		
PROJECT NAME	LIGHTING UPGRADE	
DRAWN	W.D	REF.
TRACED	CAD	DATE 28.06.21
CHECKED	K.N	APPROVED Z.M
SCALE	NTS	
DRAWING No.	REV	
PL 121583		