


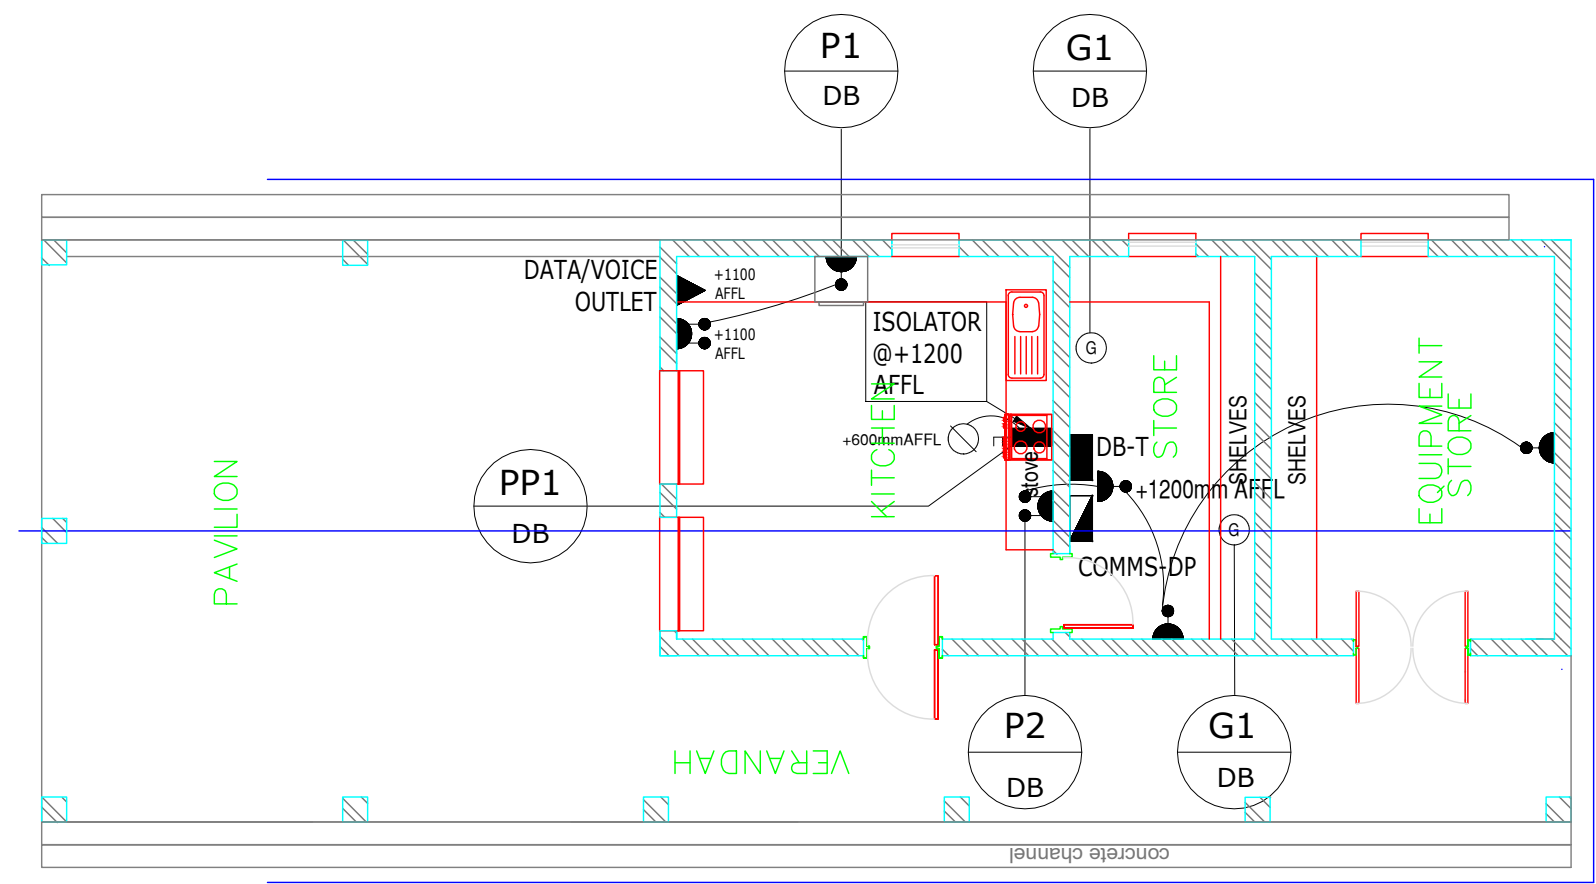

Plan – TUCK SHOP

SMALL POWER LAYOUT
1:100

SMALL POWER LEGEND

- COMMS, SECURITY AND FIRE DETECTION PANEL
- ELECTRICAL DISTRIBUTION BOARD
- WORKSTATION OUTLET @+300mm AFFL
UNLESS OTHERWISE INDICATED CONSISTING OF:
1x DUO 16A SSO
3x RSA 3PIN SSO'S
- WORKSTATION OUTLET @+300mm AFFL
UNLESS OTHERWISE INDICATED CONSISTING OF:
1x DUO 16A SSO
3x RSA 3PIN SSO'S
1x DATA/VOICE OUTLET
- WORKSTATION OUTLET POWERSKIRTING
CONSISTING OF:
1x 16A DEDICATED SSO
1x DATA/VOICE OUTLET
- DATA / VOICE OUTLET AT +300mm AFFL TO
CENTRE IN 100x 100mm BOX.
- 16A SWITCHED SOCKET OUTLET WITH 1x RSA
3-PIN SOCKET OUTLET MOUNTED AT +300mm
AFFL TO CENTRE IN 100x 100mm BOX.
- P9000 TRUNKING IN CEILING VOID FOR
LIGHTING AND POWER RETICULATION.
- P8000 TRUNKING IN CEILING VOID FOR COMMS
/ SECURITY AND FIRE RETICULATION.
- GEYSER OUTLET

No.	DATE	AMENDMENT	.
A	11/5/21	ISSUED FOR TENDER	D.A.
B	1/10/21	UPDATED FOR TENDER	D.A.
Copyright vests in the Department of Public Works			
as-built drawings			
certified as-built drawings as per Centralised Drawing Archive AS-BUILT DRAWING REQUIREMENTS			
name: _____			
date: _____			
professional registration no.: _____			

cad file name	page type
E6(11)(a)	A 2



public works
Department:
Public Works
REPUBLIC OF SOUTH AFRICA

DIRECTOR-GENERAL
MR. MZIWONKE DLABANTU

consultant	
discipline	ELECTRICAL
service	
WCS number	EDIT
drawing title	TROMPSBURG SPECIAL NEEDS SCHOOL ELECTRICAL AND ELECTRONIC
ref.no.	EDIT
scale	1:100
date	2018.11.02
DPW drawing number	E6(11)(a)

TENDER