


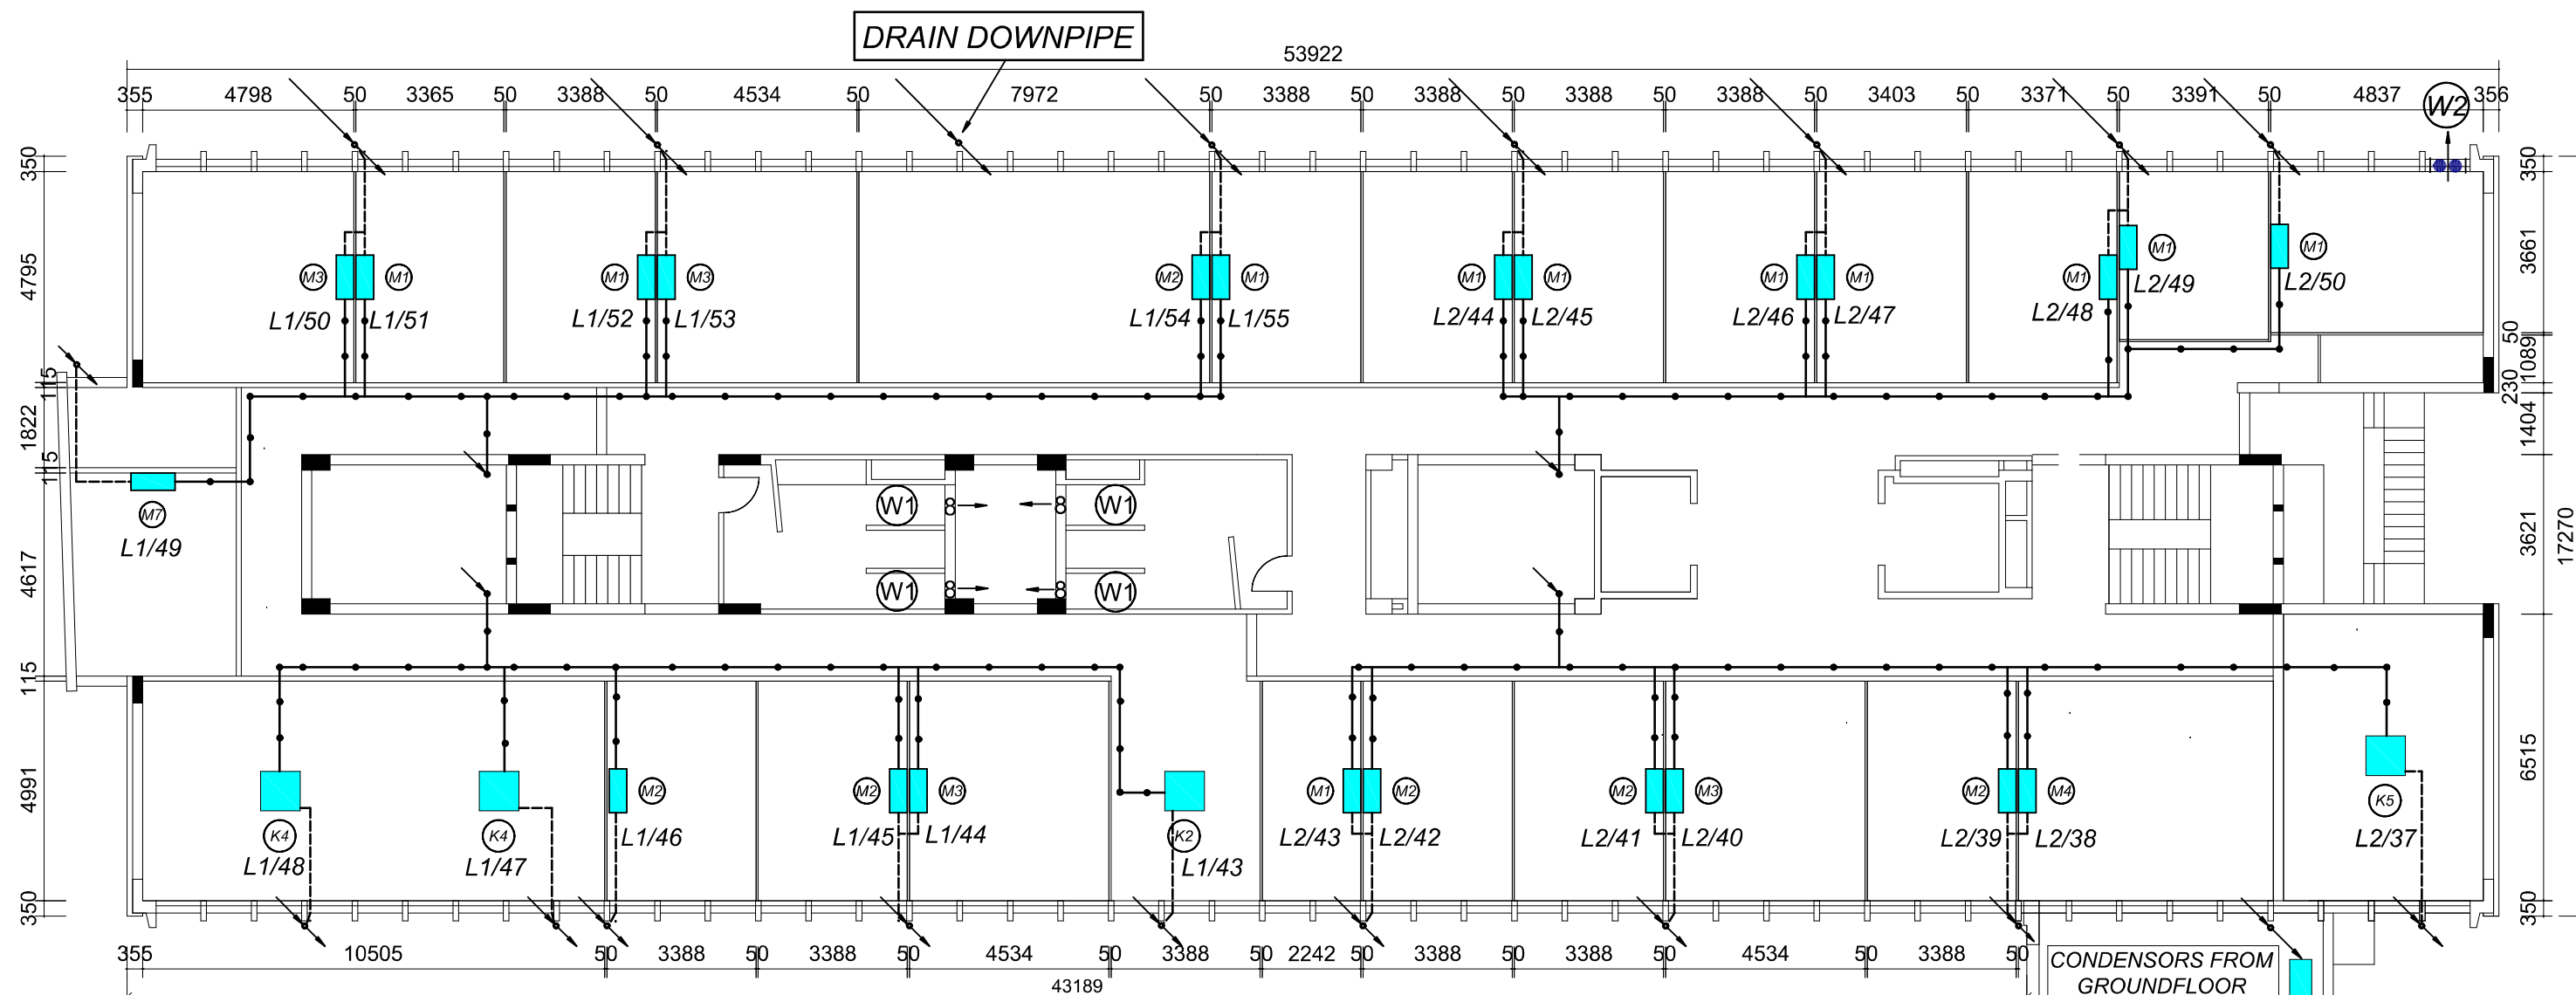

LEGEND:

H 1 = 7.1 kWc Hide Away 350 l/s
H2 = 9.0 kWc Hide Away 460 l/s

D1 = Ø150mm Constant Volume Diffuser

G1 = 1200 x 600mm Hinged Return Air Grille, complete with washable filter and holding frame.

W1 = Window Extract Fan 120l/s.

W2 = Window Extract Fan 255l/s.

K1 = 2.2 kWc Cassette
K2 = 2.8 kWc Cassette
K3 = 3.6 kWc Cassette
K4 = 4.5 kWc Cassette
K5 = 5.6 kWc Cassette
K6 = 7.1 kWc Cassette
K7 = 9.0 kWc Cassette

M1 = 2.2 kWc Midwall
M2 = 2.8 kWc Midwall
M3 = 3.6 kWc Midwall
M4 = 4.5 kWc Midwall
M5 = 5.6 kWc Midwall

Refrigerant Pipping.
uPVC class 6 Drain Pipe

NOTE:

AC units on this (Ground) floor are all split units with position of outdoor condensators on First Floor Roof.

SECOND FLOOR

ROOF OVER FIRST FLOOR

CONDENSATORS FROM GROUND FLOOR LEVEL UNITS

2 - D3 - 140

Flow through a diffuser (l/s)

Diffuser size and type

Number of diffusers

DRAWING DESCRIPTION:	DRAWN:	DESIGNED:	 public works & infrastructure Department of Public Works & Infrastructure FREE STATE PROVINCE ENGINEERING PLANNING SERVICES DRAW No: M.PW.3.2015/16-ML010 FILE No: M.PW.3.2015/16
NEW HVAC INSTALLATION SECOND FLOOR PLAN LAYOUT	J.H. KYMDELL	C.A. SKIBBE	
SERVICE:	APPROVED:	CHECKED:	
MEDFONTEIN BUILDING BLOEMFONTEIN	DATE:	SCALE:	
	07-07-2015	1:150 SHEET: A3	