


16684-D01-A

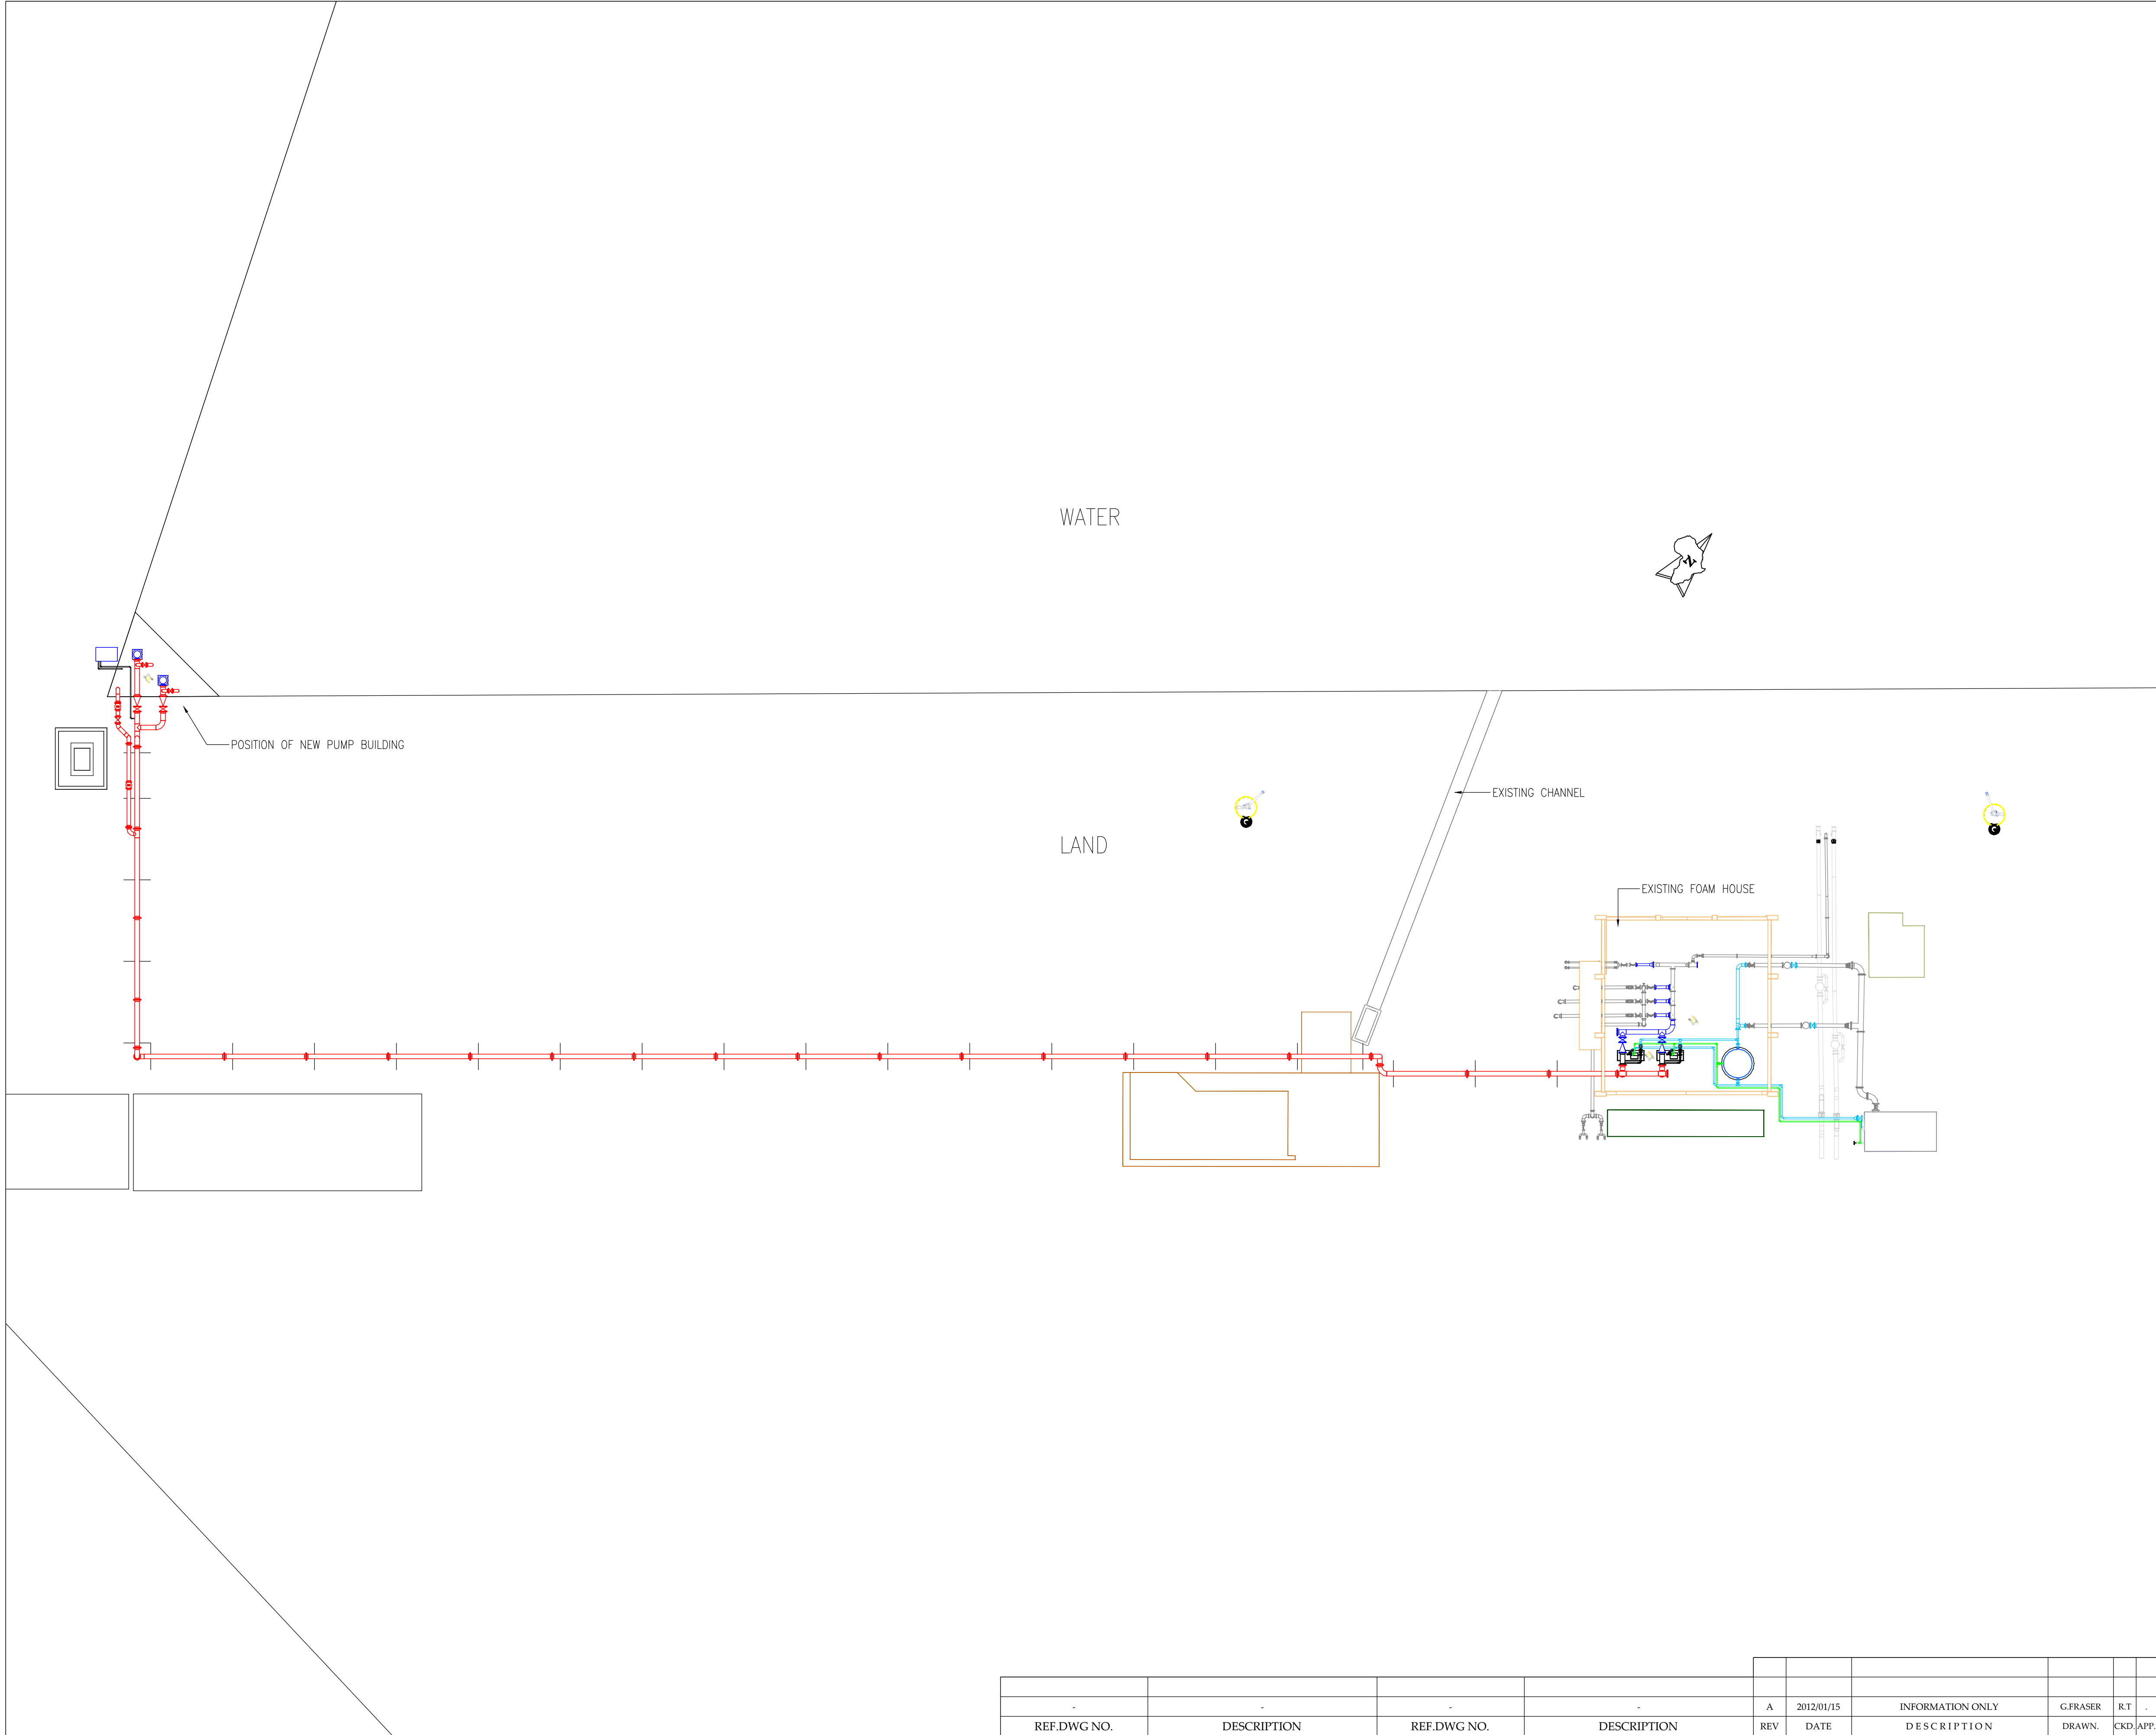

©COPYRIGHT
THIS DRAWING & DESIGN ARE CONFIDENTIAL &
THE PROPERTY OF KANTEY & TEMPLER & MAY
NOT BE DISCLOSED TO A THIRD PARTY,
COPIED/REPRODUCED IN WHOLE OR IN PART
WITHOUT THE WRITTEN PERMISSION OF
KANTEY & TEMPLER.

LEGEND:

- SEA WATER
- FOAM
- RELIEF LINE
- FOAM & WATER MIX

THIS IS A CAD DRAWING AND MUST
NOT BE ALTERED MANUALLY



KANTEY & TEMPLER
CONSULTING ENGINEERS
Engineering African Development
P O BOX 1621 WANDSBECK 3631 TEL 0312666535

DESIGNED: R.THOMSON	DRAWN: G.FRASER	DATE 2012/01/15	DRAWING NO. 16684-D01
------------------------	--------------------	--------------------	--------------------------




PROJECT: TNPA EL HARBOUR FIRE FIGHTING


PROPOSED GENERAL
ARRANGEMENT

									CODE: 16684	SCALE: 1:250	STATE: DRAFT
									DRAWN: GF	DATE: 2012/01/15	SHEET NO. 1
				A	2012/01/15	INFORMATION ONLY	G.FRASER	R.T	CHECKED: RT	DRAWING No. 16684-D01	
REF.DWG NO.	DESCRIPTION	REF.DWG NO.	DESCRIPTION	REV	DATE	DESCRIPTION	DRAWN	CKD/APP	APPR: -		REV A


16684-D03-B

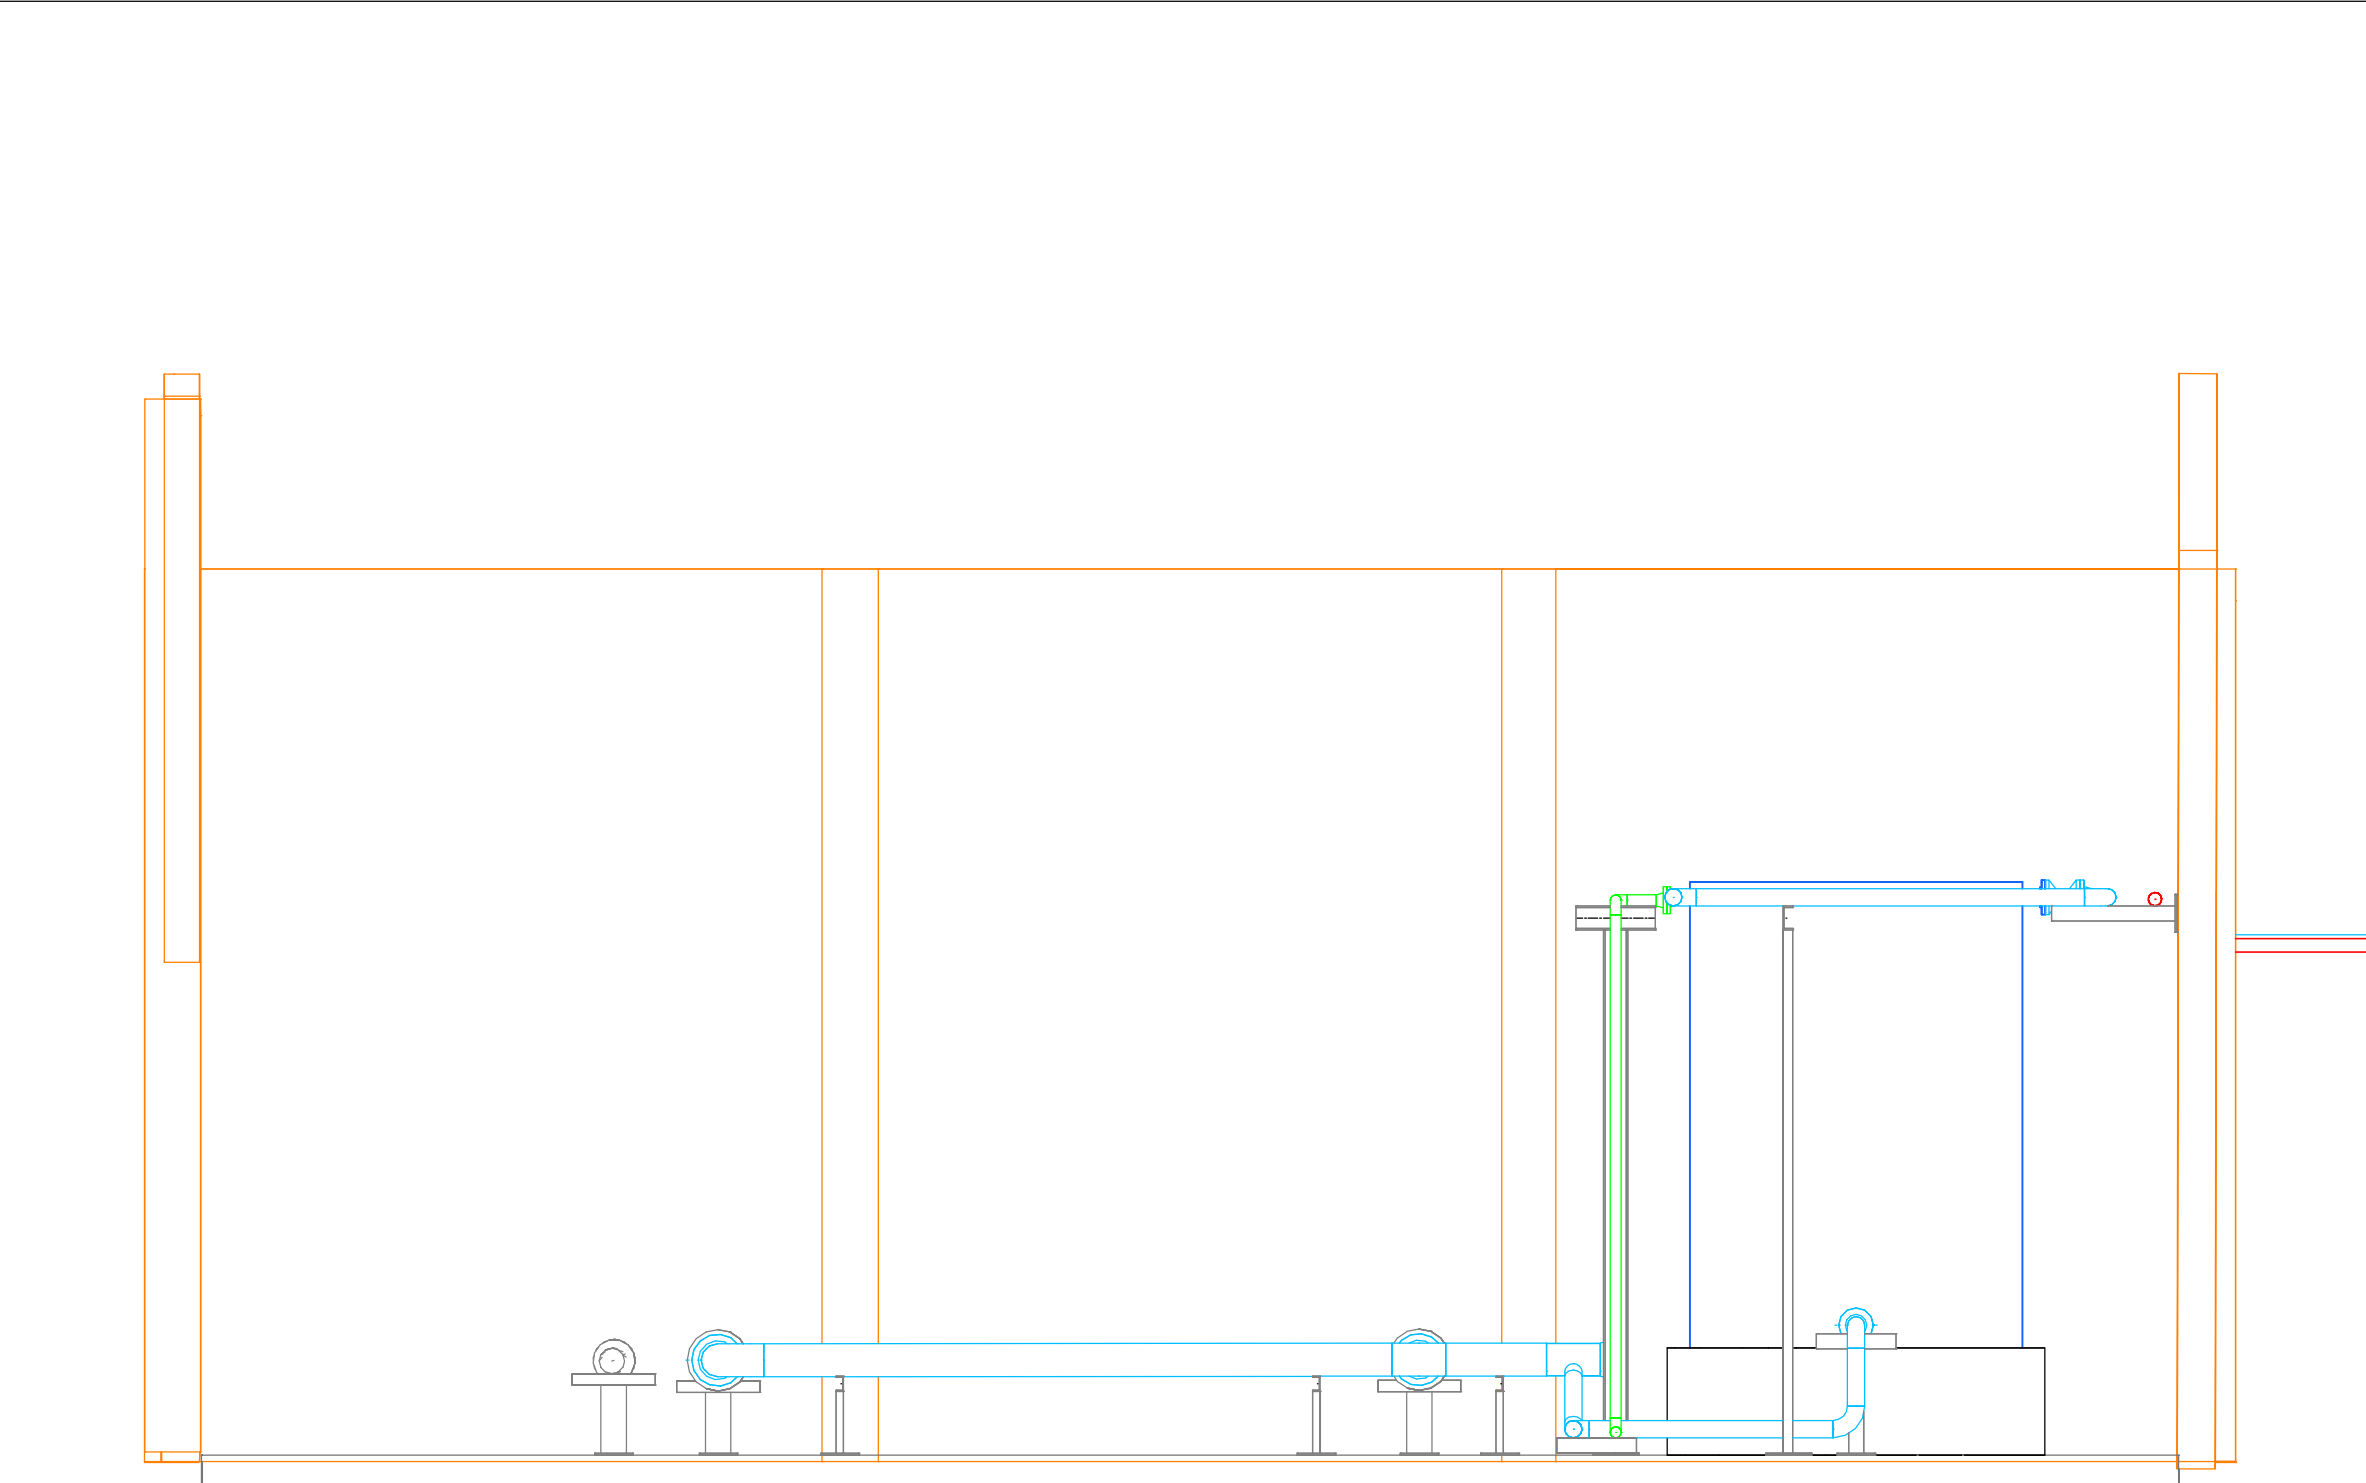


SECTION A-A
PLAN VIEW ON 16684-D01
SCALE 1:50

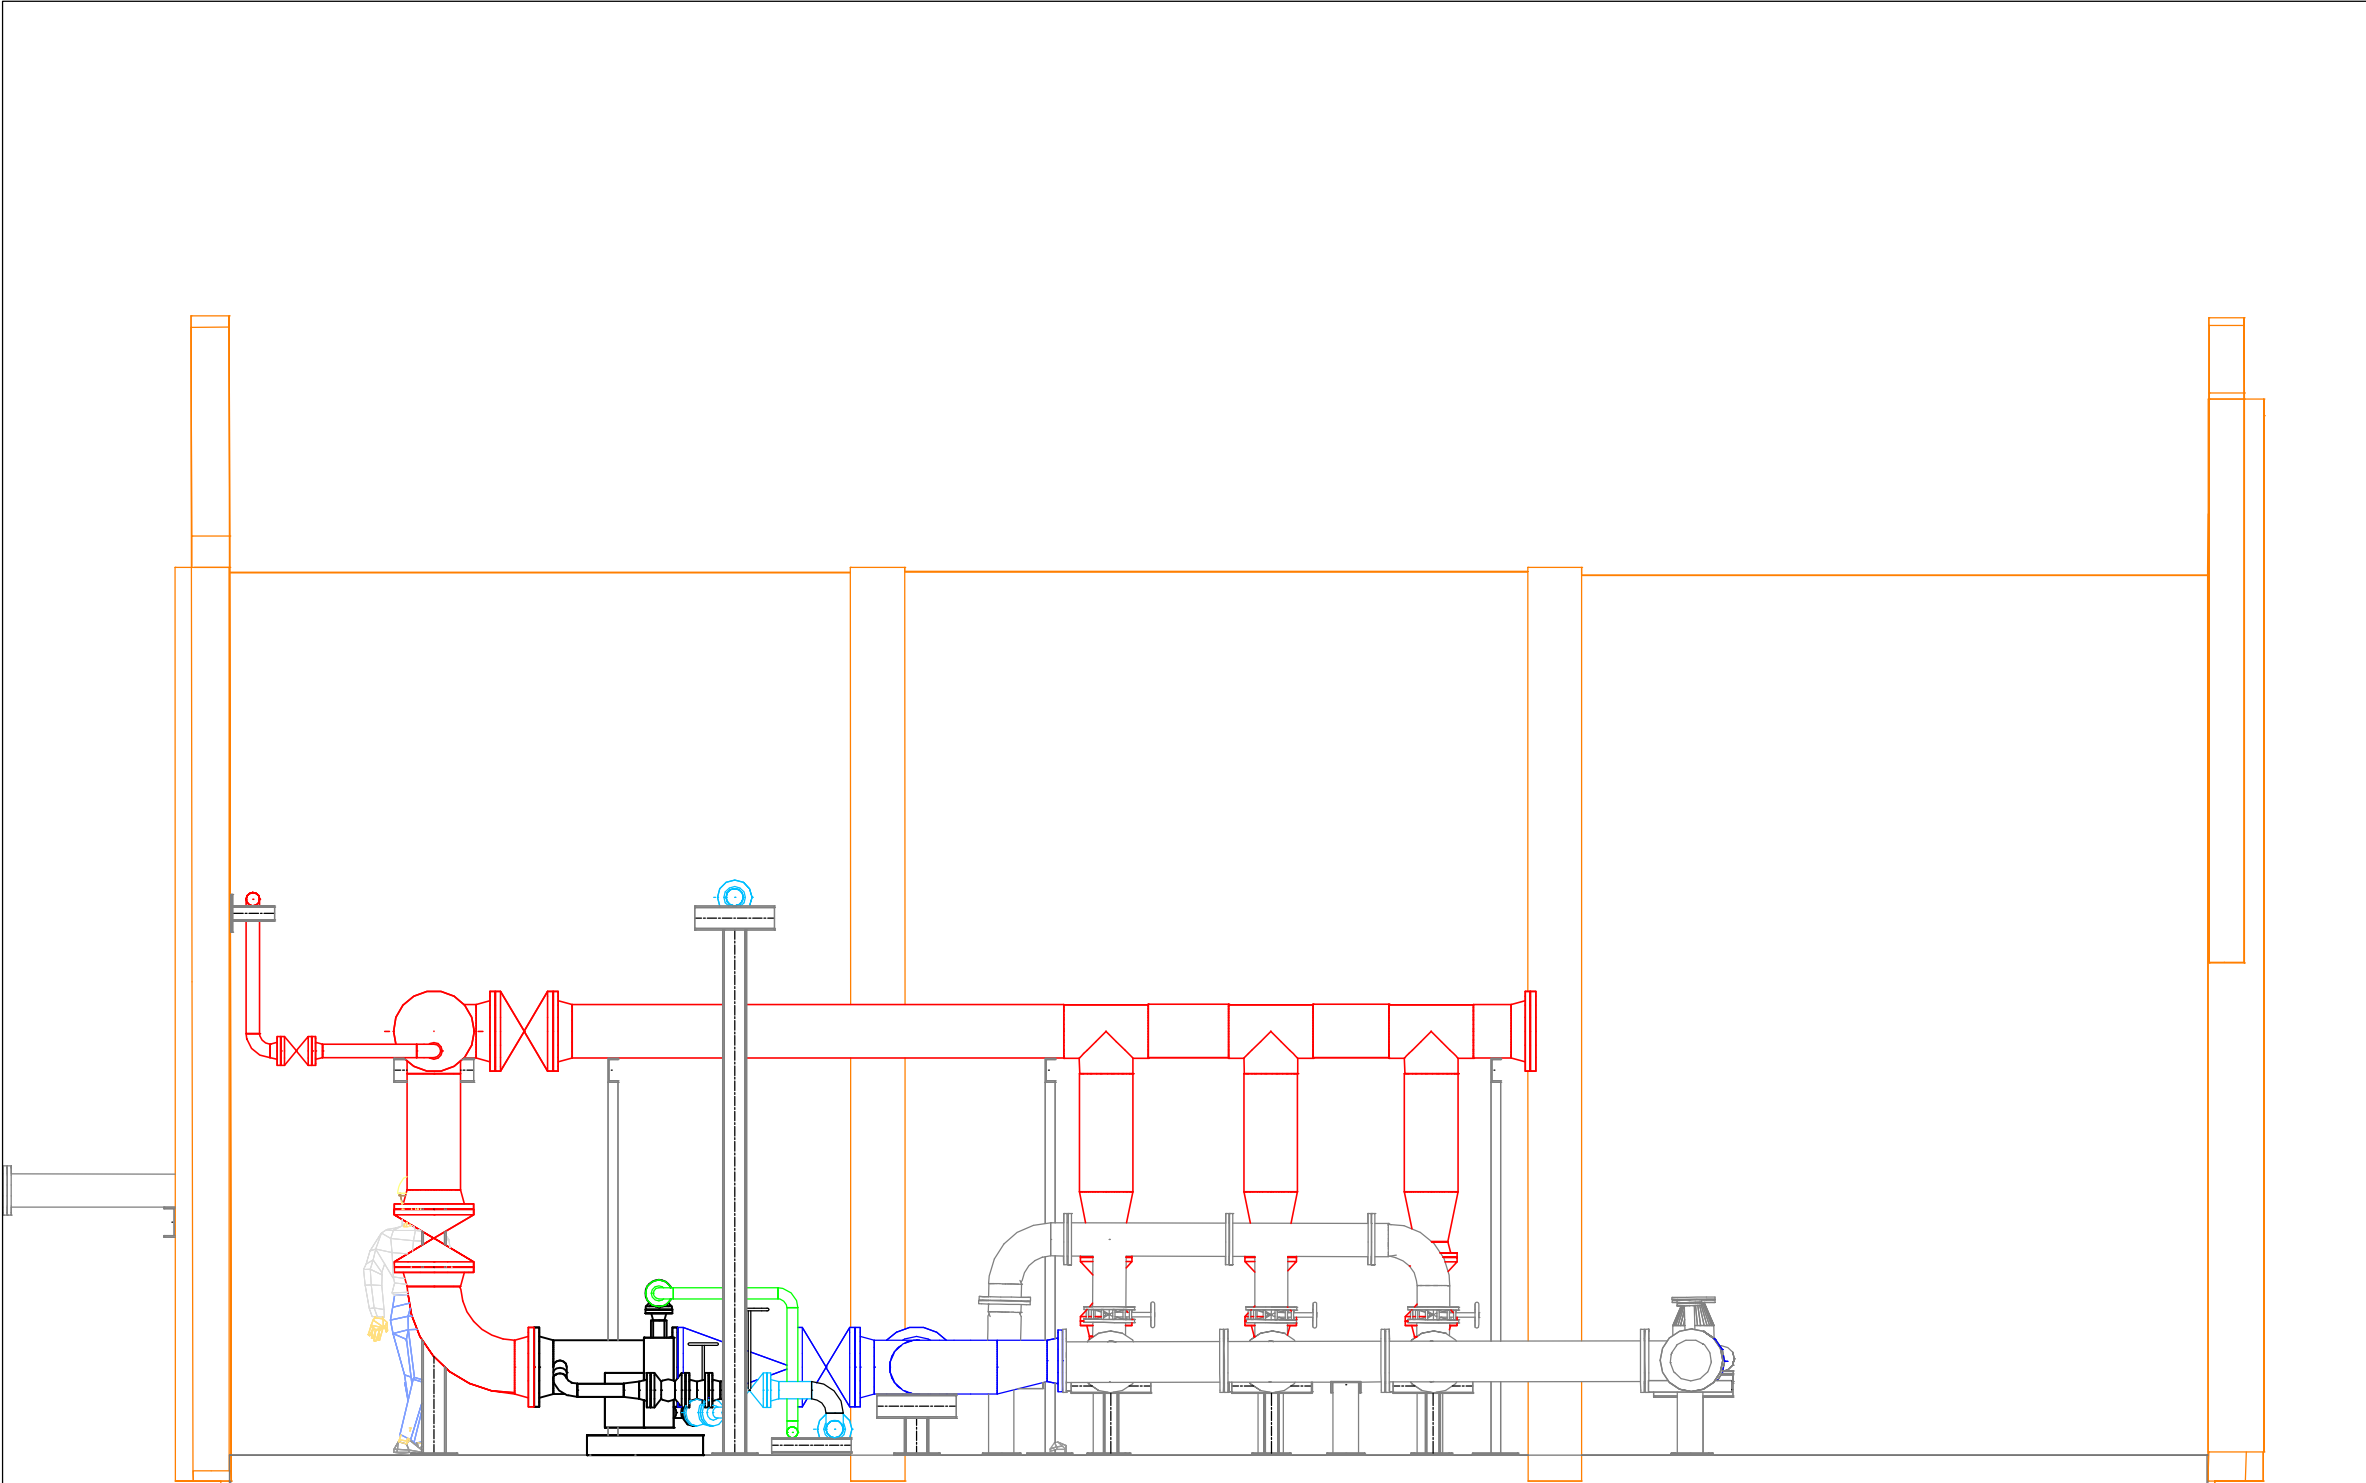

SECTION B-B
PLAN VIEW ON 16684-D01
SCALE 1:50

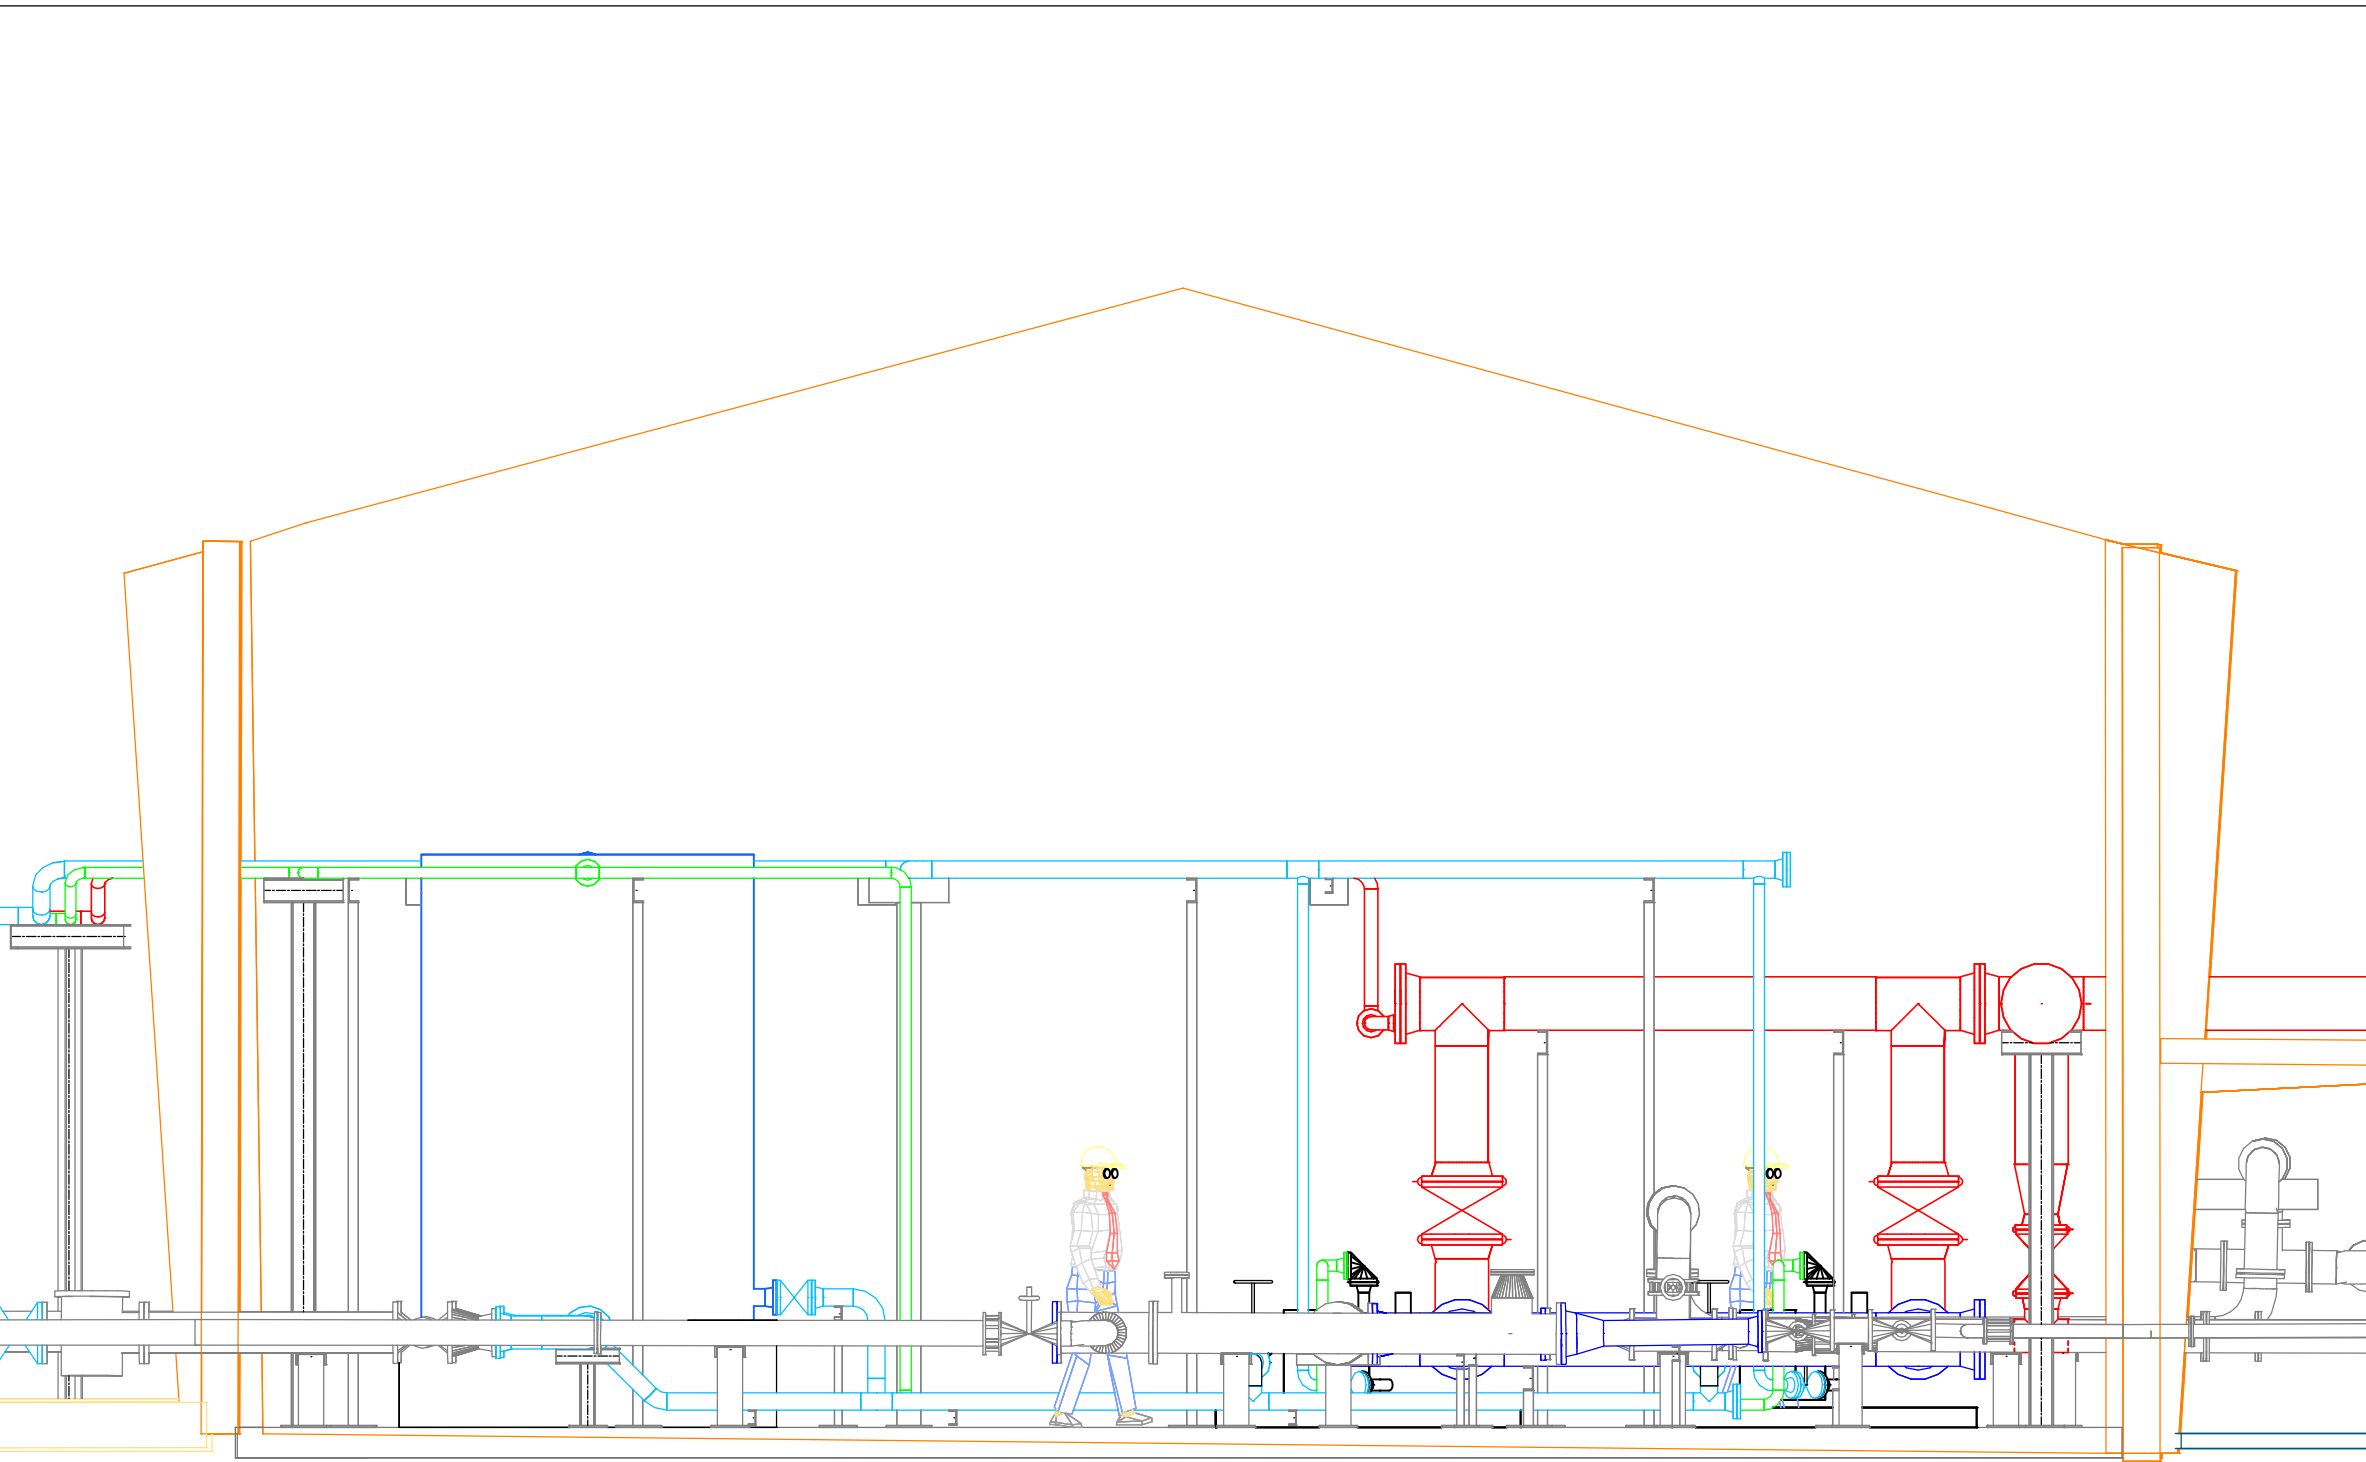

SECTION C-C
PLAN VIEW ON 16684-D01
SCALE 1:50

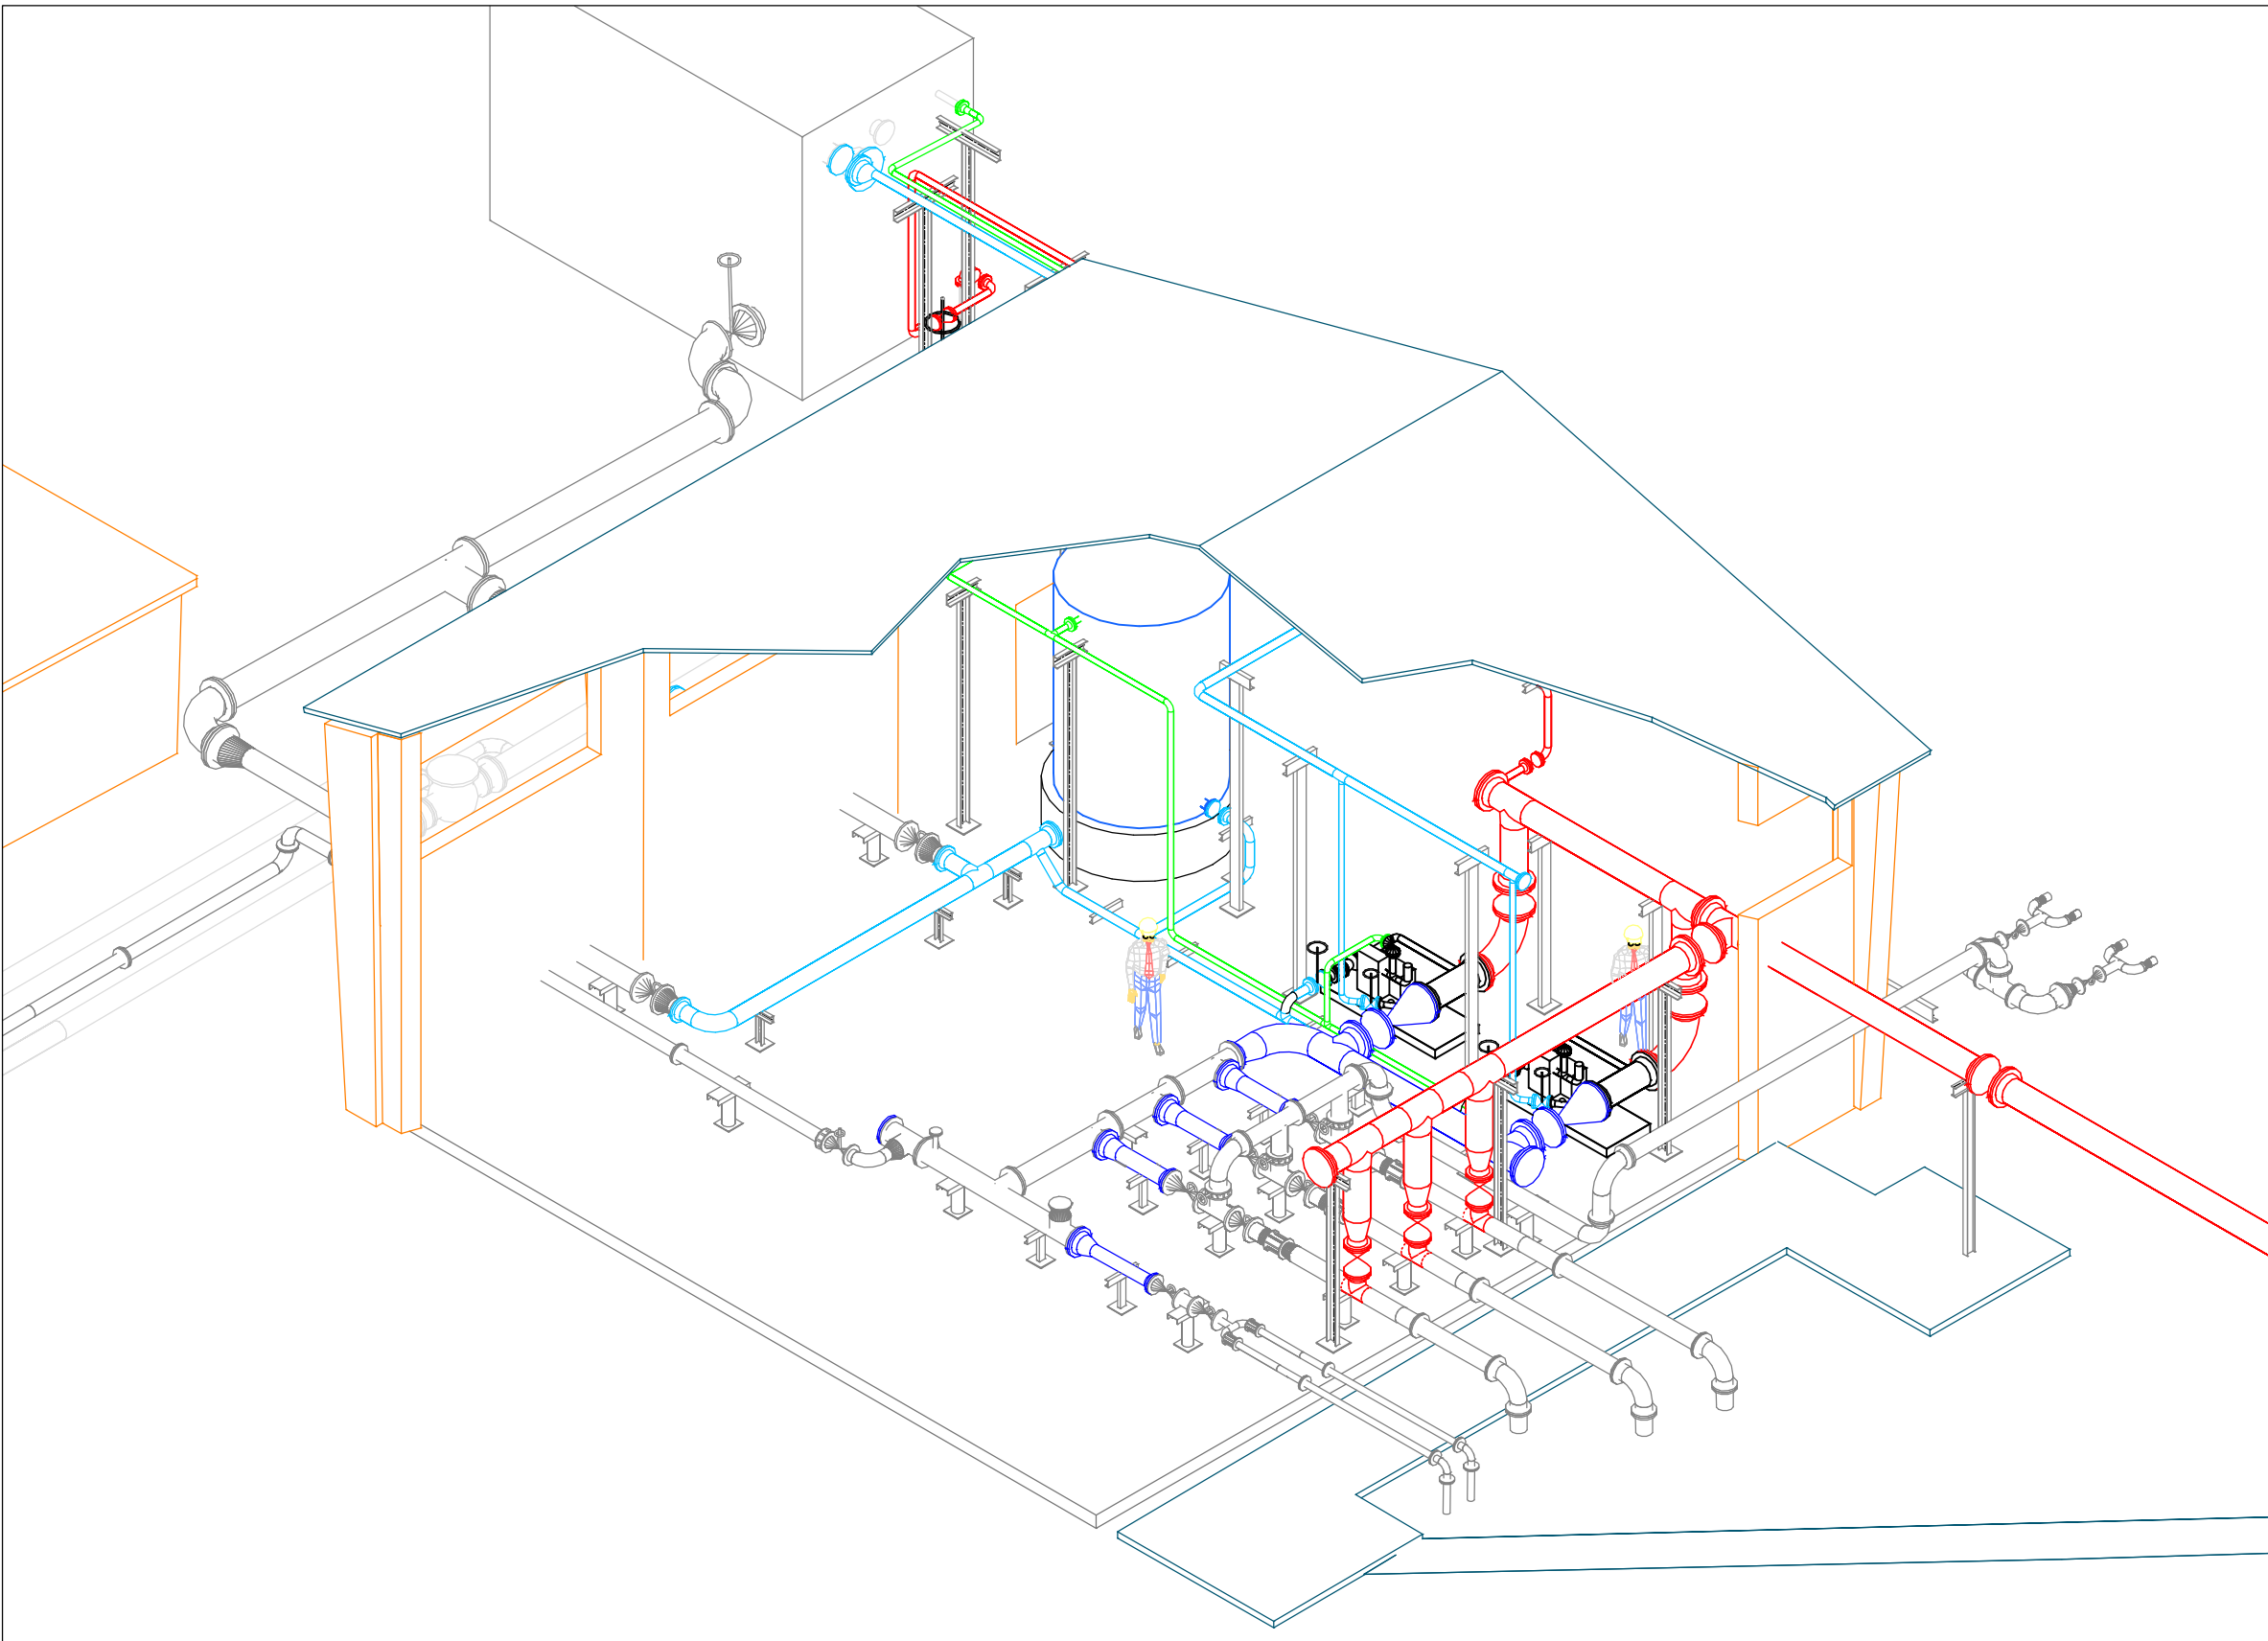

©COPYRIGHT
THIS DRAWING & DESIGN ARE CONFIDENTIAL &
THE PROPERTY OF KANTEY & TEMPLER & MAY
NOT BE DISCLOSED TO A THIRD PARTY,
COPIED/REPRODUCED IN WHOLE OR IN PART
WITHOUT THE WRITTEN PERMISSION OF
KANTEY & TEMPLER.

LEGEND:

- SEA WATER
- FOAM
- RELIEF LINE
- FOAM & WATER MIX

THIS IS A CAD DRAWING AND MUST
NOT BE ALTERED MANUALLY

K&T
KANTEY & TEMPLER
CONSULTING ENGINEERS
Engineering African Development
P O BOX 1621 WANDSBECK 3631 TEL 0312666535



DESIGNED: R.THOMSON DRAWN: G.FRASER DATE: 2013/01/15 DRAWING NO. 16684-D02

TRANSNET
national ports
authority

PROJECT: TNPA EL HARBOUR FIRE FIGHTING
SECTIONS & ISOMETRIC VIEW
OF FIRE FIGHTING PUMP
STATION

	B	2013/01/29	ISSUED FOR TENDER	G.FRASER	R.T	CODE: 16684	SCALE: AS SHOWN	STATE: DRAFT	
	A	2012/01/15	INFORMATION ONLY	G.FRASER	R.T	DRAWN: GF	DATE: 2012/01/15	SHEET NO. 1	
	REV	DATE	DESCRIPTION	DRAWN	CKD/APP	CHECKED: RT	DRAWING No. 16684-D03		REV B
REF.DWG NO.			DESCRIPTION	REF.DWG NO.		DESCRIPTION			

16684-D02-D

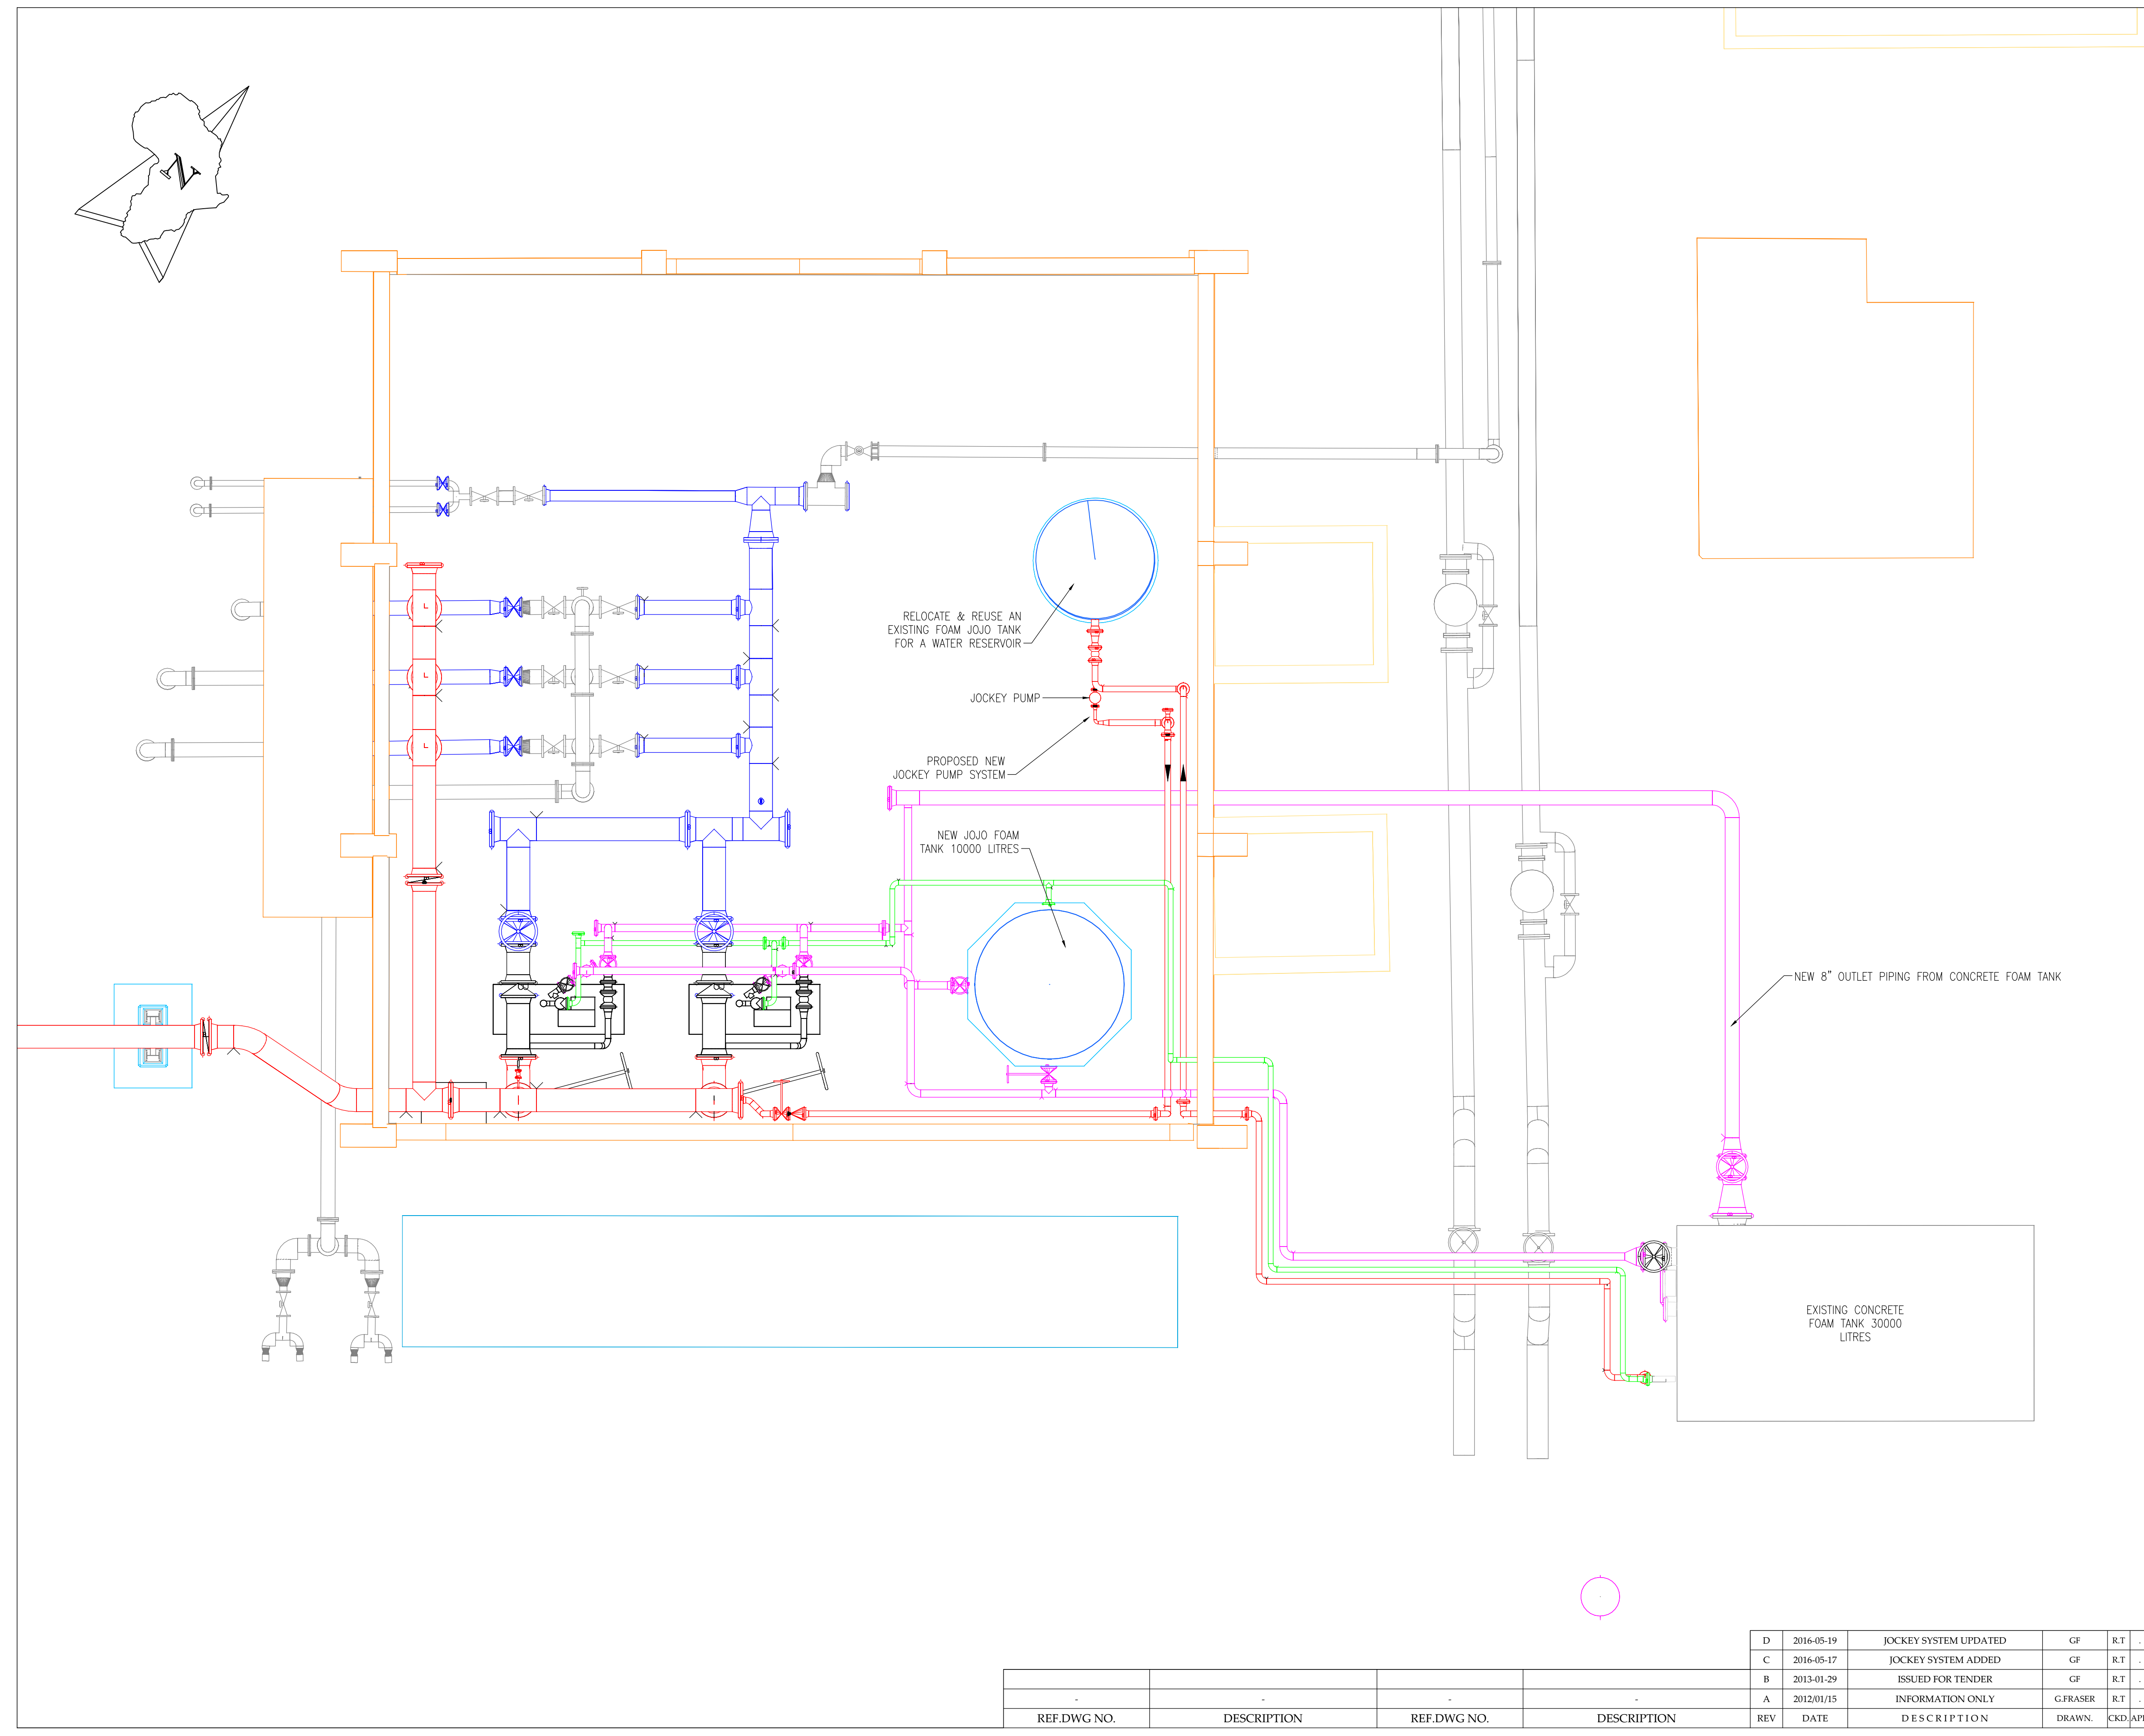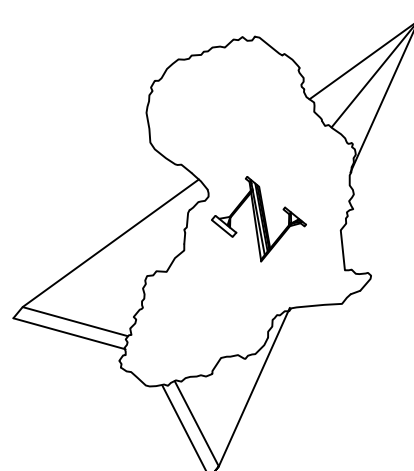

©COPYRIGHT
THIS DRAWING & DESIGN ARE CONFIDENTIAL &
THE PROPERTY OF KANTEY & TEMPLER & MAY
NOT BE DISCLOSED TO A THIRD PARTY,
COPIED/REPRODUCED IN WHOLE OR IN PART
WITHOUT THE WRITTEN PERMISSION OF
KANTEY & TEMPLER.

LEGEND:

- SEA WATER
- FOAM CONCENTRATE
- RELIEF LINE
- FOAM PREMIX

TNPA APPROVALS			
NAME	DESIGNATION	SIGN	DATE

THIS IS A CAD DRAWING AND MUST
NOT BE ALTERED MANUALLY

KANTEY & TEMPLER
CONSULTING ENGINEERS
Engineering African Development
P O BOX 1621 WANDSBECK 3631 TEL 0312666535

TRANSNET
national ports
authority

PROJECT: TNPA EL HARBOUR FIRE FIGHTING

GENERAL ARRANGEMENT OF
PROPOSED FIRE FIGHTING
PUMP HOUSE




D	2016-05-19	JOCKEY SYSTEM UPDATED	GF	R.T	CODE: 16684 DRAWN: GF CHECKED: RT APPR: -	SCALE: 1:50 DATE: 2012/01/15 SHEET NO. 1	STATE: DRAFT
C	2016-05-17	JOCKEY SYSTEM ADDED	GF	R.T			
B	2013-01-29	ISSUED FOR TENDER	GF	R.T			
A	2012/01/15	INFORMATION ONLY	G.FRASER	R.T			
REV	DATE	DESCRIPTION	DRAWN	CKD/APP	DRAWING No. 16684-D02		REV D

REF.DWG NO.	DESCRIPTION	REF.DWG NO.	DESCRIPTION

16684-PFD02-I

© COPYRIGHT
This drawing is the property of Kantey & Templer (Pty) Ltd and its assignees. It is supplied in confidence and must not be used for any purpose than that for which it is supplied. It must not be reproduced, copied or lent without permission in writing from the owners.

LEGEND:

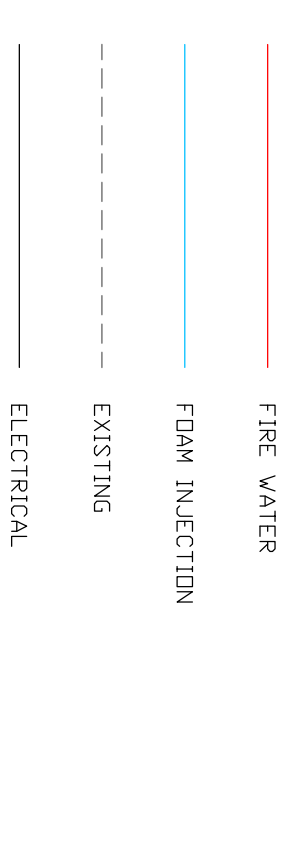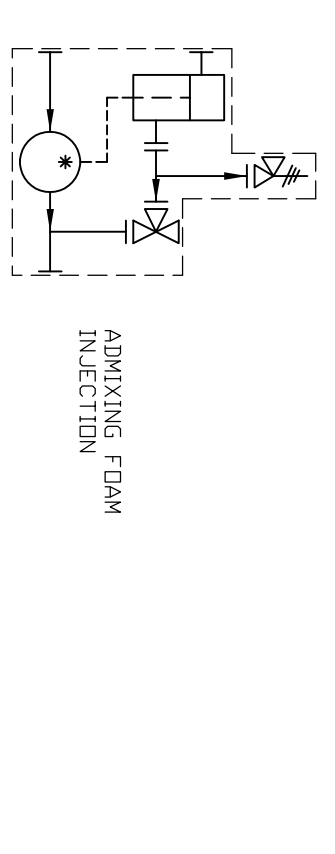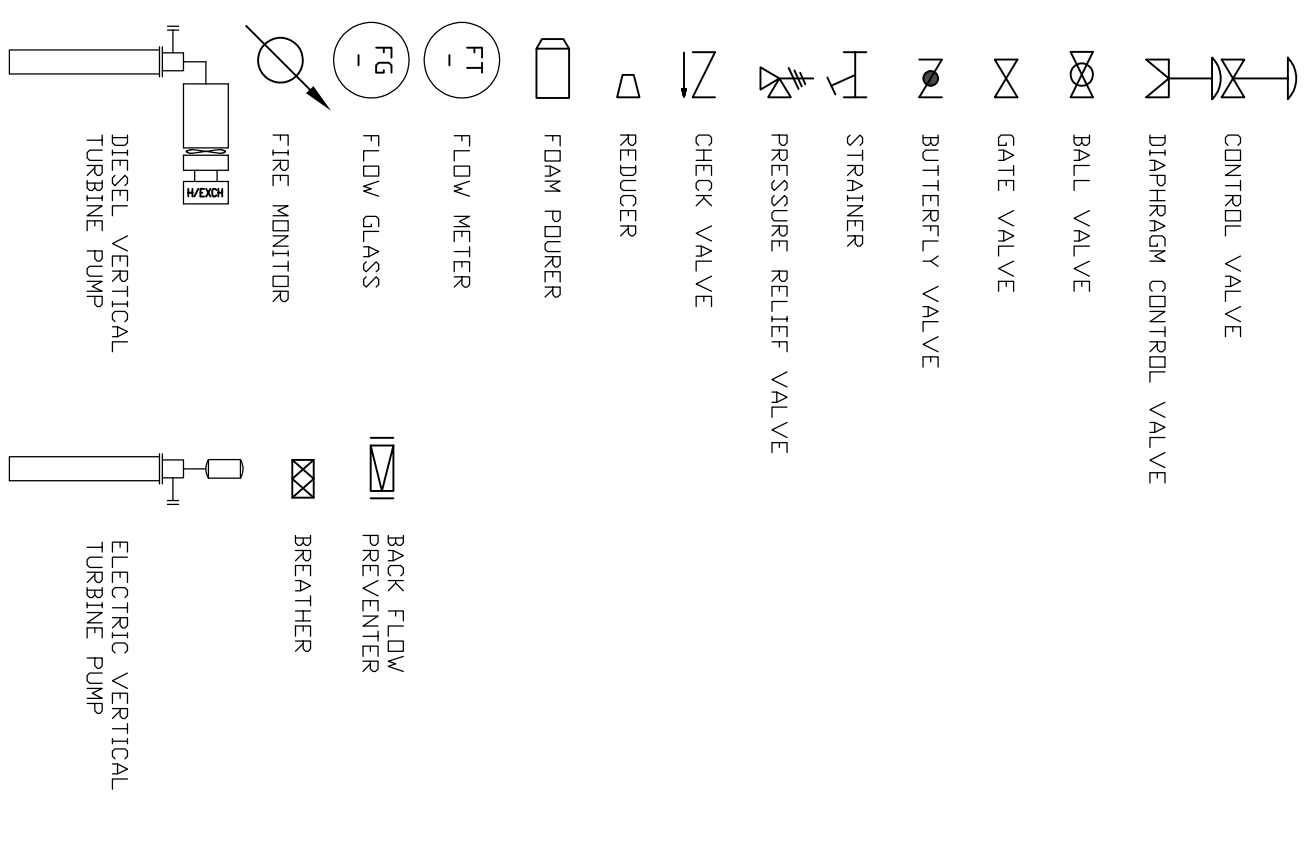

THIS IS A CAD DRAWING AND MUST NOT BE ALTERED MANUALLY

KANTEY & TEMPLER
CONSULTING ENGINEERS
Engineering African Development
P O BOX 1621 WANDSBECK 3631 TEL. 0312666535



TRANSNET
national ports
authority

PROJECT: TNPA EL HARBOUR FIRE FIGHTING

PROPOSED PROCESS
FLOW DIAGRAM

REV	DATE	DESCRIPTION	DRAWN	CHECKED	DATE	DESCRIPTION	REF.DWG. NO.	DESCRIPTION	REF.DWG. NO.
I	2017-03-13	AS BUILT	C.E.	R.T.					
H	2015-02-03	LIVEL INSTRUMENTATION ADDED	C.E.	R.T.					
G	2015-01-22	LINE NUMBERS ADDED	C.E.	R.T.					
F	2014-11-24	PMID UPDATED	C.E.	R.T.					

 Tanker berth monitor site plan

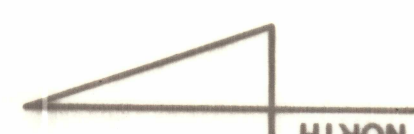

THIS DRAWING IS THE PROPERTY OF
PROTEKON WATER DESIGN SERVICES.
COPYRIGHT, PATENTS AND ALL INDUSTRIAL
PROPERTY RIGHTS RESERVED.

SITE PLAN EAST LONDON OIL TANKER BERTH PROPOSED FIRE FIGHTING SERVICES

SCALE 1: 200'

PORT OF EAST LONDON



FIRE PROTECTION PROPOSED SERVICES

FIDE FIGHTING