


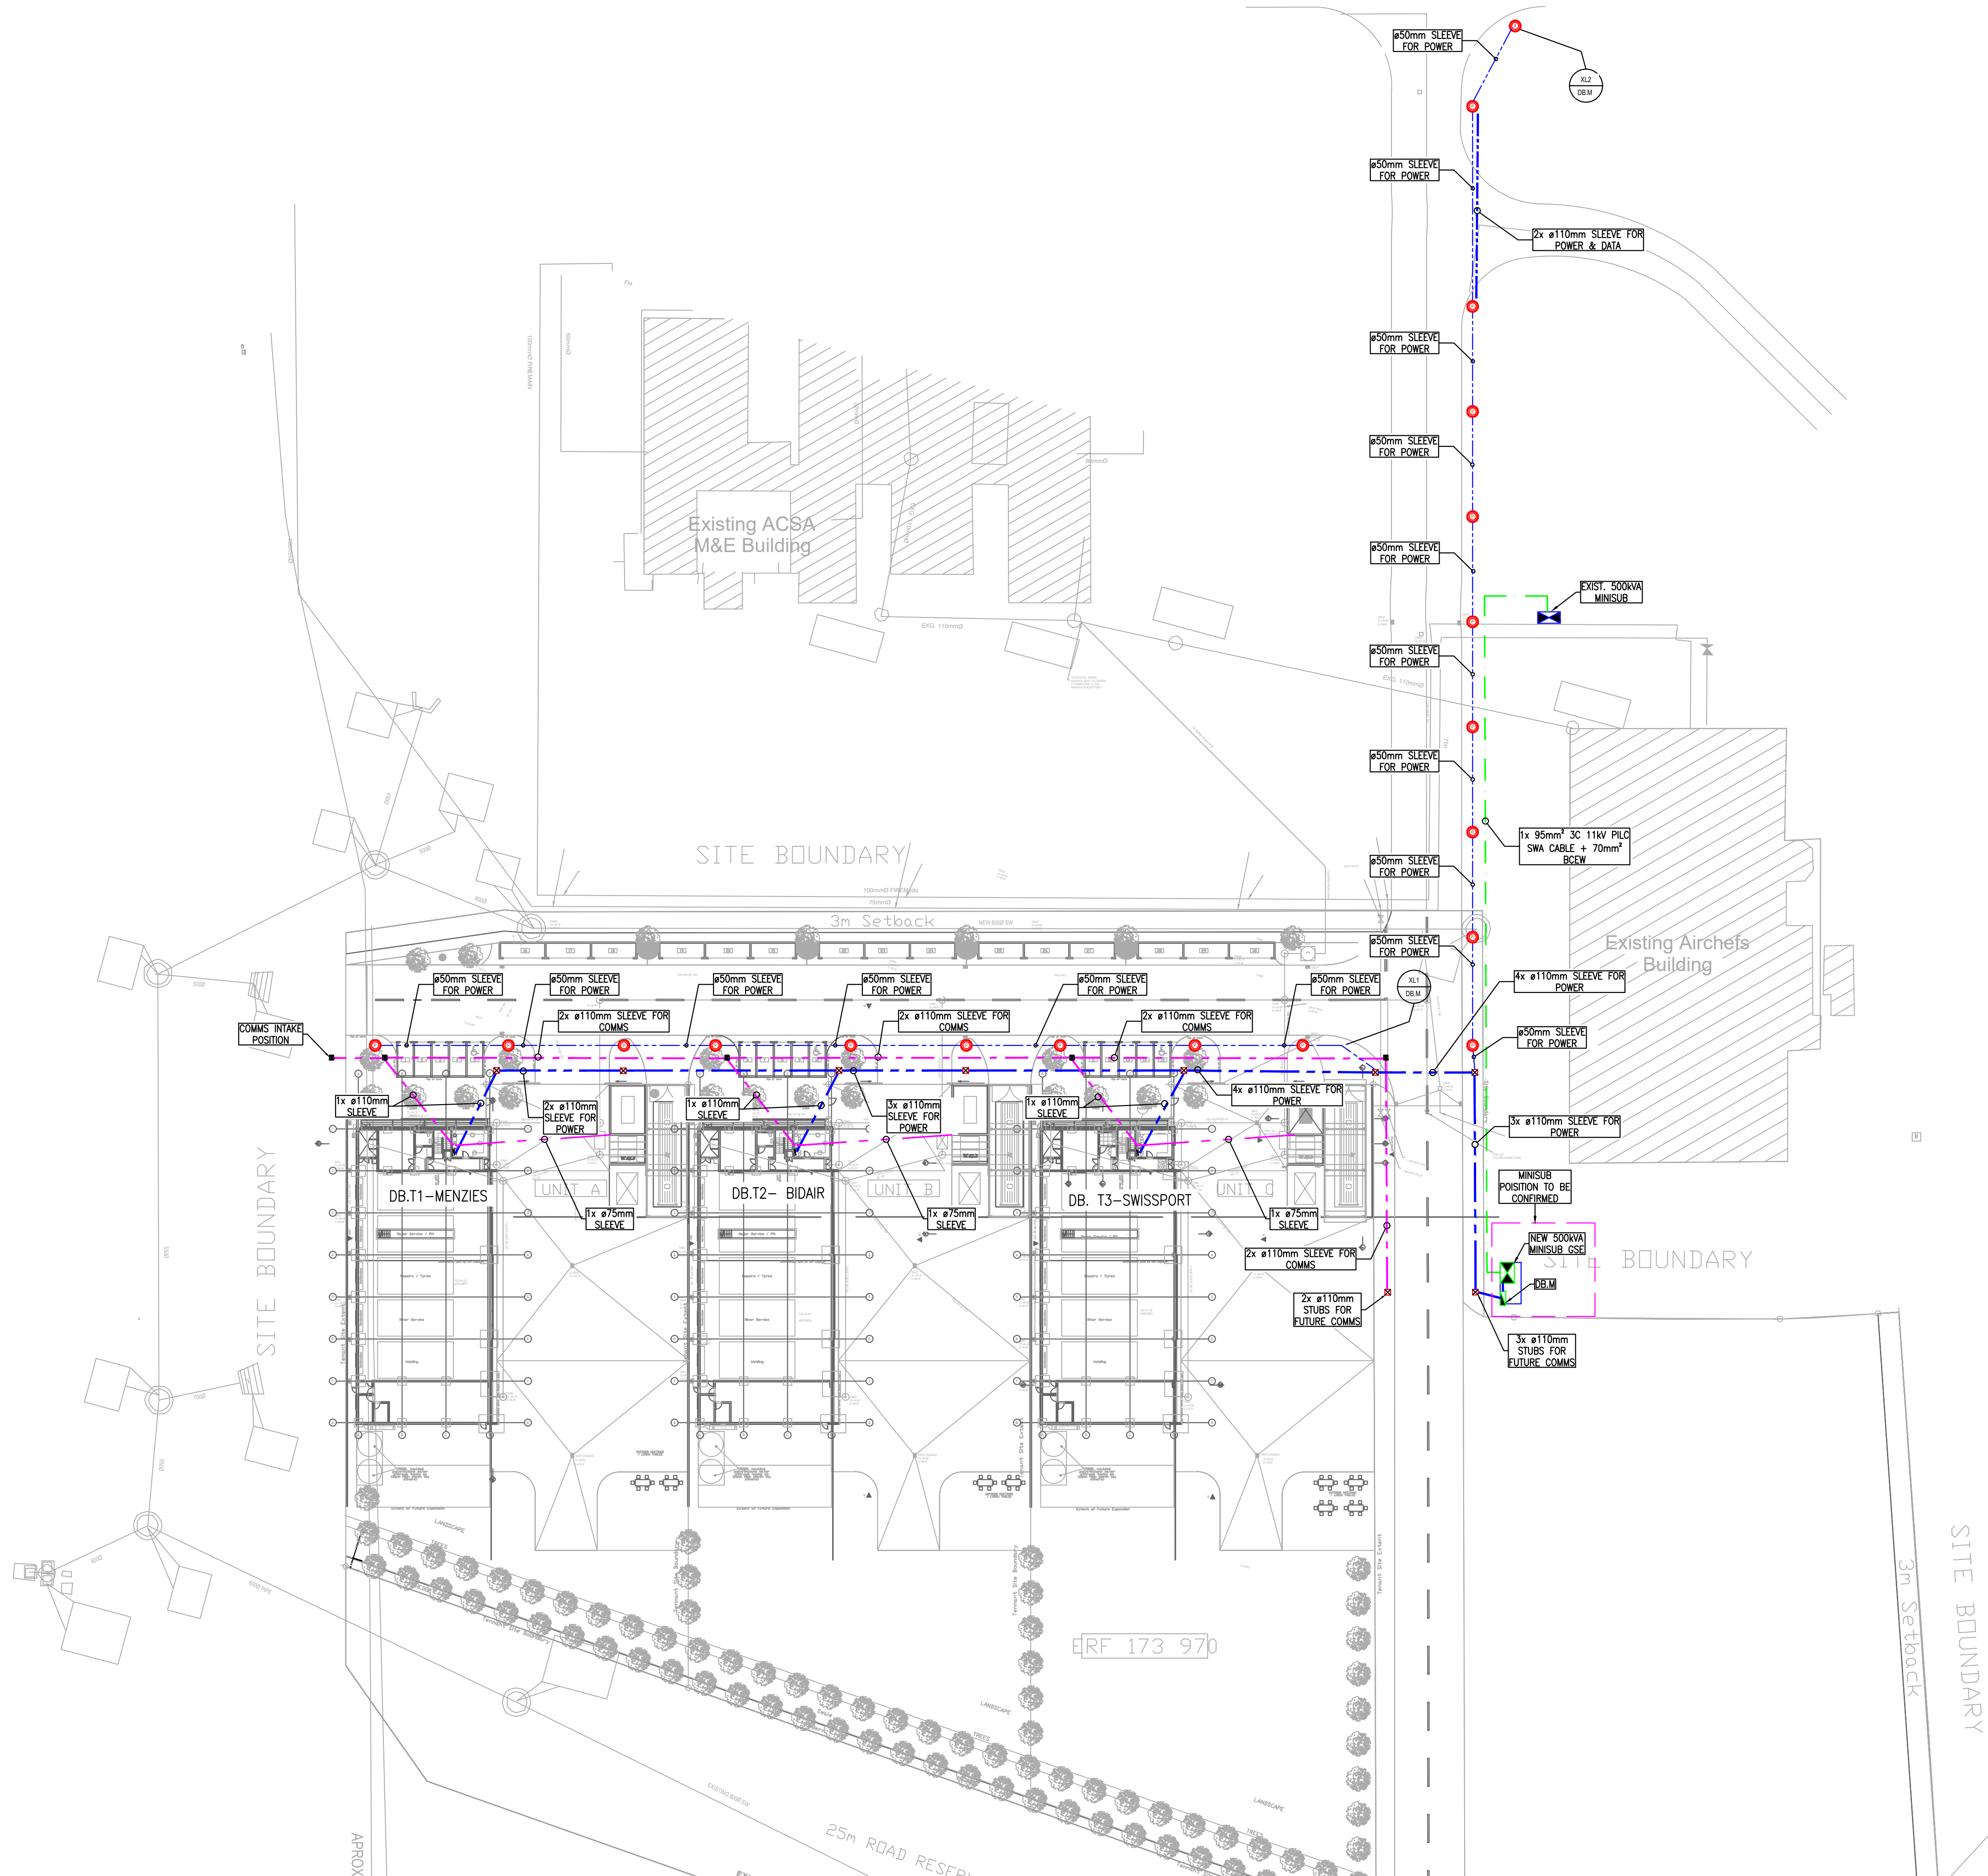

ELECTRICAL LEGEND

----- SLEEVES FOR POWER CABLING @ 600mm BFGL
(QUANTITY AND SIZE AS INDICATED ON DRAWING)

----- SLEEVES FOR COMMS CABLING @ 600mm BFGL
(QUANTITY AND SIZE AS INDICATED ON DRAWING)

----- ELECTRICAL CABLE @ 800mm BFGL

⬢ ELECTRICAL MINUSUB

⬢ MANHOLE TELKOM
(600mm x 600mm)

⬢ MANHOLE POWER
(800mm x 800mm)

⬢ POLE TOP LUMINAIRE

NOTES:

1. ALL SLEEVES TO BE A MINIMUM OF 600mm BFGL

REV	ISSUE FOR CONSTRUCTION	DATE
C0	ISSUE FOR CONSTRUCTION	06-02-2020
REV	REVISION DESCRIPTION	DATE

SUTHERLAND
Structural, Civil, Mechanical, Electrical and Facade Engineers

Cape Town Tyger Valley Johannesburg Durban Nairobi

PROJECT:
**ACSA - GSE
PROPOSED NEW WAREHOUSE**

CLIENT:
ACSA

DRAWING TITLE:
**CABLE RETICULATION
SITE PLAN**

SCALE: 1:500
DATE: AUGUST 2011
CHECKED: J. Edwards

DRAWN: M. Coetzee
PLOT SIZE: A1

DWG No:
2500-E-CR-001

REVISION
C0

NOTE:
THESE DRAWINGS ARE TO BE READ IN CONJUNCTION WITH ALL THE RELEVANT CONSULTANTS' DRAWINGS. ALL DIMENSIONS ARE TO BE READ AND NOT SCALED. ANY DISCREPANCIES ARE TO BE REPORTED TO THE PRINCIPAL AGENT IMMEDIATELY. THESE DRAWINGS ENJOY COPYRIGHT WHICH RESTS IN SUTHERLAND ASSOCIATES UNLESS OTHERWISE AGREED IN WRITING. THESE DRAWINGS MAY NOT BE REPRODUCED OR TRANSMITTED IN ANY FORM OR BY ANY MEANS WHATSOEVER TO ANY PERSON WITHOUT THE WRITTEN PERMISSION OF THE COPYRIGHT HOLDER.