


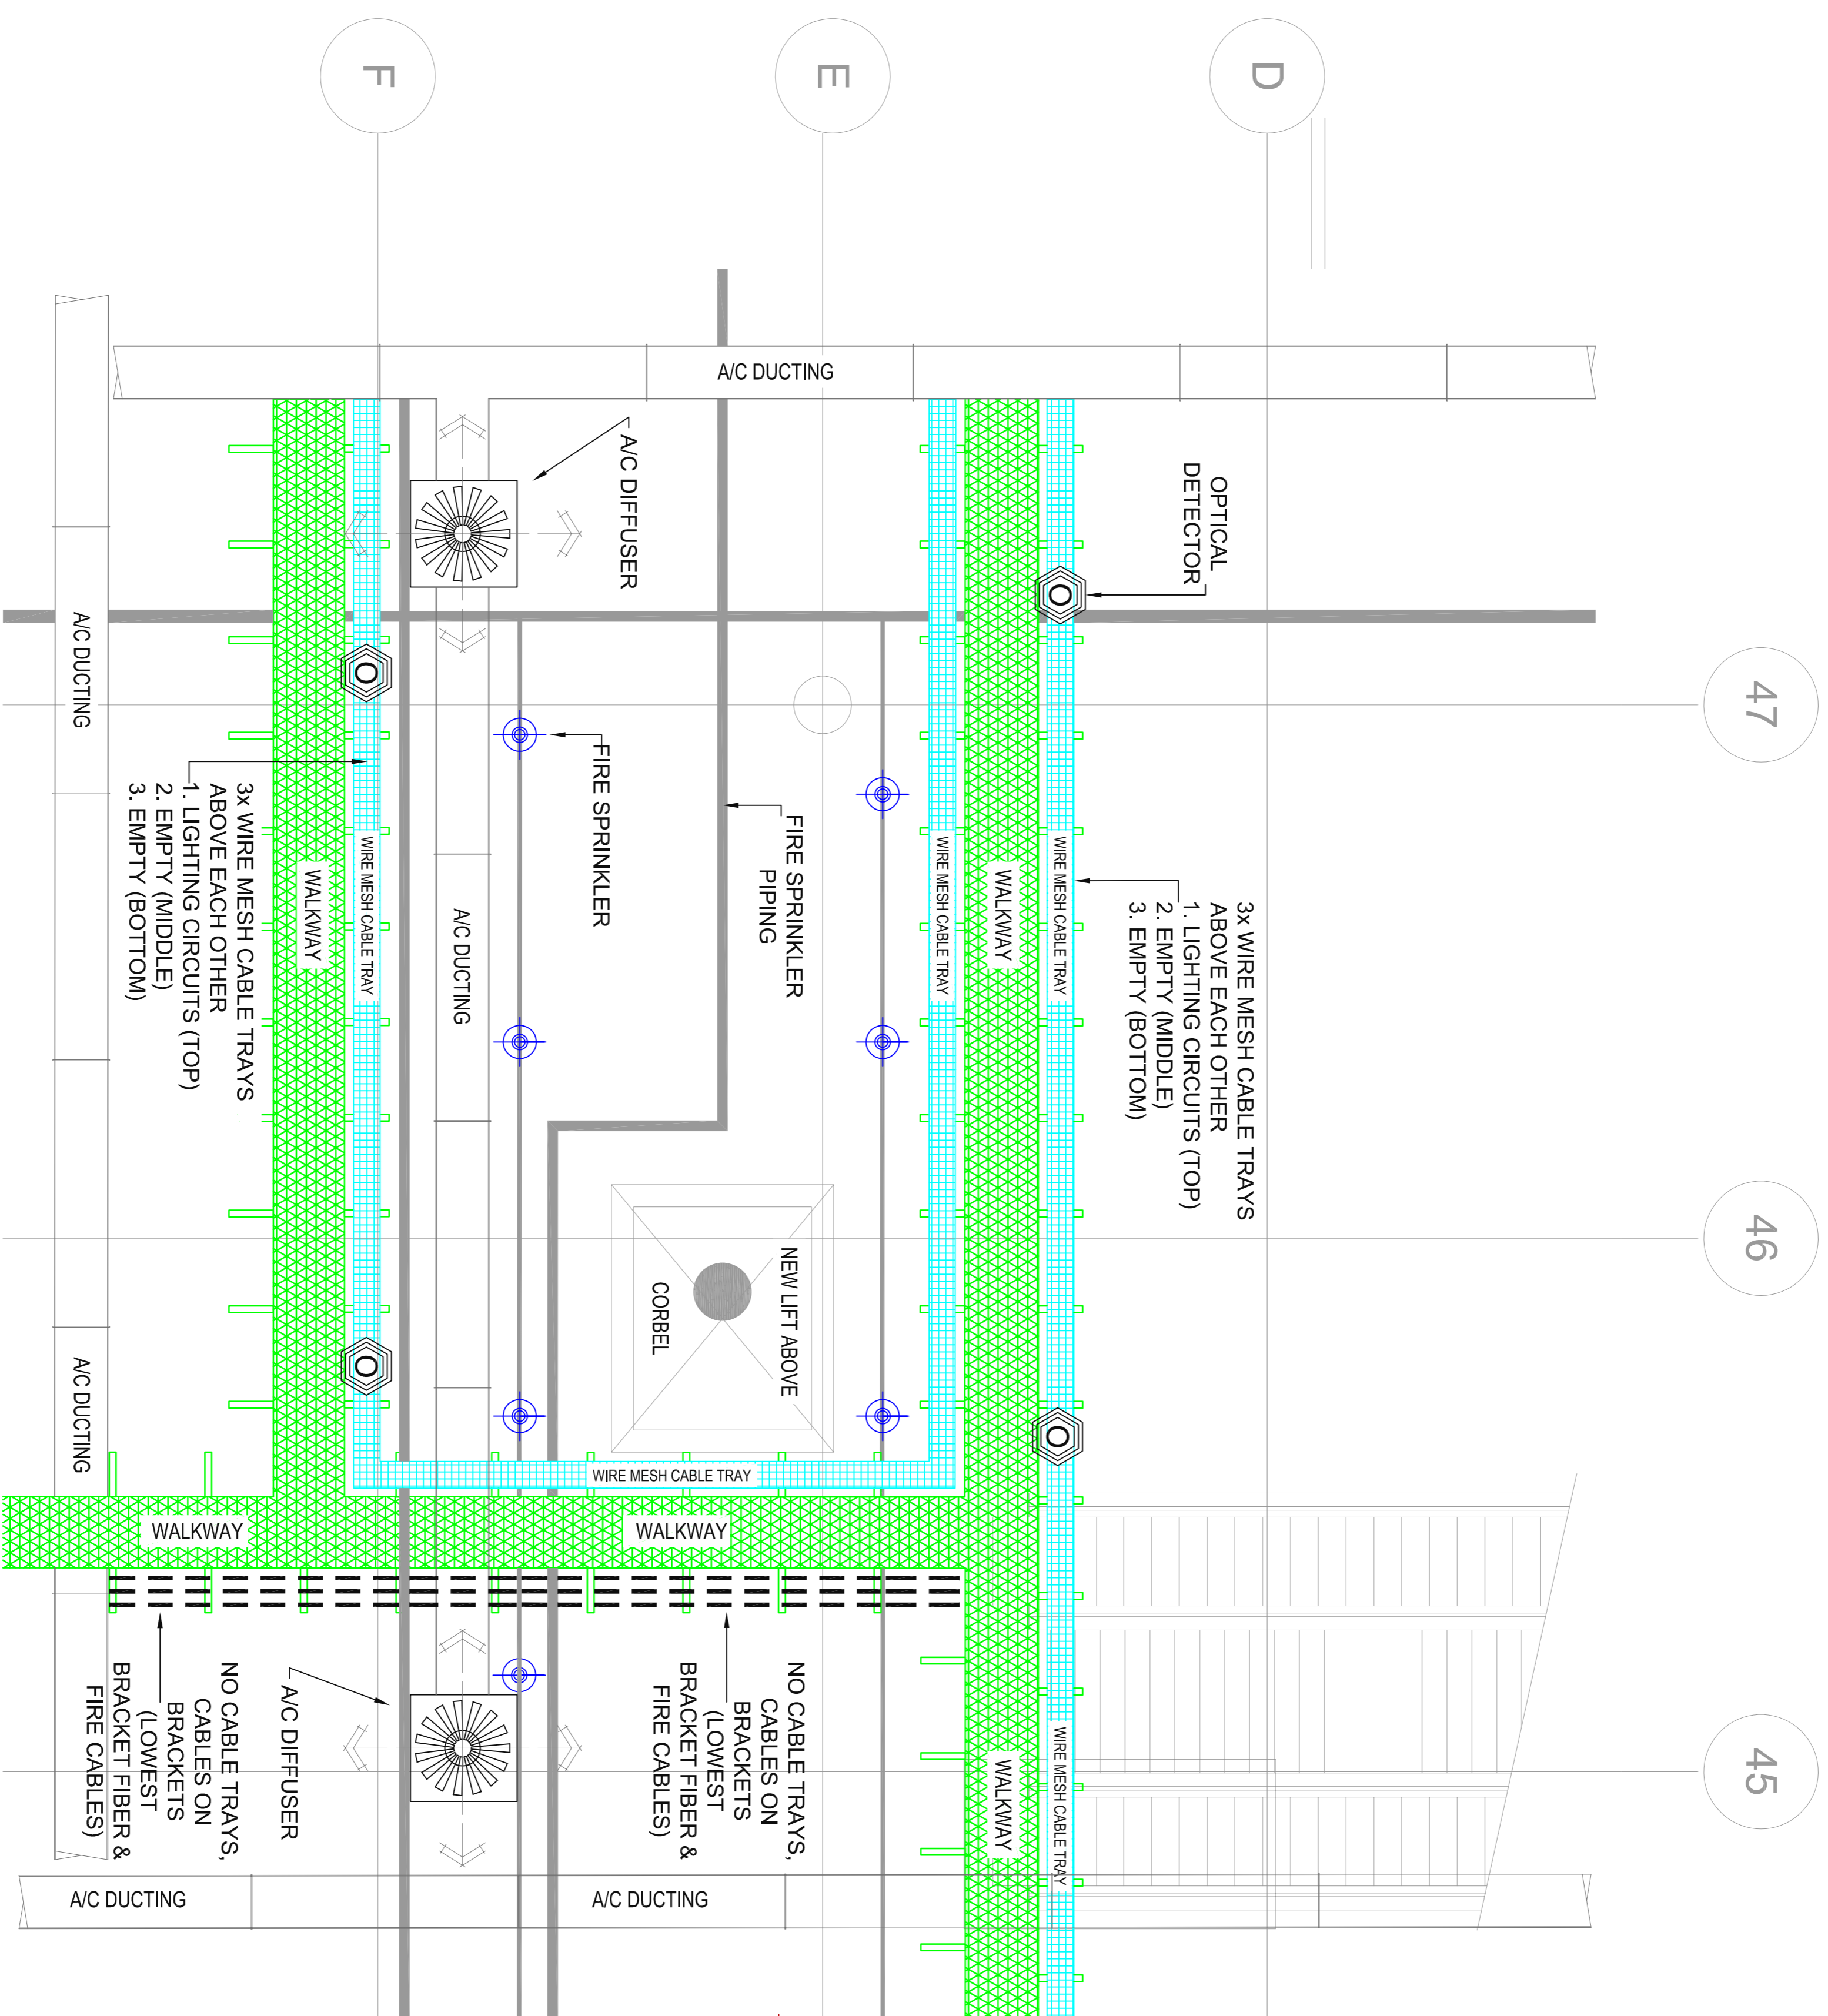



HVAC LEGEND		
	SYMBOL	FITTING DESCRIPTION
		X
FIRE PROTECTION LEGEND		
	SYMBOL	FITTING DESCRIPTION
		X
FIRE DETECTION LEGEND		
	SYMBOL	FITTING DESCRIPTION
		X



This drawing is copyright and remains the property of Moon Poly Ltd.		
AS	09/10/2018	AS RESULT
NO. DATE	REVISIONS	
PROJECT NO: 0916 DRAWINGS NO: 6-04 - Rev-01/09/02/2018		

The logo for NAKO TRIOCON features a stylized red 'N' composed of two curved segments. Below the 'N', the word 'NAKO' is written in a large, bold, black sans-serif font, and 'TRIOCON' is written below it in a smaller, all-caps, black sans-serif font.

Two Exhibitors, 11 Different Companies
Offering the Most Comprehensive Line of
Cementitious Aggregate Products
Email: info@triocon.co.za
Tel: +27(0)21-585-0449
Fax: +27(0)21-585-0448
www.triocon.co.za

PROJECT _____
I.D.T. _____
NEW CENTRAL LOUNGE _____
CLIENT _____
ACSA - CTIA _____
DRAWING SERVICE _____
ELEC. / ELECTRO. / MECH. _____

DESCRIPTION
NEW LIFT SHAFT
SERVICES LAYOUT

DESIGNED— M.PIKKER	DATE OCTOBER 2018
CHECKED— M.PIKKER	DRAWN— SCALE
	M.TAUTE 1:50(A1)

DRAWING No. C2891S/C01/LS01

REV No. AS

AS BUILT