
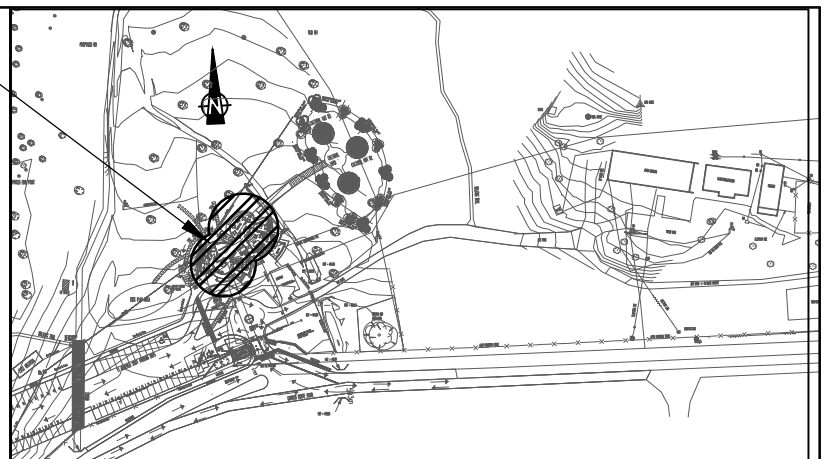


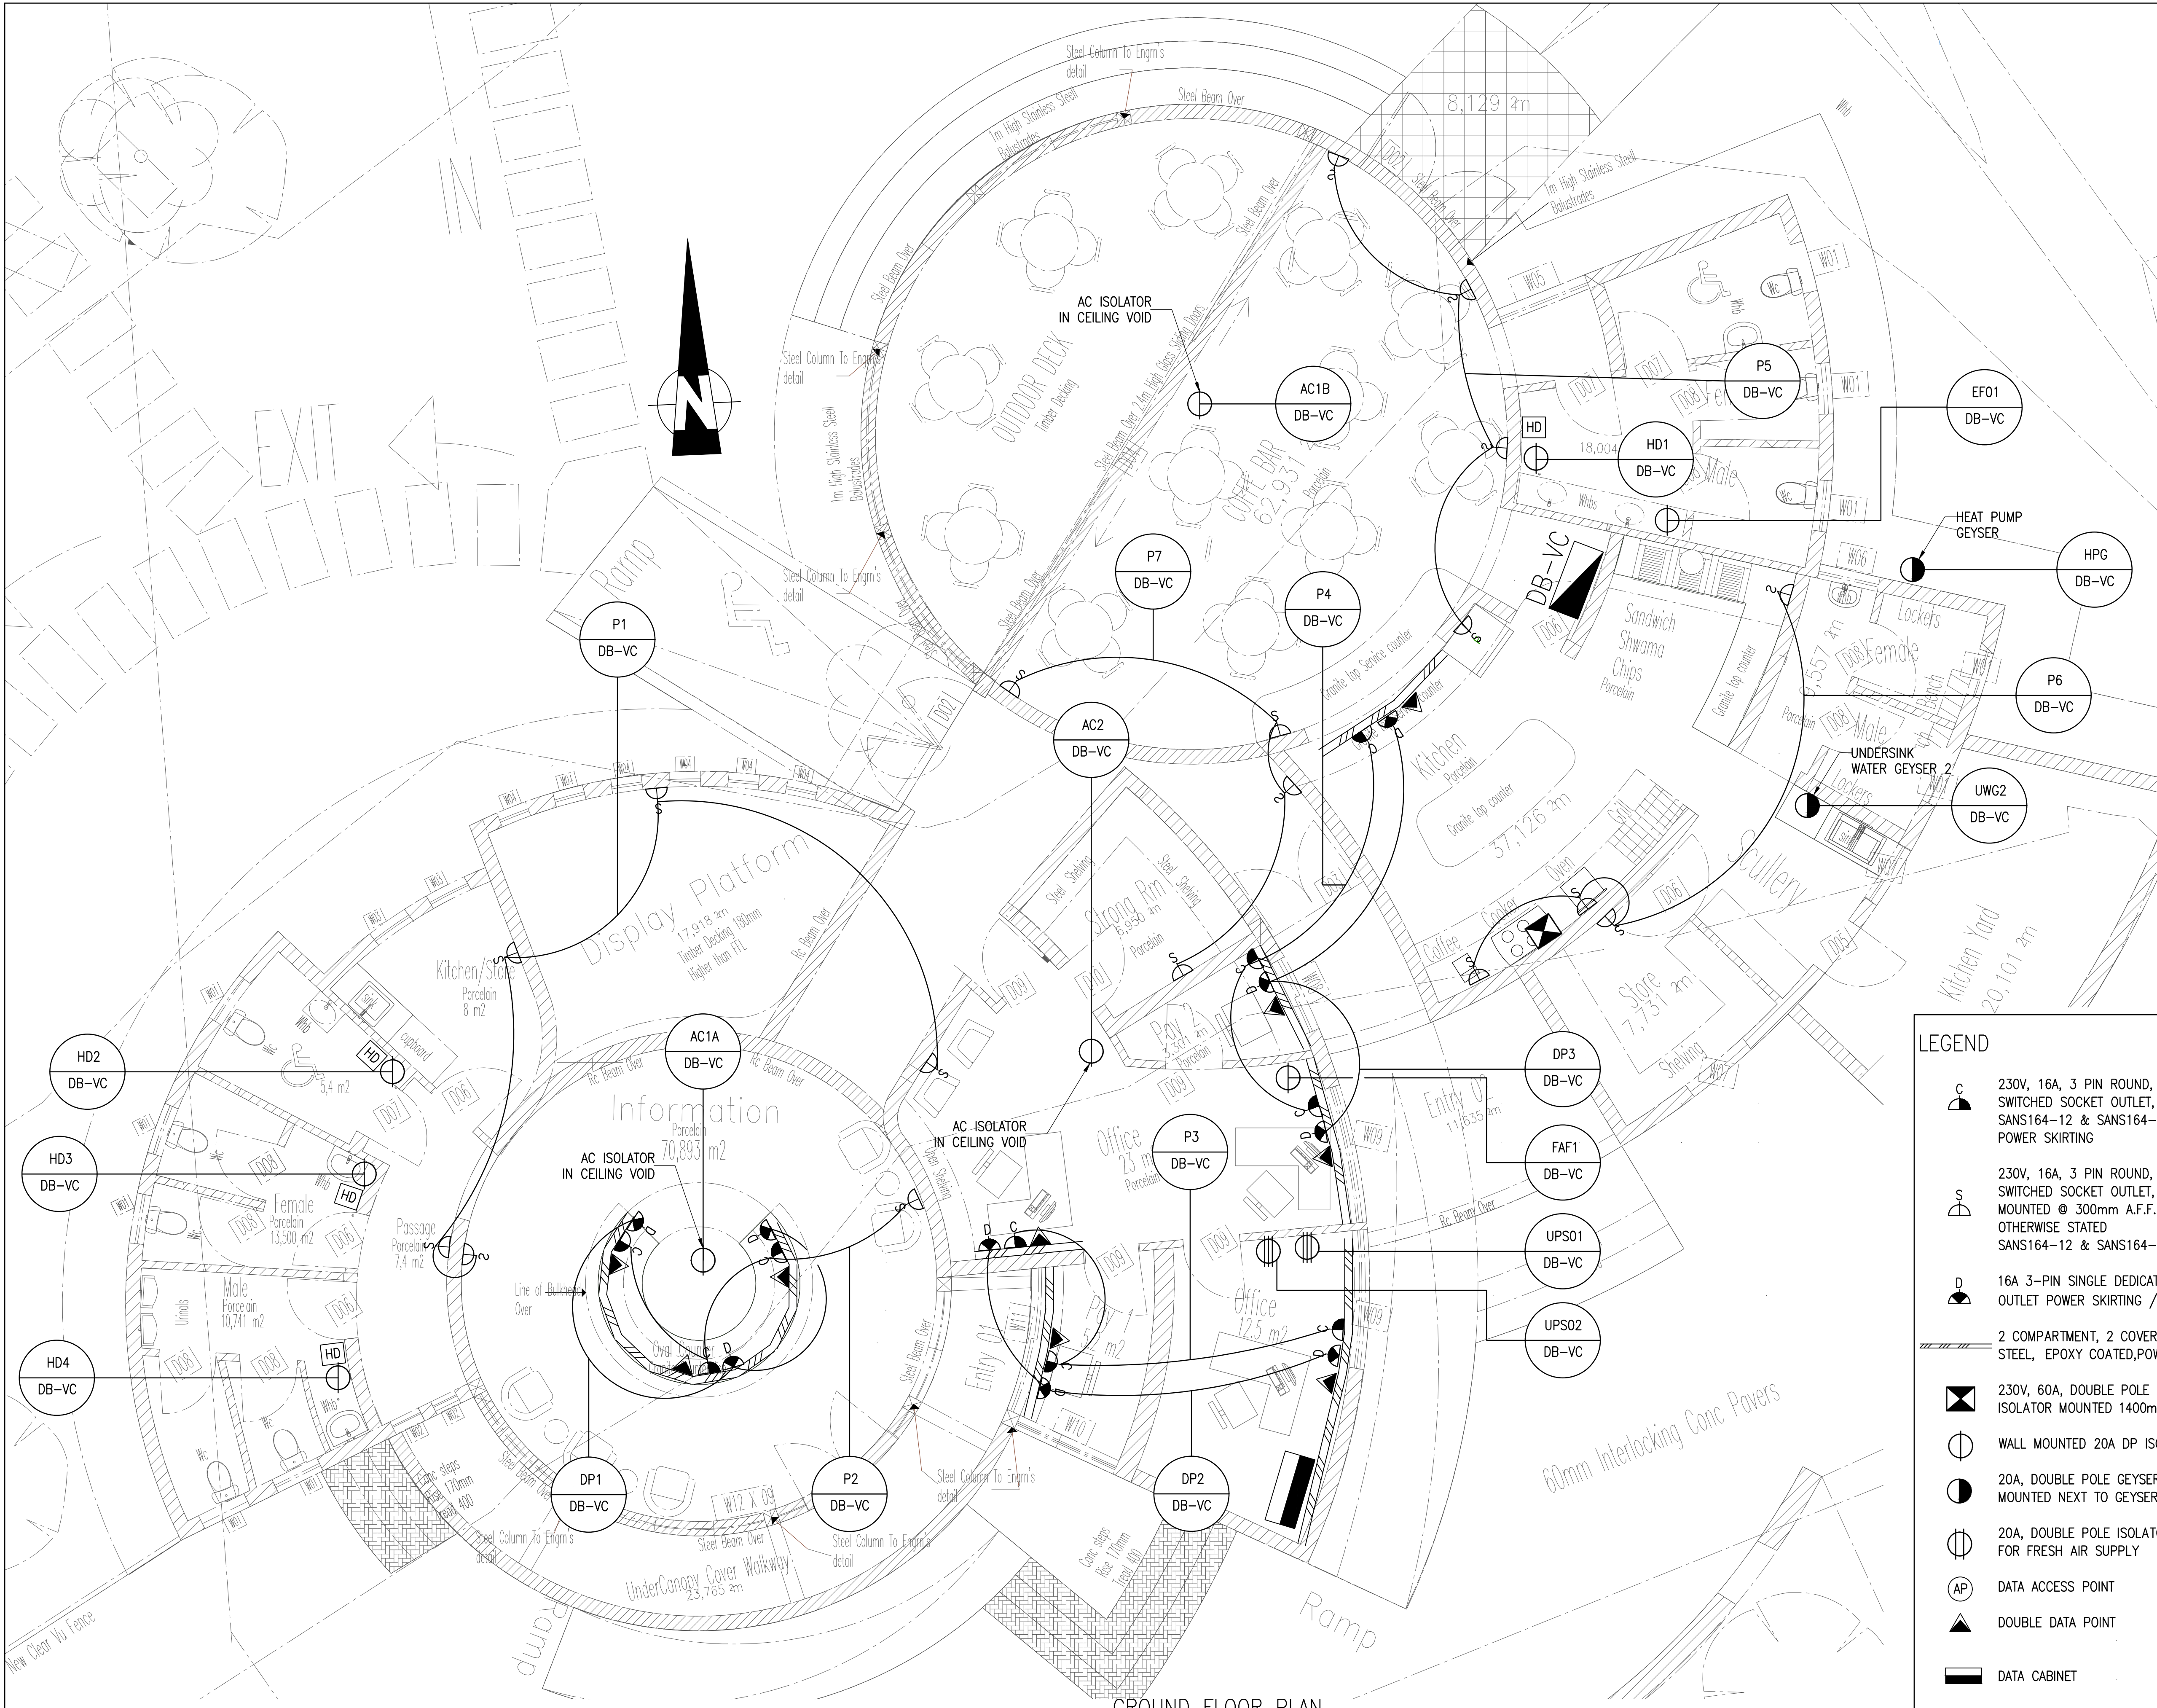

SITE PLAN
N.T.S

CLIENT
SOUTH AFRICAN NATIONAL BIODIVERSITY INSTITUTE

SANBI
Biodiversity for Life
South African National Biodiversity Institute

TD	2022-09-26	ISSUED FOR TENDER
A	2022-09-13	ISSUED FOR APPROVAL
REV NO.	DATE	DESCRIPTION

REVISIONS

PROJECT CONSULTANT
PROJECTNEERS CONSULTING ENGINEERS & PROJECT MANAGERS

PROJECTNEERS
PROJECTNEERS CONSULTING ENGINEERS
& PROJECT MANAGERS
BUILDING 2, 1ST FLOOR, THORNHILL OFFICE PARK
94 BEKKER ROAD, MIDRAND, 1685
+27 11 043 1307
technical@projectneers.com
www.projectneers.com

DRAWING CHECKS			
DRAWN BY	CHECKED BY	DATE	APPROVED BY
F.MPOFU			B.MDLULI F.MPOFU

APPROVAL CONSULTANT			
N.K. MPOFU			

DATE	FILE NO.	THE MASTER FILE OF THE PROJECTNEERS CONSULTING ENGINEERS & PROJECT MANAGERS IS THE ORIGINAL SOURCE OF ALL INFORMATION.
31-08-2022	20130388	

PROJECT NAME
ASSESSMENT, DESIGN & PROJECT MANAGEMENT OF REQUIRED NEW BUILDINGS & REPAIRS, RENOVATIONS & UPGRADES TO VARIOUS INFRASTRUCTURE ASSETS IN THE THOHOYANDOU BOTANICAL GARDEN, THOHOYANDOU, & NATIONAL ZOOLOGICAL GARDEN CAMPUSES BASED IN PRETORIA & MOKOPANE

SITE
THOHOYANDOU BOTANICAL GARDENS

SHEET TITLE
VISITORS CENTRE
POWER LAYOUT
DISCIPLINE
ELECTRICAL


CONTRACT NUMBER
G3062018

FILE NUMBER
ZA2018_2008


DRAWING NUMBER
PJN_ZA_2022_2002_SANBI_TBG_EE_6000_TD

ISSUED FOR TENDER

THIS DRAWING

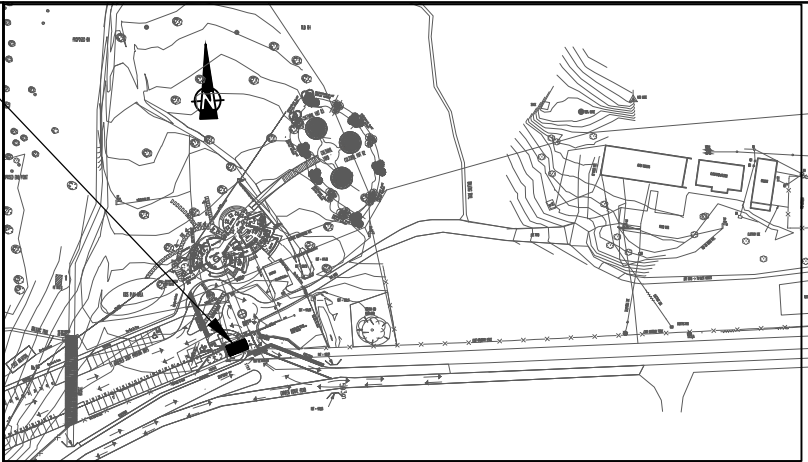

SITE PLAN
N.T.S

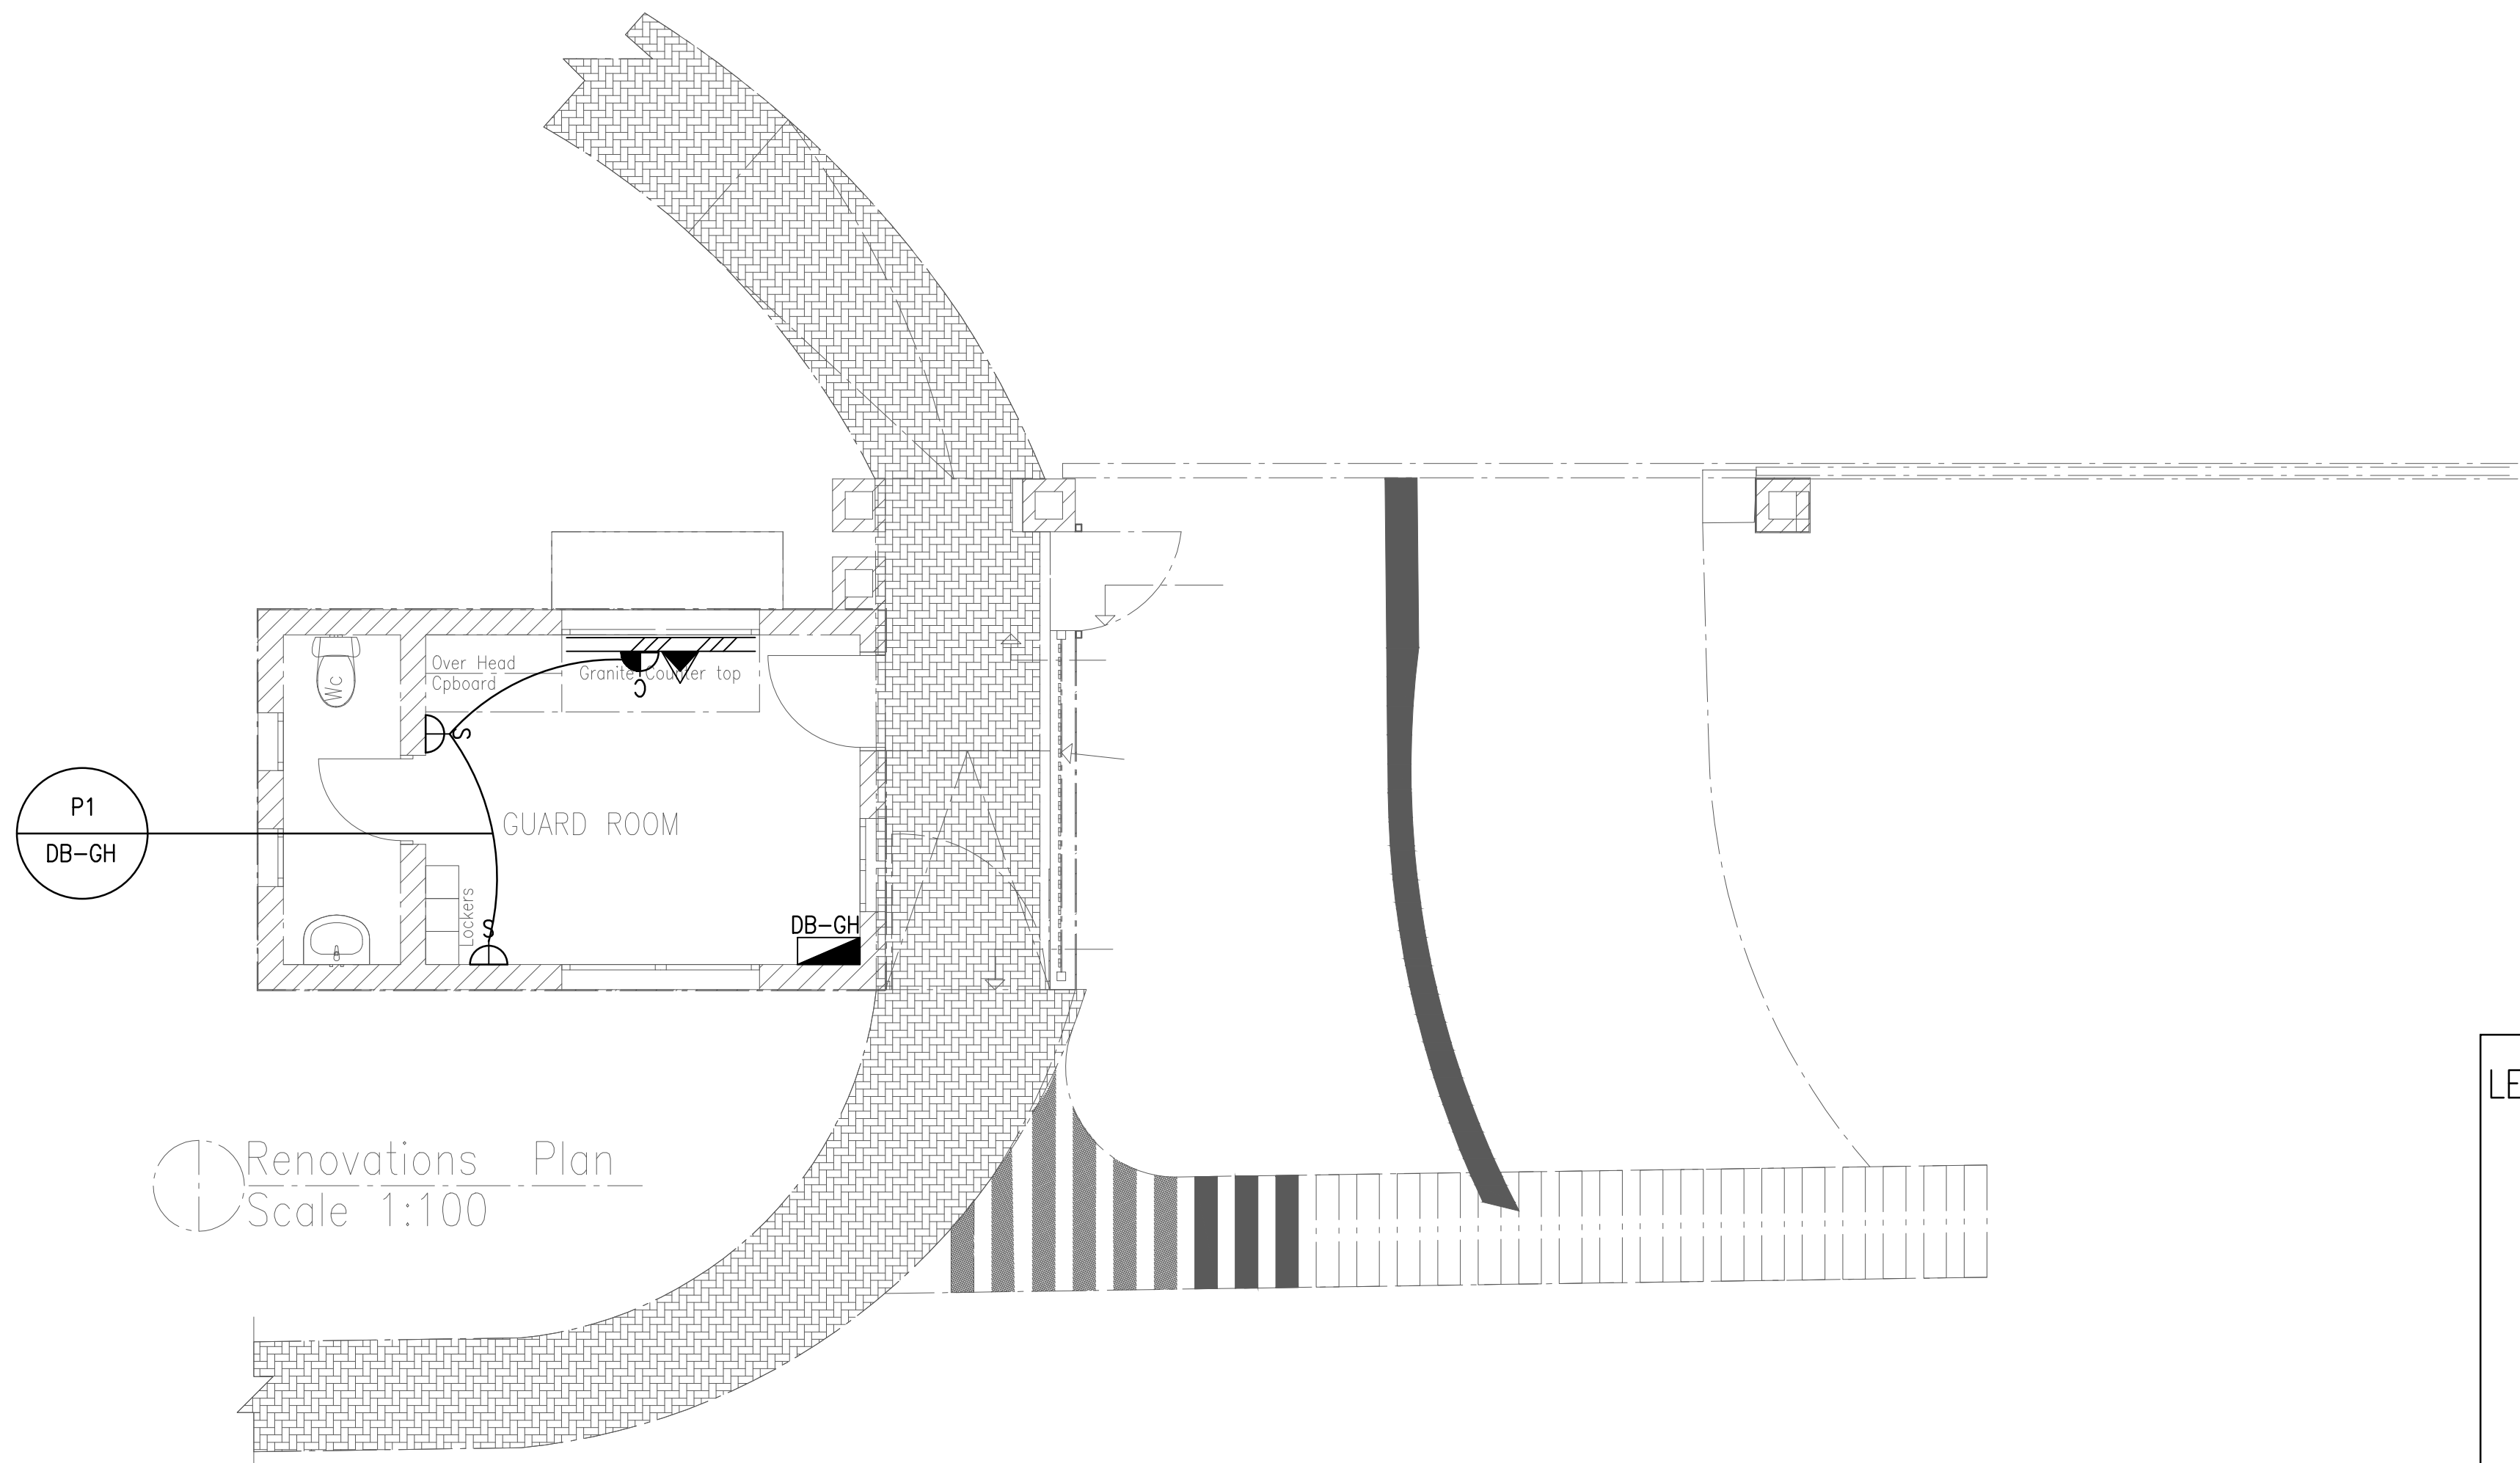

Exist Brick walls
Exist Screen walls To Be Demolished

GROUND FLOOR PLAN
SCALE 1:50

LEGEND

- C** 230V, 16A, 3 PIN ROUND, NORMAL SINGLE SWITCHED SOCKET OUTLET, WHITE IN COLOR, SANS164-12 & SANS164-2 MOUNTED ON POWER SKIRTING
- S** 230V, 16A, 3 PIN ROUND, NORMAL SINGLE SWITCHED SOCKET OUTLET, WHITE IN COLOR, MOUNTED @ 300mm A.F.F.L. UNLESS OTHERWISE STATED SANS164-12 & SANS164-2
- D** 16A 3-PIN SINGLE DEDICATED SOCKET OUTLET POWER SKIRTING / WALL MOUNTED
- 2 COMPARTMENT, 2 COVER, GALVANISED STEEL, EPOXY COATED, POWER SKIRTING**
- WALL MOUNTED 20A DP ISOLATOR**
- 20A, DOUBLE POLE GEYSER ISOLATOR MOUNTED NEXT TO GEYSER.**
- 20A, DOUBLE POLE ISOLATOR FOR FRESH AIR SUPPLY**
- DATA ACCESS POINT**
- SINGLE DATA POINT**
- DOUBLE DATA POINT**
- TELEPHONE POINT**
- ELECTRICAL DISTRIBUTION BOARD**
- P** CIRCUIT NUMBER
- DB** DISTRIBUTION BOARD NUMBER

CLIENT
SOUTH AFRICAN NATIONAL BIODIVERSITY INSTITUTE

SANBI
Biodiversity for Life
South African National Biodiversity Institute

TD	2022-09-26	ISSUED FOR TENDER
A	2022-09-13	ISSUED FOR APPROVAL
REV NO.	DATE	DESCRIPTION

REVISIONS

PROJECT CONSULTANT
PROJECTNEERS CONSULTING ENGINEERS & PROJECT MANAGERS

PROJECTNEERS
PROJECTNEERS CONSULTING ENGINEERS & PROJECT MANAGERS
BUILDING 2, 1ST FLOOR, THORNHILL OFFICE PARK
94 BEKKER ROAD, MIDRAND, 1685
+27 11 043 1307
technical@projectneers.com
www.projectneers.com

DRAWING CHECKS	DESIGNED BY	CHECKED BY	APPROVED BY	DRAWN BY
F.MPOFU			B.MDLULI	F.MPOFU

APPROVAL CONSULTANT
N.K. MPOFU

DATE	FILE NO.	THE MASTER FILE OF THE PROJECTNEERS CONSULTING ENGINEERS & PROJECT MANAGERS IS THE ORIGINAL SOURCE OF APPROVAL.
31-08-2022	20130388	

PROJECT NAME
ASSESSMENT, DESIGN & PROJECT MANAGEMENT OF REQUIRED NEW BUILDINGS & REPAIRS, RENOVATIONS & UPGRADES TO VARIOUS INFRASTRUCTURE ASSETS IN THE THOHOYANDOU BOTANICAL GARDEN, THOHOYANDOU & NATIONAL ZOOLOGICAL GARDEN CAMPUSES BASED IN PRETORIA & MOKOPANE

SITE
THOHOYANDOU BOTANICAL GARDENS

SHEET TITLE
VISITORS CENTRE GUARD HOUSE
POWER LAYOUT
DISCIPLINE
ELECTRICAL

CONTRACT NUMBER
G3062018


FILE NUMBER
ZA2018_2008

SCALE
AS INDICATED

DRAWING NUMBER
PJN_ZA_2022_2002_SANBI_TBG_EE_6001_TD

A1


ISSUED FOR TENDER

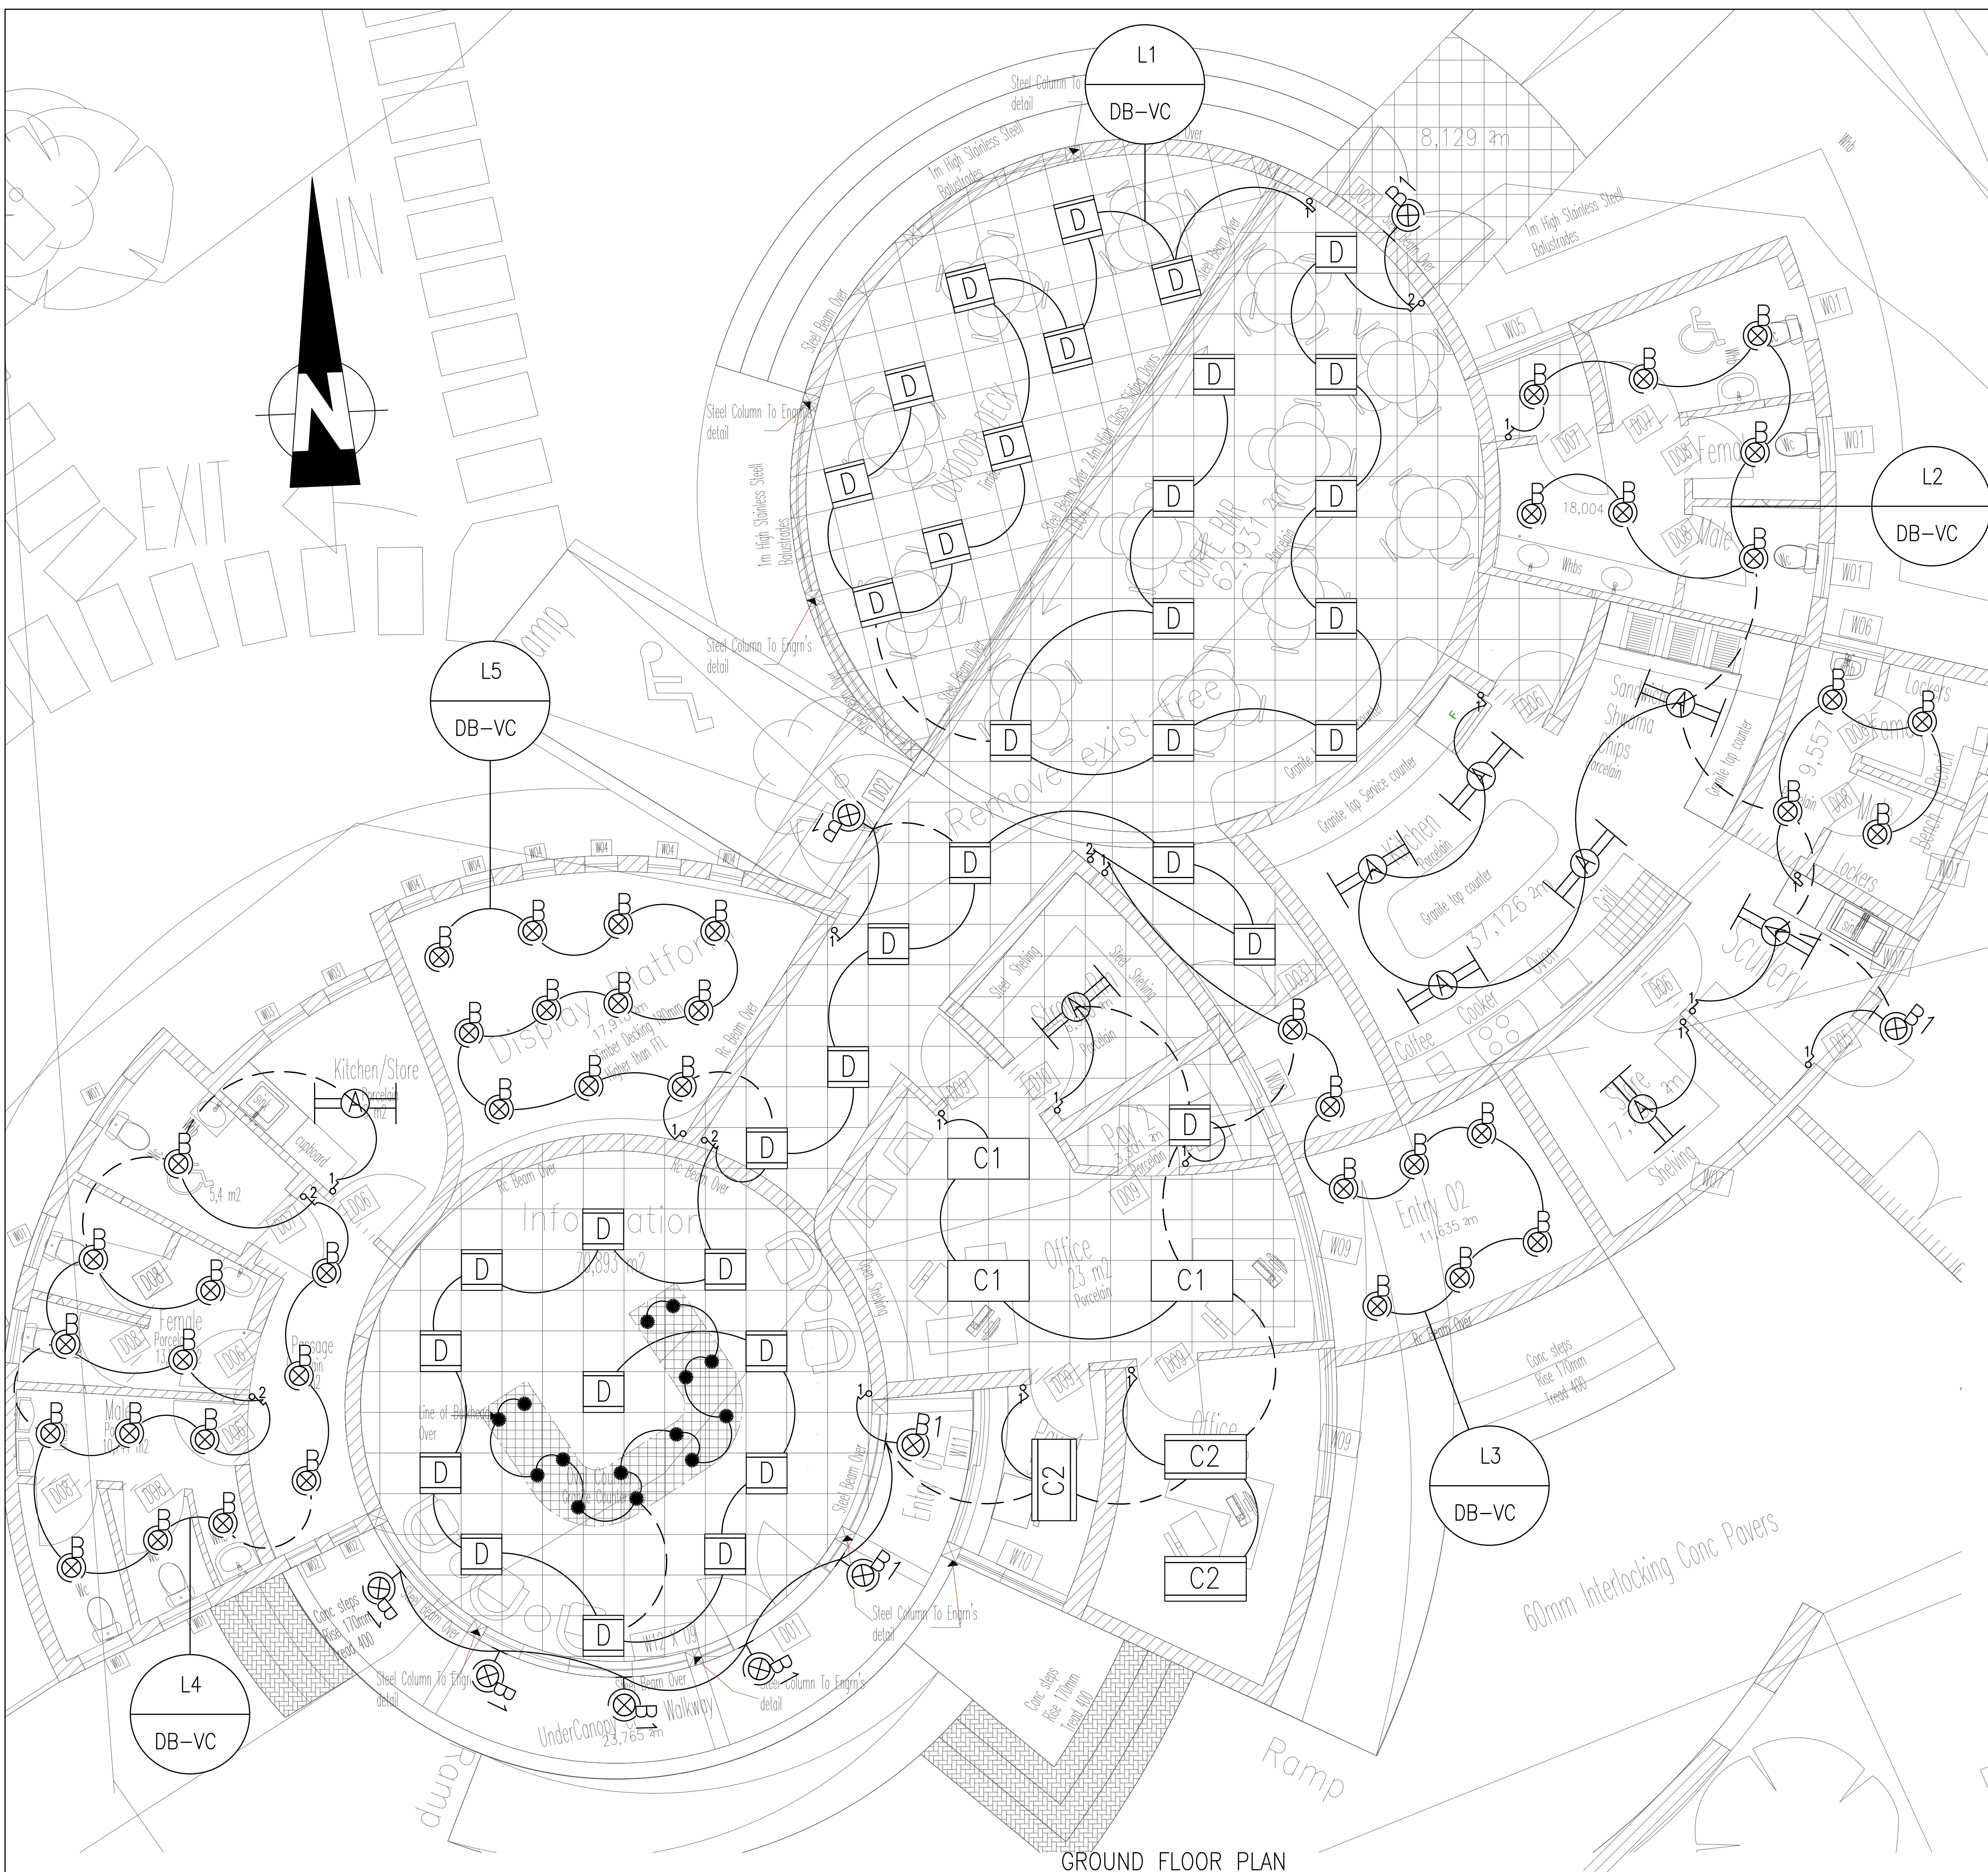

GROUND FLOOR PLAN
SCALE 1:50

ISSUED FOR TENDER

THIS DRAWING

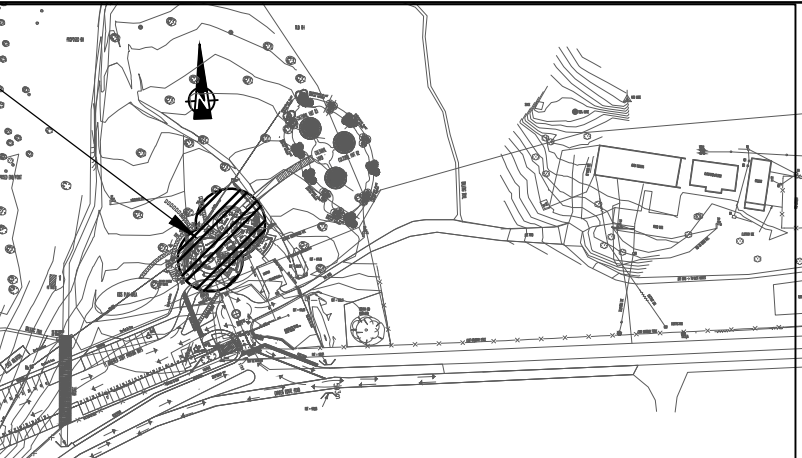

SITE PLAN
N.T.S

LEGEND

- TYPE A: 1300mm SURFACE MOUNTED LED LIGHT FITTING, POLYCARBONATE OPTICAL COVER, 31W LAMP, 4200 LUMENS, 4000K COLOUR TEMPERATURE, IP66 PROTECTION, ELECTRONIC CONTROL GEAR.
- TYPE B: RECESSED MOUNTED LED OPAL DOWNLIGHT, 120mm DIAMETER, HIGH PRESSURE ALUMINIUM DIE CAST HOUSING COMPLETE WITH WHITE EPOXY POWDER COATING, 12W LED LAMP, 850 LUMENS, 4000K COLOUR TEMPERATURE, IP20 PROTECTION, ELECTRONIC CONTROL GEAR.
- TYPE B1: DECORATIVE RECTANGULAR SURFACE-MOUNTED BULKHEAD LUMINAIRE, HIGH PRESSURE DIE-CAST ALUMINIUM BASE, OPAQUE PRISMATIC HIGH IMPACT ACRYLIC DIFFUSER, 32W LED LAMP, 5840 LUMENS, 4000K COLOUR TEMPERATURE, IP66 PROTECTION, ELECTRONIC CONTROL GEAR.
- TYPE C1: RECESS MOUNTED LED PANEL LUMINAIRE, 1200mm X 600mm, POLY-CARBONATE BODY, ACRYLIC OPAL DIFFUSER, 65W LED LAMP, 5850 LUMENS, 4000K COLOUR TEMPERATURE, IP20 PROTECTION, ELECTRONIC CONTROL GEAR. EMERGENCY VERSION.
- TYPE C1E: RECESS MOUNTED LED PANEL LUMINAIRE, 1200mm X 600mm, POLY-CARBONATE BODY, ACRYLIC OPAL DIFFUSER, 65W LED LAMP, 5850 LUMENS, 4000K COLOUR TEMPERATURE, IP20 PROTECTION, ELECTRONIC CONTROL GEAR. EMERGENCY VERSION.
- TYPE C2: SURFACE-MOUNTED LED PANEL LUMINAIRE, 1200mm X 600mm, POLY-CARBONATE BODY, ACRYLIC OPAL DIFFUSER, 65W LED LAMP, 5850 LUMENS, 4000K COLOUR TEMPERATURE, IP20 PROTECTION, ELECTRONIC CONTROL GEAR.
- TYPE C2E: SURFACE-MOUNTED LED PANEL LUMINAIRE, 1200mm X 600mm, POLY-CARBONATE BODY, ACRYLIC OPAL DIFFUSER, 65W LED LAMP, 5850 LUMENS, 4000K COLOUR TEMPERATURE, IP20 PROTECTION, ELECTRONIC CONTROL GEAR. EMERGENCY VERSION.
- TYPE D: RECESS MOUNTED LED PANEL LUMINAIRE, 600mm x 600mm, POLY-CARBONATE BODY, ACRYLIC OPAL DIFFUSER, 36W LED LAMP, 3240 LUMENS, 4000K COLOUR TEMPERATURE, IP20 PROTECTION, ELECTRONIC CONTROL GEAR.
- TYPE DE: RECESS MOUNTED LED PANEL LUMINAIRE, 600mm x 600mm, POLY-CARBONATE BODY, ACRYLIC OPAL DIFFUSER, 36W LED LAMP, 3240 LUMENS, 4000K COLOUR TEMPERATURE, IP20 PROTECTION, ELECTRONIC CONTROL GEAR. EMERGENCY VERSION.
- TYPE E: DECORATIVE 80mm DIAMETER, LED DOWNLIGHTER
- 10A 1GANG 1WAY LIGHT SWITCH
- 10A 1GANG 2WAY LIGHT SWITCH
- 10A 2GANG 2WAY LIGHT SWITCH
- ELECTRICAL DISTRIBUTION BOX
- PHOTO CELL
- CIRCUIT NUMBER
- DISTRIBUTION BOARD NUMBER

CLIENT
SOUTH AFRICAN NATIONAL BIODIVERSITY INSTITUTE

SANBI
Biodiversity for Life

South African National Biodiversity Institute

REV NO.	DATE	DESCRIPTION
TD	2022-09-26	ISSUED FOR TENDER
A	2022-09-13	ISSUED FOR APPROVAL

REVISIONS

PROJECT CONSULTANT
PROJECTNEERS CONSULTING ENGINEERS & PROJECT MANAGERS

PROJECTNEERS
PROJECTNEERS CONSULTING ENGINEERS & PROJECT MANAGERS

BUILDING 2, 1ST FLOOR, THORNHILL OFFICE PARK
94 BEKKER ROAD, MIDRAND, 1685
+27 11 043 1307

technical@projectneers.com
www.projectneers.com

DRAWING CHECKS			
DESIGNED BY	DATE CHECKED	CHECKED BY	DATE
F.MPOFU	--	B.MDLULI	F.MPOFU

APPROVAL CONSULTANT			
NAME	DATE	DATE	DATE
N.K. MPOFU	31-08-2022	20130388	

PROJECT NAME
ASSESSMENT, DESIGN & PROJECT MANAGEMENT OF REQUIRED NEW BUILDINGS & REPAIRS, RENOVATIONS & UPGRADES TO VARIOUS INFRASTRUCTURE ASSETS IN THE THOHOYANDOU BOTANICAL GARDEN, THOHOYANDOU & NATIONAL ZOOLOGICAL GARDEN CAMPUSES BASED IN PRETORIA & MKOPANE

SITE
THOHOYANDOU BOTANICAL GARDENS

SHEET TITLE
VISITORS CENTRE LIGHTING LAYOUT
DISCIPLINE
ELECTRICAL


CONTRACT NUMBER
G3062018

FILE NUMBER
ZA2018_2008


DRAWING NUMBER
PJN_ZA_2022_2002_SANBI_TBG_EE_6100_TD

SCALE
AS INDICATED

THIS DRAWING

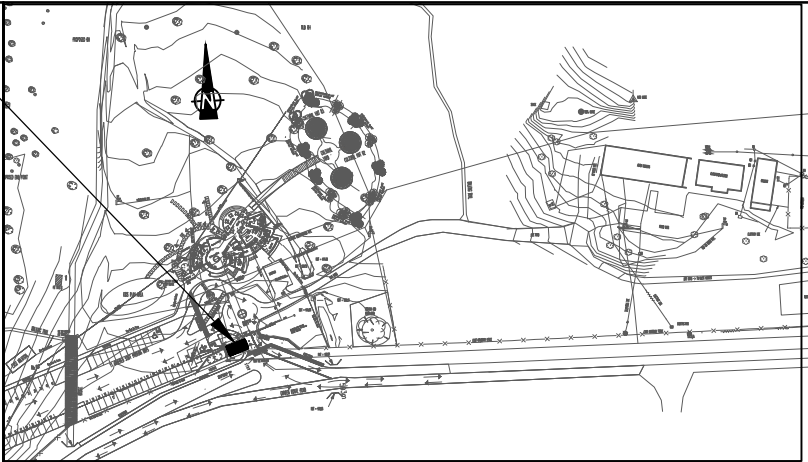

SITE PLAN
N.T.S

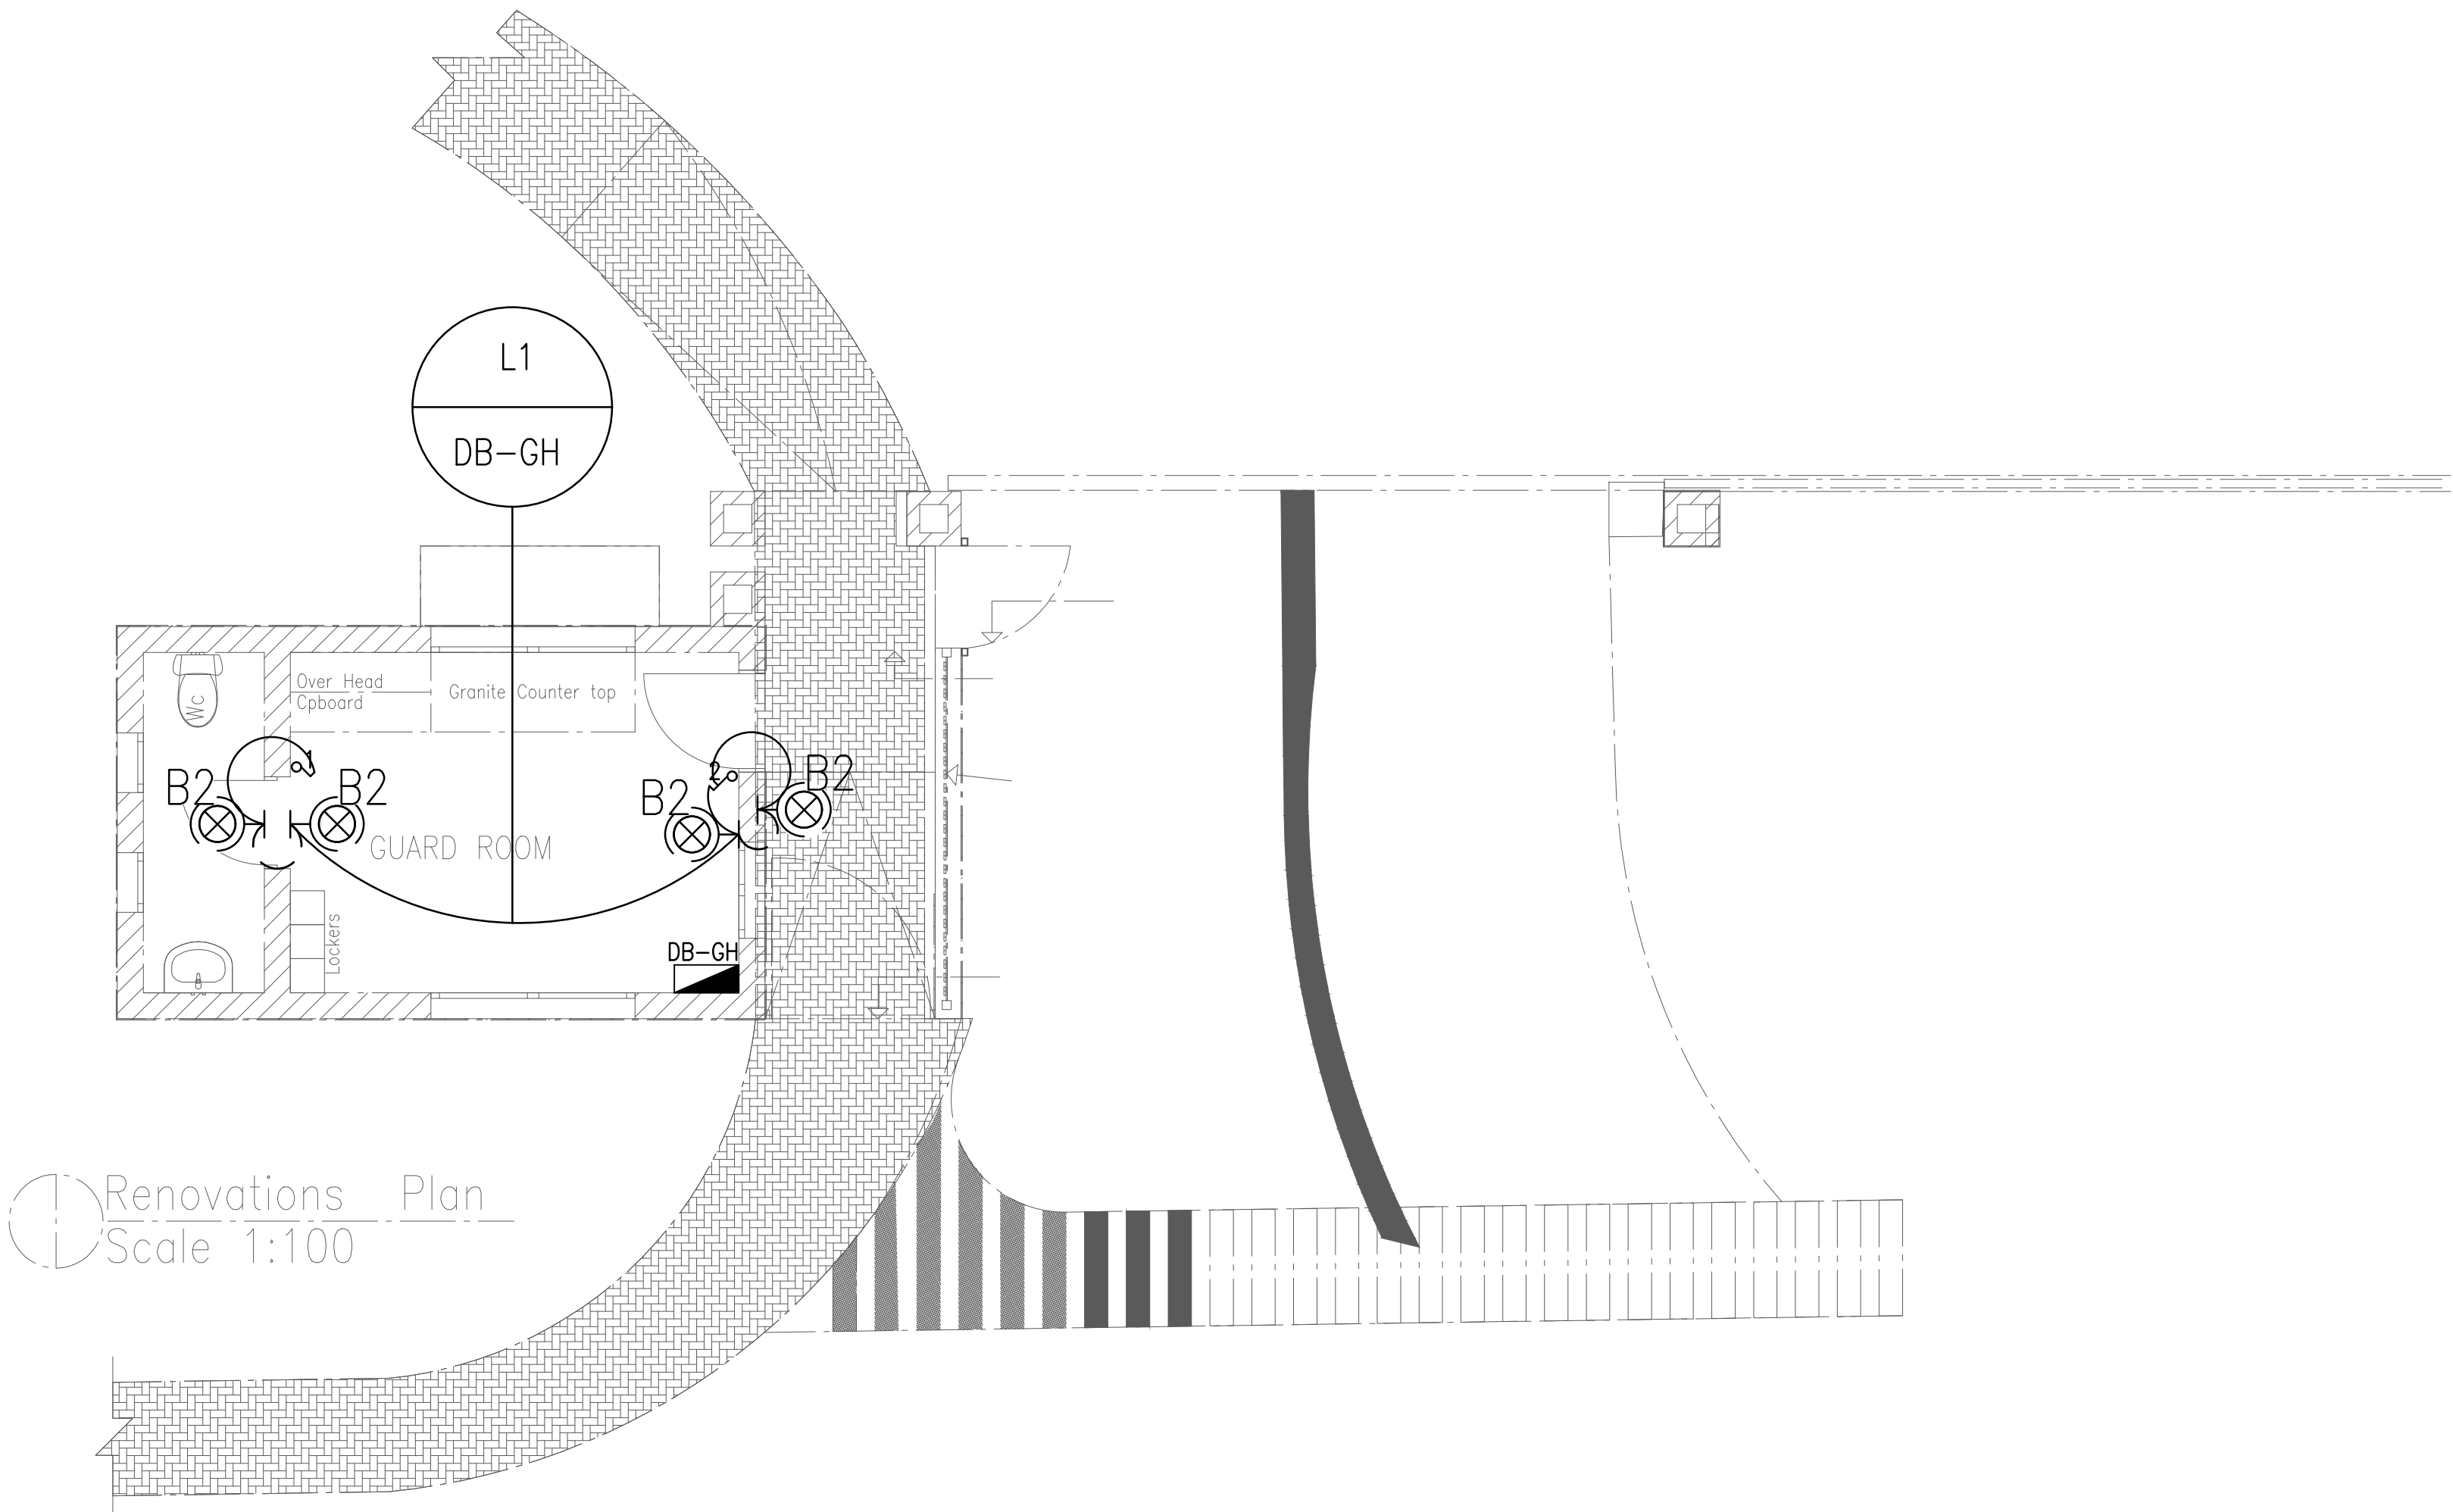

Exist Brick walls
Exist Screen walls To Be Demolished

GROUND FLOOR PLAN
SCALE 1:50

LEGEND

- B2 DECORATIVE WALL MOUNTED BULKHEAD LIGHT FITTING, 11W LED LAMP AND ELECTRONIC CONTROL GEAR
- 10A 1GANG 1WAY LIGHT SWITCH
- 10A 1GANG 2WAY LIGHT SWITCH
- 10A 2GANG 2WAY LIGHT SWITCH
- ELECTRICAL DISTRIBUTION BOX
- CIRCUIT NUMBER
- DISTRIBUTION BOARD NUMBER

ISSUED FOR TENDER

CLIENT
SOUTH AFRICAN NATIONAL BIODIVERSITY INSTITUTE



TD	2022-09-26	ISSUED FOR TENDER
A	2022-09-13	ISSUED FOR APPROVAL

REV NO.	DATE	DESCRIPTION
---------	------	-------------

REVISIONS

PROJECT CONSULTANT
PROJECTNEERS CONSULTING ENGINEERS & PROJECT MANAGERS

PROJECTNEERS

PROJECTNEERS CONSULTING ENGINEERS
& PROJECT MANAGERS
BUILDING 2, 1ST FLOOR, THORNHILL OFFICE PARK
94 BEKKER ROAD, MIDRAND, 1685
+27 11 043 1307

technical@projectneers.com
www.projectneers.com

DRAWING CHECKS	DESIGNED BY	CHECKED BY	APPROVED BY	DATE
F.MPOFU			B.MDLULI	F.MPOFU

APPROVAL CONSULTANT
N.K. MPOFU

DATE	FILE NO.	THE MASTER FILE OF THE PROJECTNEERS CONSULTING ENGINEERS & PROJECT MANAGERS IS THE ORIGINAL SIGNATURE OF APPROVAL.
31-08-2022	20130388	

PROJECT NAME
ASSESSMENT, DESIGN & PROJECT MANAGEMENT OF REQUIRED NEW BUILDINGS & REPAIRS, RENOVATIONS & UPGRADES TO VARIOUS INFRASTRUCTURE ASSETS IN THE THOHOYANDOU BOTANICAL GARDEN, THOHOYANDOU & NATIONAL ZOOLOGICAL GARDEN CAMPUSES BASED IN PRETORIA & MOKOPANE


SITE
THOHOYANDOU BOTANICAL GARDENS

SHEET TITLE
VISITORS CENTRE GUARD HOUSE
LIGHTING LAYOUT
DISCIPLINE
ELECTRICAL

CONTRACT NUMBER
G3062018

FILE NUMBER
ZA2018_2008
SCALE
AS INDICATED


DRAWING NUMBER
PJN_ZA_2022_2002_SANBI_TB_G_EE_6101_TD
A1

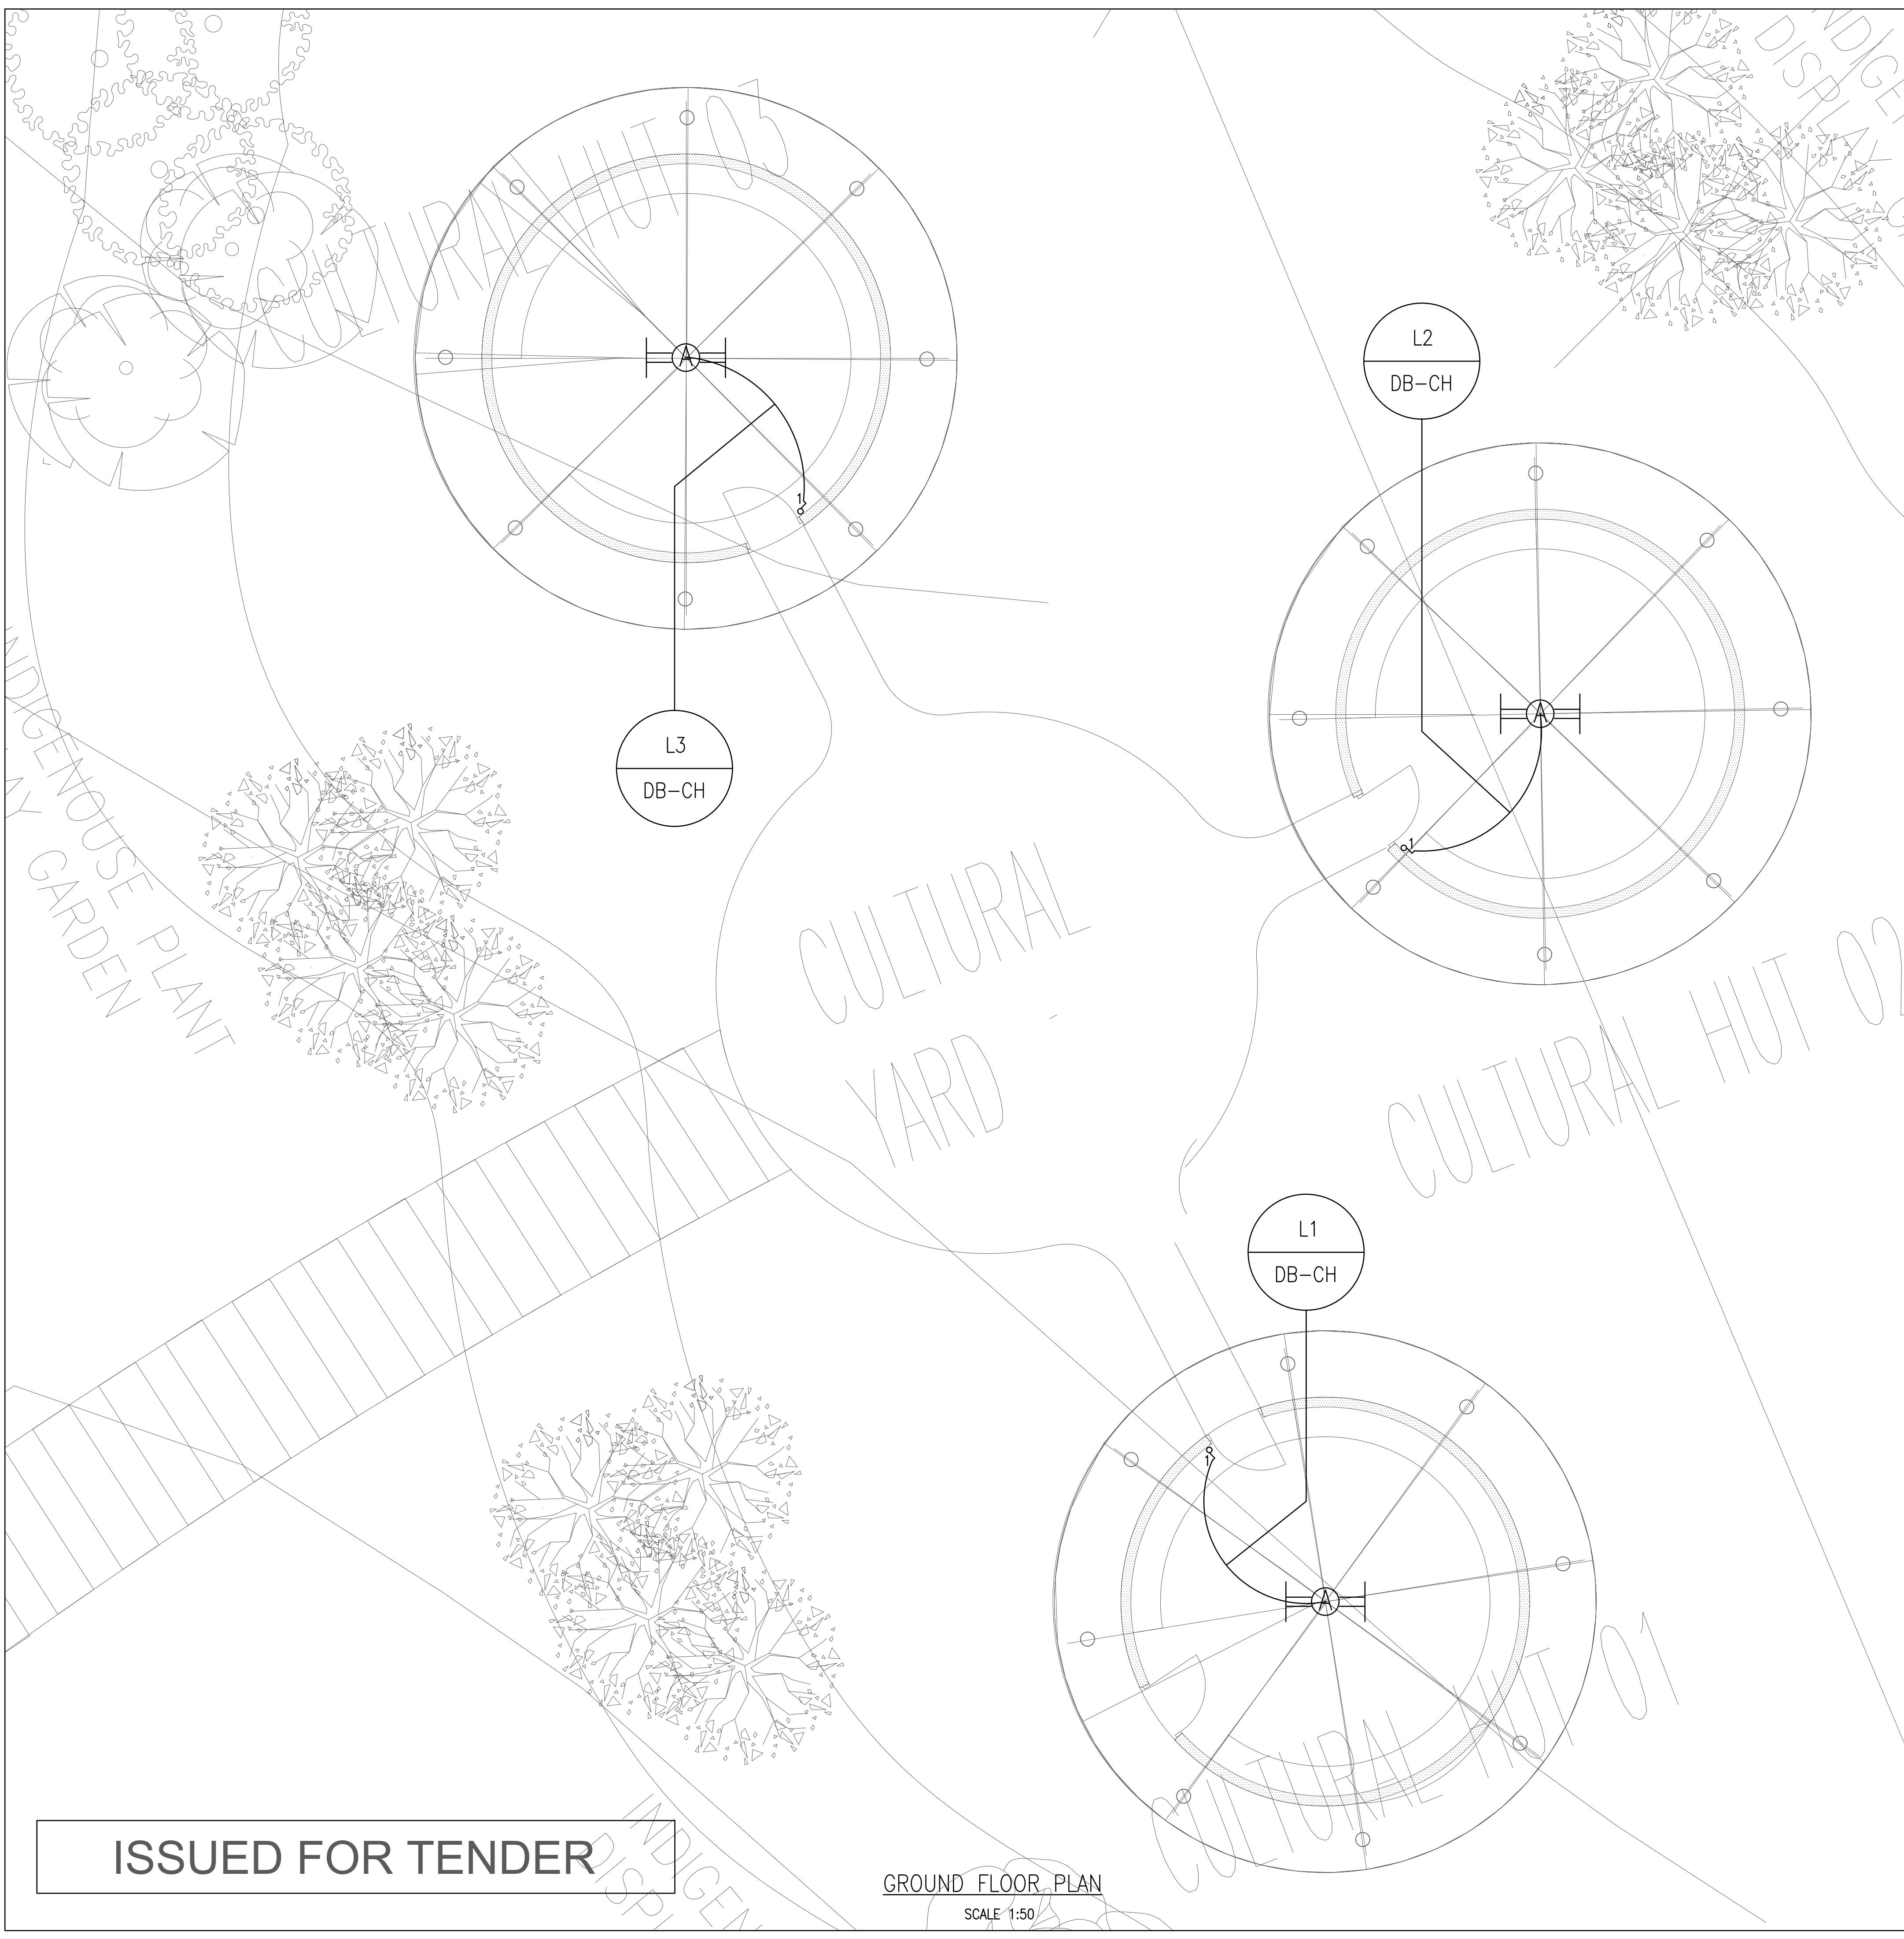

ISSUED FOR TENDER

GROUND FLOOR PLAN
SCALE 1:50

 LEGEND



TYPE A: 1300mm SURFACE MOUNTED LED LIGHT FITTING, POLYCARBONATE OPTICAL COVER, 31W LAMP, 4200 LUMENS, 4000K COLOUR TEMPERATURE, IP66 PROTECTION, ELECTRONIC CONTROL GEAR.



10A 1GANG 1WAY LIGHT SWITCH




10A 1GANG 2WAY LIGHT SWITCH



10A 2GANG 2WAY LIGHT SWITCH



ELECTRICAL DISTRIBUTION BOX

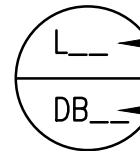

CIRCUIT NUMBER

DISTRIBUTION BOARD NUMBER

THIS DRAWING



SITE PLAN
N.T.S

CLIENT
SOUTH AFRICAN NATIONAL BIODIVERSITY INSTITUTE

SANBI
Biodiversity for Life

South African National Biodiversity Institute

TD	2022-09-26	ISSUED FOR TENDER
A	2022-09-13	ISSUED FOR APPROVAL
REV NO.	DATE	DESCRIPTION

REVISIONS

PROJECT CONSULTANT
PROJECTNEERS CONSULTING ENGINEERS & PROJECT MANAGERS

PROJECTNEERS
PROJECTNEERS CONSULTING ENGINEERS
& PROJECT MANAGERS
BUILDING 2, 1ST FLOOR, THORNHILL OFFICE PARK
94 BEKKER ROAD, MIDRAND, 1685
+27 11 043 1307
technical@projectneers.com
www.projectneers.com

DESIGNED BY	DATE	DESIGNED BY	DATE	DESIGNED BY	DATE
F.MPOFU	31-08-2022	B.MDLULI	20130388	F.MPOFU	

APPROVAL CONSULTANT N.K. MPOFU

PROJECT NAME
ASSESSMENT, DESIGN & PROJECT MANAGEMENT OF REQUIRED NEW BUILDINGS & REPAIRS, RENOVATIONS & UPGRADES TO VARIOUS INFRASTRUCTURE ASSETS IN THE THOHOYANDOU BOTANICAL GARDEN, THOHOYANDOU & NATIONAL ZOOLOGICAL GARDEN CAMPUSES BASED IN PRETORIA & MOKOPANE

SITE
THOHOYANDOU BOTANICAL GARDENS

SHEET TITLE
VISITORS CENTRE CULTURAL HUTS 1, 2 & 3 LIGHTING LAYOUT

DISCIPLINE
ELECTRICAL


CONTRACT NUMBER
G306/2018

FILE NUMBER
ZA2018_2008

SCALE
AS INDICATED

DRAWING NUMBER
PJN_ZA_2022_2002_SANBI_TBG_EE_6102_TD

ISSUED FOR TENDER

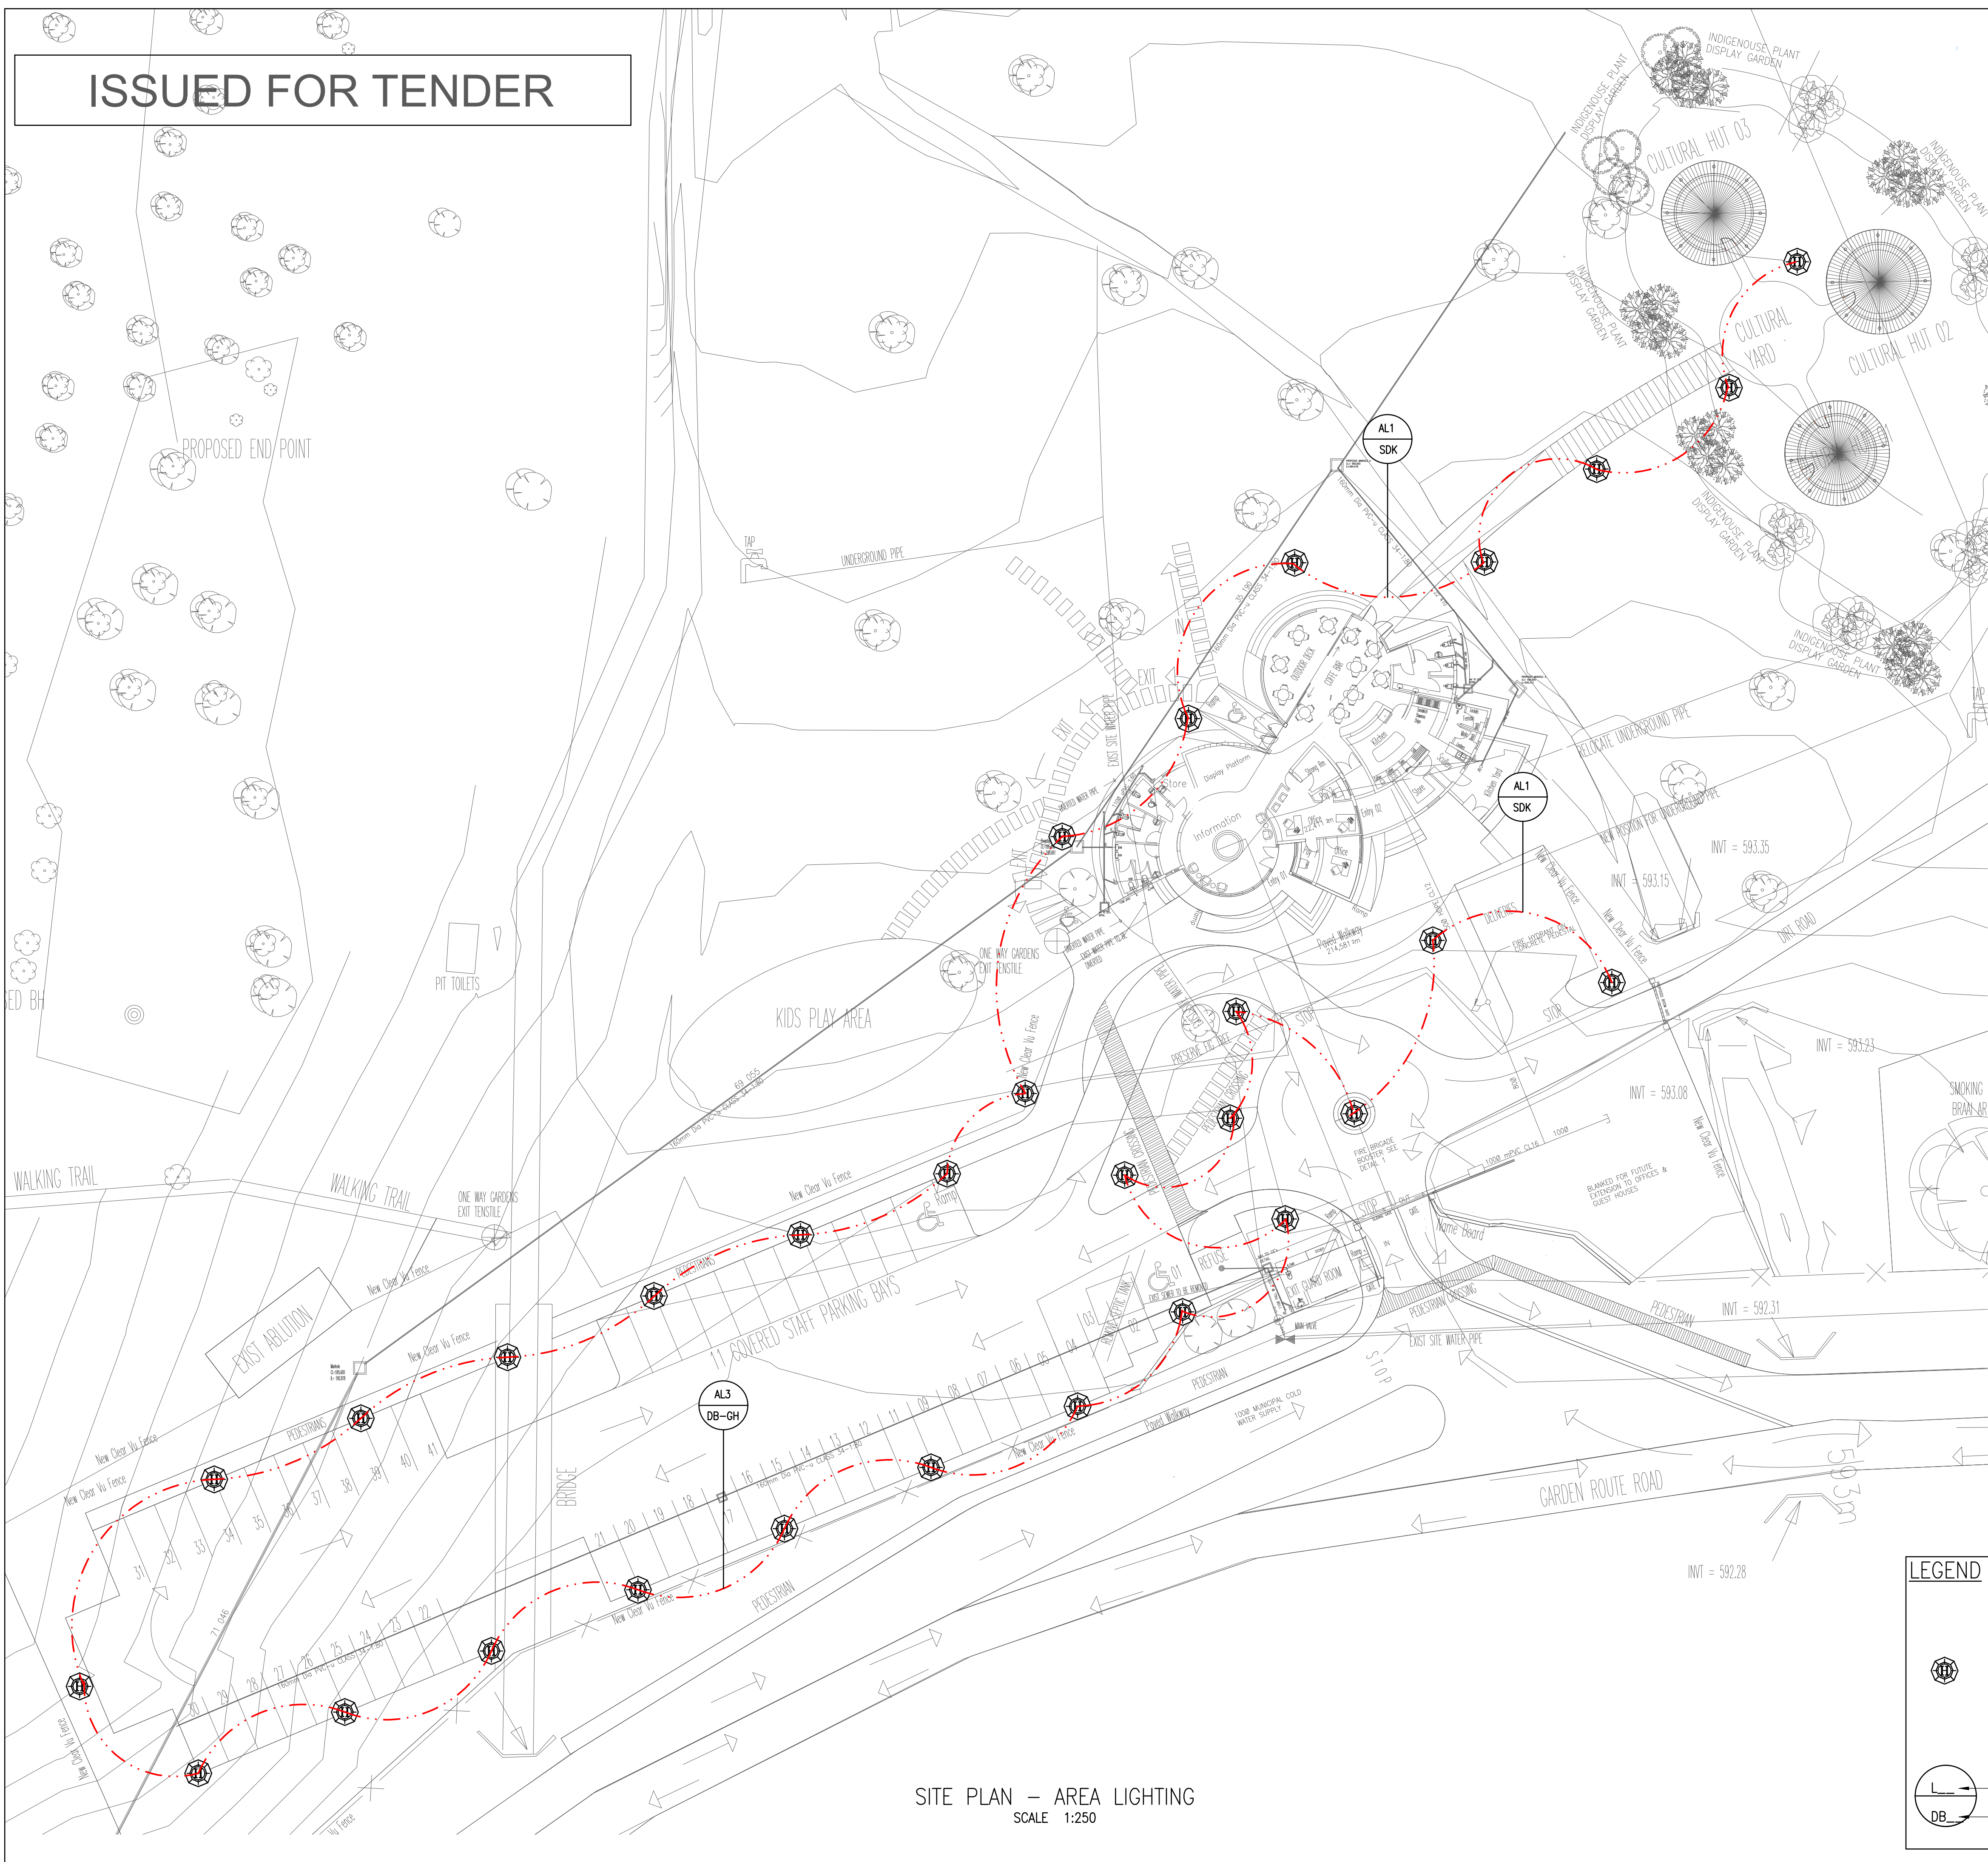

SITE PLAN – AREA LIGHTING
SCALE 1:250

LEGEND

TYPE H – POST TOP LED LUMINAIRE, ACRYLONITRILE STYRENE ACRYLATE (ASA) TOP COVER, HIGH-PRESSURE POWDER-COATED DIE-CAST ALUMINIUM BASE AND GEAR PLATE, HIGH-IMPACT ACRYLIC PROTECTOR, 55W LED LAMP, 6490 LUMENS, IP66 PROTECTION, ELECTRONIC CONTROL GEAR COMPLETE WITH A 4m GALVANISED STEEL POLE.

CIRCUIT NUMBER

DISTRIBUTION BOARD NUMBER



SITE PLAN
N.T.S

CLIENT
SOUTH AFRICAN NATIONAL BIODIVERSITY INSTITUTE

South African National Biodiversity Institute

TD	2022-09-26	ISSUED FOR TENDER
A	2022-09-13	ISSUED FOR APPROVAL
REV NO.	DATE	DESCRIPTION

REVISIONS

PROJECT CONSULTANT
PROJECTNEERS CONSULTING ENGINEERS & PROJECT MANAGERS

PROJECTNEERS
PROJECTNEERS CONSULTING ENGINEERS & PROJECT MANAGERS
BUILDING 2, 1ST FLOOR, THORNHILL OFFICE PARK
94 BEKKER ROAD, MIDRAND, 1685
+27 11 043 1307
technical@projectneers.com
www.projectneers.com

DRAWING CHECKS
F.MPOFU
B.MDLULI
F.MPOFU

APPROVAL CONSULTANT
N.K. MPOFU

DATE	31-08-2022	REVISED	20130388
------	------------	---------	----------

THE MASTER FILE OF THE PROJECTNEERS CONSULTING ENGINEERS & PROJECT MANAGERS IS THE ORIGINAL SOURCE OF ALL INFORMATION.

PROJECT NAME
ASSESSMENT, DESIGN & PROJECT MANAGEMENT OF REQUIRED NEW BUILDINGS & REPAIRS, RENOVATIONS & UPGRADES TO VARIOUS INFRASTRUCTURE ASSETS IN THE THOHOYANDOU BOTANICAL GARDEN, THOHOYANDOU & NATIONAL ZOOLOGICAL GARDEN CAMPUSES BASED IN PRETORIA & MOKOPANE

SITE
THOHOYANDOU BOTANICAL GARDENS

SHEET TITLE
VISITORS CENTRE LIGHTING LAYOUT
DISCIPLINE
ELECTRICAL

CONTRACT NUMBER
G3062018

FILE NUMBER
ZA2018_2008

SCALE
AS INDICATED

DRAWING NUMBER
PJN_ZA_2022_2002_SANBI_TBG_EE_6103_TD

A1



SANBI 
Biodiversity for Life
South African National Biodiversity Institute

TD	2022-09-26	ISSUED FOR TENDER
A	2022-09-13	ISSUED FOR APPROVAL
REV NO.	DATE	DESCRIPTION

REVISIONS

PROJECTNEERS

BUILDING 2, 1ST FLOOR, THORNHILL OFFICE PARK
94 BEKKER ROAD, MIDRAND, 1685
+27 11 043 1307

technical@projectneers.com
www.projectneers.com

DRAWING CHECKS

ORDERED BY	ORDER CHECKED BY	ORDERED BY	ORDER CHECKED BY
EMPOEU	**	BMDIUU	EMPOEU

APPROVAL CONSULTANT

APPROVAL CONSULTANT		
N.K. MPOFU		
DATE	REF. NO.	THE MASTER HELD AT THE PROJECT/NEEDS CONSULTING BUREAU OFFICE BEARS THE ORIGINAL SIGNATURE OF APPROVAL
31.08.2022	20130388	

PROJECT NAME

ASSESSMENT, DESIGN & PROJECT MANAGEMENT OF REQUIRED NEW BUILDINGS & REPAIRS, RENOVATIONS & UPGRADES TO VARIOUS INFRASTRUCTURE ASSETS IN THE THOHOYANDOU BOTANICAL GARDEN, THOHOYANDOU, & NATIONAL ZOOLOGICAL GARDEN CAMPUSES BASED IN PRETORIA & MOKOPANE

SITE

THOHOYANDOU BOTANICAL GARDENS

SHEET TITLE

VISITORS CENTRE
SECURITY LAYOUT
DISCIPLINE
ELECTRICAL

CONTRACT NUMBER
G306/2018

FILE NUMBER
7A2018-2008

DRAWING NUMBER

DOC	STATE	YEAR	PAGE NO	COUNT	DTG	REG	SRCH NO	REV
PJN	ZA	2022	2002	SANBI	TBG	EE	6200	TD

SCALE
AS INDICATED

POSTER

SITE PLAN – SECURITY
SCALE 1:50

ISSUED FOR TENDER

 
LEGEND



IP CCTV BULLET CAMERA



IP CCTV MINI-DOME CAMERA



ACCESS CONTROL

ISSUED FOR TENDER

THIS DRAWING



SITE PLAN
N.T.S

CLIENT
SOUTH AFRICAN NATIONAL BIODIVERSITY INSTITUTE



TD	2022-09-26	ISSUED FOR TENDER
A	2022-09-13	ISSUED FOR APPROVAL
REV NO.	DATE	DESCRIPTION

REVISIONS

PROJECT CONSULTANT
PROJECTNEERS CONSULTING ENGINEERS & PROJECT MANAGERS

PROJECTNEERS

PROJECTNEERS CONSULTING ENGINEERS
&
PROJECT MANAGERS
BUILDING 2, 1ST FLOOR, THORNHILL OFFICE PARK
94 BEKKER ROAD, MIDRAND, 1685
+27 11 043 1307

technical@projectneers.com
www.projectneers.com

DRAWING CHECKS	DESIGNED BY	CHECKED BY	APPROVED BY
F.MPOFU		B.MDLULI	F.MPOFU

APPROVAL CONSULTANT	DESIGNED BY	CHECKED BY	APPROVED BY
N.K. MPOFU			

PROJECT NAME
ASSESSMENT, DESIGN & PROJECT MANAGEMENT OF REQUIRED NEW
BUILDINGS & REPAIRS, RENOVATIONS & UPGRADES TO VARIOUS
INFRASTRUCTURE ASSETS IN THE THOHOYANDOU BOTANICAL GARDEN,
THOHOYANDOU & NATIONAL ZOOLOGICAL GARDEN CAMPUSES BASED IN
PRETORIA & MKOPANE

SITE
THOHOYANDOU BOTANICAL GARDENS

SHEET TITLE
VISITORS CENTRE
LV RETICULATION LAYOUT
DISCIPLINE
ELECTRICAL


CONTRACT NUMBER
G3062018

FILE NUMBER
ZA2018_2008

SCALE
AS INDICATED

DRAWING NUMBER
PJN_ZA_2022_2002_SANBI_TBG_EE_6300_TD

A1

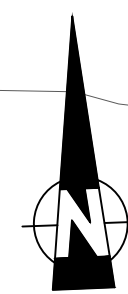

LOW VOLTAGE UNDERGROUND CABLES,
SUPPLY FROM SUB-DISTRIBUTION KIOSK



LEGEND

PROPOSED SUB-DISTRIBUTION KIOSK (BY OTHERS)


PROPOSED LOW VOLTAGE CABLES

NUMBER OF SLEEVES INDICATED THUS
 2 No. 110mm PVC SLEEVES, ACROSS THE ROAD


SITE PLAN - LV RETICULATION
SCALE 1:250

ISSUED FOR TENDER


THIS DRAWING

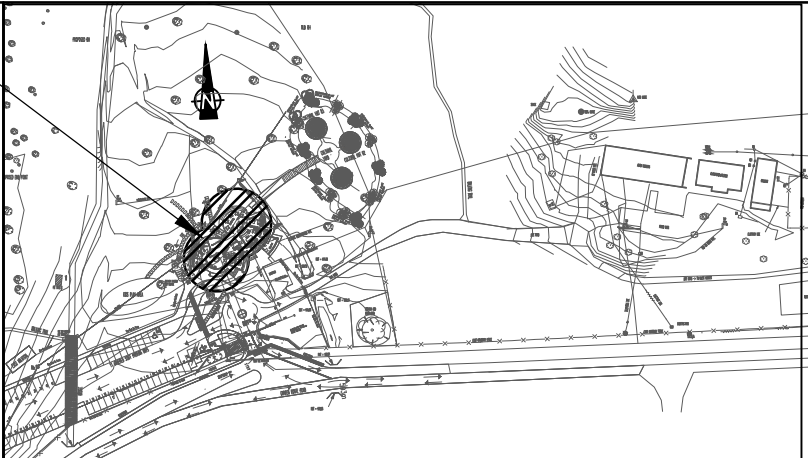

SITE PLAN
N.T.S

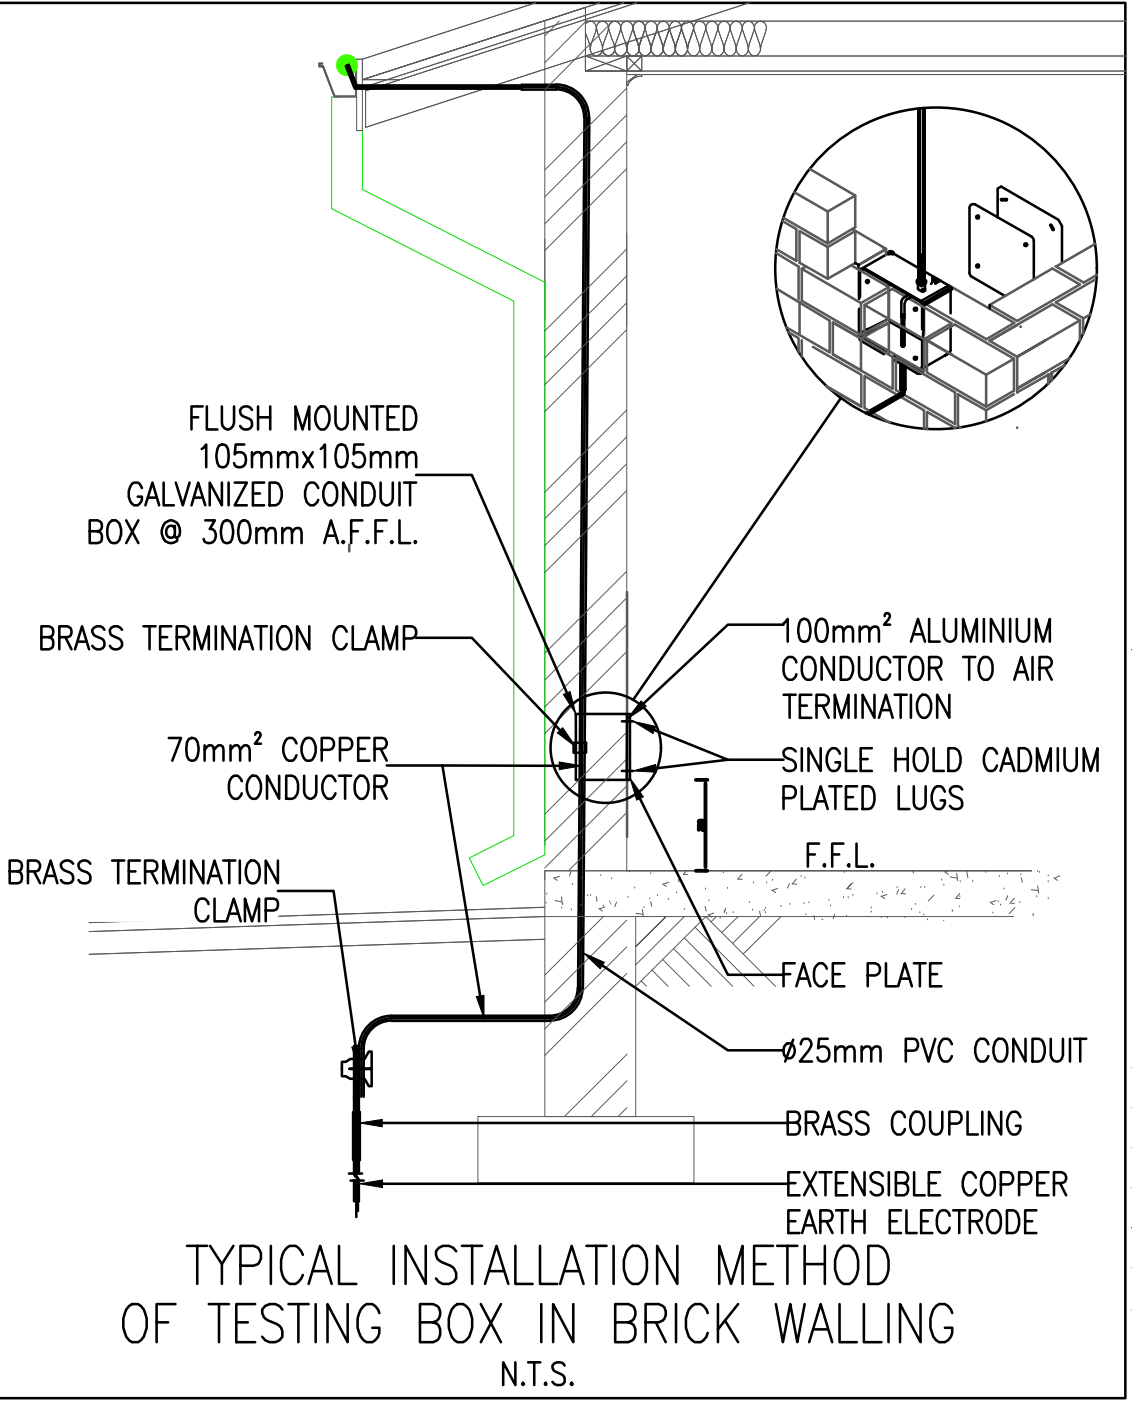

- LEGEND**
- 70mm BCEW BURIED AT 1000mm DEPTH, 1000mm AWAY FROM EDGE OF THE BUILDING
 - Ø16mm VERTICALLY DRIVEN 1.5m EXTENSIBLE EARTH ROD
 - CADWELD CONNECTION
 - EARTH LUG CONNECTION
 - TINNED COPPER MAIN EARTH BAR MOUNTED ON WALL 350mm ABOVE TRENCH FLOOR
 - CONNECTION TO SLAB REINFORCEMENT STEEL
 - WALKWAY BONDING EARTH ELECTRODE 1500mm LONG, SOLID COPPER, Ø16mm

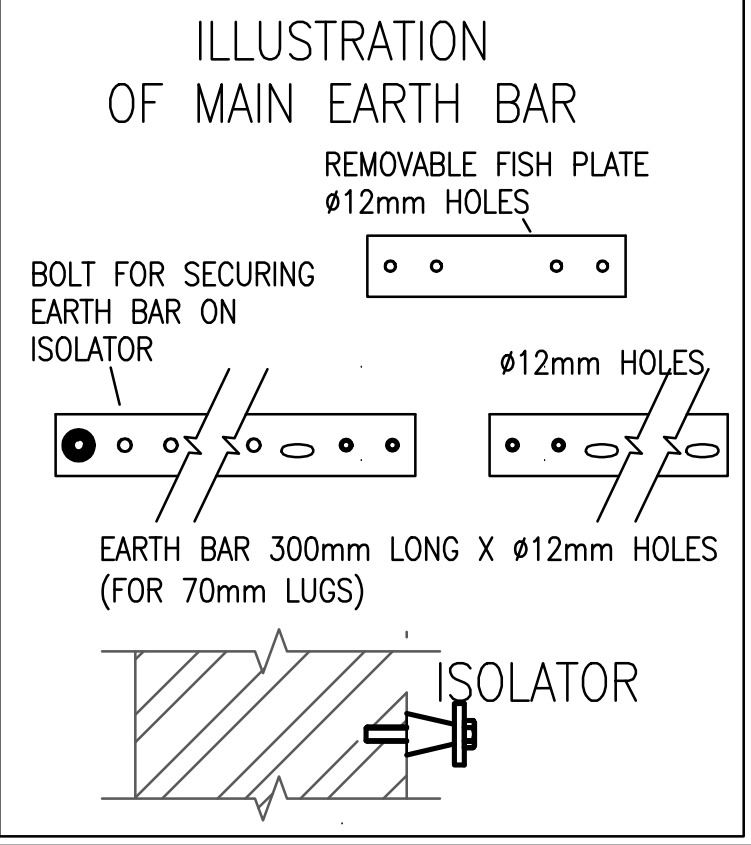

CLIENT
SOUTH AFRICAN NATIONAL BIODIVERSITY INSTITUTE

SANBI
Biodiversity for Life
South African National Biodiversity Institute

REV NO.	DATE	DESCRIPTION
TD	2022-09-26	ISSUED FOR TENDER
A	2022-09-13	ISSUED FOR APPROVAL

REVISIONS

PROJECT CONSULTANT
PROJECTNEERS CONSULTING ENGINEERS & PROJECT MANAGERS

PROJECTNEERS
PROJECTNEERS CONSULTING ENGINEERS & PROJECT MANAGERS
BUILDING 2, 1ST FLOOR, THORNHILL OFFICE PARK
94 BEKKER ROAD, MIDRAND, 1685
+27 11 043 1307
technical@projectneers.com
www.projectneers.com

DRAWING CHECKS			
DESIGNED BY	DRAWN BY	CHECKED BY	APPROVED BY
F.MPOFU			B.MDLULI F.MPOFU

APPROVAL CONSULTANT			
DESIGNED BY	DRAWN BY	CHECKED BY	APPROVED BY
N.K. MPOFU			

PROJECT NAME
ASSESSMENT, DESIGN & PROJECT MANAGEMENT OF REQUIRED NEW BUILDINGS & REPAIRS, RENOVATIONS & UPGRADES TO VARIOUS INFRASTRUCTURE ASSETS IN THE THOHOYANDOU BOTANICAL GARDEN, THOHOYANDOU & NATIONAL ZOOLOGICAL GARDEN CAMPUSES BASED IN PRETORIA & MOKOPANE

SITE
THOHOYANDOU BOTANICAL GARDENS

SHEET TITLE
VISITORS CENTRE
LV RETICULATION LAYOUT
DISCIPLINE
ELECTRICAL

CONTRACT NUMBER
G3062018

FILE NUMBER
ZA2018_2008

SCALE
AS INDICATED

DRAWING NUMBER
PJN_ZA_2022_2002_SANBI_TBG_EE_6301_TD

A1

ISSUED FOR TENDER

THIS DRAWING



SITE PLAN
N.T.S

CLIENT
SOUTH AFRICAN NATIONAL BIODIVERSITY INSTITUTE

SANBI
Biodiversity for Life
South African National Biodiversity Institute

TD	2022-09-26	ISSUED FOR TENDER
A	2022-09-13	ISSUED FOR APPROVAL
REV NO.	DATE	DESCRIPTION

REVISIONS

PROJECT CONSULTANT
PROJECTNEERS CONSULTING ENGINEERS & PROJECT MANAGERS

PROJECTNEERS
PROJECTNEERS CONSULTING ENGINEERS
& PROJECT MANAGERS
BUILDING 2, 1ST FLOOR, THORNHILL OFFICE PARK
94 BEKKER ROAD, MIDRAND, 1685
+27 11 043 1307
technical@projectneers.com
www.projectneers.com

DESIGNED BY	CHECKED BY	DATE	APPROVED BY
F.MPOFU			B.MDLULI

APPROVAL CONSULTANT N.K. MPOFU	DATE	REV	DESCRIPTION
	31-08-2022	20130388	THE MASTER FILE OF THE PROJECTNEERS CONSULTING ENGINEERS & PROJECT MANAGERS IS THE ORIGINAL SOURCE OF APPROVAL.

PROJECT NAME
ASSESSMENT, DESIGN & PROJECT MANAGEMENT OF REQUIRED NEW BUILDINGS & REPAIRS, RENOVATIONS & UPGRADES TO VARIOUS INFRASTRUCTURE ASSETS IN THE THOHOYANDOU BOTANICAL GARDEN, THOHOYANDOU & NATIONAL ZOOLOGICAL GARDEN CAMPUSES BASED IN PRETORIA & MOKOPANE

SITE
THOHOYANDOU BOTANICAL GARDENS

SHEET TITLE
VISITORS CENTRE
DATA SLEEVES RETICULATION LAYOUT
DISCIPLINE
ELECTRICAL

CONTRACT NUMBER
G3062018

FILE NUMBER
ZA2018_2008

SCALE
AS INDICATED

DRAWING NUMBER
PJN_ZA_2022_2002_SANBI_TBG_EE_6302_TD


SITE PLAN – DATA SLEEVES RETICULATION
SCALE 1:250

LEGEND



MANHOLE

PROPOSED 2x ø50mm DATA SLEEVES

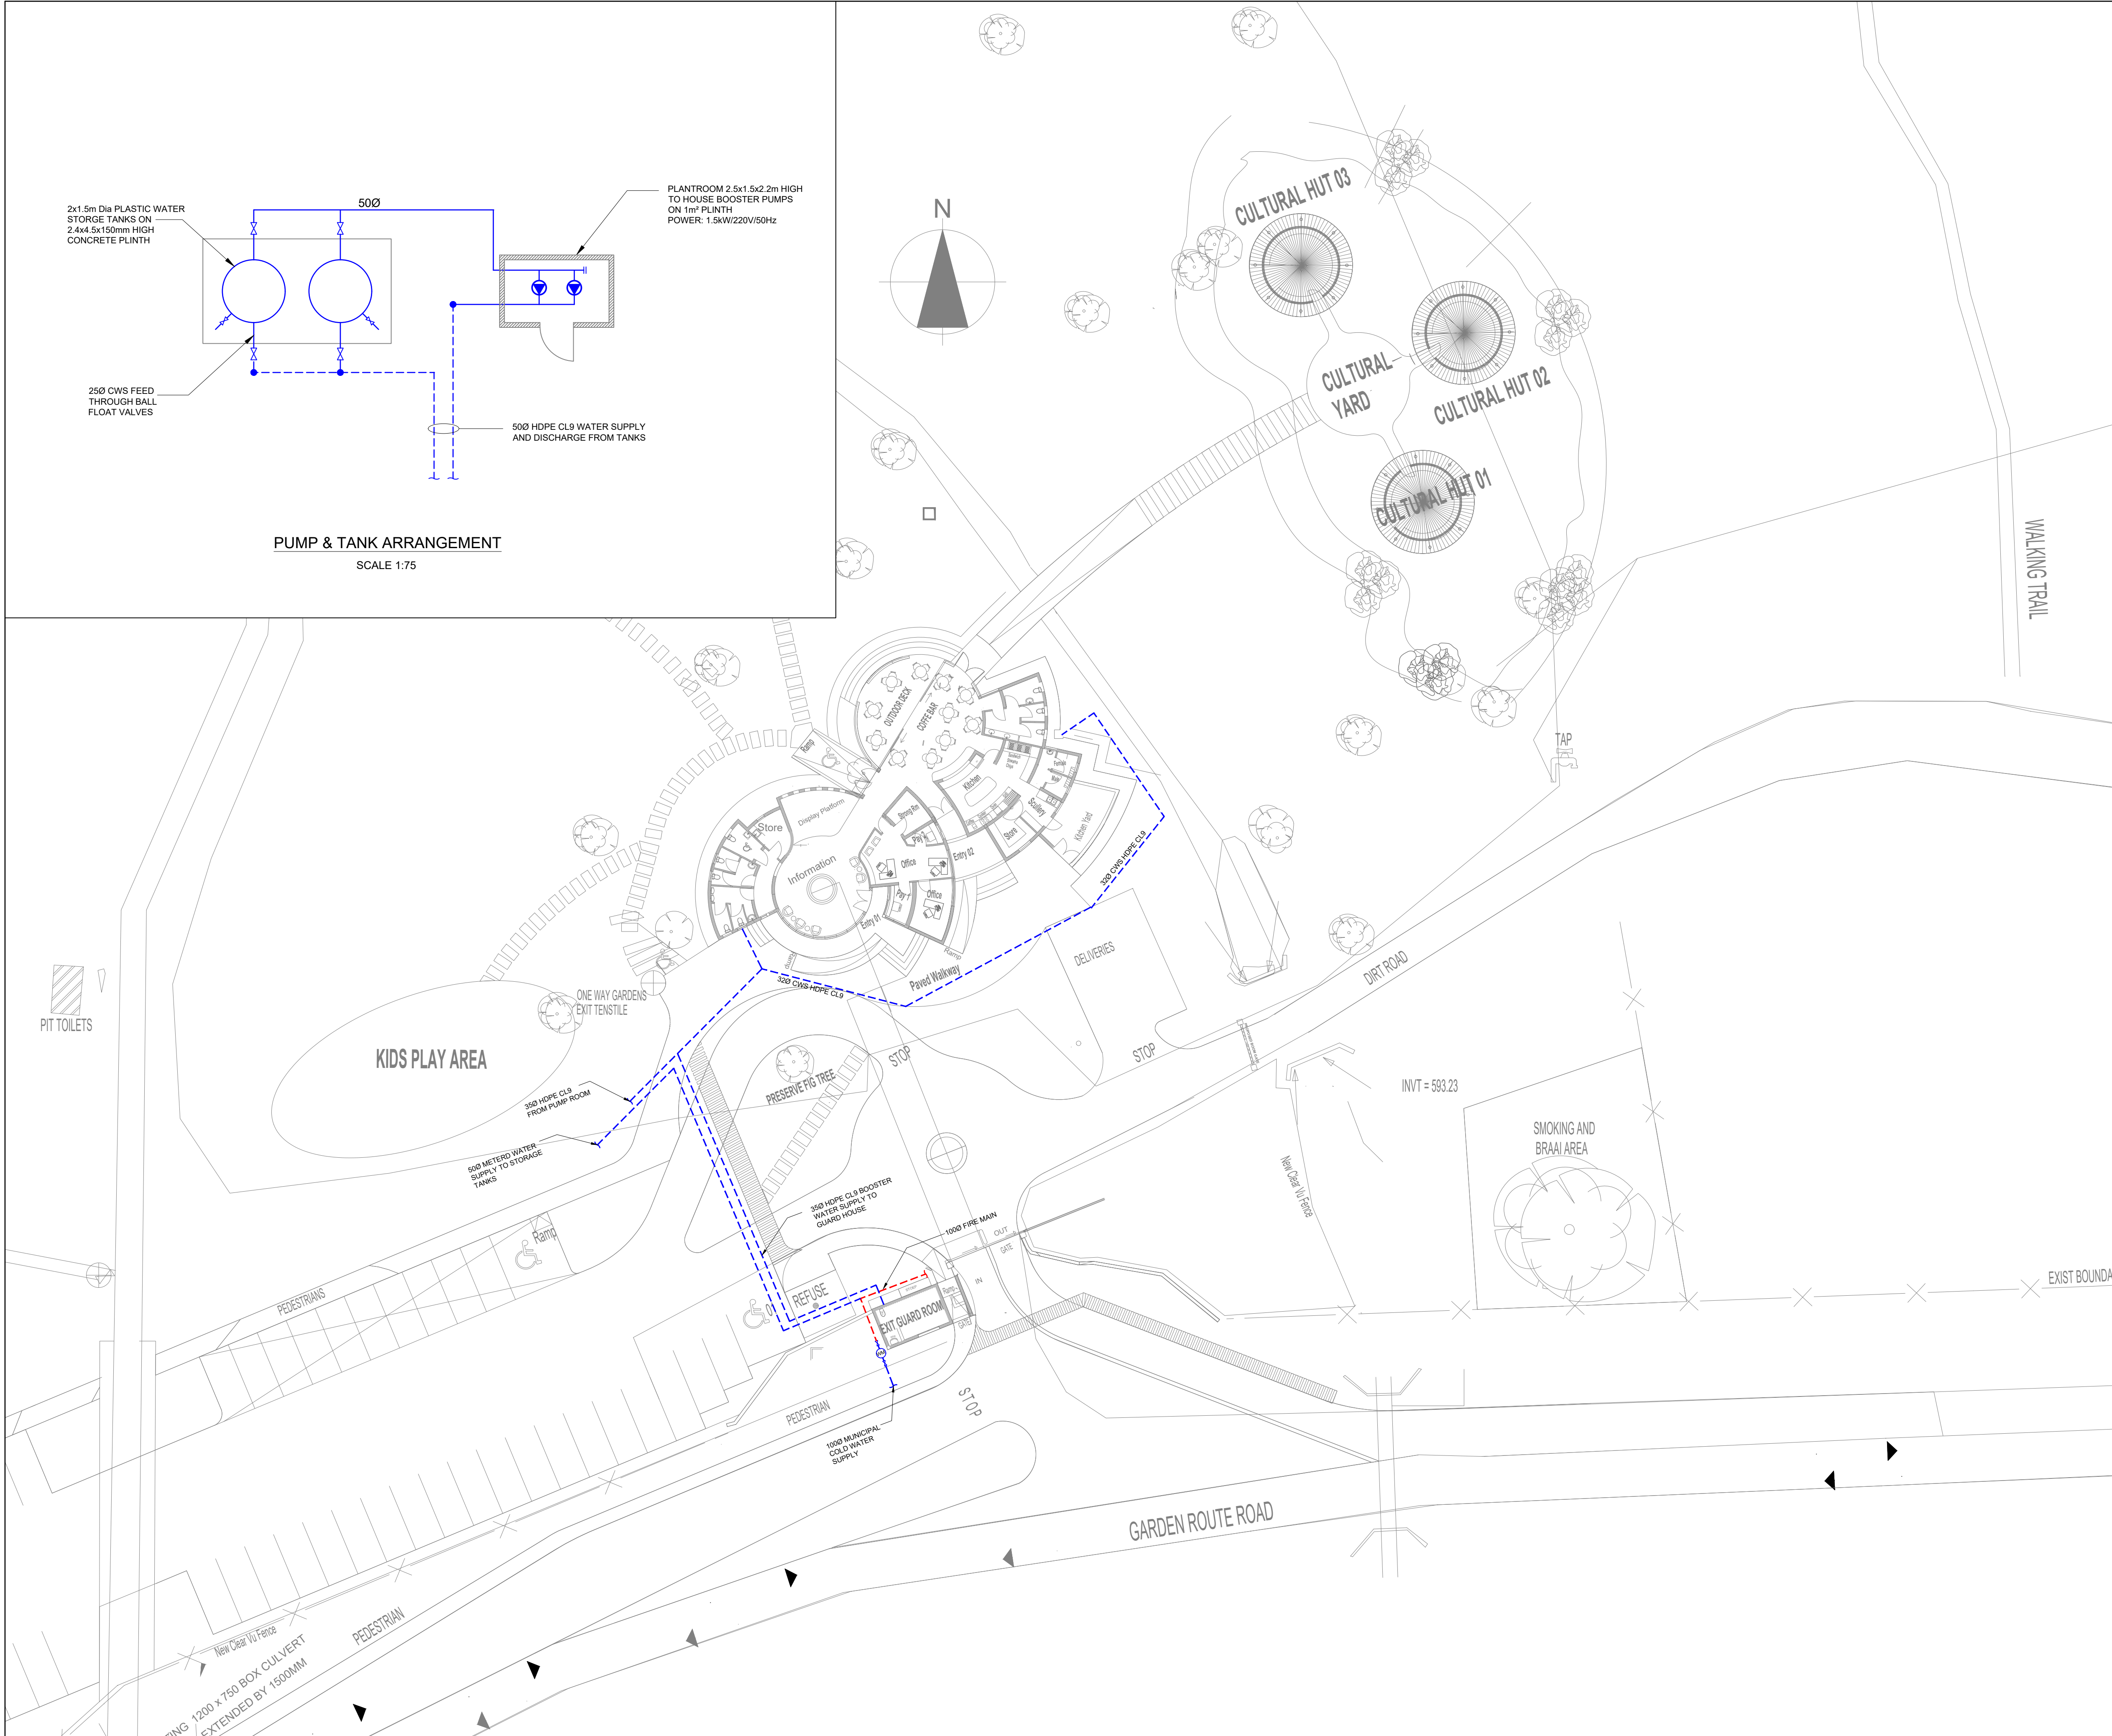

NOTES

1. THIS DRAWING IS TO BE READ IN CONJUNCTION WITH ALL RELEVANT ENGINEERS' DRAWINGS.

2. DO NOT SCALE FROM THE DRAWING. THE CONTRACTOR MUST CHECK AND CONFIRM ALL DIMENSIONS INCLUDING LEVELS ON SITE WITH THE SERVICES ENGINEERS.

3. ANY QUERIES AND/OR DISCREPANCIES MUST BE REFERRED TO THE SERVICES ENGINEER BEFORE MATERIALS ARE ORDERED AND BEFORE EXECUTION ON SITE.

CLIENT

SOUTH AFRICAN NATIONAL BIODIVERSITY INSTITUTE

SANBI

Biodiversity for Life

South African National Biodiversity Institute

REV NO.	DATE	DESCRIPTION
R00	2022-09-13	ISSUED FOR REVIEW.

REVISIONS

PROJECT CONSULTANT

PROJECTNEERS CONSULTING ENGINEERS & PROJECT MANAGERS

PROJECTNEERS

PROJECTNEERS CONSULTING ENGINEERS
& PROJECT MANAGERS

BUILDING 2, 1ST FLOOR, THORNHILL OFFICE PARK
94 BEKKER ROAD, MIDRAND, 1685
+27 11 043 1307

technical@projectneers.com
www.projectneers.com

DRAWING CHECKS

DESIGNED BY	CHECKED BY	DATE	APPROVED BY
S.MUTARINGE	S.MUTARINGE		I.SVODZIWA S.MUTARINGE

APPROVAL CONSULTANT

N.K. MPOFU

DATE	PROJ. REV. NO.	THE MATERIALS HELD AT THE PROJECTNEERS CONSULTING ENGINEERS OFFICE BEARS THE ORIGINAL SIGNATURE OF APPROVAL.
31-08-2022	20130388	

PROJECT NAME

ASSESSMENT, DESIGN & PROJECT MANAGEMENT OF REQUIRED NEW BUILDINGS & REPAIRS, RENOVATIONS & UPGRADES TO VARIOUS INFRASTRUCTURE ASSETS IN THE THOHOYANDOU BOTANICAL GARDEN, THOHOYANDOU, & NATIONAL ZOOLOGICAL GARDEN CAMPUSES BASED IN PRETORIA & MOKOPANE

SITE

THOHOYANDOU BOTANICAL GARDENS

SHEET TITLE

VISITORS CENTRE
SITE WATER SUPPLY RETICULATION LAYOUT
DISCIPLINE
MECHANICAL

CONTRACT NUMBER

G306/2018

FILE NUMBER

ZA2018_2008


DRAWING NUMBER

PJN_ZA_2022_2002_SANBI_TBG_ME_5002_R00

SCALE

1:250

A1

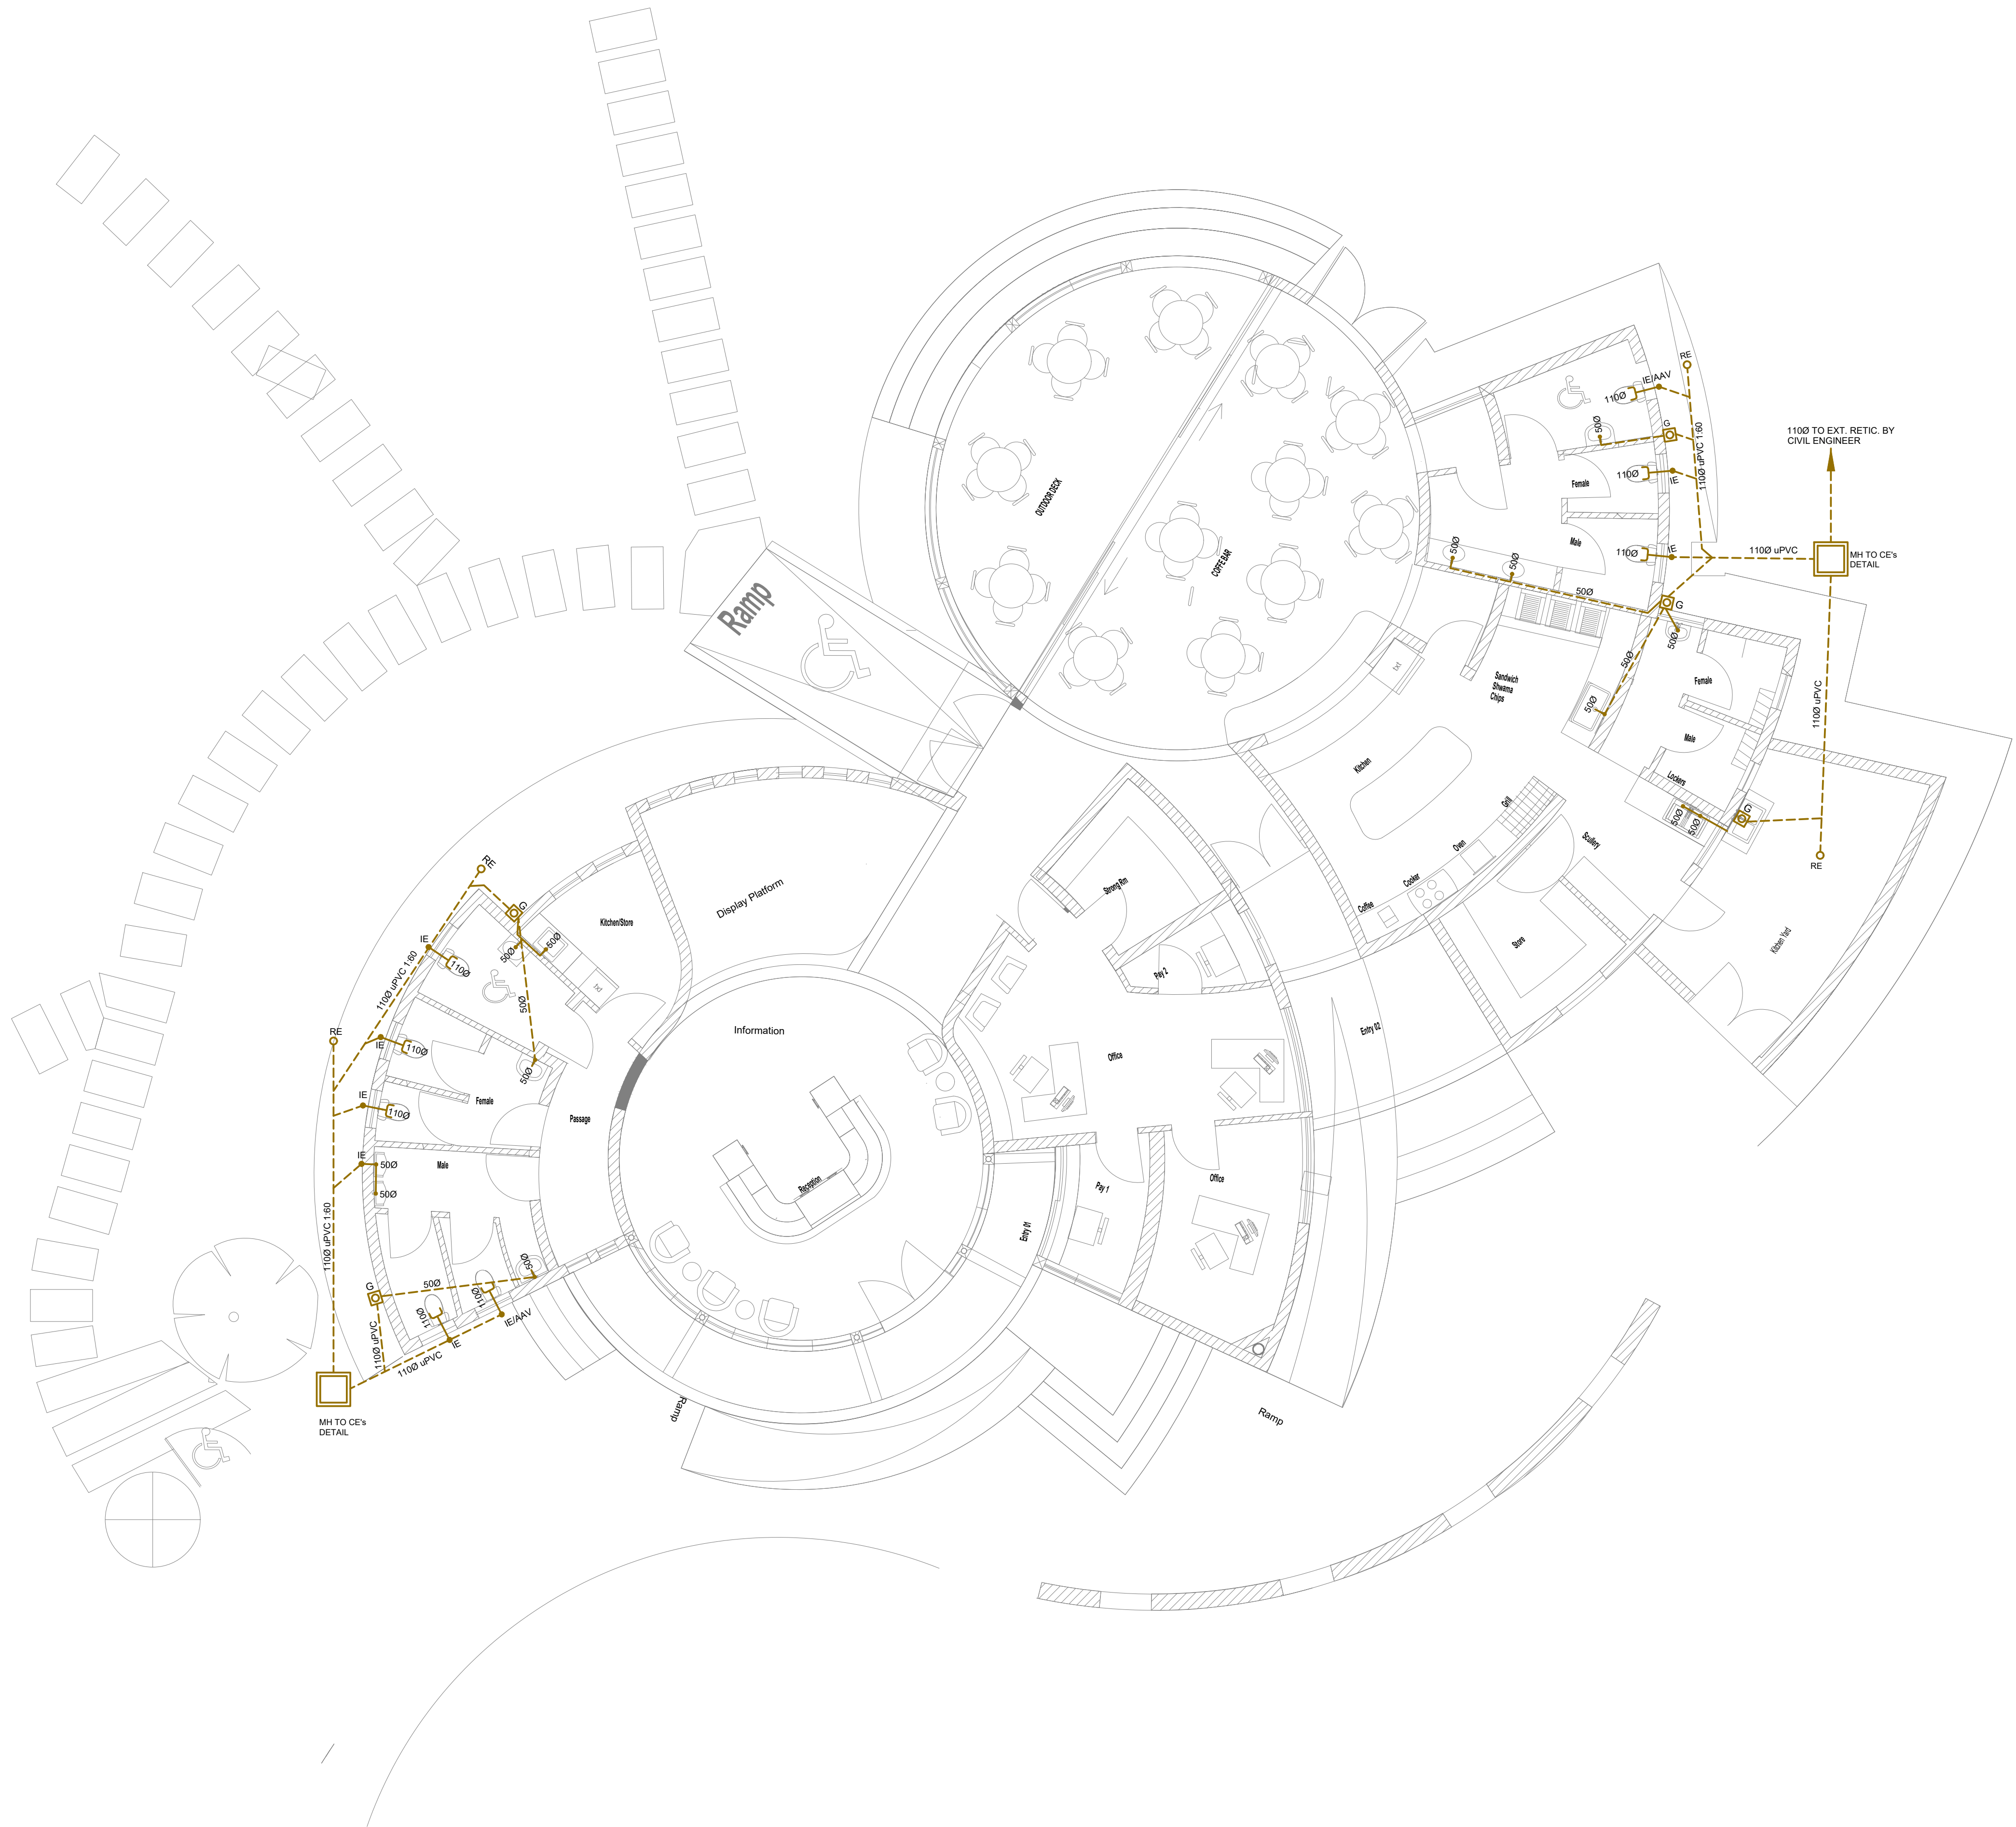

- NOTES
1. THIS DRAWING IS TO BE READ IN CONJUNCTION WITH ALL RELEVANT ENGINEERS' DRAWINGS.
 2. DO NOT SCALE FROM THIS DRAWING. THE CONTRACTOR MUST CHECK AND CONFIRM ALL DIMENSIONS INCLUDING LEVELS ON SITE WITH THE SERVICES ENGINEERS.
 3. ANY QUERIES AND/OR DISCREPANCIES MUST BE REFERRED TO THE SERVICES ENGINEER BEFORE MATERIALS ARE ORDERED AND BEFORE EXECUTION ON SITE.
 4. ALL PORTABLE WATER PIPEWORK ABOVE GROUND TO BE COPPER SANS 490 UNLESS OTHERWISE NOTED. UNDERGROUND PIPES TO BE HDPE.
 5. DRAINAGE & WATER INSTALLATION TO BE IN ACCORDANCE TO SANS 10252-2 AND SANS 10252-1.
 6. ALL DOMESTIC HOT WATER SUPPLY & STORAGE VESSELS PIPES TO BE INSULATED TO SANS 10400-XA AND SANS 204.
 7. DRAINAGE/WASTE PIPES TO BE IN UPVC TO SANS 967.
 8. DRAINAGE PIPE OUTSIDE BUILDING SHOWN FOR GUIDANCE ONLY. REFER TO CIVIL ENGINEERS' DRAWINGS FOR DETAIL.

DRAINAGE LEGEND	
	PIPE AT HIGH LEVEL
	PIPE BELOW GROUND
	PIPE ABOVE GROUND
	DIRECTION OF FLOW
	TRAPPED GULLY
	DOUBLE SEAL STAINLESS STEEL FLOOR DRAIN
	RODDING EYE
	CLEANING EYE
	AIR ADMITTANCE VALVE
	VENT COWL
	WASTE PIPE
	VENT PIPE
	PIPE RISER
	PIPE DROPPER

CLIENT

SOUTH AFRICAN NATIONAL BIODIVERSITY INSTITUTE



SANBI
Biodiversity for Life
South African National Biodiversity Institute

REV NO.	DATE	DESCRIPTION
R00	2022-09-13	ISSUED FOR REVIEW.

REVISIONS

PROJECT CONSULTANT

PROJECTNEERS CONSULTING ENGINEERS & PROJECT MANAGERS

PROJECTNEERS

PROJECTNEERS CONSULTING ENGINEERS
& PROJECT MANAGERS
BUILDING 2, 1ST FLOOR, THORNHILL OFFICE PARK
94 BEKKER ROAD, MIDRAND, 1685
+27 11 043 1307
technical@projectneers.com
www.projectneers.com

DRAWING CHECKS	DESIGNED BY	CHECKED BY	APPROVED BY
S.MUTARANGE	S.MUTARANGE	I.SVODZIWA	S.MUTARANGE

APPROVAL CONSULTANT	DATE	PROJ. REV. NO.	THE SIGNATURE OF THE PROJECTNEERS CONSULTING ENGINEERS OFFICE BEARS THE ORIGINAL SIGNATURE OF APPROVAL
N.K. MPOFU	31-08-2022	20130388	

PROJECT NAME

ASSESSMENT, DESIGN & PROJECT MANAGEMENT OF REQUIRED NEW BUILDINGS & REPAIRS, RENOVATIONS & UPGRADES TO VARIOUS INFRASTRUCTURE ASSETS IN THE THOHOYANDOU BOTANICAL GARDEN, THOHOYANDOU, & NATIONAL ZOOLOGICAL GARDEN CAMPUSES BASED IN PRETORIA & MOKOPANE

SITE

THOHOYANDOU BOTANICAL GARDENS

SHEET TITLE

VISITORS CENTRE
DRAINAGE LAYOUT
DISCIPLINE
MECHANICAL

CONTRACT NUMBER

G306/2018

FILE NUMBER


ZA2018_2008

SCALE


1:75

DRAWING NUMBER	DATE	REV.	BY	CHKD.	APPD.	DATE
PJN_ZA_2022_2002_SANBI_TB_G_ME_5004_R00						

A1

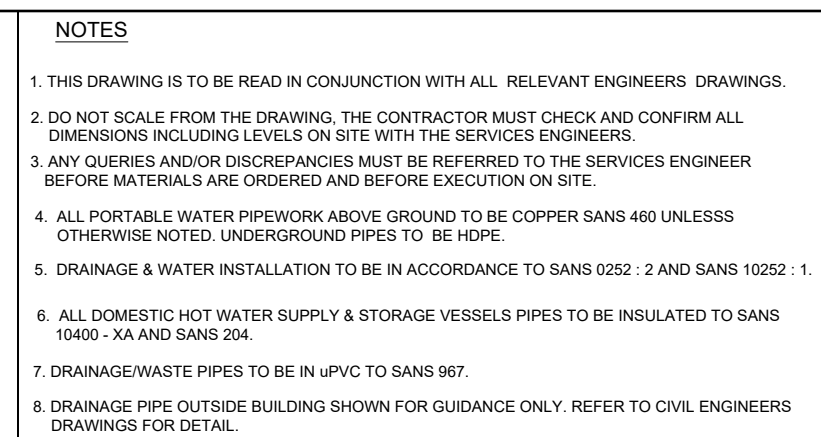

WATER LEGEND

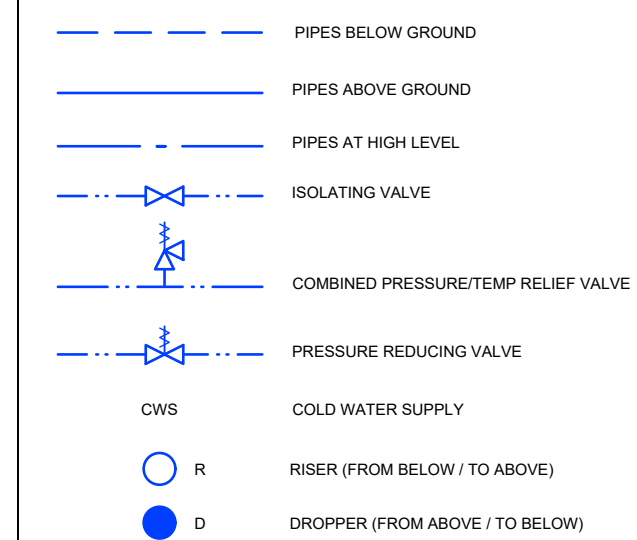

CLIENT

SOUTH AFRICAN NATIONAL BIODIVERSITY INSTITUTE

SANBI

Biodiversity for Life

South African National Biodiversity Institute



R00	2022-09-13	ISSUED FOR REVIEW.
REV NO.	DATE	DESCRIPTION

REVISIONS

PROJECT CONSULTANT

PROJECTNEERS CONSULTING ENGINEERS & PROJECT MANAGERS

PROJECTNEERS

PROJECTNEERS CONSULTING ENGINEERS
& PROJECT MANAGER

BUILDING 2, 1ST FLOOR, THORNHILL OFFICE PARK
94 BEKKER ROAD, MIDRAND, 1685
+27 11 043 1307

technical@projectneers.com
www.projectneers.com

DRAWING CHECKS

DRAWING CHECKS			
DESIGNED BY	DESIGN CHECKED BY	DRAWN BY	DRAWING CHECKED BY
S.MUTARINGE	S.MUTARINGE	I.SVODZIWA	S.MUTARINGE

APPROVAL CONSULTANT

DATE: 31-08-2022 PROJECT NO: 20130388

PROJECT NAME

ASSESSMENT, DESIGN & PROJECT MANAGEMENT OF REQUIRED NEW BUILDINGS & REPAIRS, RENOVATIONS & UPGRADES TO VARIOUS INFRASTRUCTURE ASSETS IN THE THOHOYANDOU BOTANICAL GARDEN, THOHOYANDOU, & NATIONAL ZOOLOGICAL GARDEN CAMPUSES BASED IN PRETORIA & MOKOPANE

SITE

THOHOYANDOU BOTANICAL GARDENS

SHEET TITLE

SHEET TITLE	VISITORS CENTRE WATER SUPPLY LAYOUT
DISCIPLINE	MECHANICAL

CONTRACT NUMBER

G306/2018



FILE NUMBER

FILE NUMBER
ZA2018 2008

DRAWING NUMBER

ORIG	STATE	YEAR	PROJ NO	CLIENT	SITE	ROLE	SIGNAL NO	REV	SHEET SIZE
PJN	ZA	2022	2002	SANBI	TBG	ME	5005	R00	A1

SCHEDULE OF HVAC EQUIPMENT				
REF	QTY	TYPE	CAPACITY	POWER REQ"D kW/V/Hz
AC01	2	HEAT PUMP CASSETTE	7.0 kW	3.0/220/50Hz
ACO2	1	HIDEAWAY HEAT PUMP	7.0 kW	3.0/220/50Hz
SD01	5	RADIAL DIFFUSER	150 l/s	600x600
FAF01	1	1NLINE FAN	50 l/s	150W/220/50Hz

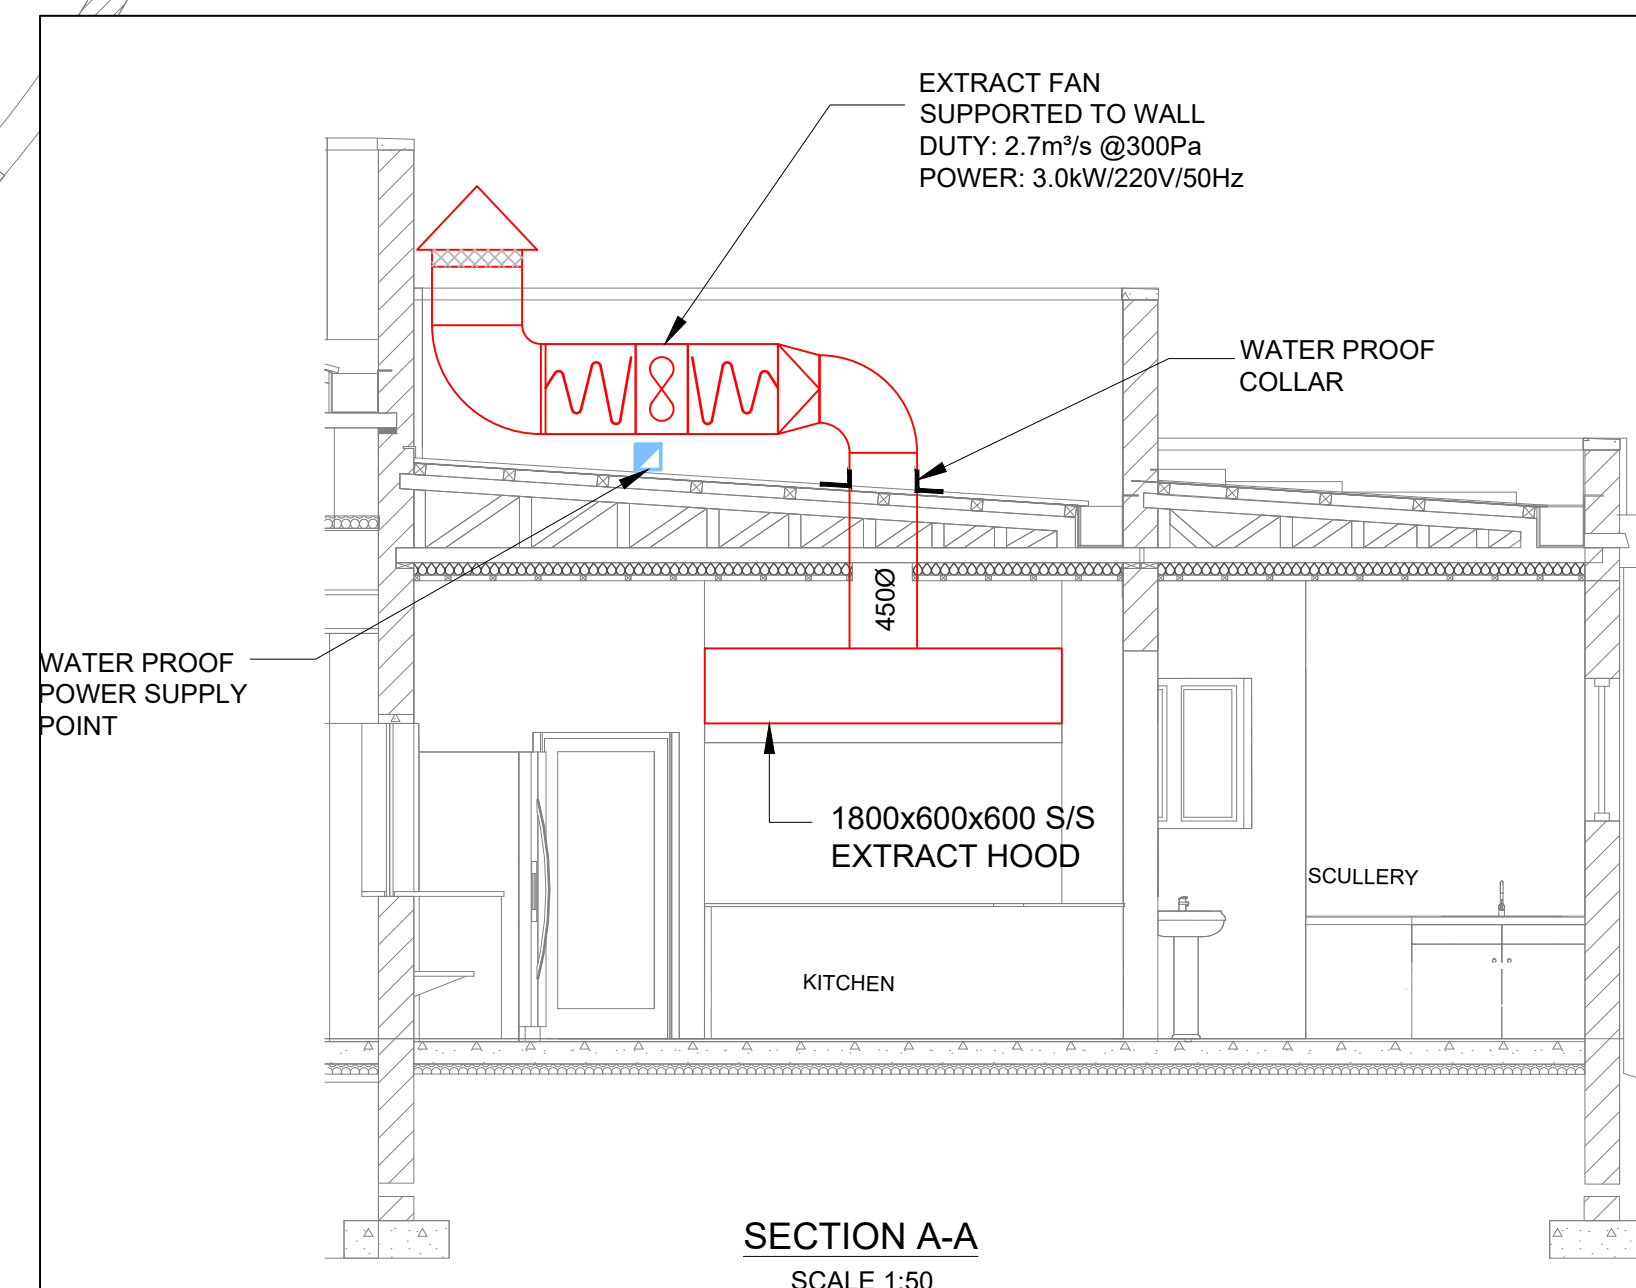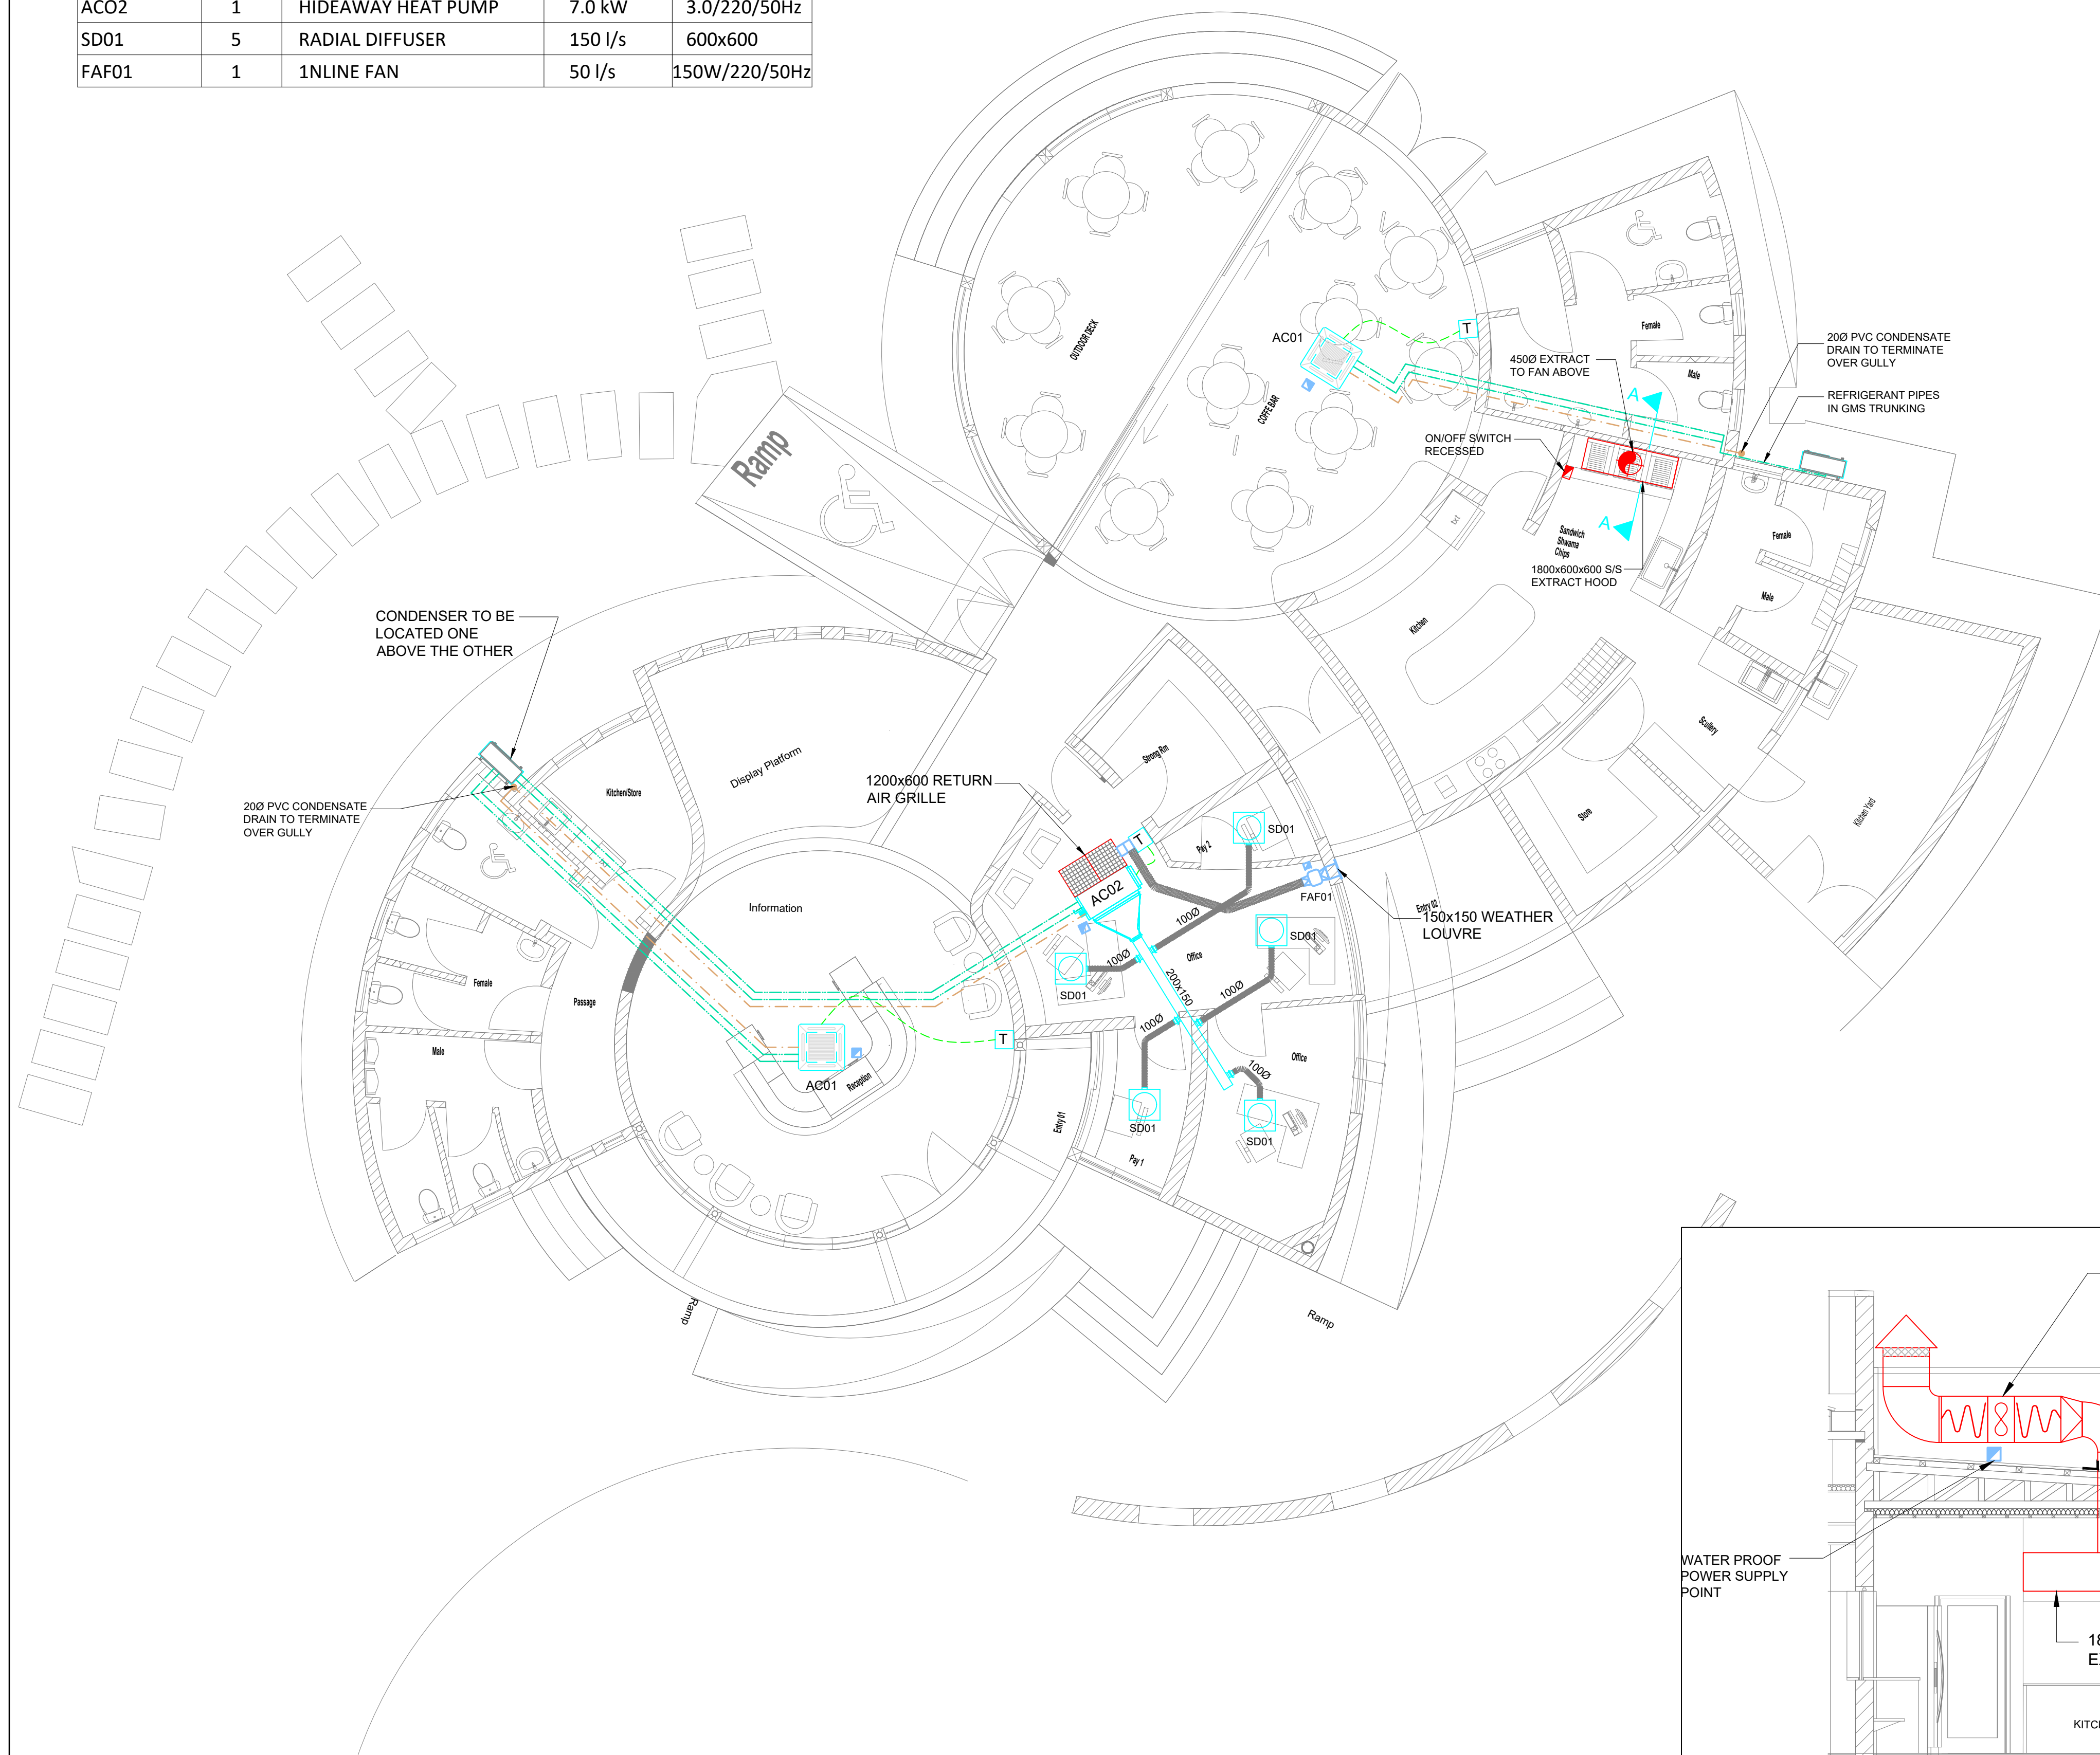

NOTES

1. THIS DRAWING IS TO BE READ IN CONJUNCTION WITH ALL RELEVANT ENGINEERS' DRAWINGS.
2. DO NOT SCALE FROM THE DRAWING, THE CONTRACTOR MUST CHECK AND CONFIRM ALL DIMENSIONS INCLUDING LEVELS ON SITE WITH THE SERVICES ENGINEERS.
3. ANY QUERIES AND/OR DISCREPANCIES MUST BE REFERRED TO THE SERVICES ENGINEER BEFORE MATERIALS ARE ORDERED AND BEFORE EXECUTION ON SITE.

T	HARD WIRED CONTROLLER 1500mm AFFL
---	-----------------------------------

 POWER POINT

FD	FIRE DAMPER
----	-------------

CLIENT

SOUTH AFRICAN NATIONAL BIODIVERSITY INSTITUTE

SANBI
Biodiversity for Life
South African National Biodiversity Institute

R00	2022-09-13	ISSUED FOR REVIEW.
REV NO.	DATE	DESCRIPTION

REVISIONS

PROJECT CONSULTANT

PROJECTNEERS CONSULTING ENGINEERS & PROJECT MANAGERS

PROJECTNEERS

**PROJECTNEERS CONSULTING ENGINEERS
& PROJECT MANAGERS**
BUILDING 2, 1ST FLOOR, THORNHILL OFFICE PARK
94 BEKKER ROAD, MIDRAND, 1685
+27 11 043 1307

technical@projectneers.com
www.projectneers.com

DRAWING CHECKS

DESIGNED BY	DESIGN CHECKED BY	DRAWN BY	DRAWING CHECKED BY
S.MUTARINGE	S.MUTARINGE	I.SVODZIWA	S.MUTARINGE

APPROVAL CONSULTANT

N.K. MPOFU

DATE	PROJ REG NO.	THE MASTER HELD AT THE PROJECTEERS CONSULTING MIDRAND OFFICE BEARS THE ORIGINAL SIGNATURE OF APPROVAL
31-08-2022	20130388	

PROJECT NAME

ASSESSMENT, DESIGN & PROJECT MANAGEMENT OF REQUIRED NEW BUILDINGS & REPAIRS, RENOVATIONS & UPGRADES TO VARIOUS INFRASTRUCTURE ASSETS IN THE TJOHOYANDOU BOTANICAL GARDEN, TJOHOYANDOU, & NATIONAL ZOOLOGICAL GARDEN CAMPUSES BASED IN PRETORIA & MOKOPANE

SITE
THOHOYANDOU BOTANICAL GARDENS

SHEET TITLE


VISITORS CENTRE - HVAC LAYOUT

DISCIPLINE
MECHANICAL

CONTRACT NUMBER
G306/2018

FILE NUMBER	SCALE
ZA2018 2008	1:75

DRAWING NUMBER										SHEET SIZE
ORG	STATE	YEAR	PROJ. NO.	CLIENT	SITE	ROUTE	SERIAL NO.	REV		
PJN	ZA	2022	2002	SANBI	TBG	ME	5006	R00		A1

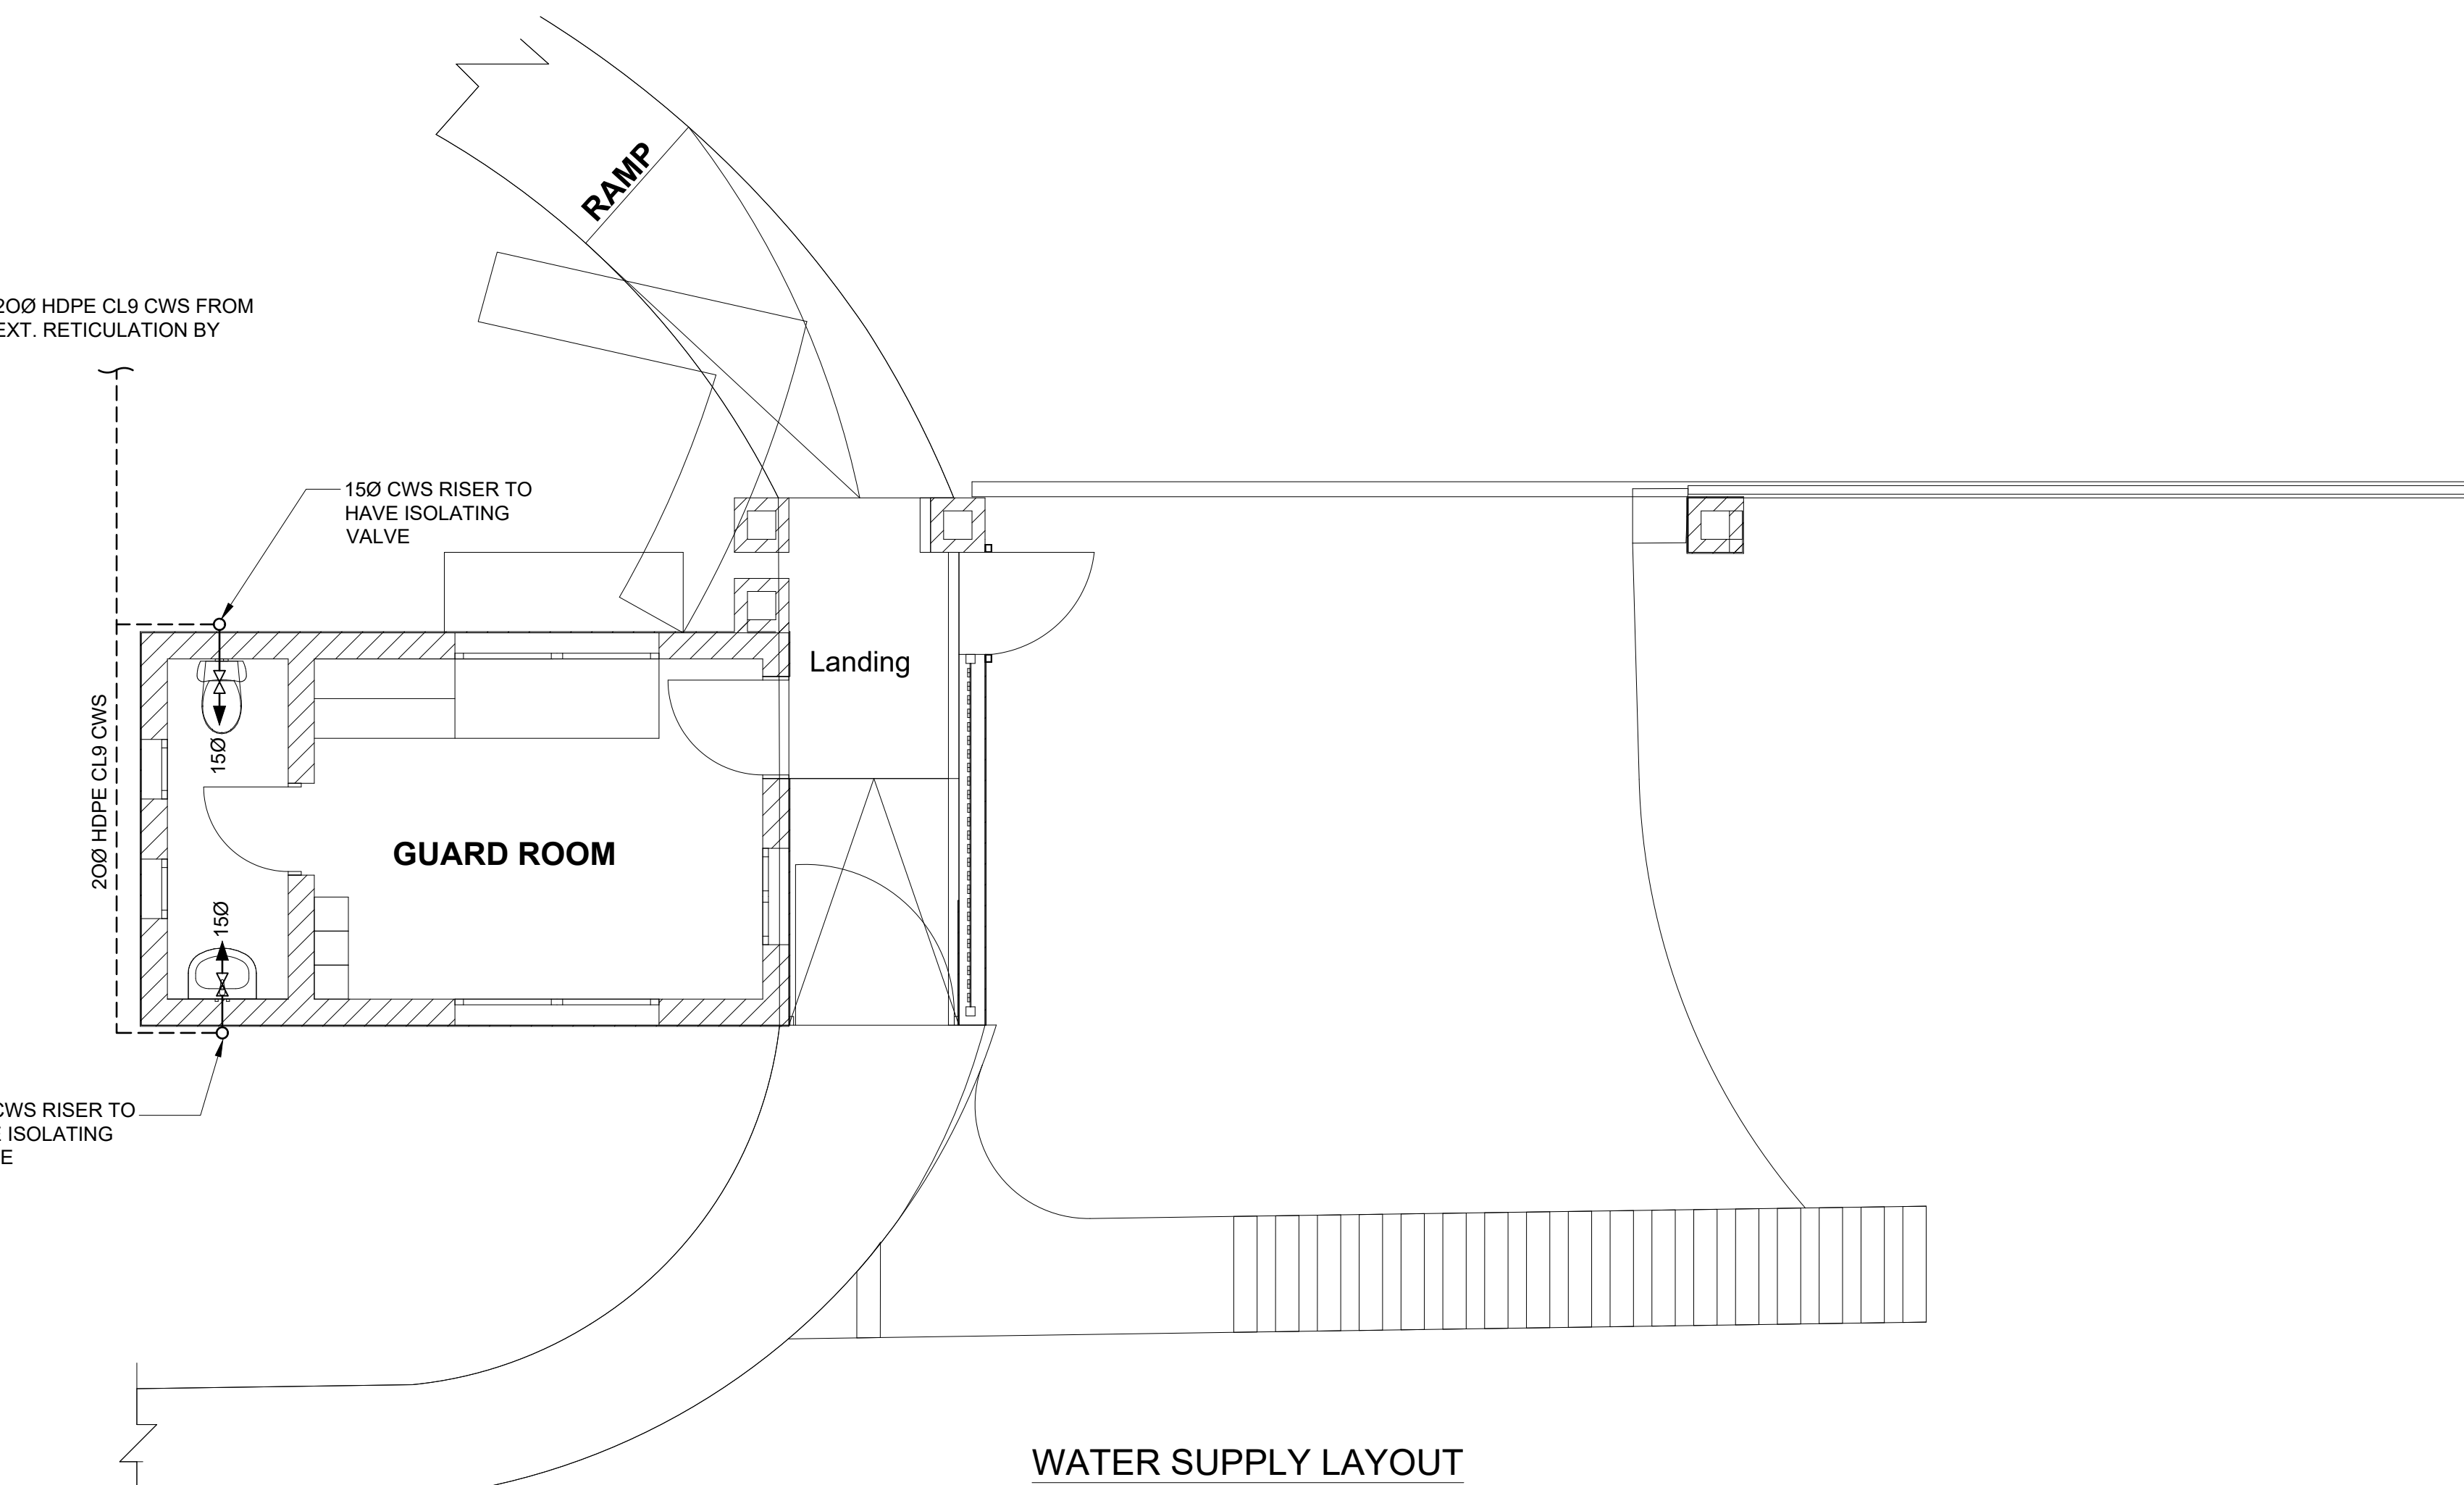

- ### DRAINAGE LEGEND
- | | |
|--|----------------------|
|  | VERTICAL DROP |
|  | PIPE BELOW GROUND |
|  | PIPE ABOVE GROUND |
|  | DIRECTION OF FLOW |
| G | TRAPPED GULLY |
| RW | RODDING WAY |
| IE  | INSPECTION EYE |
| AAV | AIR ADMITTANCE VALVE |
-
- ### WATER LEGEND
- | | |
|---|-----------------------------------|
|  | ISOLATING VALVE |
|  | R RISER (FROM BELOW / TO ABOVE) |
|  | D DROPPER (FROM ABOVE / TO BELOW) |

CLIENT
SOUTH AFRICAN NATIONAL BIODIVERSITY INSTITUTE



R00	2022-09-13	ISSUED FOR REVIEW.
REV NO.	DATE	DESCRIPTION
REVISIONS		

PROJECT CONSULTANT
PROJECTNEERS CONSULTING ENGINEERS & PROJECT MANAGERS

PROJECTNEERS

PROJECTNEERS CONSULTING ENGINEERS
& PROJECT MANAGERS

BUILDING 2, 1ST FLOOR, THORNHILL OFFICE PARK
94 BEKKER ROAD, MIDRAND, 1685
+27 11 043 1307

technical@projectneers.com
www.projectneers.com

DRAWING CHECKS			
DESIGNED BY	DESIGN CHECKED BY	DRAWN BY	DRAWING CHECKED BY
S.MUTARINGE	S.MUTARINGE	I.SVODZIWA	S.MUTARINGE

APPROVAL CONSULTANT
N.K. MPOFU

DATE	PROJ. REG. NO.	THE MASTER HELD AT THE PROJECT/NEEDS CONSULTING MIDLAND OFFICE BEARS THE ORIGINAL SIGNATURE OF APPROVAL
31-08-2022	20130388	

PROJECT NAME
ASSESSMENT, DESIGN & PROJECT MANAGEMENT OF REQUIRED NEW BUILDINGS & REPAIRS, RENOVATIONS & UPGRADES TO VARIOUS INFRASTRUCTURE ASSETS IN THE THOHOYANDOU BOTANICAL GARDEN, THOHOYANDOU, & NATIONAL ZOOLOGICAL GARDEN CAMPUSES BASED IN PRETORIA & MOKOPANE

SITE	THOHYANDOU BOTANICAL GARDENS
-------------	------------------------------

SHEET TITLE
GUARD HOUSE WET SERVICES LAYOUT
DISCIPLINE
MECHANICAL

CONTRACT NUMBER	G306/2018
-----------------	-----------

FILE NUMBER	SCALE
ZA2018 2008	1:50

DRAWING NUMBER									
ORG	EST/5	YEAR	PROJ. NO.	CUSTOMER	SITE	ROLL	SERIAL NO.	REV	DATE/ISS
PJN	ZA	2022	2002	SANBI	TBG	ME	5005	R00	AT