




RESERVOIR INLET CHAMBER

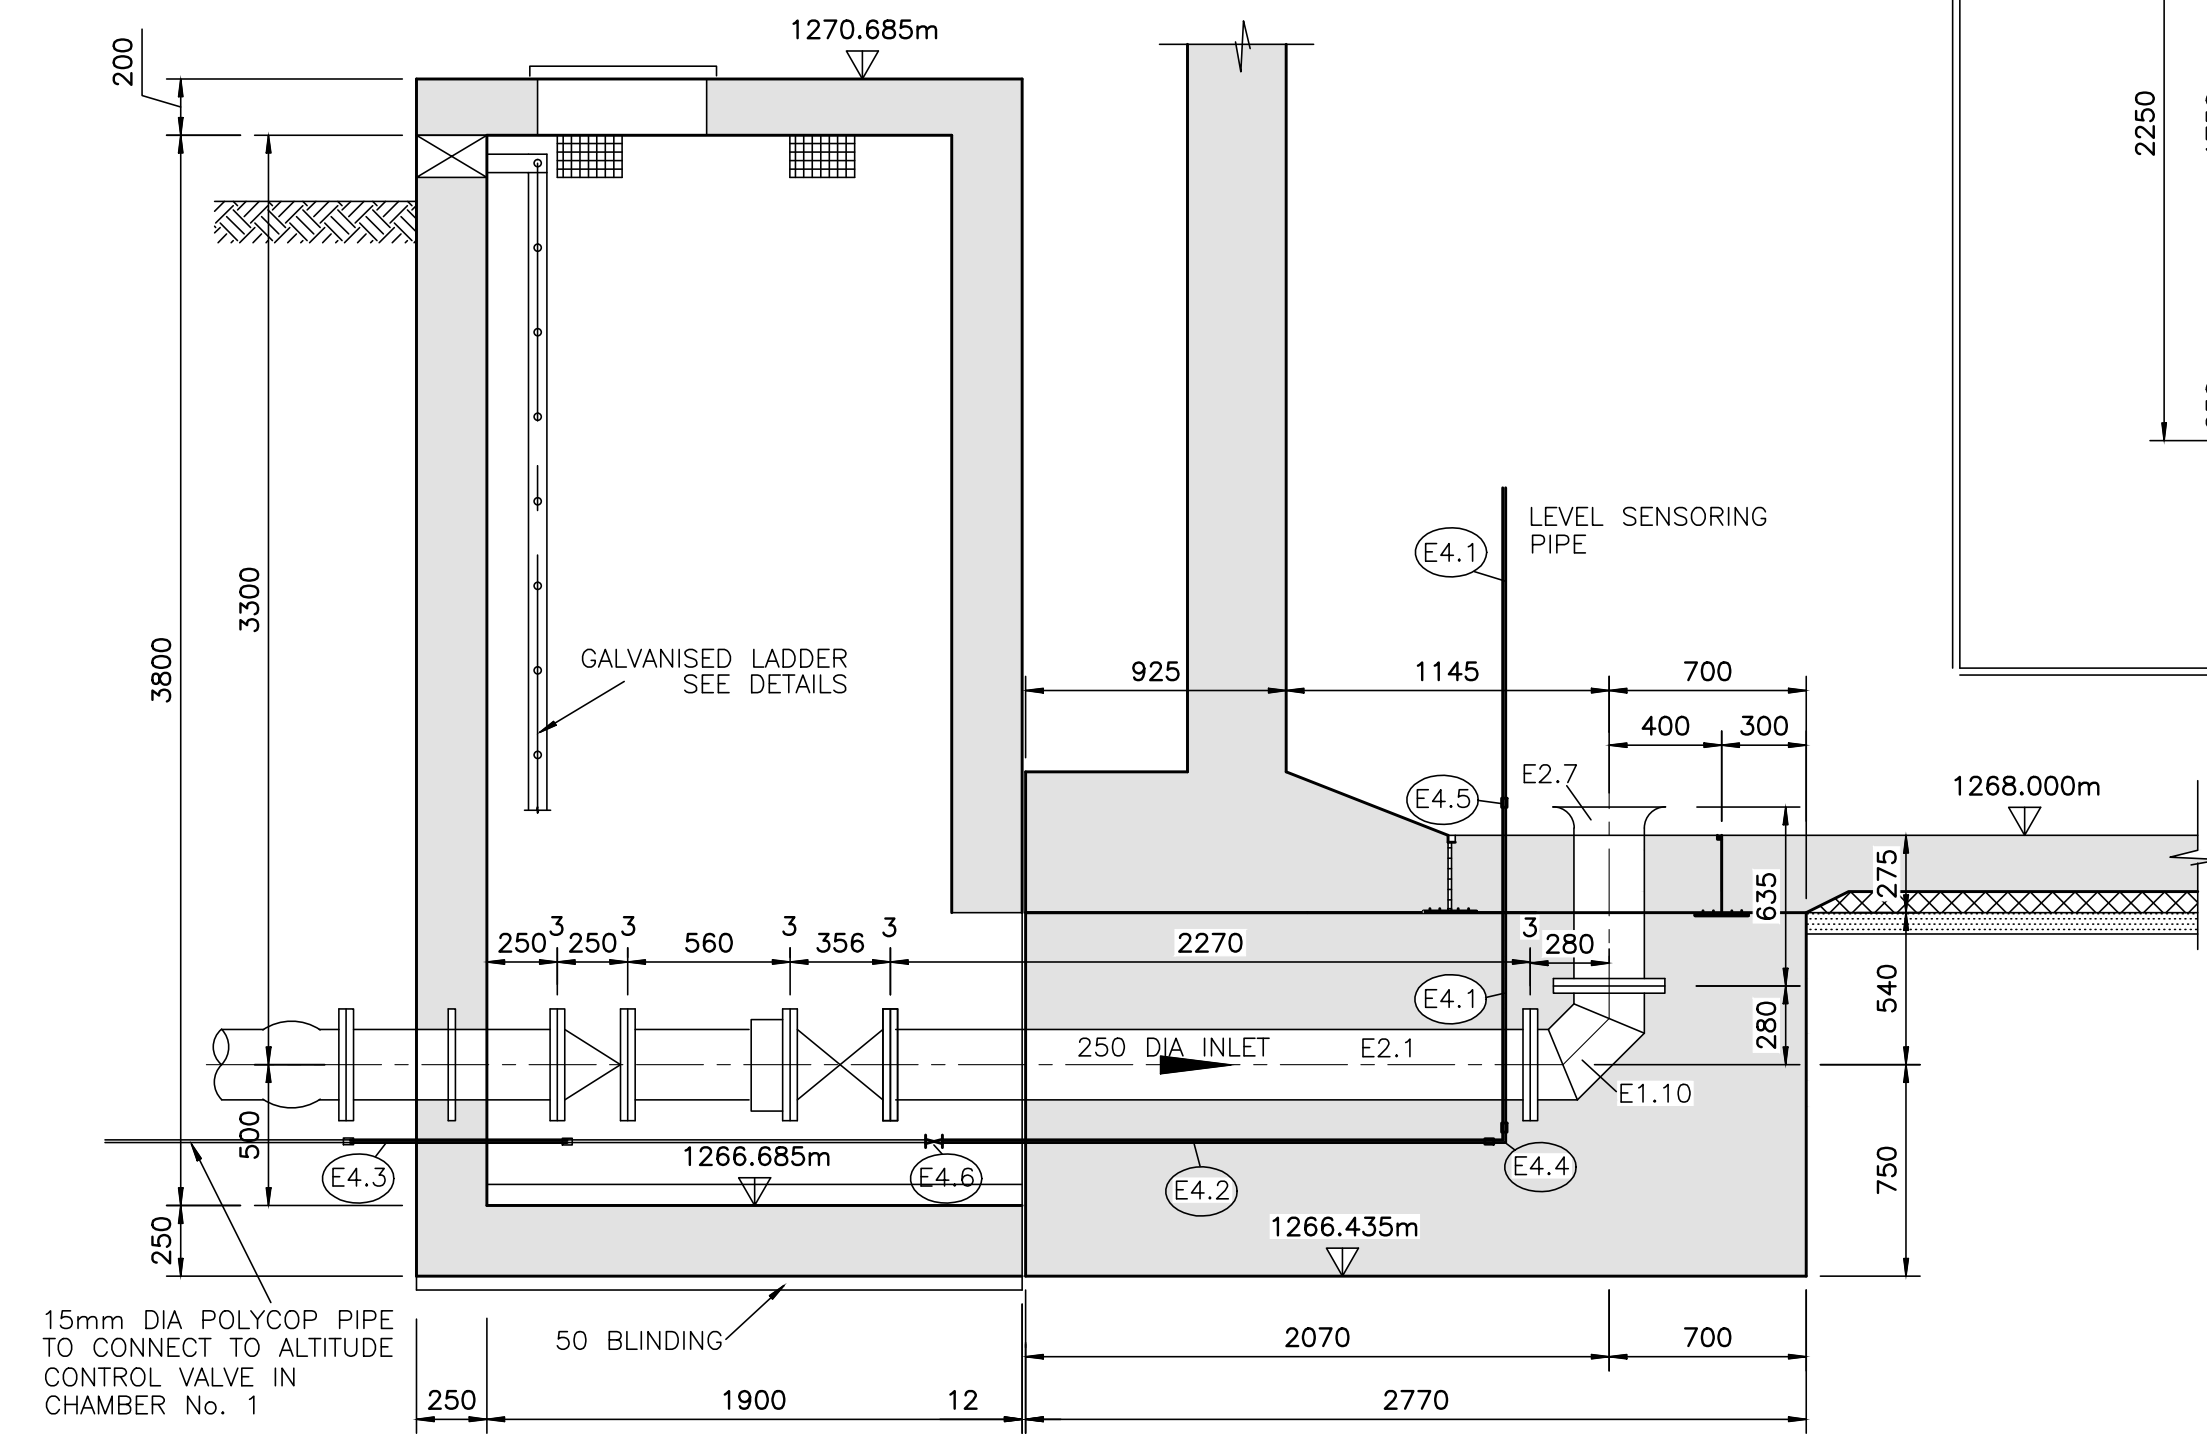


SECTION B - B
1 : 25

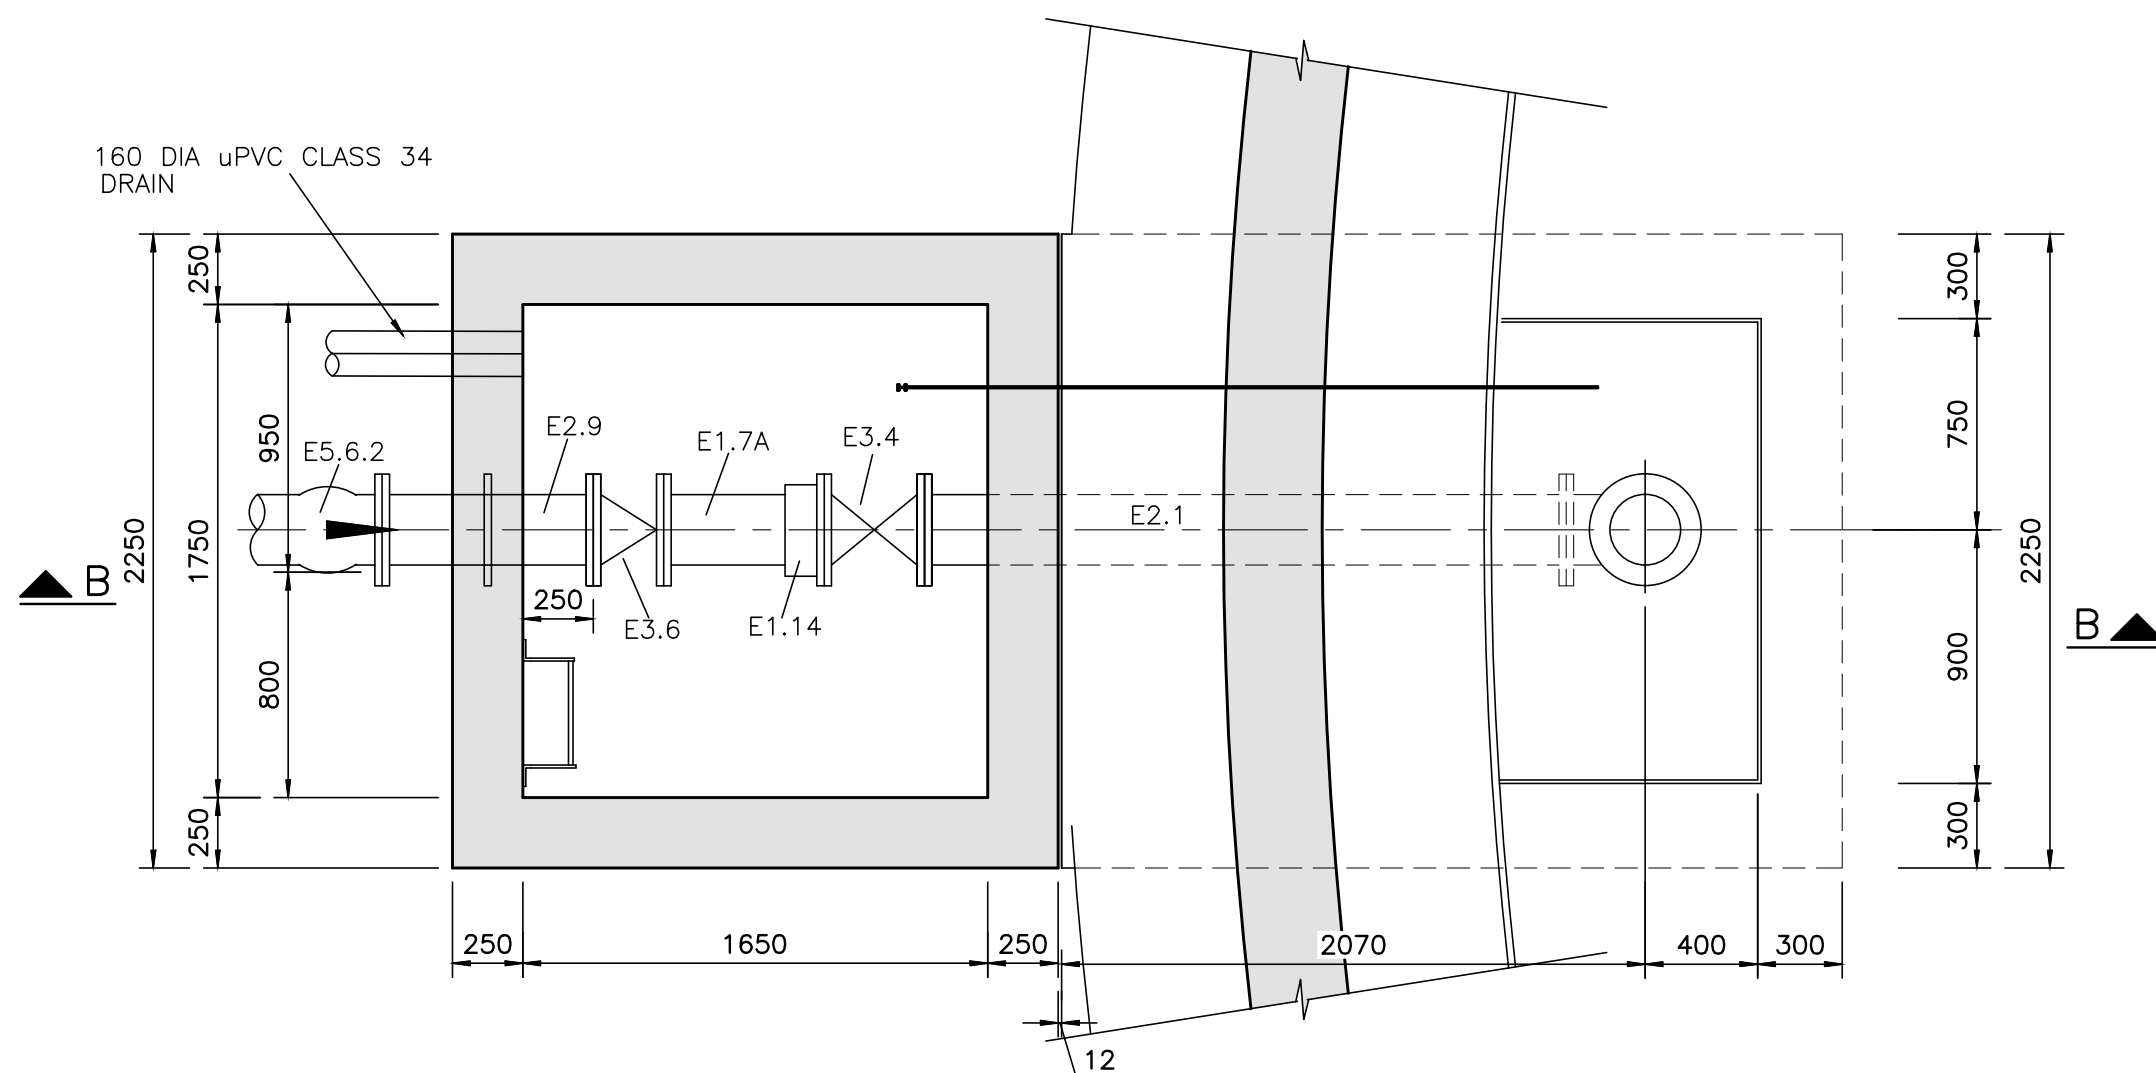

SECTIONAL PLAN A - A
1 : 25

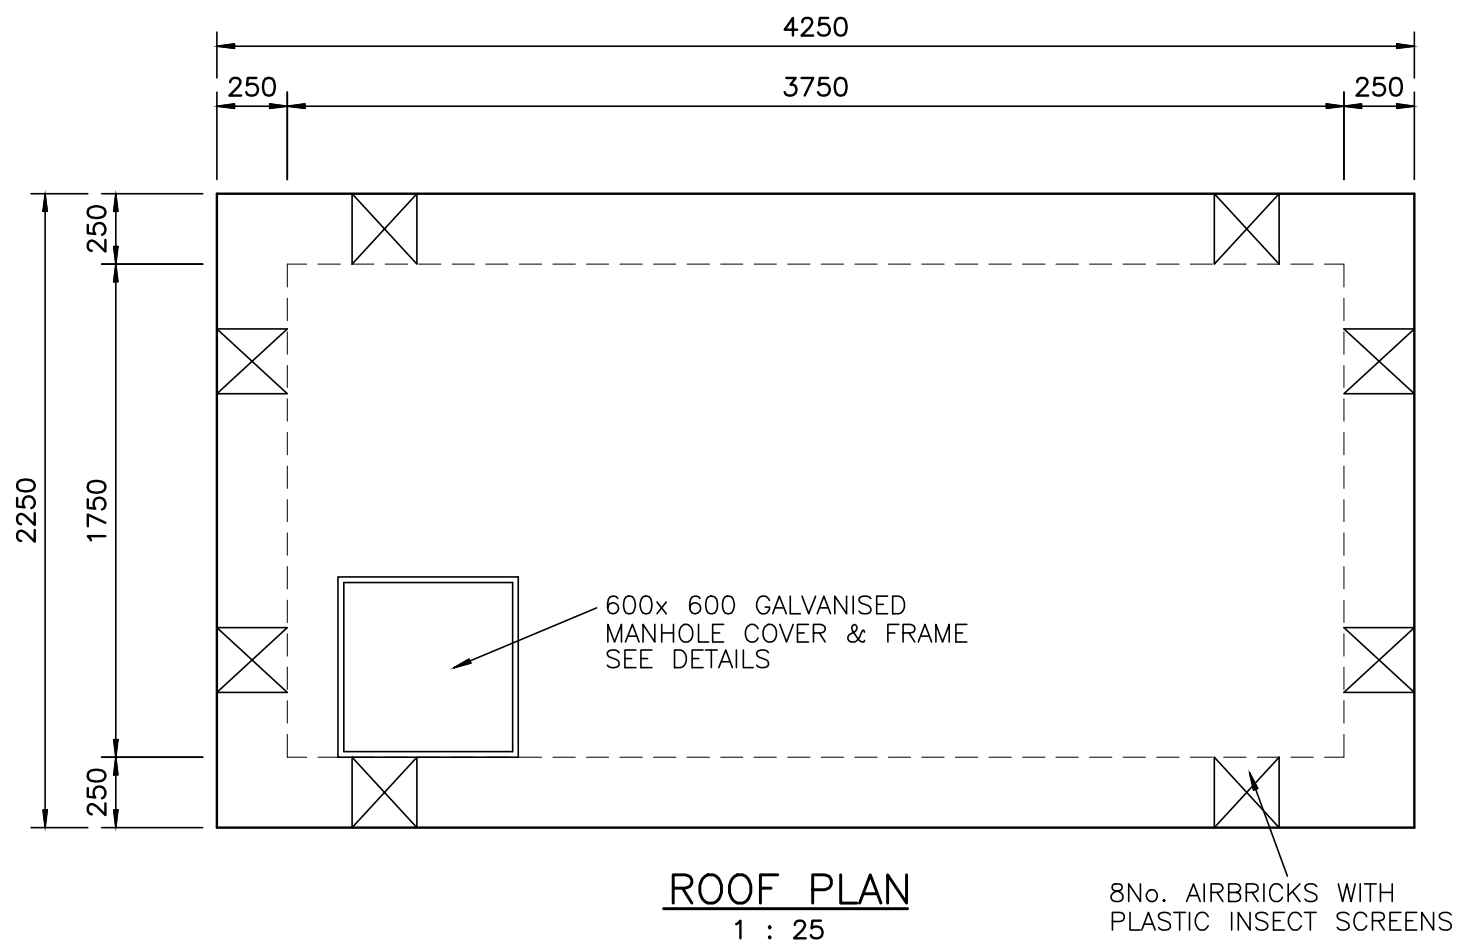


ROOF PLAN
1 : 25

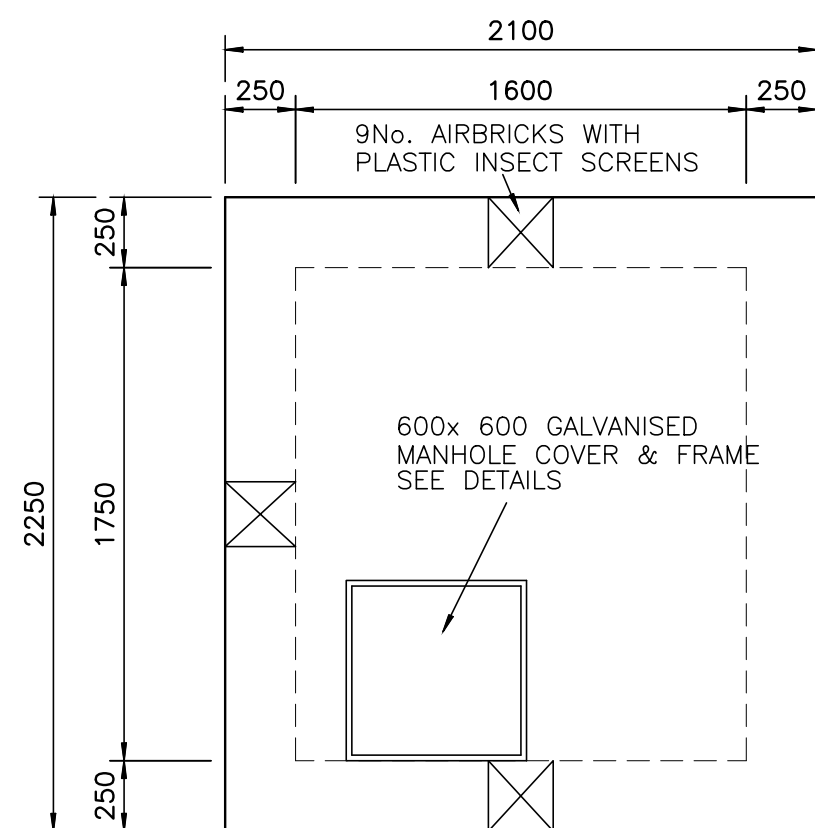


ROOF PLAN
1 : 25


ALTITUDE CONTROL VALVE CHAMBER

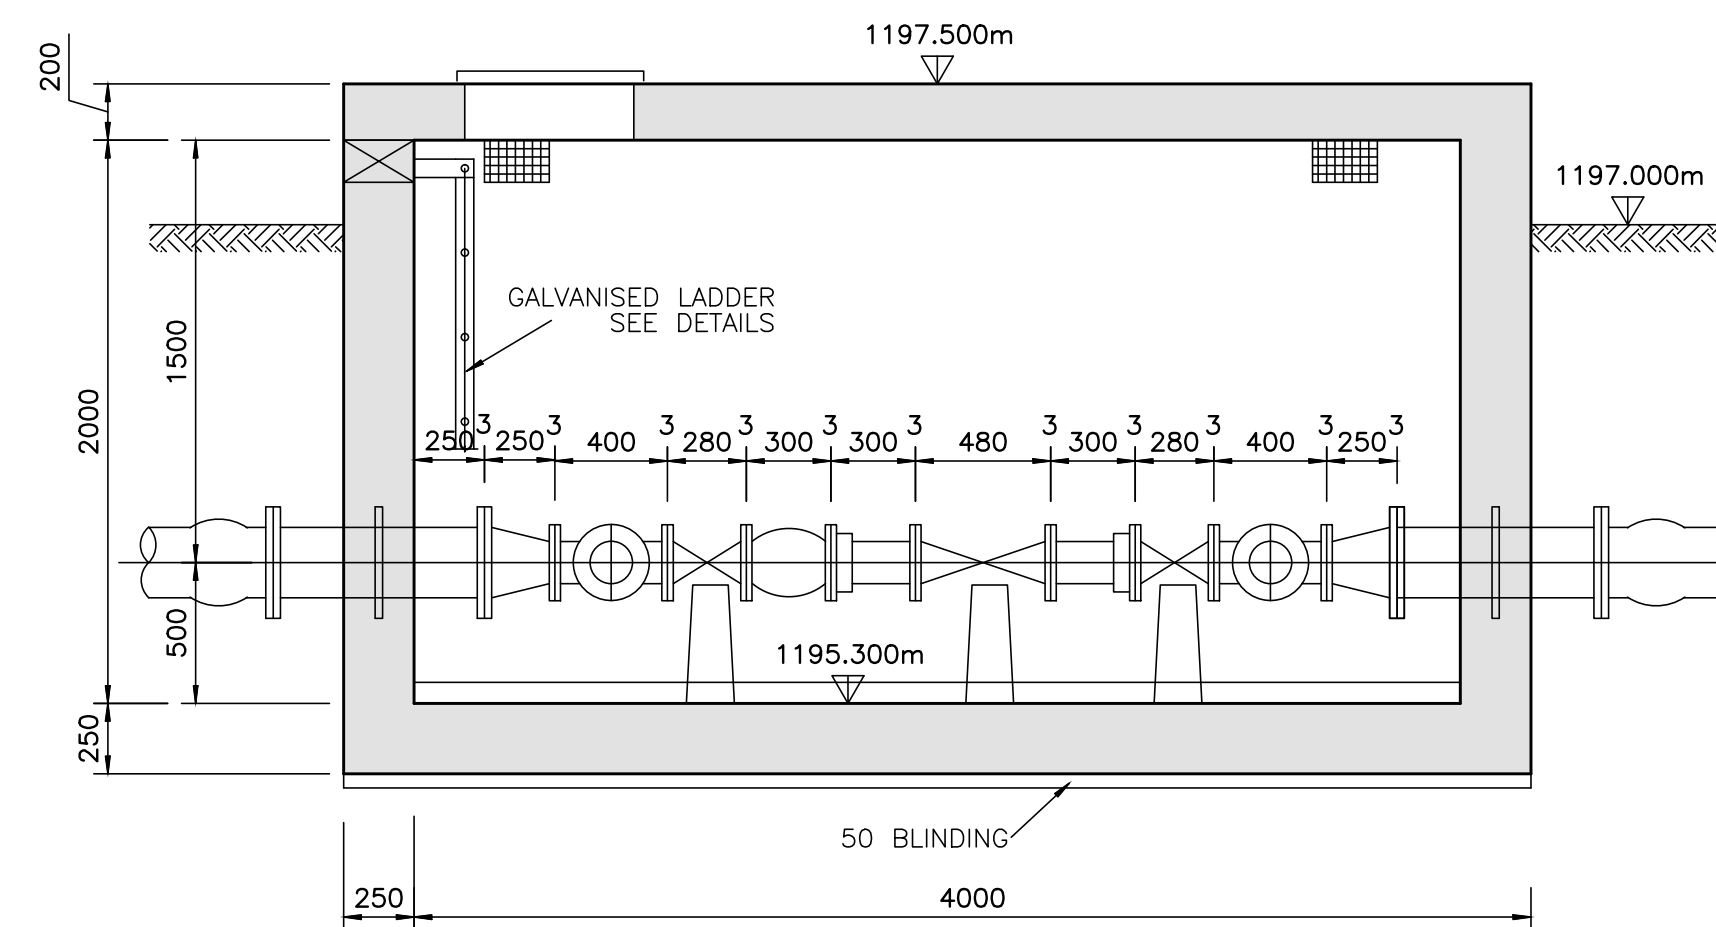

SECTION A - A
1 : 25

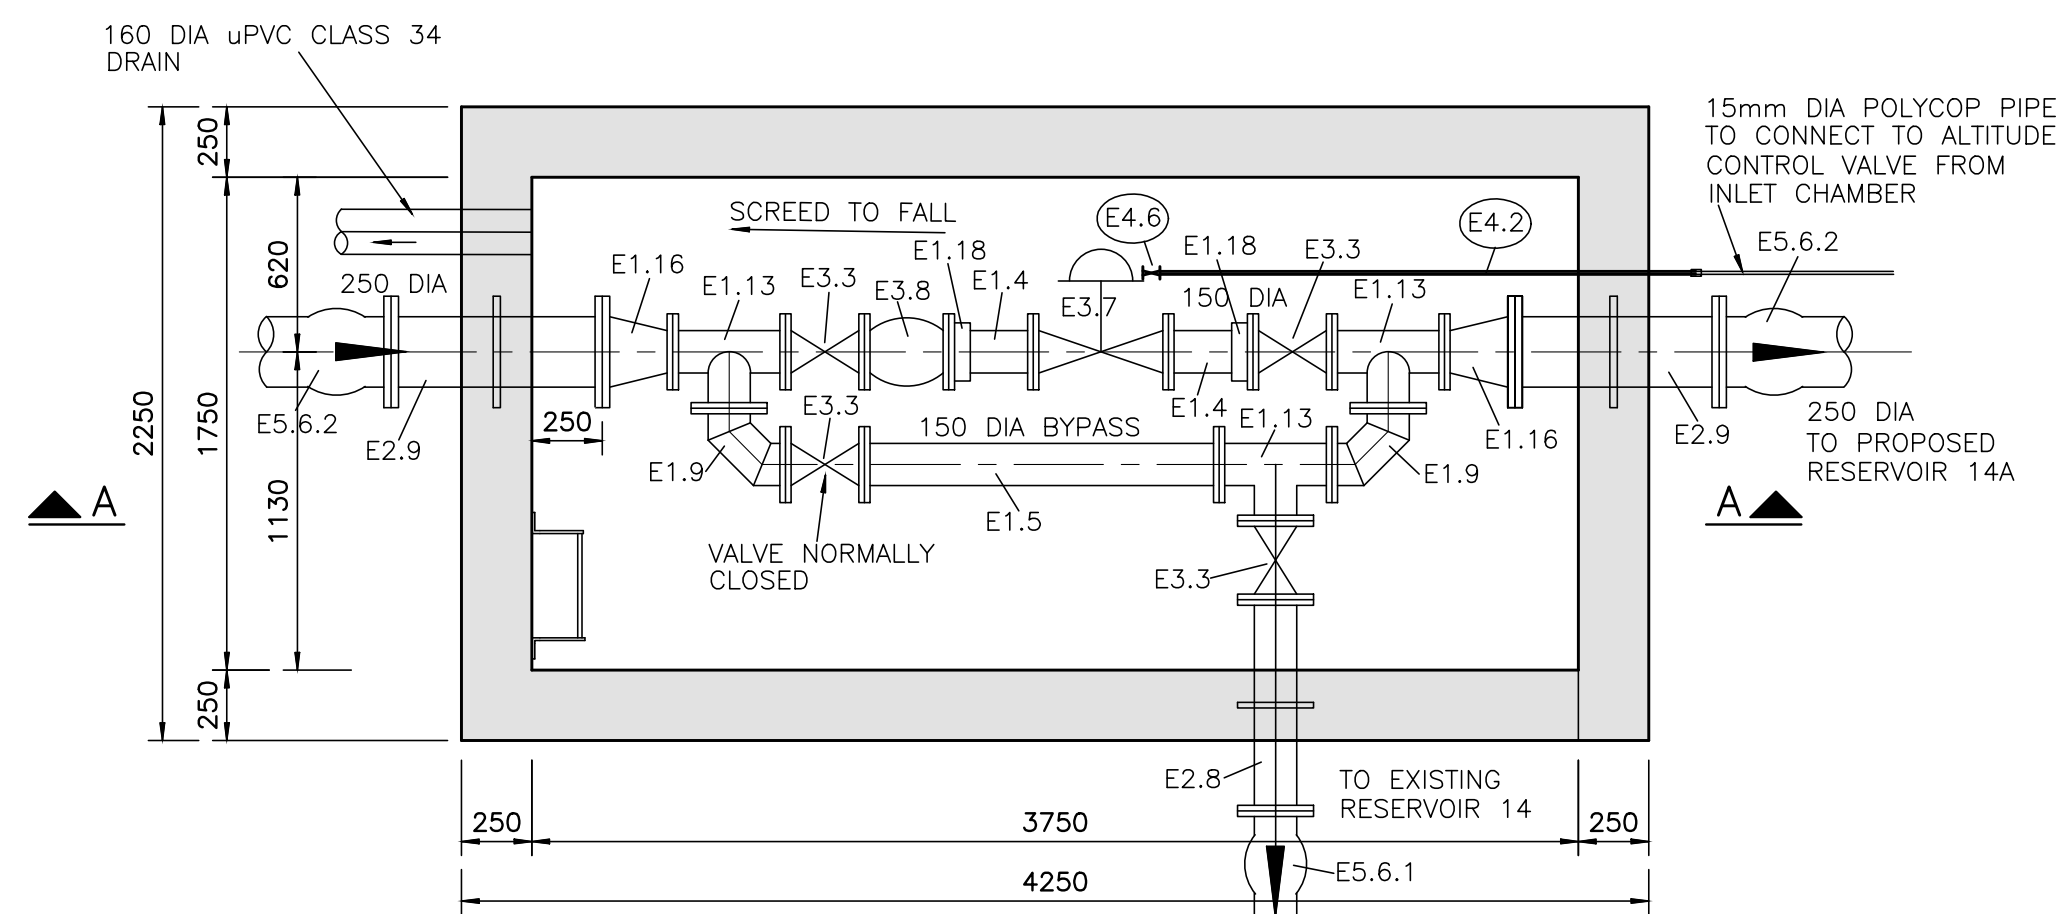

FLOOR PLAN
1 : 25

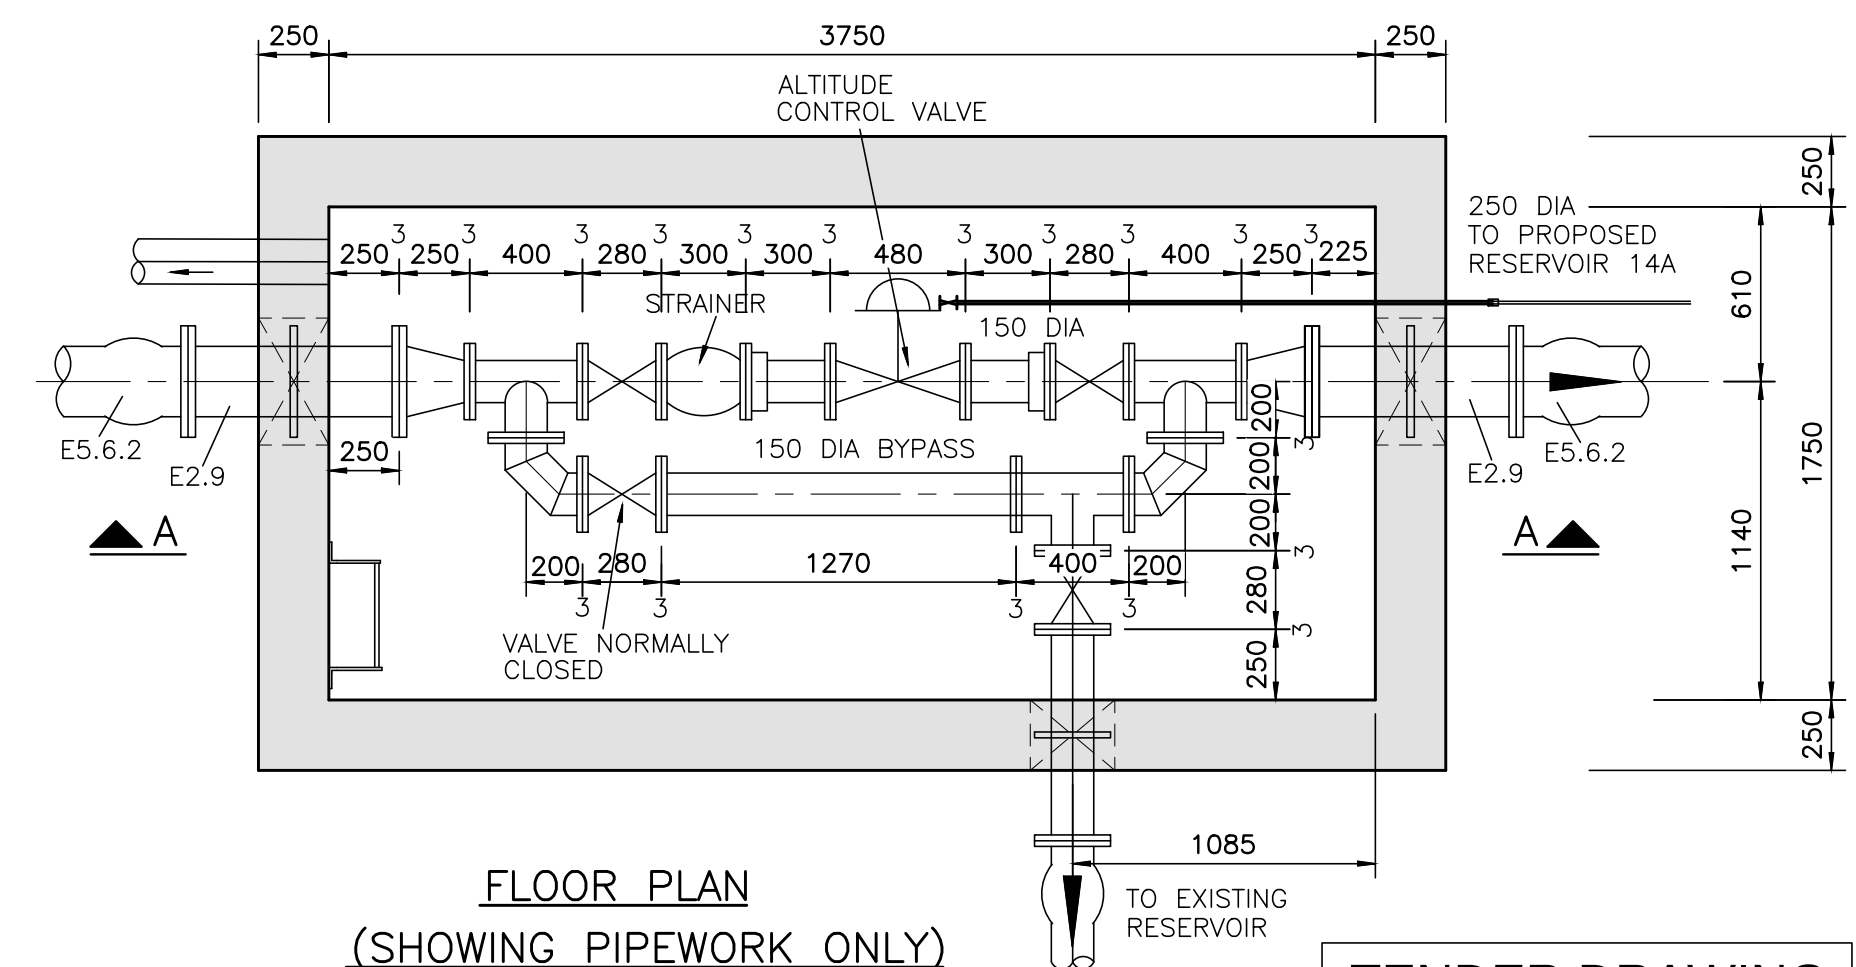

FLOOR PLAN
(SHOWING PIPEWORK ONLY)
1 : 25

TENDER DRAWING

ORIGINAL SCALE
AS SHOWN

ALT. DWG. No.	CONTRACT No.
SHT. No.	OF PROJECT No.
DRAWING No.	REVISION
MSUN-VUL-PH3C-P9	0



APPROVED : (FOR TENDER)
M NSIBIRWA
PR REG No. 930101



PROJECT/DRAWING TITLE
MSUNDUZI MUNICIPALITY
VULINDLELA PHASE 3C - WATER SUPPLY UPGRADE
PROPOSED RESERVOIR 13A (5.50 ML RESERVOIR)
INLET / ALTITUDE VALVE CHAMBER

CAD FILE CODE