


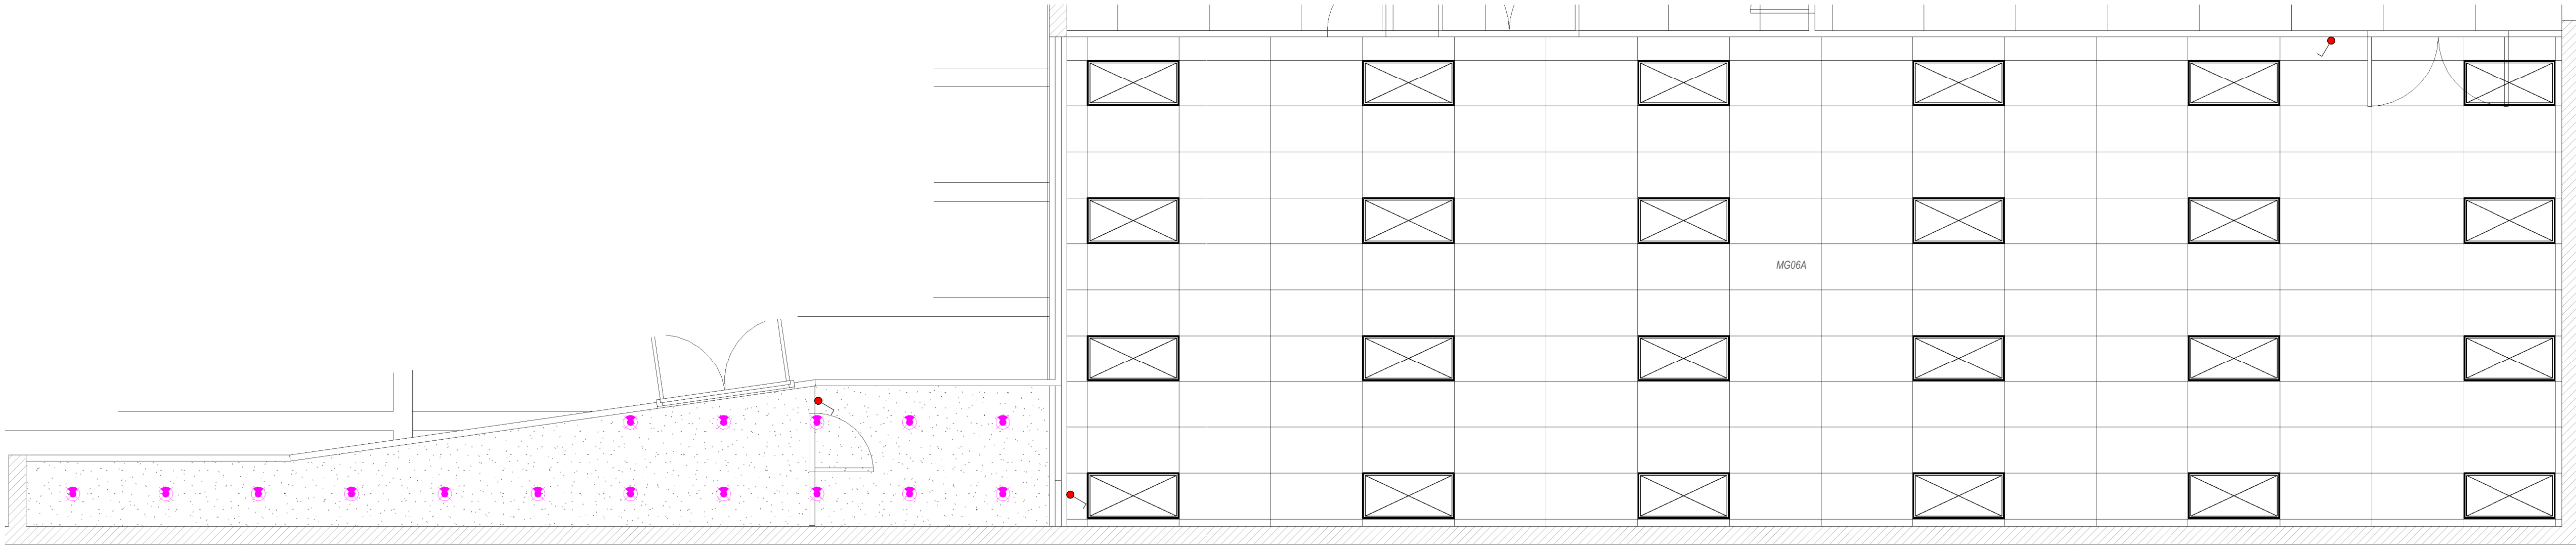


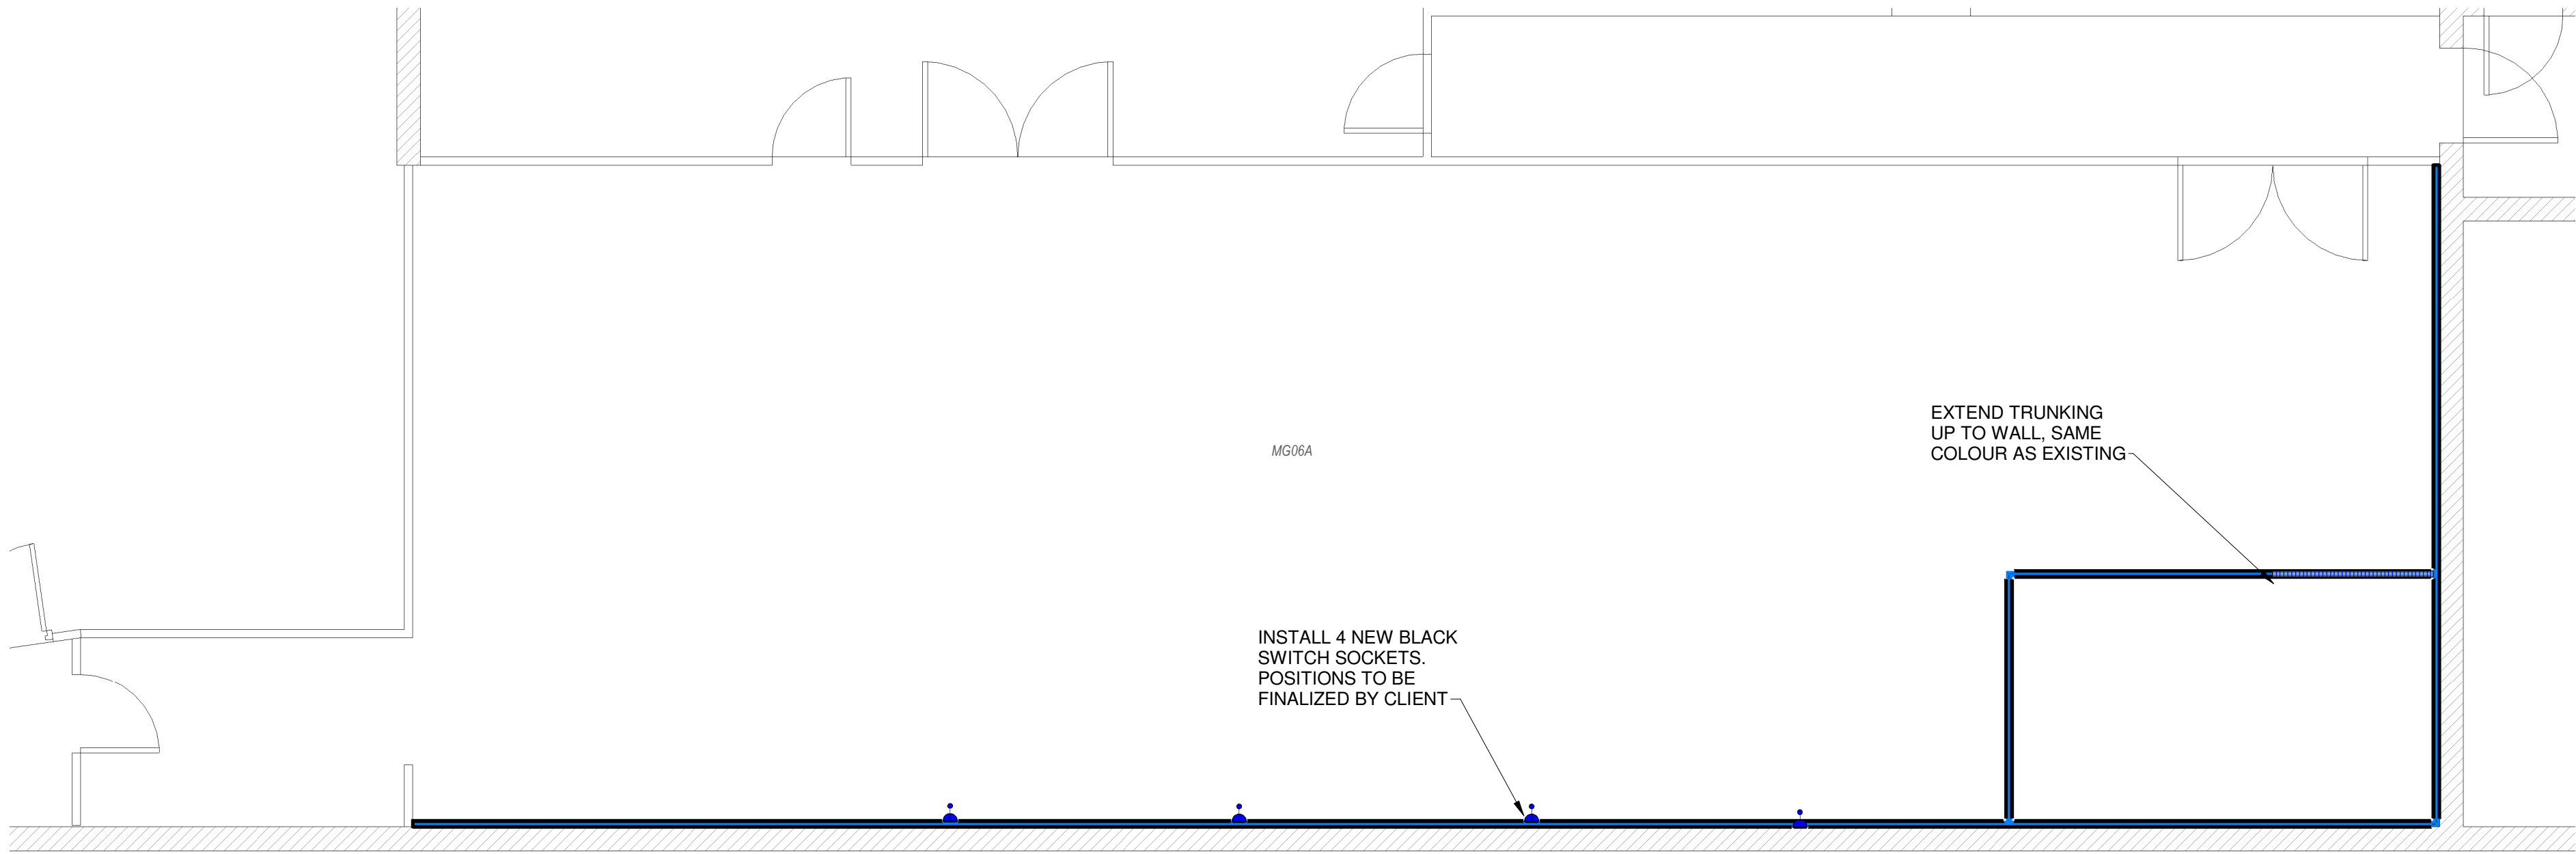


1 **MG06A POWER LAYOUT**
1 : 50

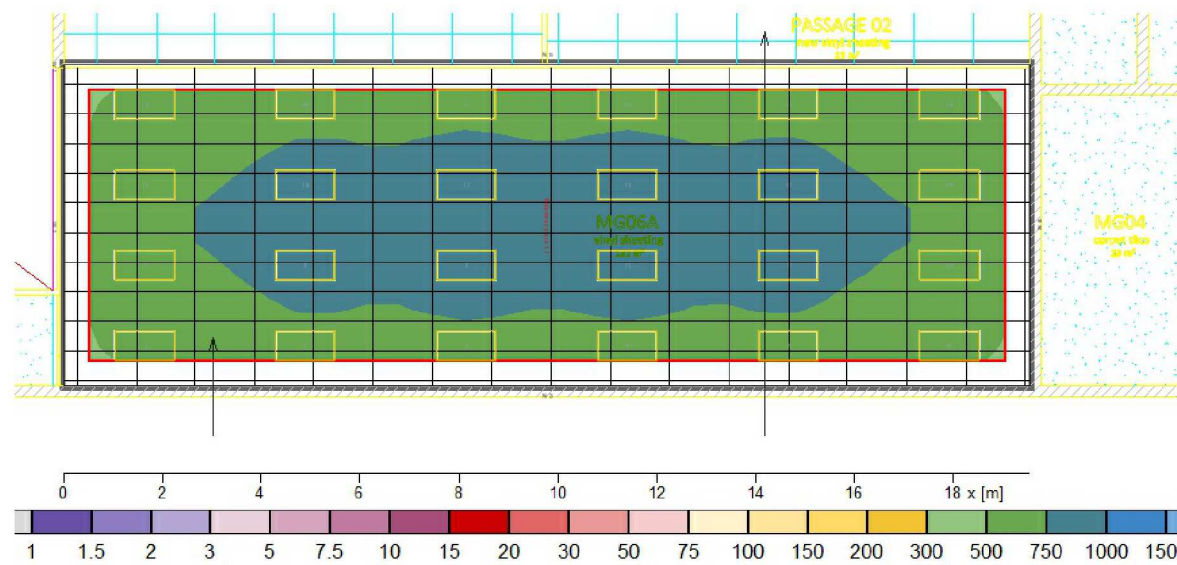

2 **MG06A POWER LAYOUT**
1 : 50

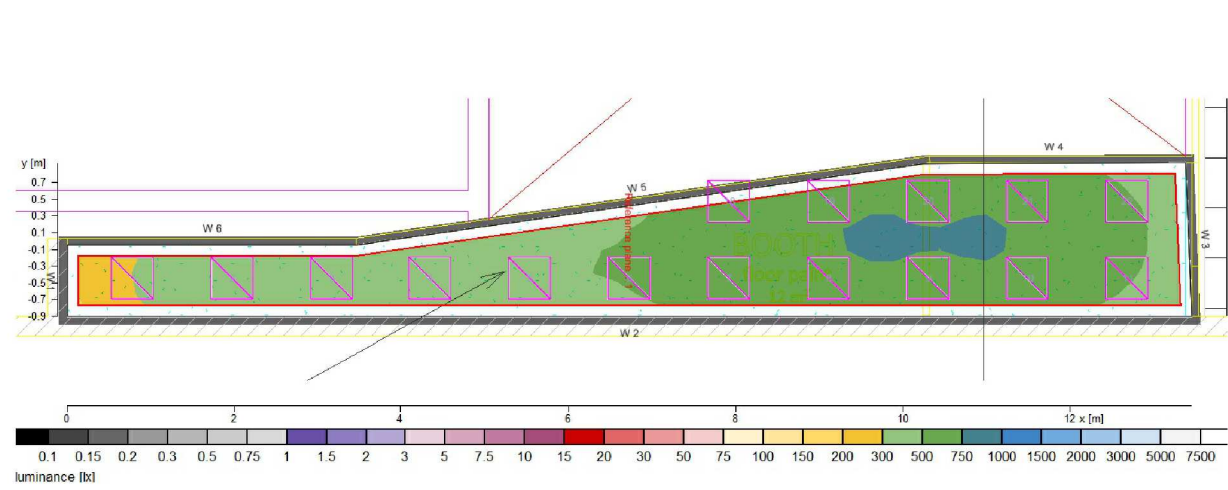

1 TIER POWER SKIRTING

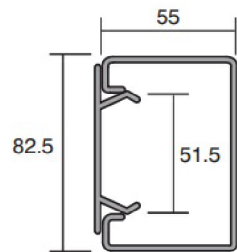

SWITCH SOCKET



LIGHT SWITCH



16w LED DOWNLIGHT



1200x600 LED PANEL



PRELIMINARY

APPROVED
NAME _____ SIGNATURE _____
PR. NO. _____ DATE _____

LEGEND		
ICON	DESCRIPTION	QTY
	50w LED PANEL 1200x600 6500K FRAME BLACK POWDER COATED	24
	16w LED DOWNLIGHT BLACK POWDER COATED	16
	LIGHT SWITCH	3
	16A SWITCH SOCKET IN POWER SKIRTING	4
	1 TIER POWER SKIRTING	

PRELIMINARY REVISIONS			
REV	DATE	DESCRIPTION	BY
0A	2024-02-06	PRELIMINARY DESIGN	DK
0B	2024-03-18	UPDATED LAYOUT	DK

CLIENT ARCHITECT

SABS **ADQ**
AFRICAN DYNAMIC QUALITY
ENGINEERING PROJECTS

CONSULTANT

ADQ
AFRICAN DYNAMIC QUALITY
ENGINEERING PROJECTS

info@adqengineering.co.za
Tel: 012 030 0355

www.adqengineering.co.za

PROJECT DESCRIPTION
SABS PRETORIA

DRAWING TITLE
MG06A LIGHTING & POWER LAYOUT

DATE 2024-02-06	DRAWN BY D. KRUGER
CHECKED BY A. JEEVA	DESIGNED BY A. JEEVA
DRAWING SIZE A1	SCALE As indicated
DRAWING NUMBER P23072-PD-ELE-200	REV 0B