


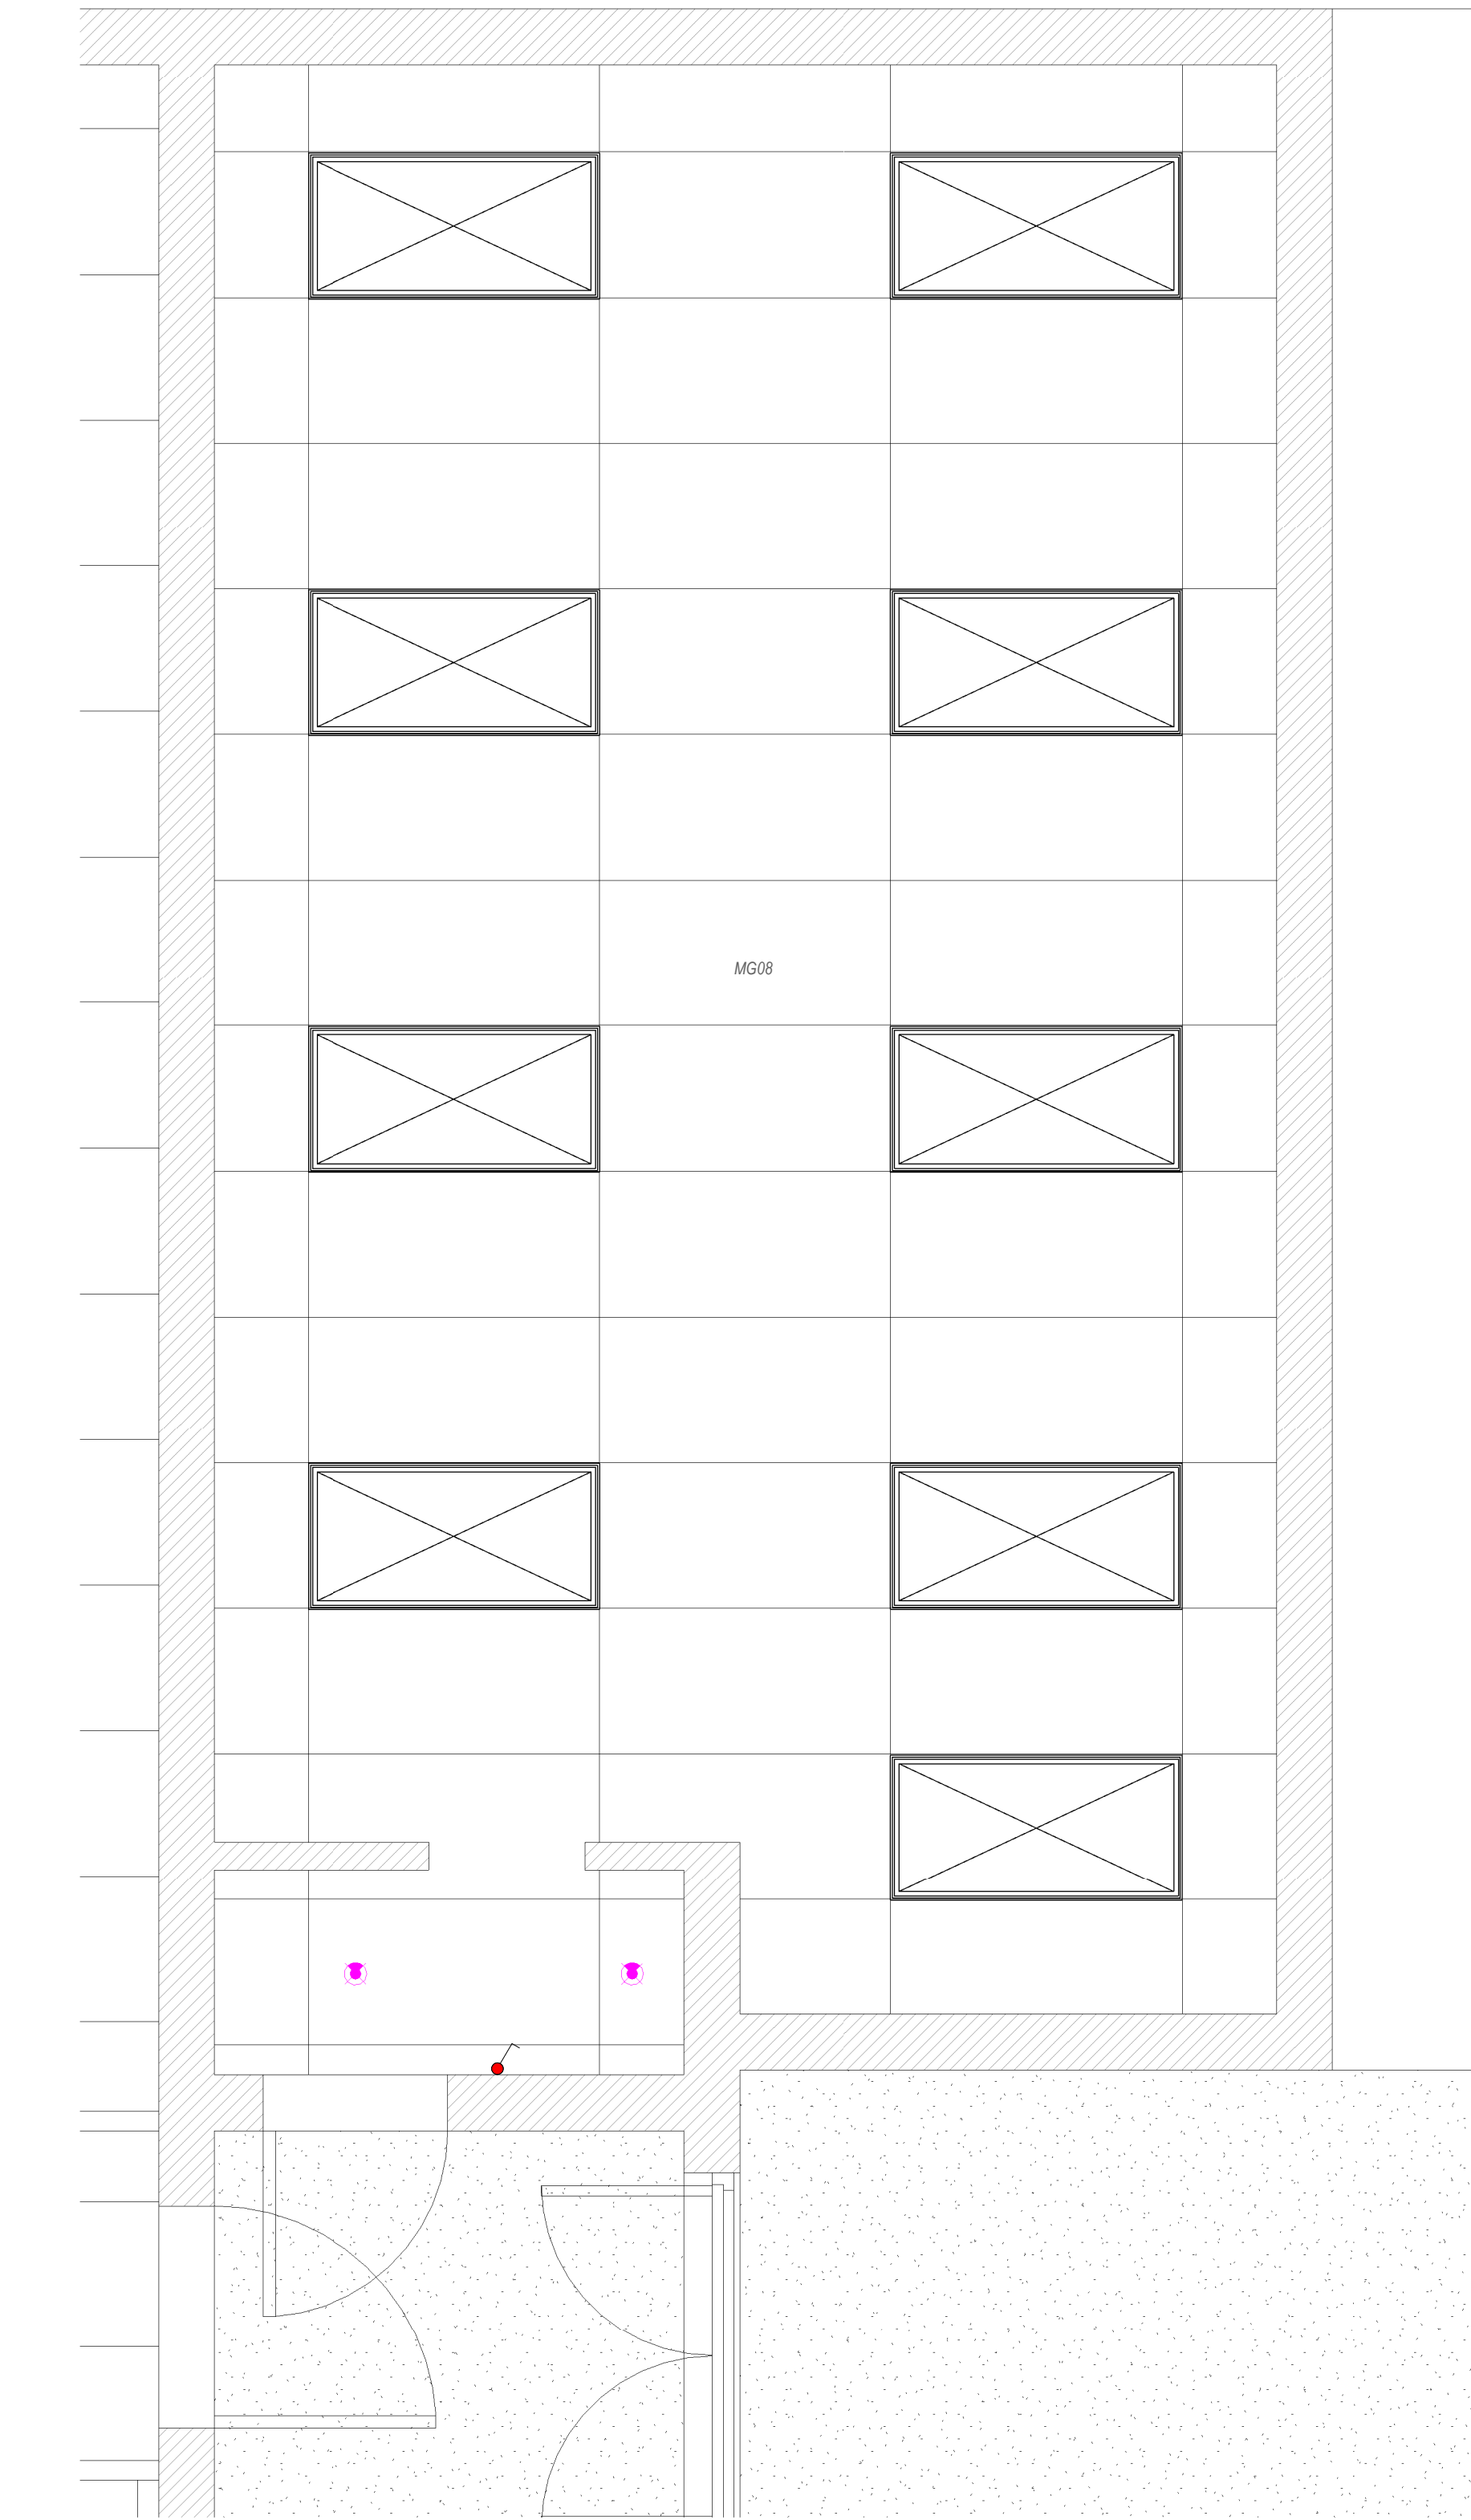


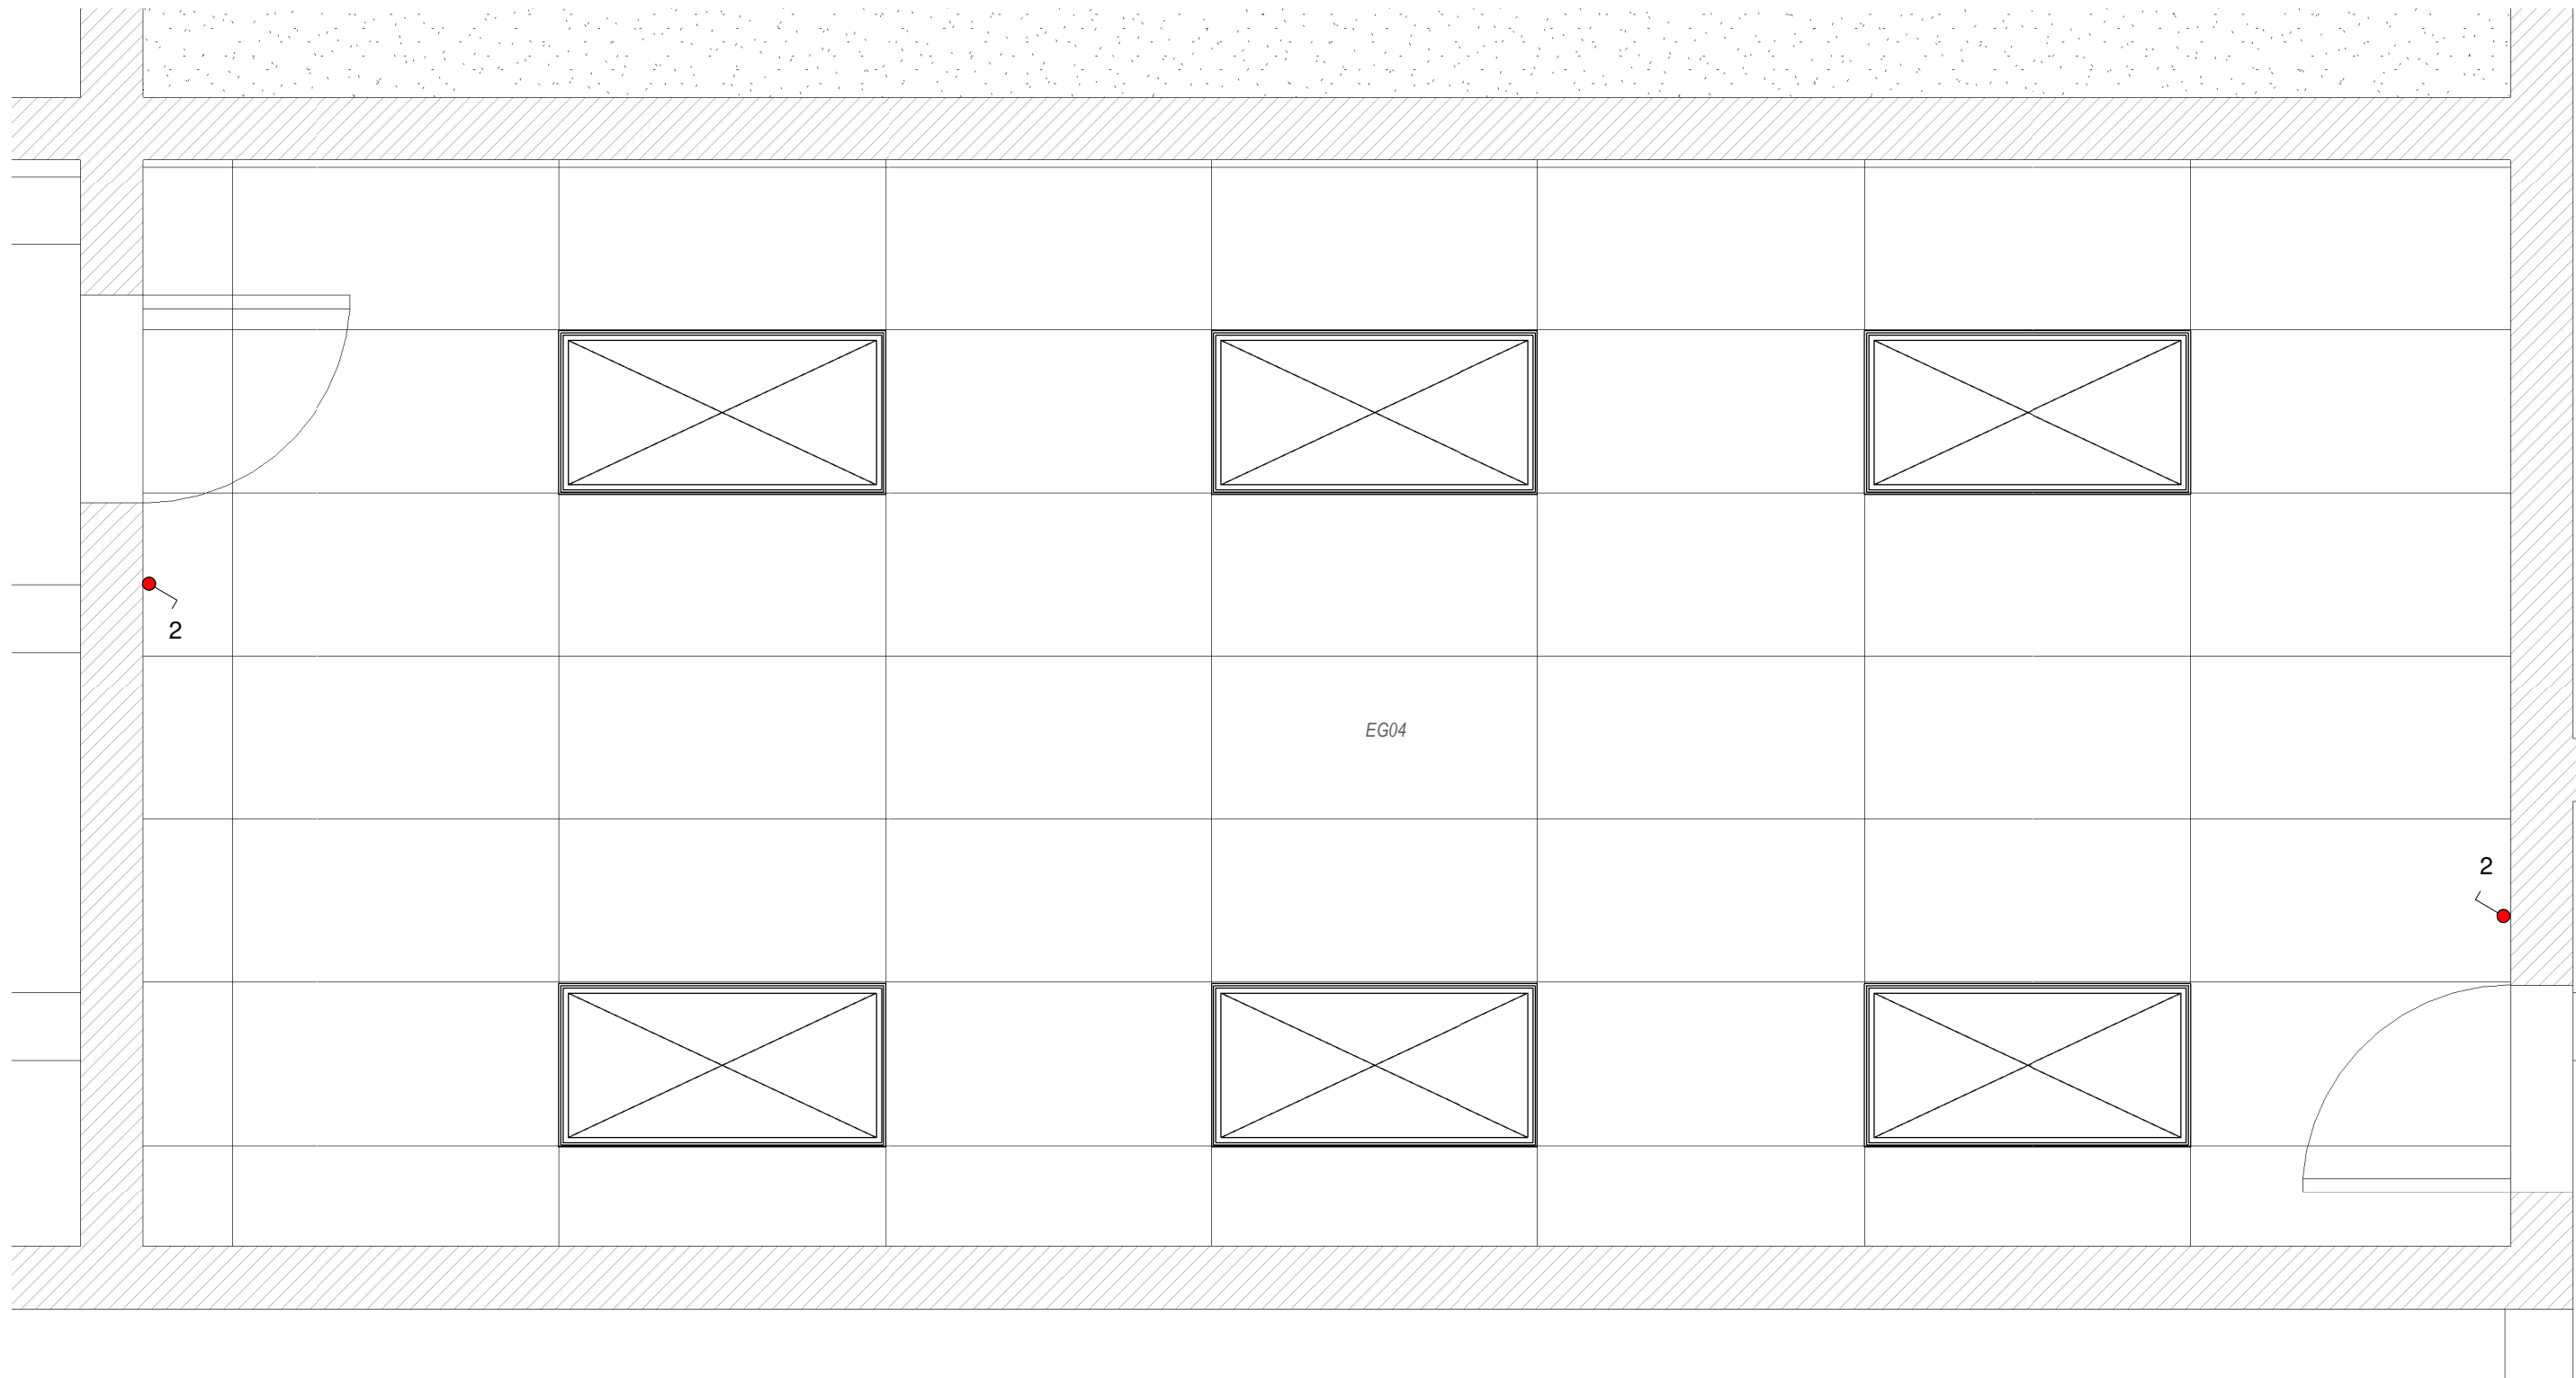


1 MG08 LIGHTING LAYOUT
1 : 25

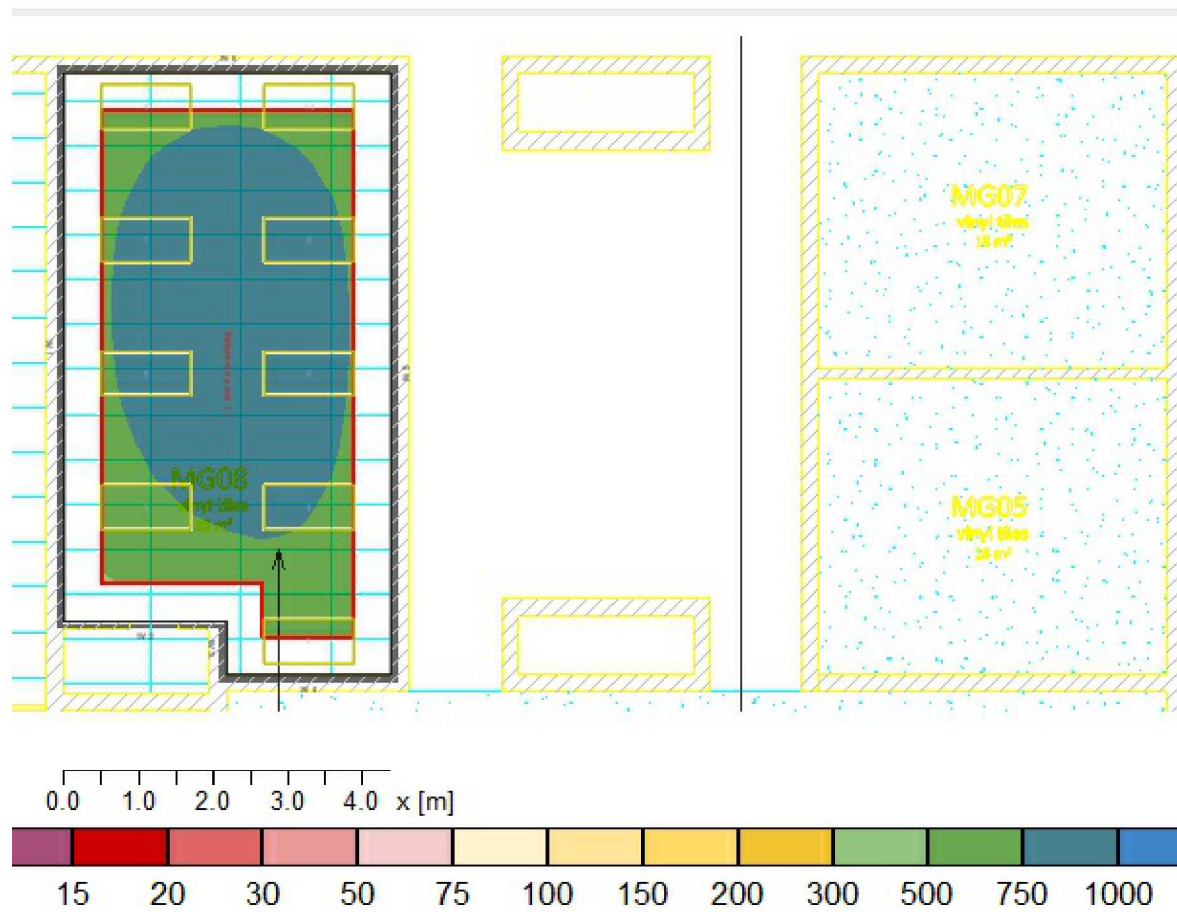

2 EG04 LIGHTING LAYOUT
1 : 25

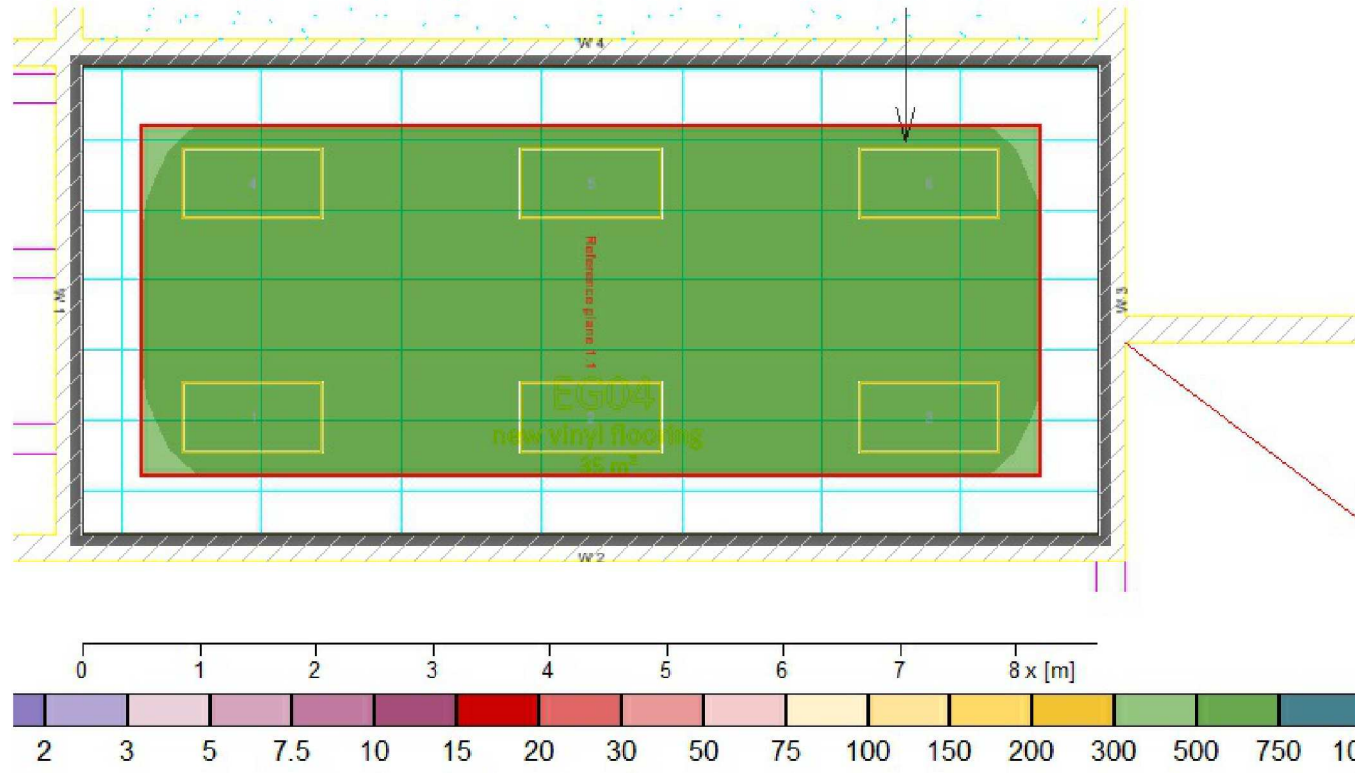

1200x600 LED PANEL

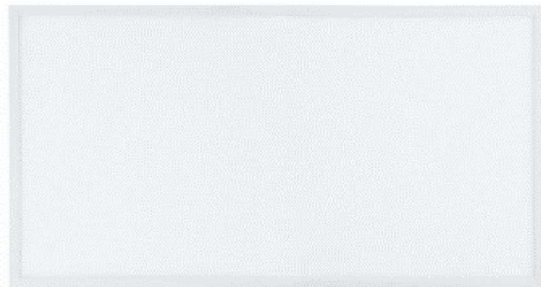

LIGHT SWITCH



PRELIMINARY

APPROVED
NAME _____ SIGNATURE _____
PR. NO. _____ DATE _____

LIGHTING LEGEND		
ICON	DESCRIPTION	QTY
	50w LED PANEL 1200x600 6500K FRAME BLACK POWDER COATED	15
	16w LED DOWNLIGHT BLACK POWDER COATED	2
	LIGHT SWITCH	1
	2 WAY LIGHT SWITCH	2

PRELIMINARY REVISIONS			
REV	DATE	DESCRIPTION	BY
0A	2024-02-06	PRELIMINARY DESIGN	DK
0B	2024-03-18	UPDATED LAYOUT	DK

CLIENT ARCHITECT

SABS **ADQ**
AFRICAN DYNAMIC QUALITY
ENGINEERING PROJECTS

CONSULTANT

ADQ
AFRICAN DYNAMIC QUALITY
ENGINEERING PROJECTS

info@adqengineering.co.za
Tel: 012 030 0355

www.adqengineering.co.za

PROJECT DESCRIPTION

SABS PRETORIA

DRAWING TITLE

MG08 & EG04 LIGHTING LAYOUT

DATE	2024-02-06	DRAWN BY	D. KRUGER
CHECKED BY	A. JEEVA	DESIGNED BY	A. JEEVA
DRAWING SIZE	A1	SCALE	As indicated
DRAWING NUMBER	P23072-PD-ELE-202	REV	0B