


SYMBOL	DESCRIPTION	QTY	MAKE
Z1	SUITABLE ZONE 1 EX LED LUMINAIRE	4	TBC
Z2	SUITABLE ZONE 2 EX LED LUMINAIRE	15	TBC
RM	RAIL MOUNT	18	
FM	FLOOR MOUNT	1	
BM	BUND MOUNT	0	
	PROPOSED CABLE ROUTE		

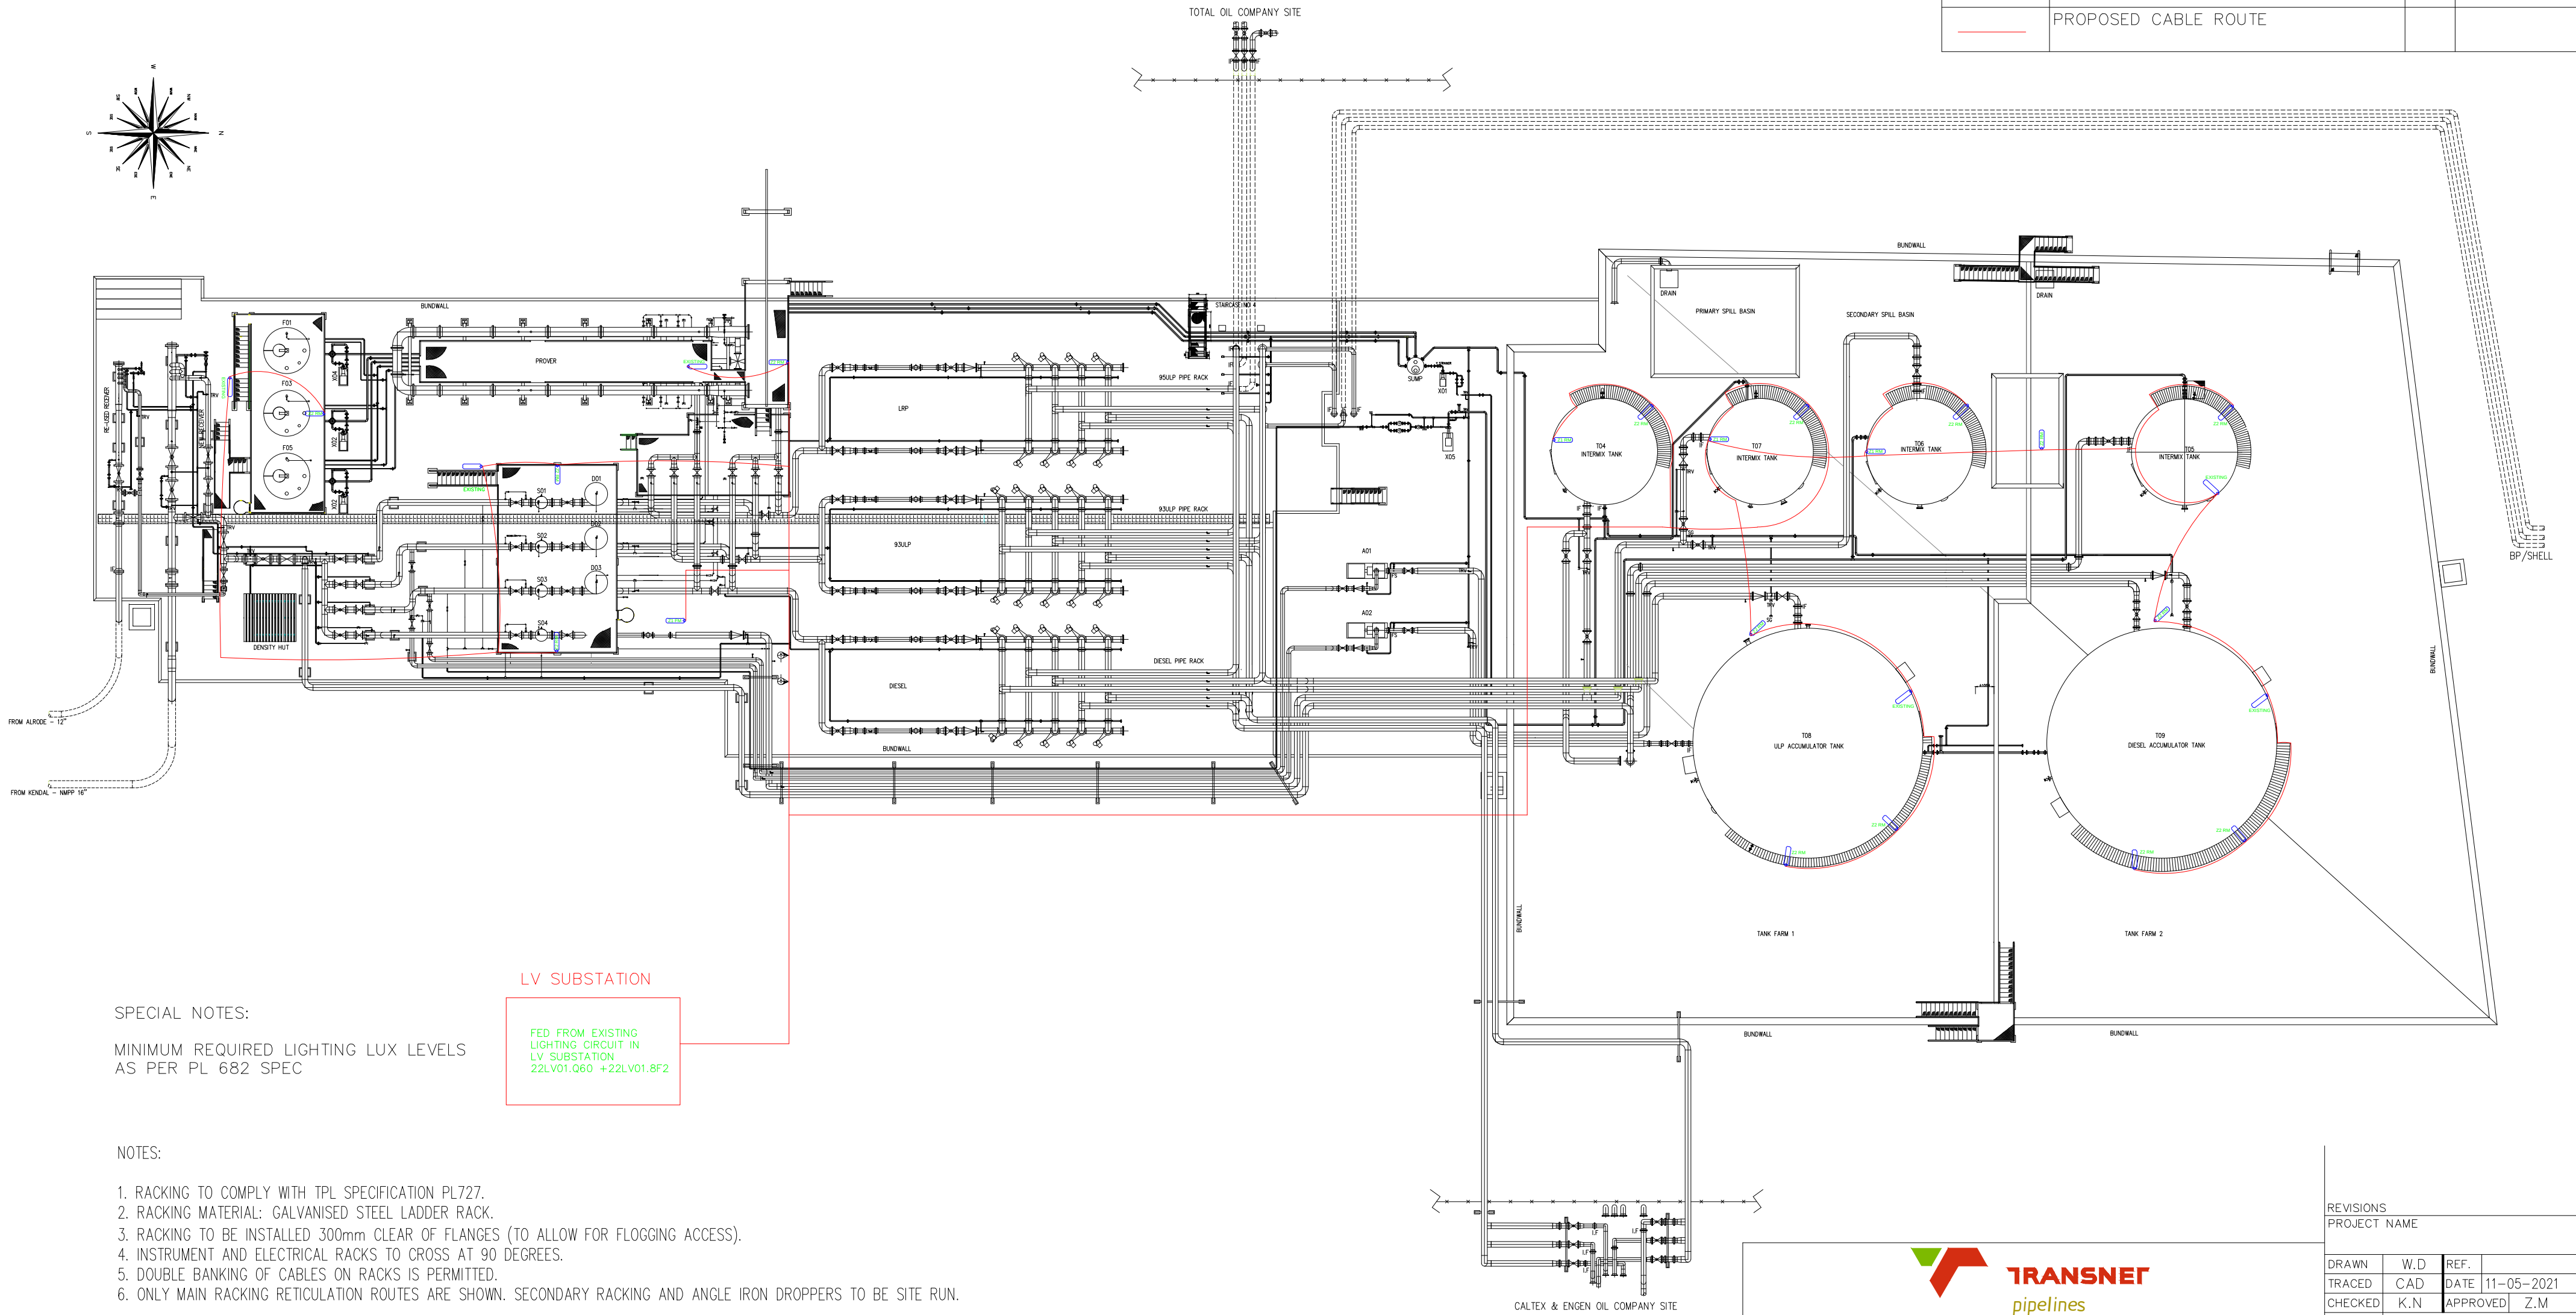

SPECIAL NOTES:

MINIMUM REQUIRED LIGHTING LUX LEVELS
AS PER PL 682 SPEC

LV SUBSTATION
FED FROM EXISTING
LIGHTING CIRCUIT IN
LV SUBSTATION
22LV01.060 +22LV01.8F2

NOTES:

1. RACKING TO COMPLY WITH TPL SPECIFICATION PL727.
2. RACKING MATERIAL: GALVANISED STEEL LADDER RACK.
3. RACKING TO BE INSTALLED 300mm CLEAR OF FLANGES (TO ALLOW FOR FLOGGING ACCESS).
4. INSTRUMENT AND ELECTRICAL RACKS TO CROSS AT 90 DEGREES.
5. DOUBLE BANKING OF CABLES ON RACKS IS PERMITTED.
6. ONLY MAIN RACKING RETICULATION ROUTES ARE SHOWN. SECONDARY RACKING AND ANGLE IRON DROPPERS TO BE SITE RUN.

REVISIONS			
PROJECT NAME			
DRAWN	W.D	REF.	
TRACED	CAD	DATE	11-05-2021
CHECKED	K.N	APPROVED	Z.M
SCALE	NTS		
DRAWING No.			REV
PL 121581			



MANIFOLD/TANK LIGHTING LAYOUT
WALTLOO DEPOT

PROPOSAL