

PRELIMINARY



FOR TENDER



APPROVED

NAME _____ SIGNATURE _____

PR. NO. _____ DATE _____

INSTALLATION NOTE

- MATERIAL QUANTITIES AND LENGTHS ARE INDICATIVE ONLY. CONTRACTOR IN. NOT TO USE QUANTITIES AND LENGTHS FOR ORDERING PURPOSES.
- CEILING LAYOUT TO BE CONFIRMED AND COORDINATED BETWEEN SERVICES.
- SOCKET AND DATA OUTLETS TO BE INSTALLED AT 300mm AFFL (CENTRE OF SOCKET), UNLESS SHOWN OTHERWISE.
- 9-WAY SOCKET CLUSTER TO BE INSTALLED AT 600mm AFFL, UNLESS SHOWN OTHERWISE.
- TV OUTLET AND ASSOCIATED SOCKET AND DATA POINTS TO BE INSTALLED AT 1800mm AFFL (CENTRE OF SOCKETS) UNLESS SHOWN OTHERWISE.
- ALL FLOOR BOXES TO BE PROVIDED WITH 2x25mm CONDUITS.
- BOARDROOM FLOOR BOXES TO BE PROVIDED WITH AN ADDITIONAL 40/50mm CONDUIT TO TV POINTS.
- OFFICES WITH TV POINTS TO HAVE 40/50mm CONDUIT TO 9-WAY BOX FOR HDMI CABLE.

PRELIMINARY

REVISIONS

REV	DATE	DESCRIPTION	BY
0A	2022-09-23	PRELIMINARY DESIGN	DK

CLIENT

SANBI
South African National Biodiversity Institute

ARCHITECT

ZAS
Architects and planners

CONSULTANT

ADQ
AFRICAN DYNAMIC QUALITY
ENGINEERING PROJECTS

info@adqengineering.co.za

Tel: 012 030 0355

www.adqengineering.co.za

PROJECT DESCRIPTION

HERBARIUM

DRAWING TITLE

BASEMENT FLOOR POWER LAYOUT

DATE	2022-09-23	DRAWN BY	D. KRUGER
CHECKED BY	A ERASMUS	DESIGNED BY	A ERASMUS
DRAWING SIZE	A1	SCALE	As indicated
DRAWING NUMBER	P20012-PD-ELE-100	REV	0A

1 BASEMENT
1 : 200

PRELIMINARY



FOR TENDER



APPROVED

NAME _____ SIGNATURE _____

PR. NO. _____ DATE _____

INSTALLATION NOTE

- MATERIAL QUANTITIES AND LENGTHS ARE INDICATIVE ONLY. CONTRACTOR IN. NOT TO USE QUANTITIES AND LENGTHS FOR ORDERING PURPOSES.
- CEILING LAYOUT TO BE CONFIRMED AND COORDINATED BETWEEN SERVICES.
- SOCKET AND DATA OUTLETS TO BE INSTALLED AT 300mm AFFL (CENTRE OF SOCKET), UNLESS SHOWN OTHERWISE.
- 9-WAY SOCKET CLUSTER TO BE INSTALLED AT 600mm AFFL, UNLESS SHOWN OTHERWISE.
- TV OUTLET AND ASSOCIATED SOCKET AND DATA POINTS TO BE INSTALLED AT 1800mm AFFL (CENTRE OF SOCKETS) UNLESS SHOWN OTHERWISE.
- ALL FLOOR BOXES TO BE PROVIDED WITH 2x25mm CONDUITS.
- BOARDROOM FLOOR BOXES TO BE PROVIDED WITH AN ADDITIONAL 40/50mm CONDUIT TO TV POINTS.
- OFFICES WITH TV POINTS TO HAVE 40/50mm CONDUIT TO 9-WAY BOX FOR HDMI CABLE.

PRELIMINARY

REVISIONS

REV	DATE	DESCRIPTION	BY
0A	2022-09-23	PRELIMINARY DESIGN	DK

CLIENT

ARCHITECT

SANBI

South African National Biodiversity Institute

Biodiversity for Life

ZAS

Architects and planners

CONSULTANT

ADQ

AFRICAN DYNAMIC QUALITY

ENGINEERING PROJECTS

info@adqengineering.co.za
Tel: 012 030 0355

www.adqengineering.co.za

PROJECT DESCRIPTION

HERBARIUM


DRAWING TITLE

GROUND FLOOR POWER LAYOUT

DATE	2022-09-23	DRAWN BY	D. KRUGER
CHECKED BY	A ERASMUS	DESIGNED BY	A ERASMUS
DRAWING SIZE	A1	SCALE	As indicated

DRAWING NUMBER	P20012-PD-ELE-101	REV	0A
----------------	-------------------	-----	----

PRELIMINARY

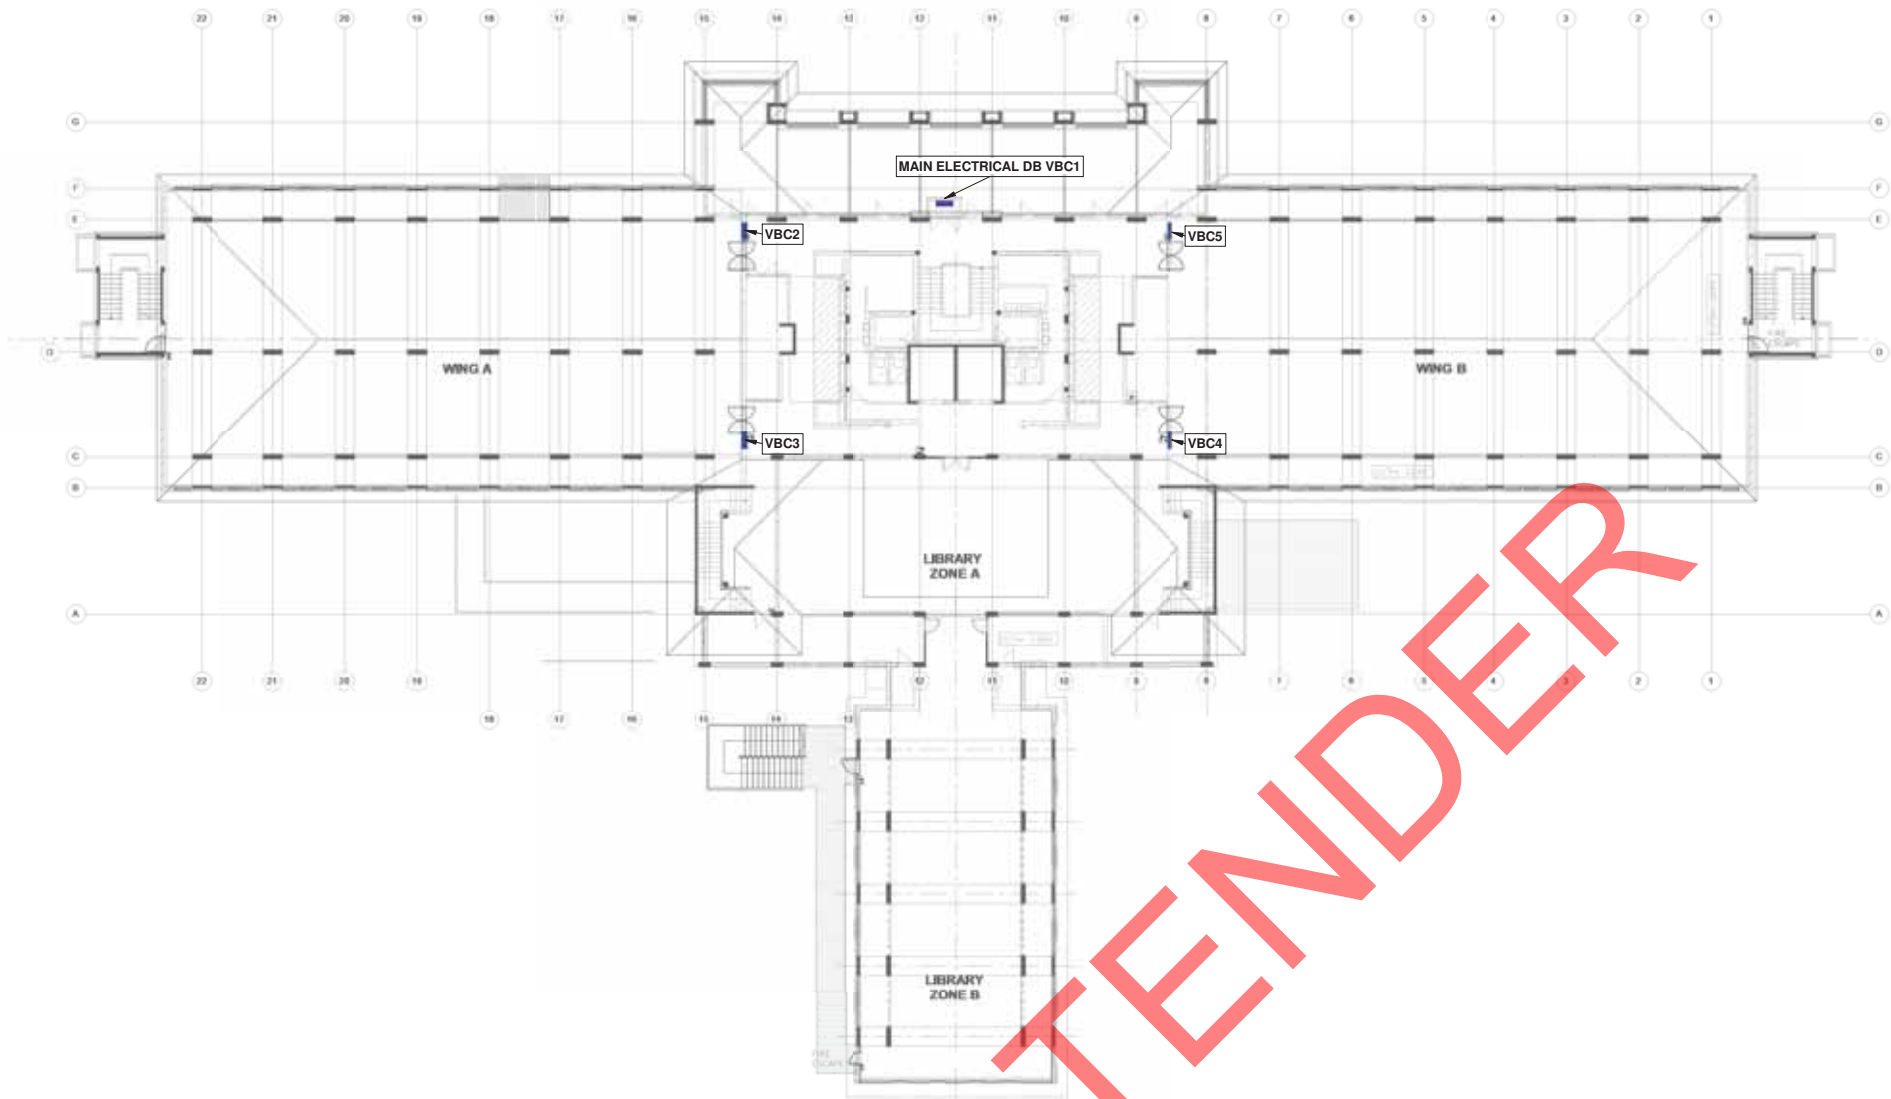

APPROVED

NAME _____ SIGNATURE _____

PR. NO. _____ DATE _____

INSTALLATION NOTE


- MATERIAL QUANTITIES AND LENGTHS ARE INDICATIVE ONLY. CONTRACTOR IN. NOT TO USE QUANTITIES AND LENGTHS FOR ORDERING PURPOSES.
- CEILING LAYOUT TO BE CONFIRMED AND COORDINATED BETWEEN SERVICES.
- SOCKET AND DATA OUTLETS TO BE INSTALLED AT 300mm AFFL (CENTRE OF SOCKET), UNLESS SHOWN OTHERWISE.
- 9-WAY SOCKET CLUSTER TO BE INSTALLED AT 600mm AFFL, UNLESS SHOWN OTHERWISE.
- TV OUTLET AND ASSOCIATED SOCKET AND DATA POINTS TO BE INSTALLED AT 1800mm AFFL (CENTRE OF SOCKETS) UNLESS SHOWN OTHERWISE.
- ALL FLOOR BOXES TO BE PROVIDED WITH 2x25mm CONDUITS.
- BOARDROOM FLOOR BOXES TO BE PROVIDED WITH AN ADDITIONAL 40/50mm CONDUIT TO TV POINTS.
- OFFICES WITH TV POINTS TO HAVE 40/50mm CONDUIT TO 9-WAY BOX FOR HDMI CABLE.

PRELIMINARY

REVISIONS

REV	DATE	DESCRIPTION	BY
0A	2022-09-23	PRELIMINARY DESIGN	DK

CLIENT

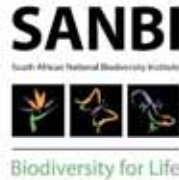

ARCHITECT



CONSULTANT




PROJECT DESCRIPTION

HERBARIUM

DRAWING TITLE

FIRST FLOOR POWER LAYOUT

DATE	2022-09-23	DRAWN BY	D. KRUGER
CHECKED BY	A ERASMUS	DESIGNED BY	A ERASMUS
DRAWING SIZE	A1	SCALE	As indicated
DRAWING NUMBER	P20012-PD-ELE-102	REV	0A

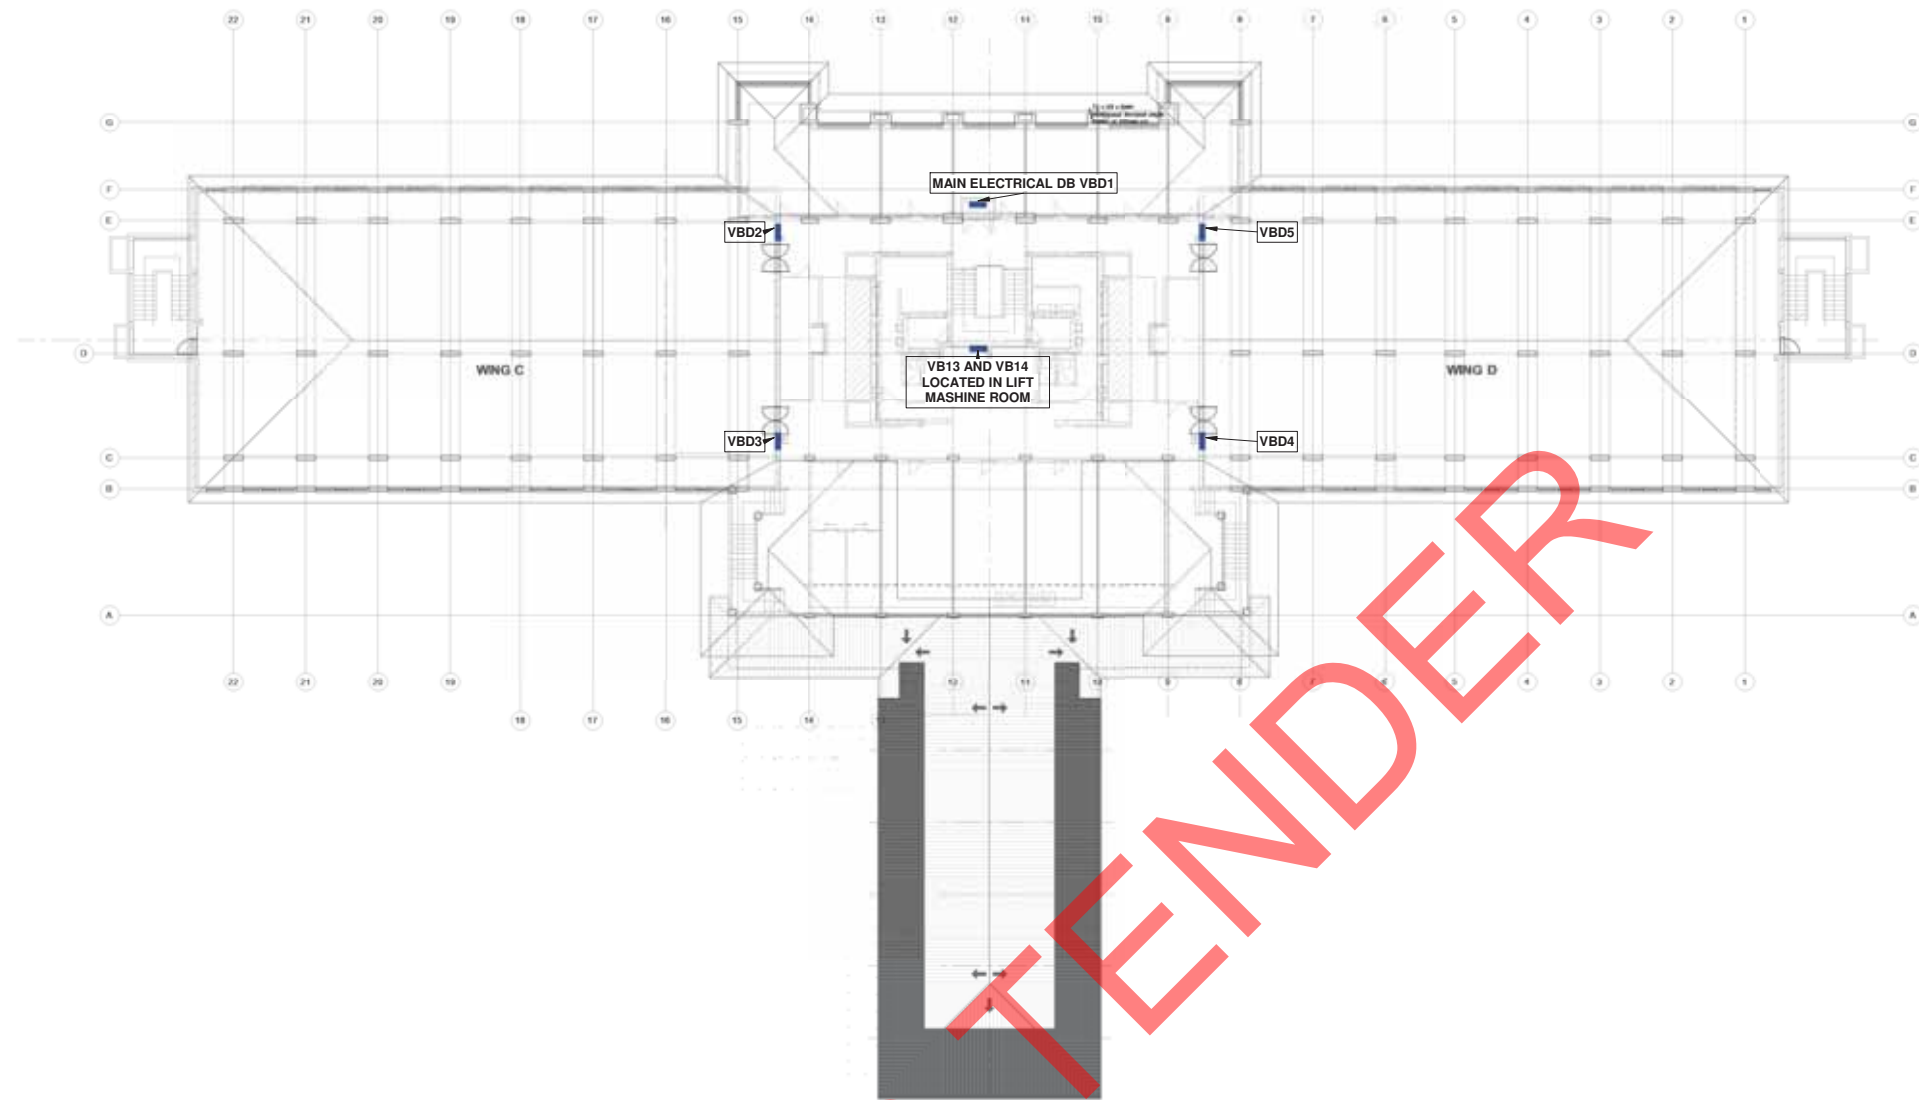

APPROVED

NAME _____ SIGNATURE _____

PR. NO. _____ DATE _____

PRELIMINARY

REVISIONS

REV	DATE	DESCRIPTION	BY
0A	2022-09-23	PRELIMINARY DESIGN	DK

CLIENT

SANBI
South African National Biodiversity Institute

Biodiversity for Life

ARCHITECT


ZAS
Architects and planners

CONSULTANT


AFRICAN DYNAMIC QUALITY
ENGINEERING PROJECTS
info@adqengineering.co.za
Tel: 012 030 0355
www.adqengineering.co.za

PROJECT DESCRIPTION

HERBARIUM

DRAWING TITLE

SECOND FLOOR POWER LAYOUT

DATE	2022-09-23	DRAWN BY	D. KRUGER
CHECKED BY	A ERASMUS	DESIGNED BY	A ERASMUS
DRAWING SIZE	A1	SCALE	1 : 200
DRAWING NUMBER	P20012-PD-ELE-103	REV	0A