


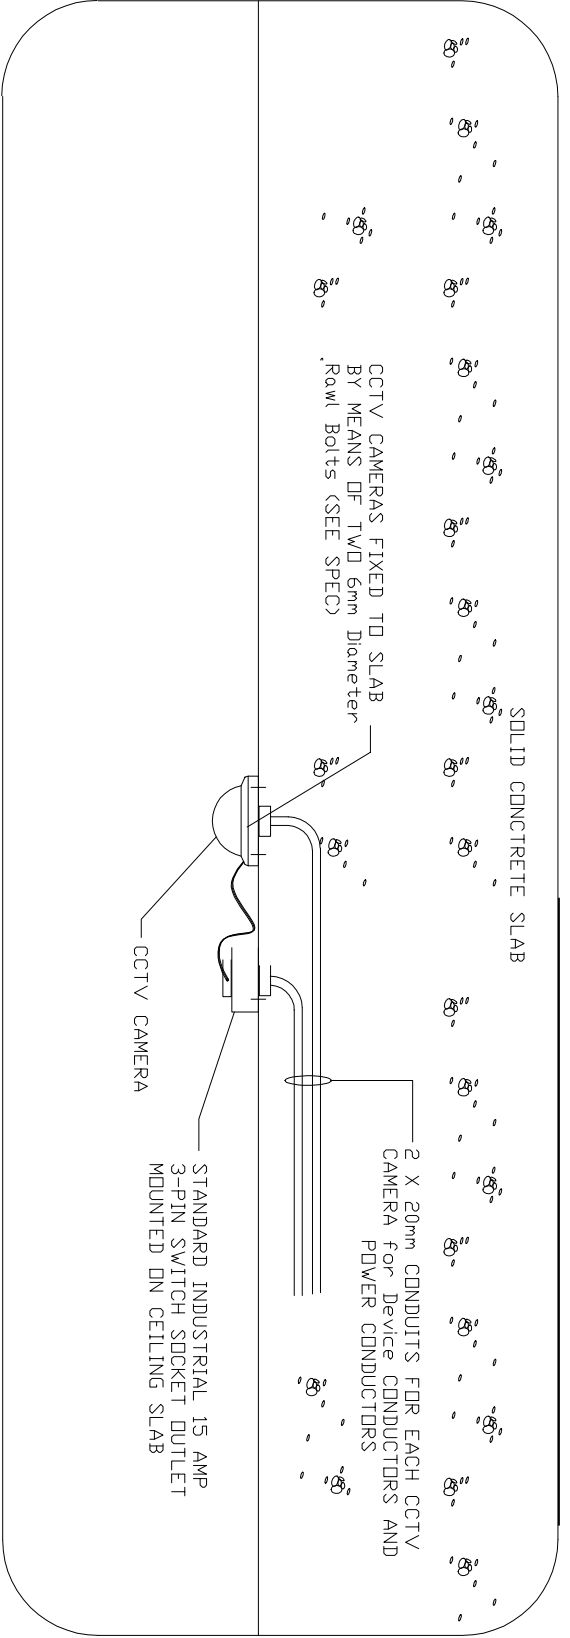

Checked by Professional Consultant  
NAME: Tilman Nel

Checked by Professional Consultant  
NAME: Tilman Nel

## HEALTH DEPARTMENT SIGNATURES

FACULTY STAMP

FACULTY MANAGER

## INFRASTRUCTURE MANAGER

GENERAL MANAGER

CHECKED BY PROFESSIONAL CONSULTANT

|      |            |
|------|------------|
| Name | Tilman Nel |
|------|------------|

Name Tilman Nel

|           |                   |
|-----------|-------------------|
| TJNeI     | 30 September 2023 |
| Signature | Date              |

CONSULTING ENGINEERS 

# TJNEL

CONSULTING ELECTRICAL ENGINEERS

P O BOX 169

PORT EDWARD

4295

CELL: 083 - 2659623



## SOUTHERN REGION

PROVINCE C

**PROVINCE OF KWAZULU-NATAL**

## SOUTHERN REGION

WIMS NO: 044044 SOUTHERN REGION  
PORT SHEPSTONE DEPARTMENT OF HEALTH  
PORT SHEPSTONE PROVINCIAL HOSPITAL  
NEW PSYCHIATRIC WARD

### Drawing Description

# PARKING LEVEL CCTV LAYOUT DRAWING

Drawn: TJN

Date: 12 November 2023

Scale/s:

|           |           |
|-----------|-----------|
| Revision: | Up to A16 |
|-----------|-----------|

Consultants Drawing number  
SL 231 - CCTV

DOPW Drawing numbe

Stampd by Plans Approval Committee