


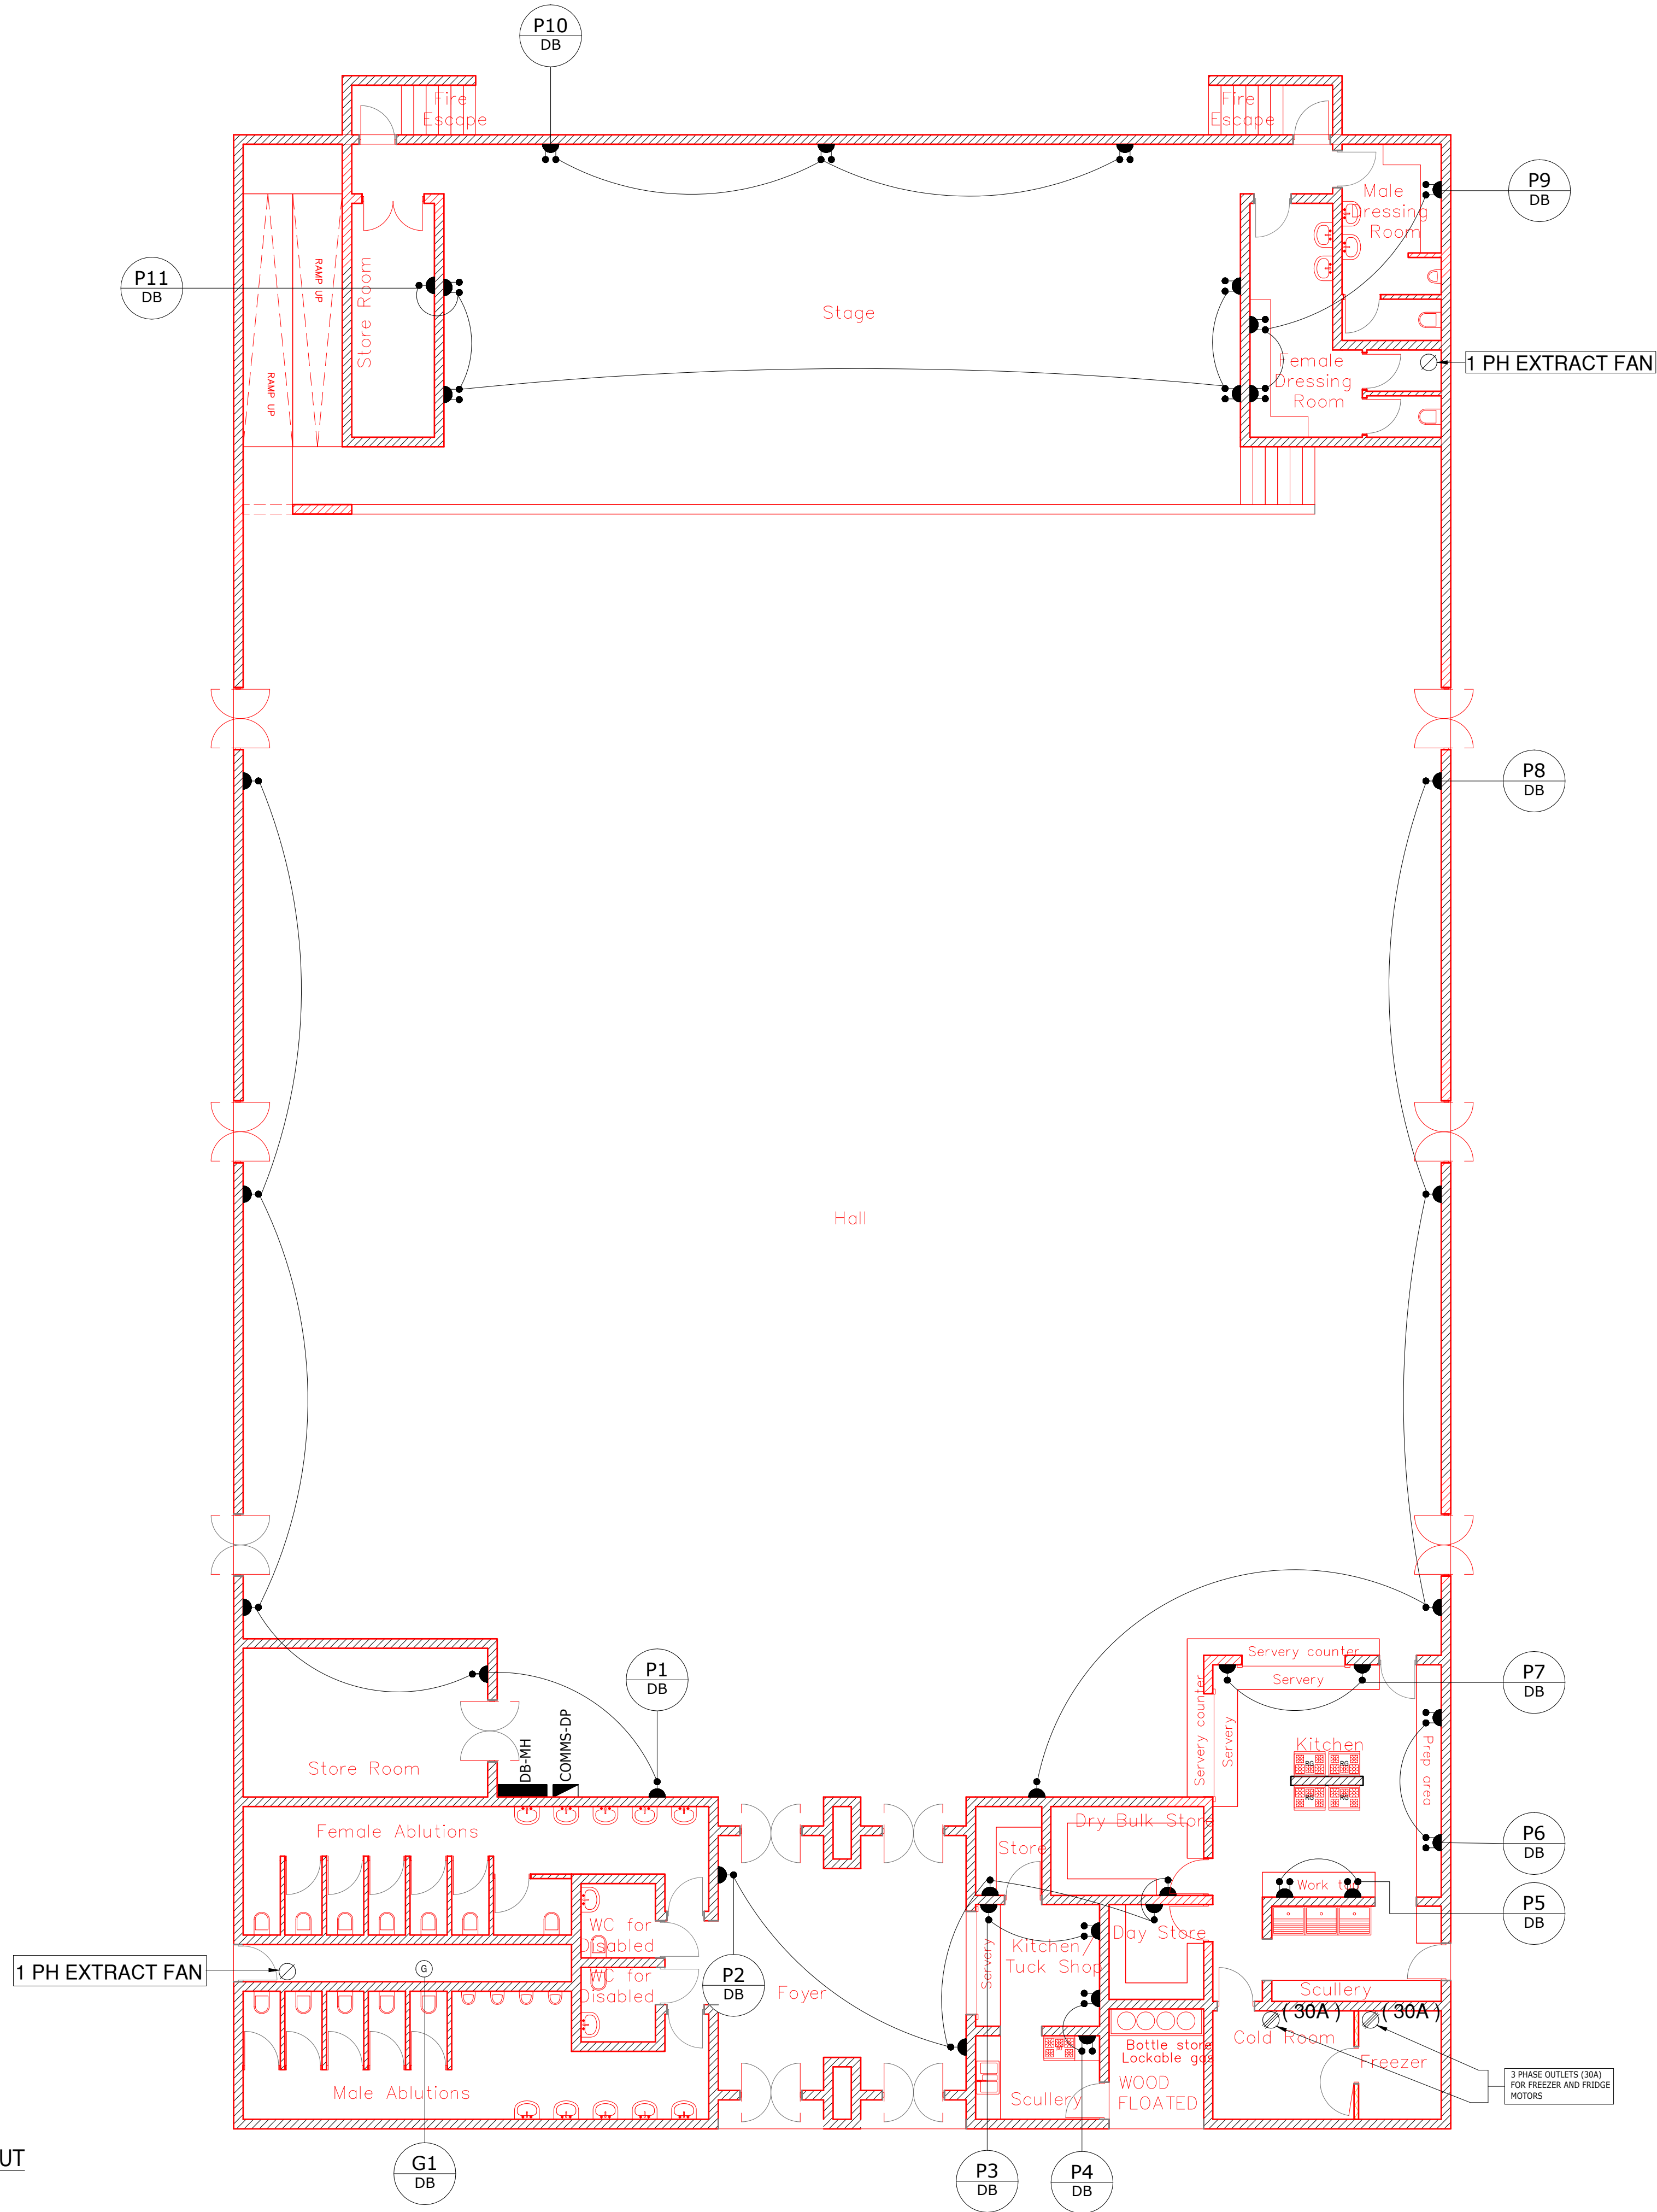

SMALL POWER LEGEND	
	COMMS, SECURITY AND FIRE DETECTION PANEL
	ELECTRICAL DISTRIBUTION BOARD
	DATA / VOICE OUTLET AT +300mm AFFL TO CENTRE IN 100x 100mm BOX.
	16A SWITCHED SOCKET OUTLET WITH 1x RSA 3-PIN SOCKET OUTLET MOUNTED AT +300mm AFFL TO CENTRE IN 100x 100mm BOX.
	P9000 TRUNKING IN CEILING VOID FOR LIGHTING AND POWER RETICULATION.
	P8000 TRUNKING IN CEILING VOID FOR COMMS / SECURITY AND FIRE RETICULATION.
	GEYSER OUTLET
	6A OUTLET FOR EXTRACTOR FAN
	3 PHASE OUTLET FOR REFRIGERATION

SMALL POWER LAYOUT
1:50

CONSTRUCTION

No.	DATE	AMENDMENT	
A	11/5/21	ISSUED FOR TENDER	D.A.
B	1/10/21	UPDATED FOR TENDER	D.A.

Copyright vests in the
Department of Public Works

as-built drawings

certified as-built drawings as per Centralised Drawing
Archive AS-BUILT DRAWING REQUIREMENTS

name: _____

date: _____

professional registration no.: _____

cad file name
EDIT

page type
A 1



consultant	
discipline ELECTRICAL	
service	
TROMPSBURG SPECIAL NEEDS SCHOOL ELECTRICAL AND ELECTRONIC	
WCS number EDIT	
drawing title MULTI-PURPOSE HALL SMALL POWER LAYOUT	
ref.no. EDIT	designed K.NEL
scale 1:100	drawn D.ALBIN
date 2018.11.02	checked K.NEL
DPW drawing number E6(17)(a)	