

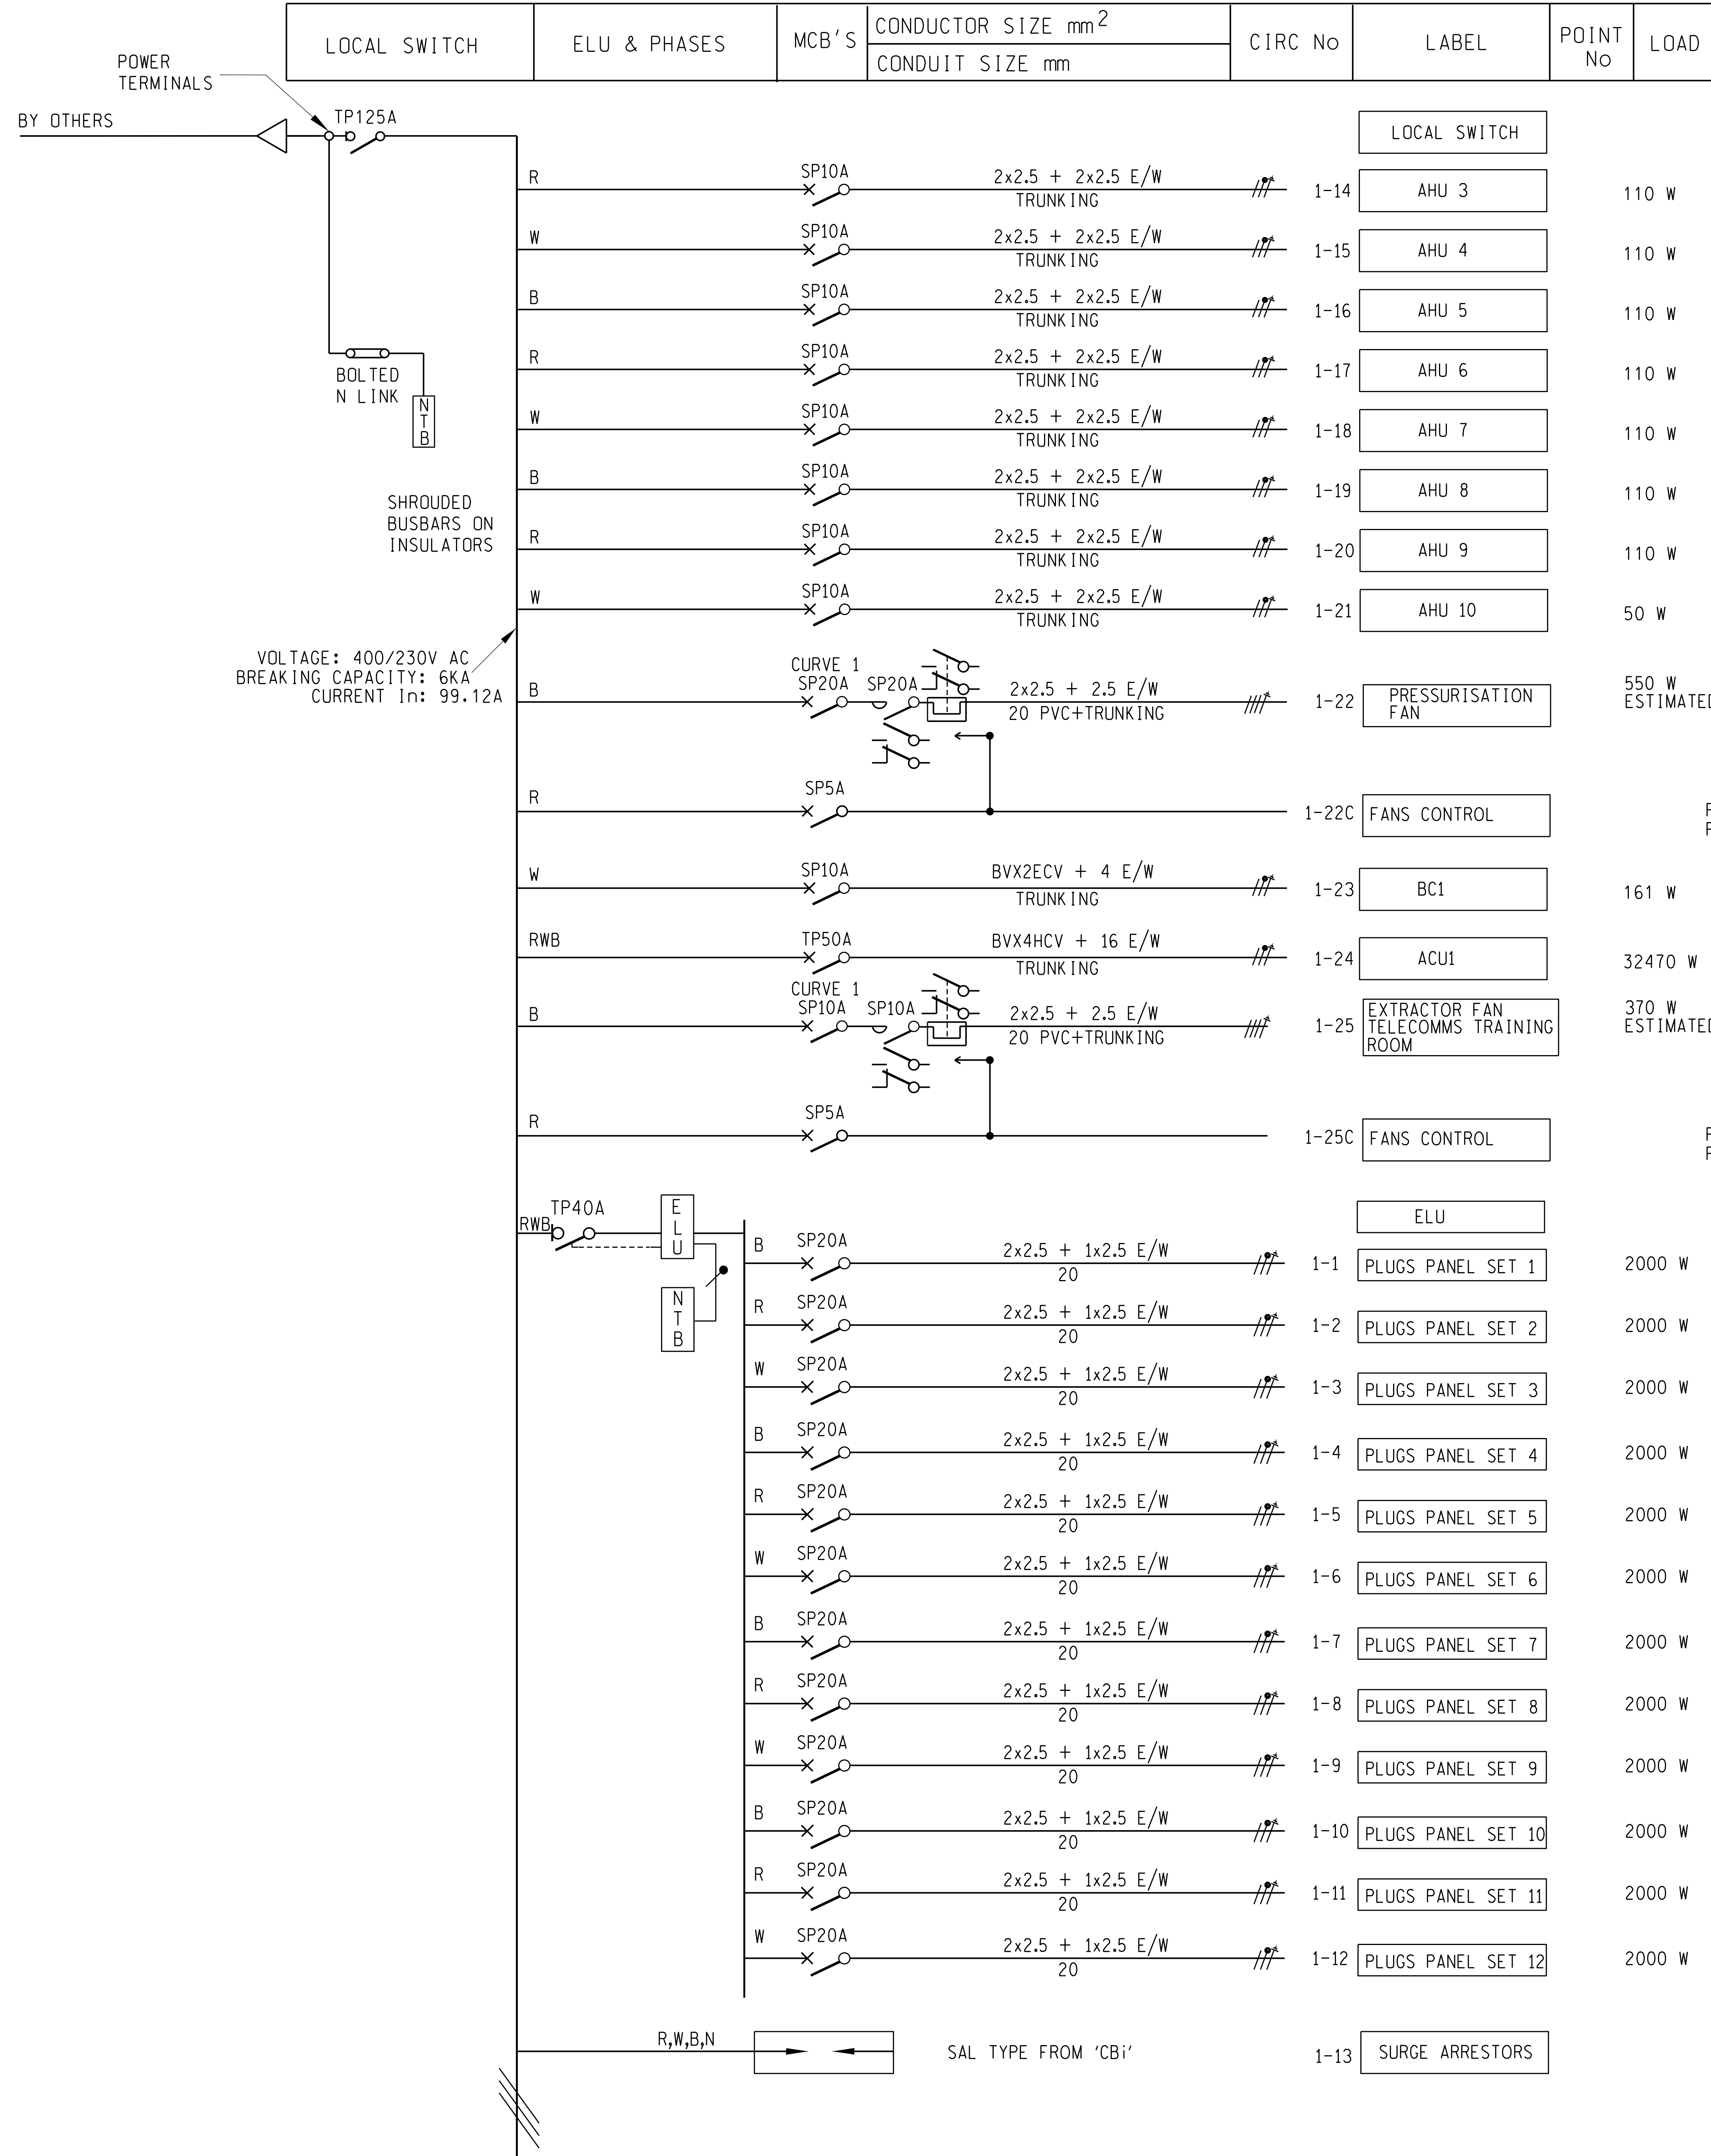


DISTRIBUTION BOARD BY OTHERS

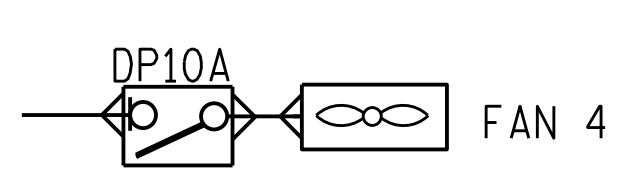

VOLTAGE: 400/230V AC  
BREAKING CAPACITY: 6KA  
CURRENT In: 99.12A

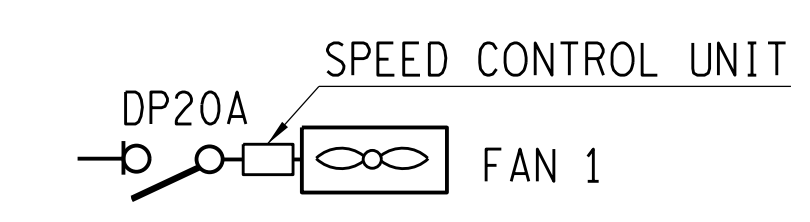

ELECTRICAL LEGEND:  
(IN ACCORDANCE WITH NRS002)

—X— O — CIRCUIT BREAKER  
—b— O — SWITCH-DISCONNECTOR

**FINAL DESIGN  
FOR CONSTRUCTION**

REV	REVISION DESCRIPTION	DRAWN	CHKD	AUTH	DATE	REFERENCE DRAWINGS
APPROVED BY	Eskom		National Transmission Company South Africa SOC Ltd		Reg No 2021/539129/30	
CHECKED BY	<p><b>SIMMERPAN COMPLEX</b> TELECOMMS LAB SCHEMATIC DIAGRAM LAYOUT</p>					
DRAWN BY						
SCALE						