
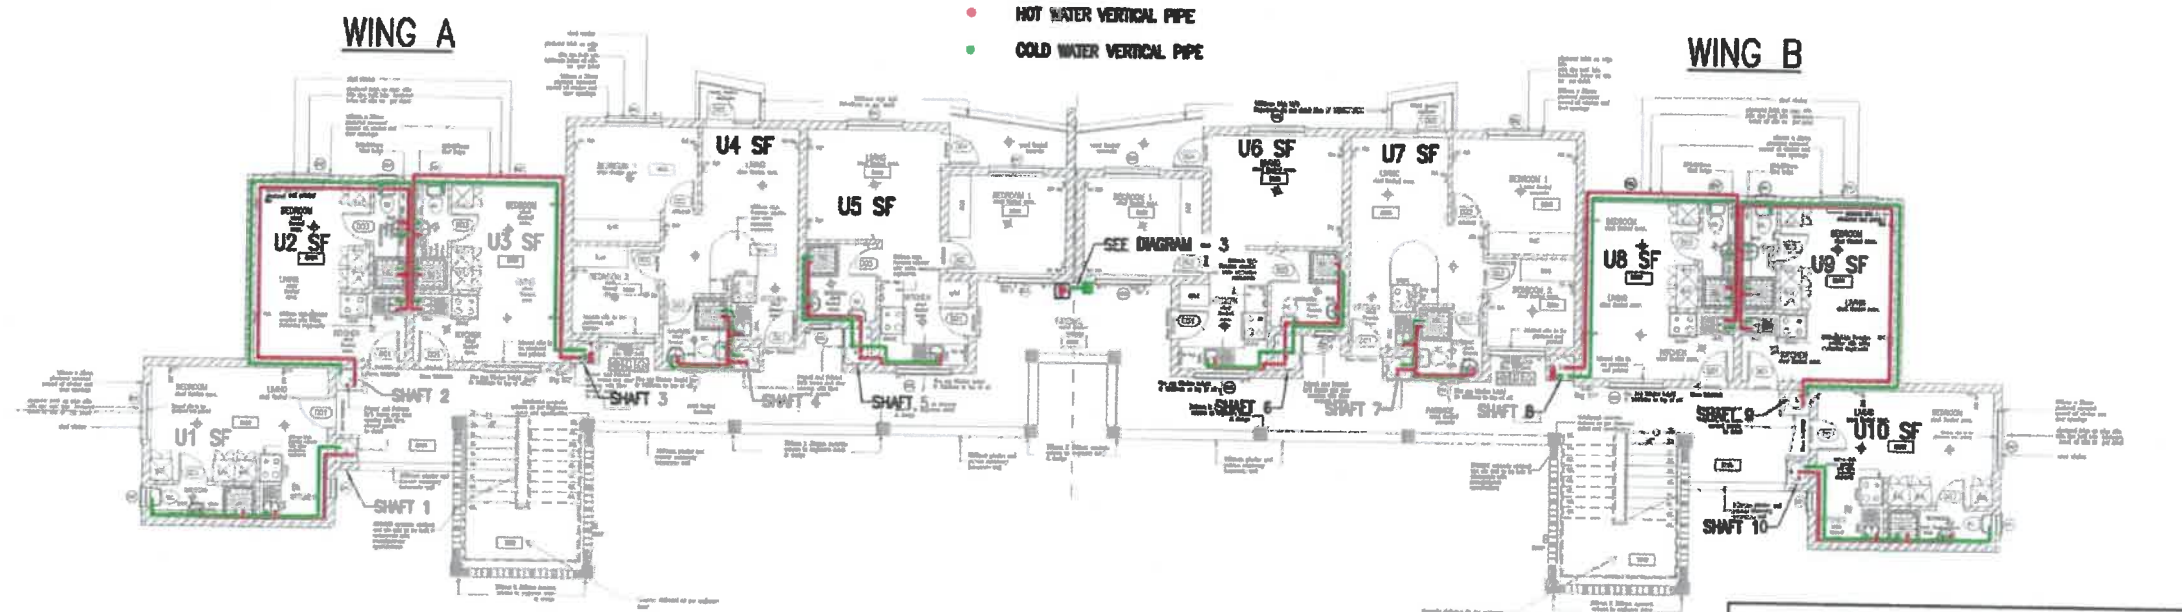


 COLD WATER
 HOT WATER
 HOT WATER RE-CIRCULATION LOOP
 STOP VALVE
 METER
 DOUBLE CHECK VALVE ASSEMBLY
 FIRE HYDRANT IN CABINET
 FIRE MAIN WATER RISER #100 PIPE
 P1 - (HOT WATER RETICULATION PUMP)

 HOT WATER UNIT
 COLD WATER UNIT
 HOT WATER VERTICAL PIPE
 COLD WATER VERTICAL PIPE

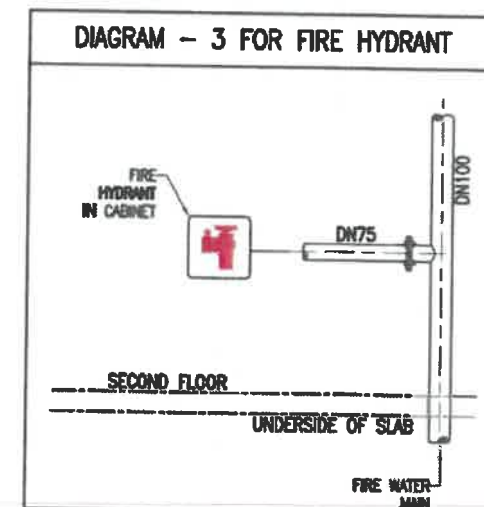

TYPE A: SECOND FLOOR PLAN
SCALE 1:100

[illegible]

FREE STATE PROVINCIAL GOVERNMENT
DEPARTMENT OF HUMAN SETTLEMENT

Physical Address	Postal Address
------------------	----------------



Project 2: 40000

BYE HOME

Building 1 Office Park (Industrie Plaza)
5 Elm Road

Seating EN 2157
Tel: 182 00 44 001 0000

APPROVED BY:	S.MOULDER
--------------	-----------

PUB. INFORMATION: 20180266

DATE: 05-03-20

**Project Name: DARK & SILVER CITY
HOUSING DEVELOPMENT
(BOTTOM SITE)**

**HOT AND COLD WATER
RETICULATION- TYPE A**

APPROVED	R. MOORE		08-08-2010
ENGINEER	P. HANSEN		08-08-2010
CHECKED	R. HANSEN		08-08-2010
DRAWN	P. HANSEN		08-08-2010

ALL RIGHTS ON THIS COVERED BEST AT ANY TIME WITH LIFE COORDINATING.
WORKOUT UNDER WRITING CONSENT IT MAY NOT BE COPIED, REPRODUCED,
COMMUNICATED OR OTHERWISE ACCOUNTED TO THIRD PARTIES.

Client Meeting No.	Rev
123 Meeting No.	

E404-Mec-09-3	5
---------------	---