
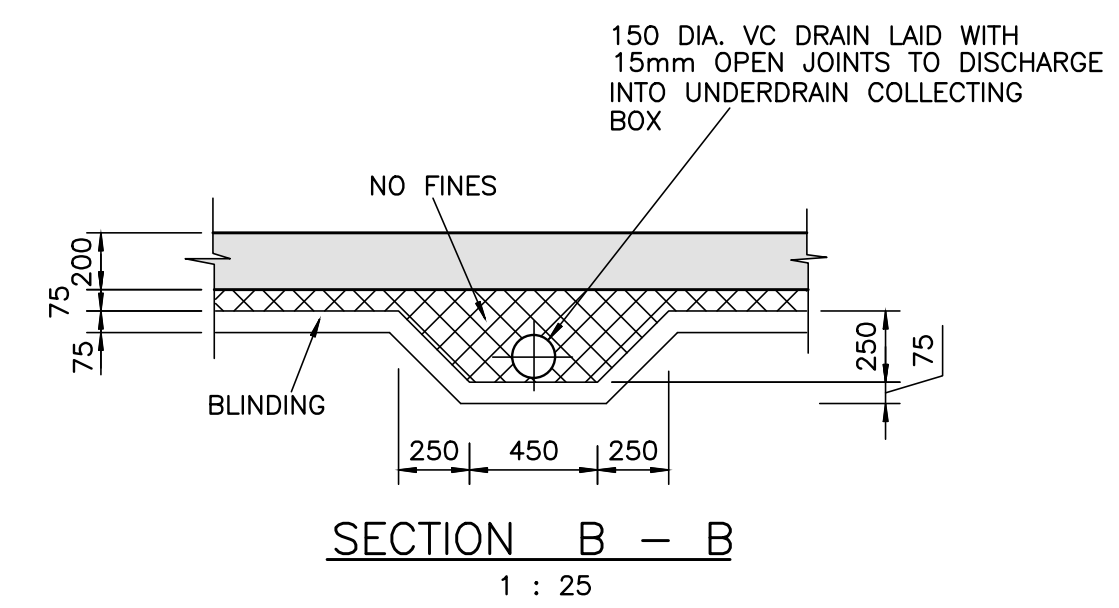
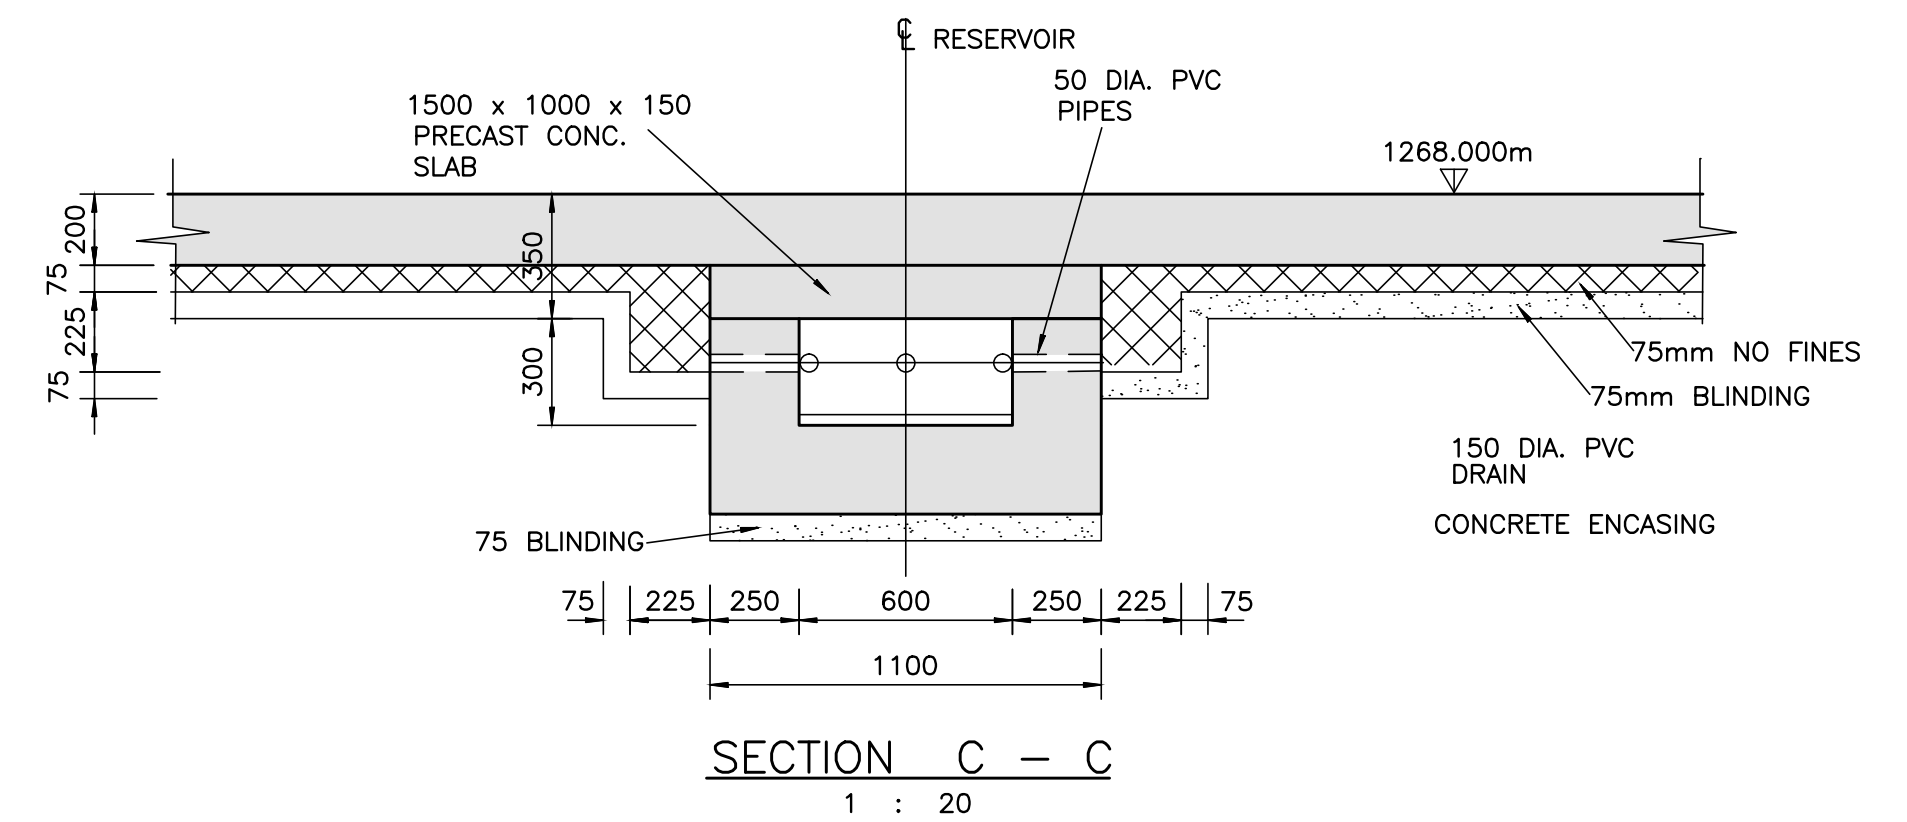
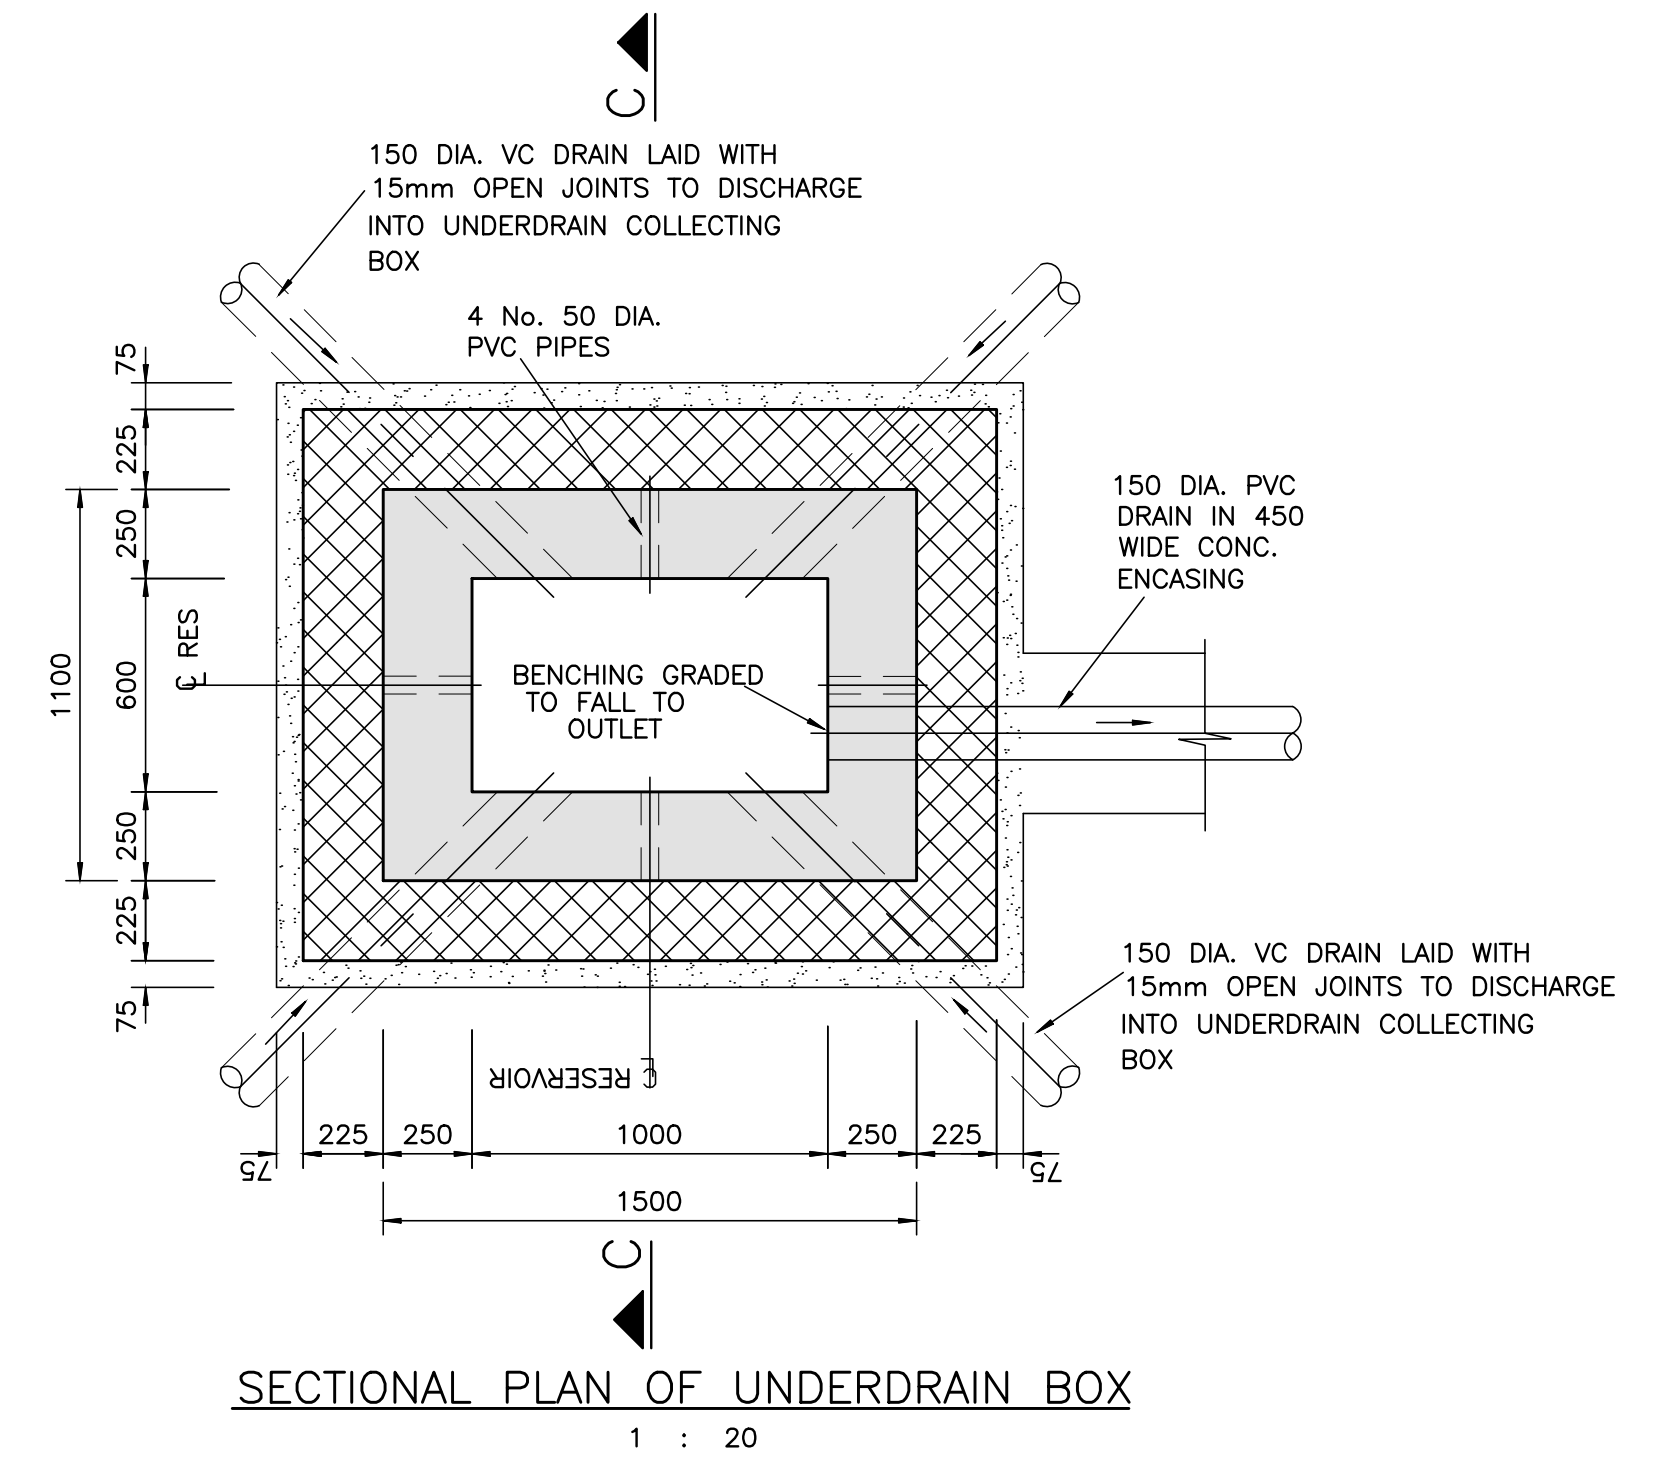


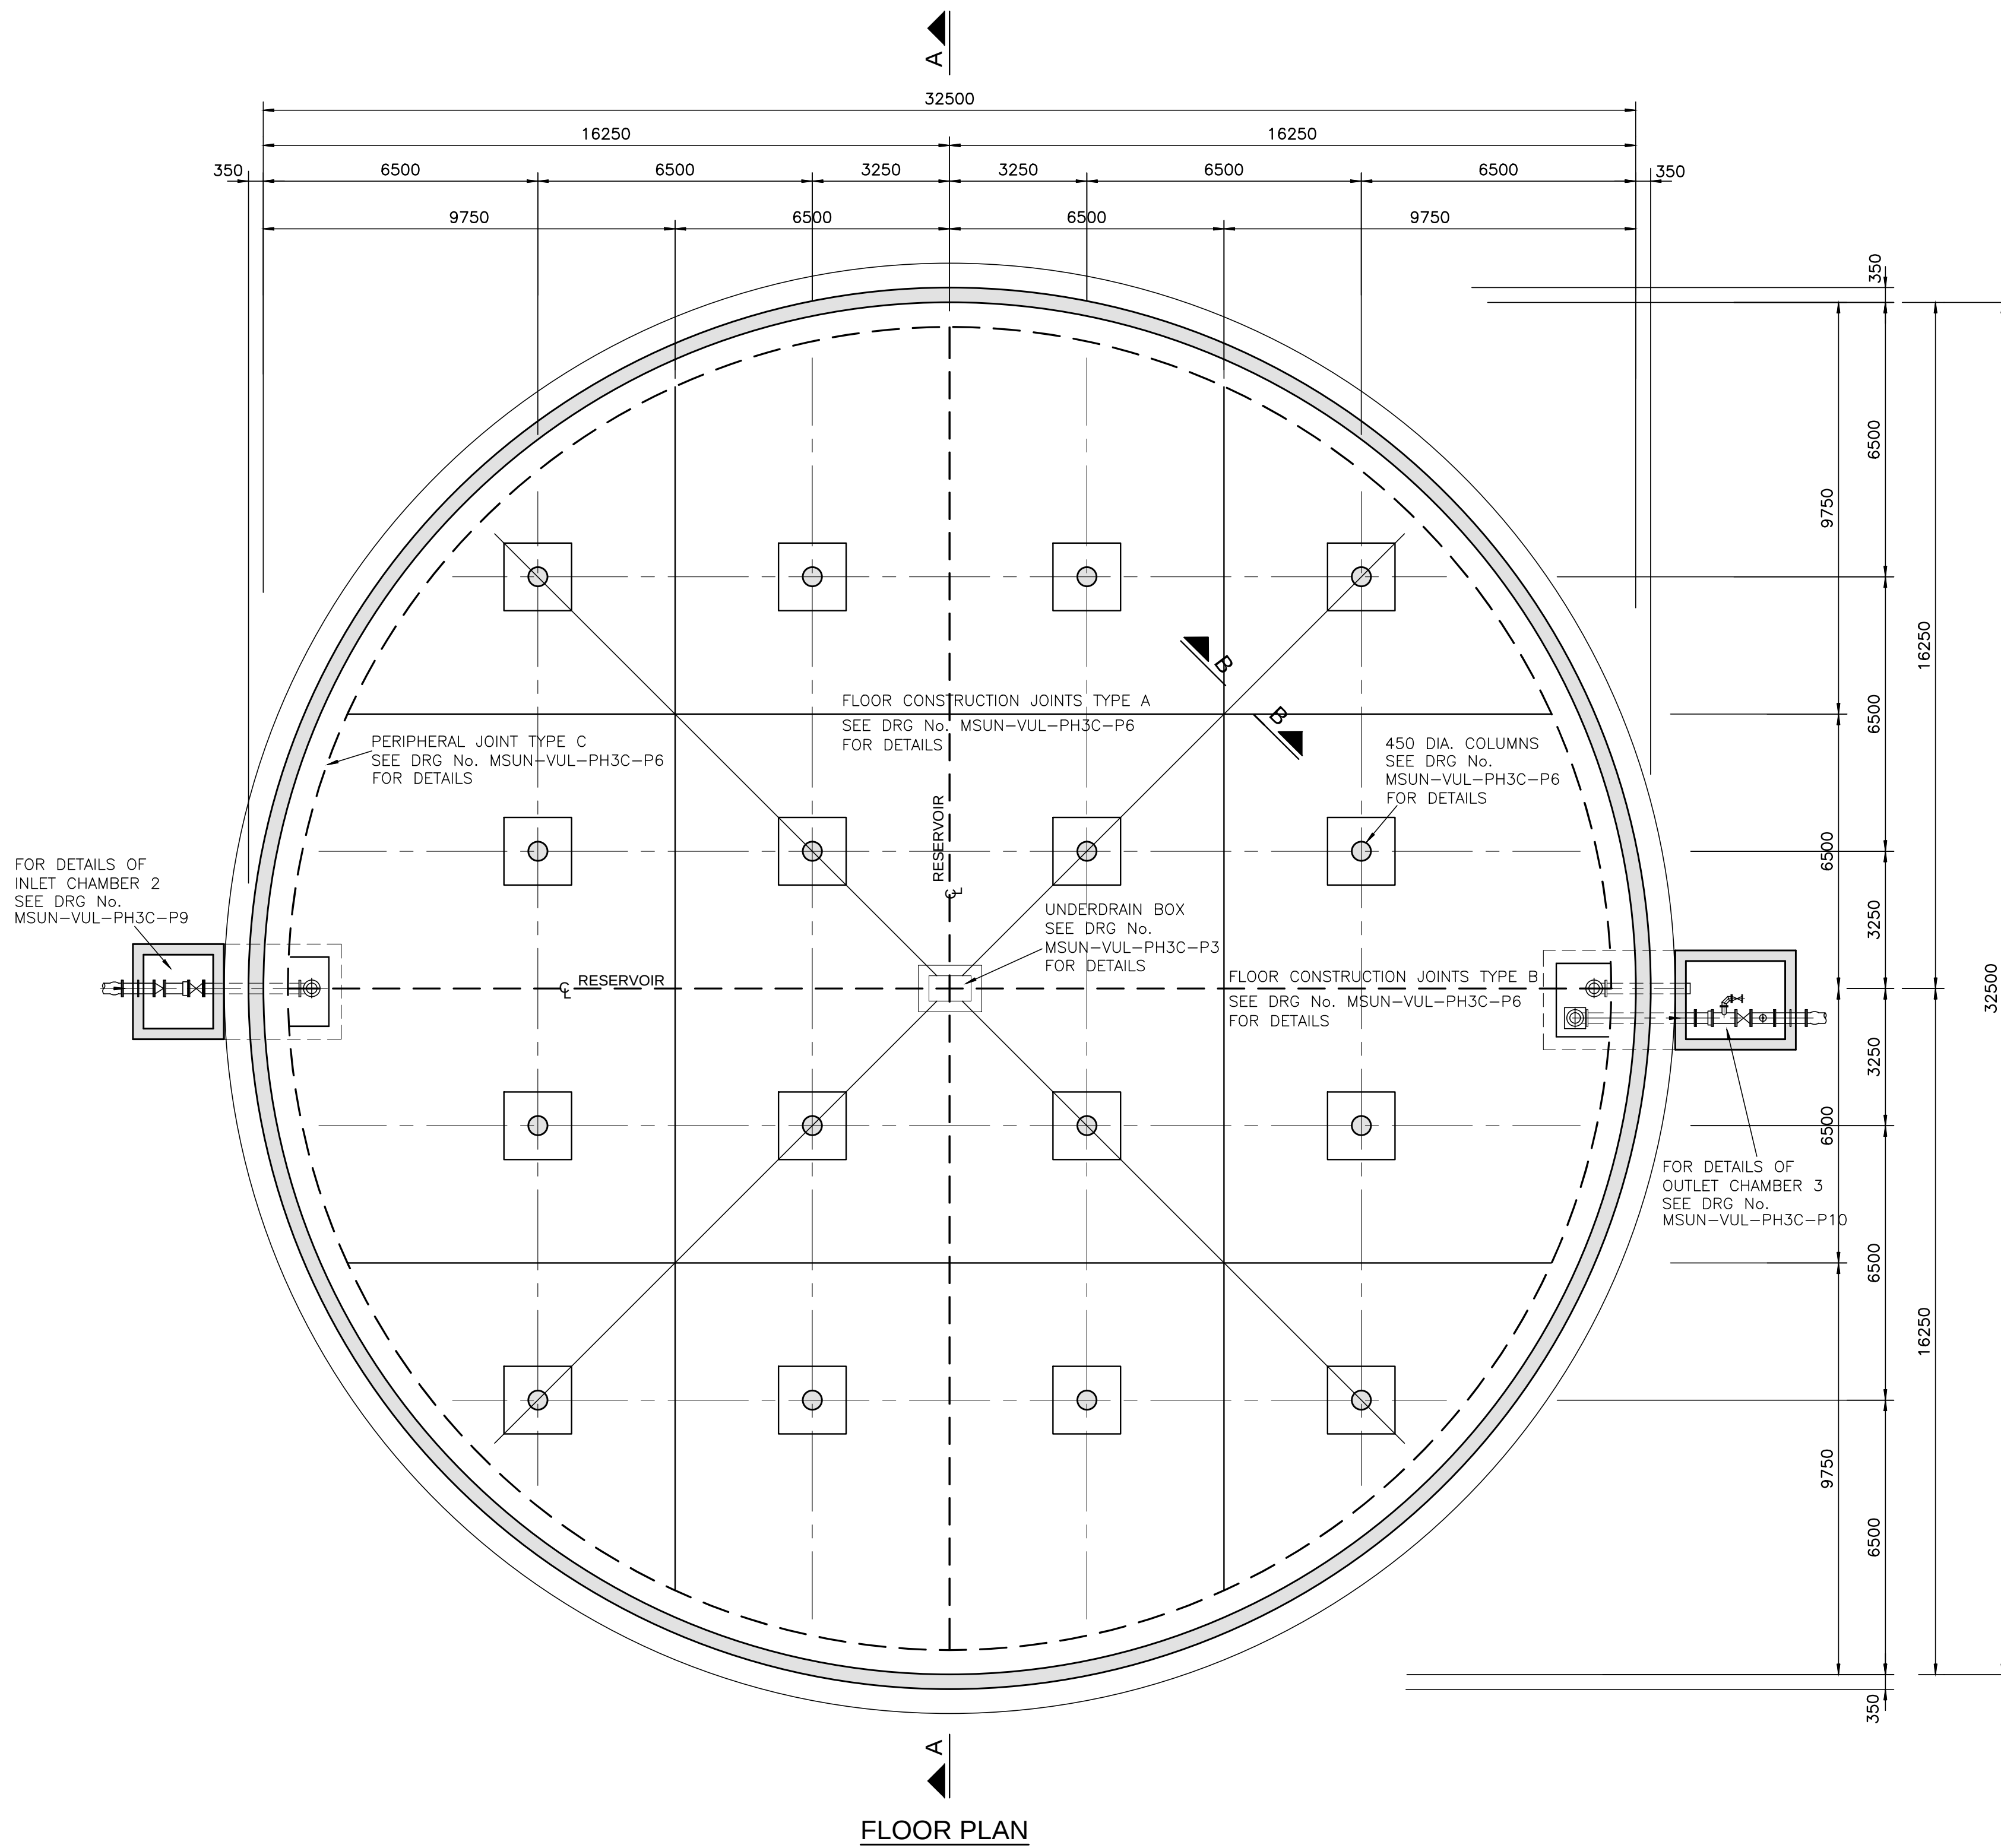

TENDER DRAWING

ORIGINAL SCALE AS SHOWN	
ALT. DWG. No.	CONTRACT No.
SHT. No.	OF PROJECT No.
DRAWING No. MSUN-VUL-PH3C-P3	REVISION 0


No.	REFERENCE DRAWINGS
0	ISSUED FOR TENDER
JUL 25	DATE
CHKD	APPRV
REVISIONS	

DESIGNED	R. PILLAY
CHECKED	
DRAWN	P.N
CHECKED	
PROJ. ENG.	M NSIBIRWA PR REG No. 930101

LINGELA
CONSULTING ENGINEERS (PTY) LTD

APPROVED : (FOR TENDER)

M NSIBIRWA
PR REG No. 930101

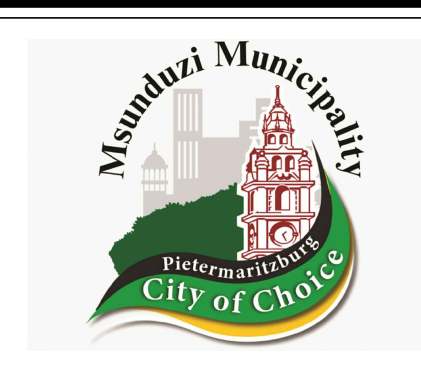

PROJECT/DRAWING TITLE

MSUNDUZI MUNICIPALITY
VULINDLELA PHASE 3C – WATER SUPPLY UPGRADE
PROPOSED RESERVOIR 13A (5.50 ML RESERVOIR)
FLOOR PLAN AND DETAILS