
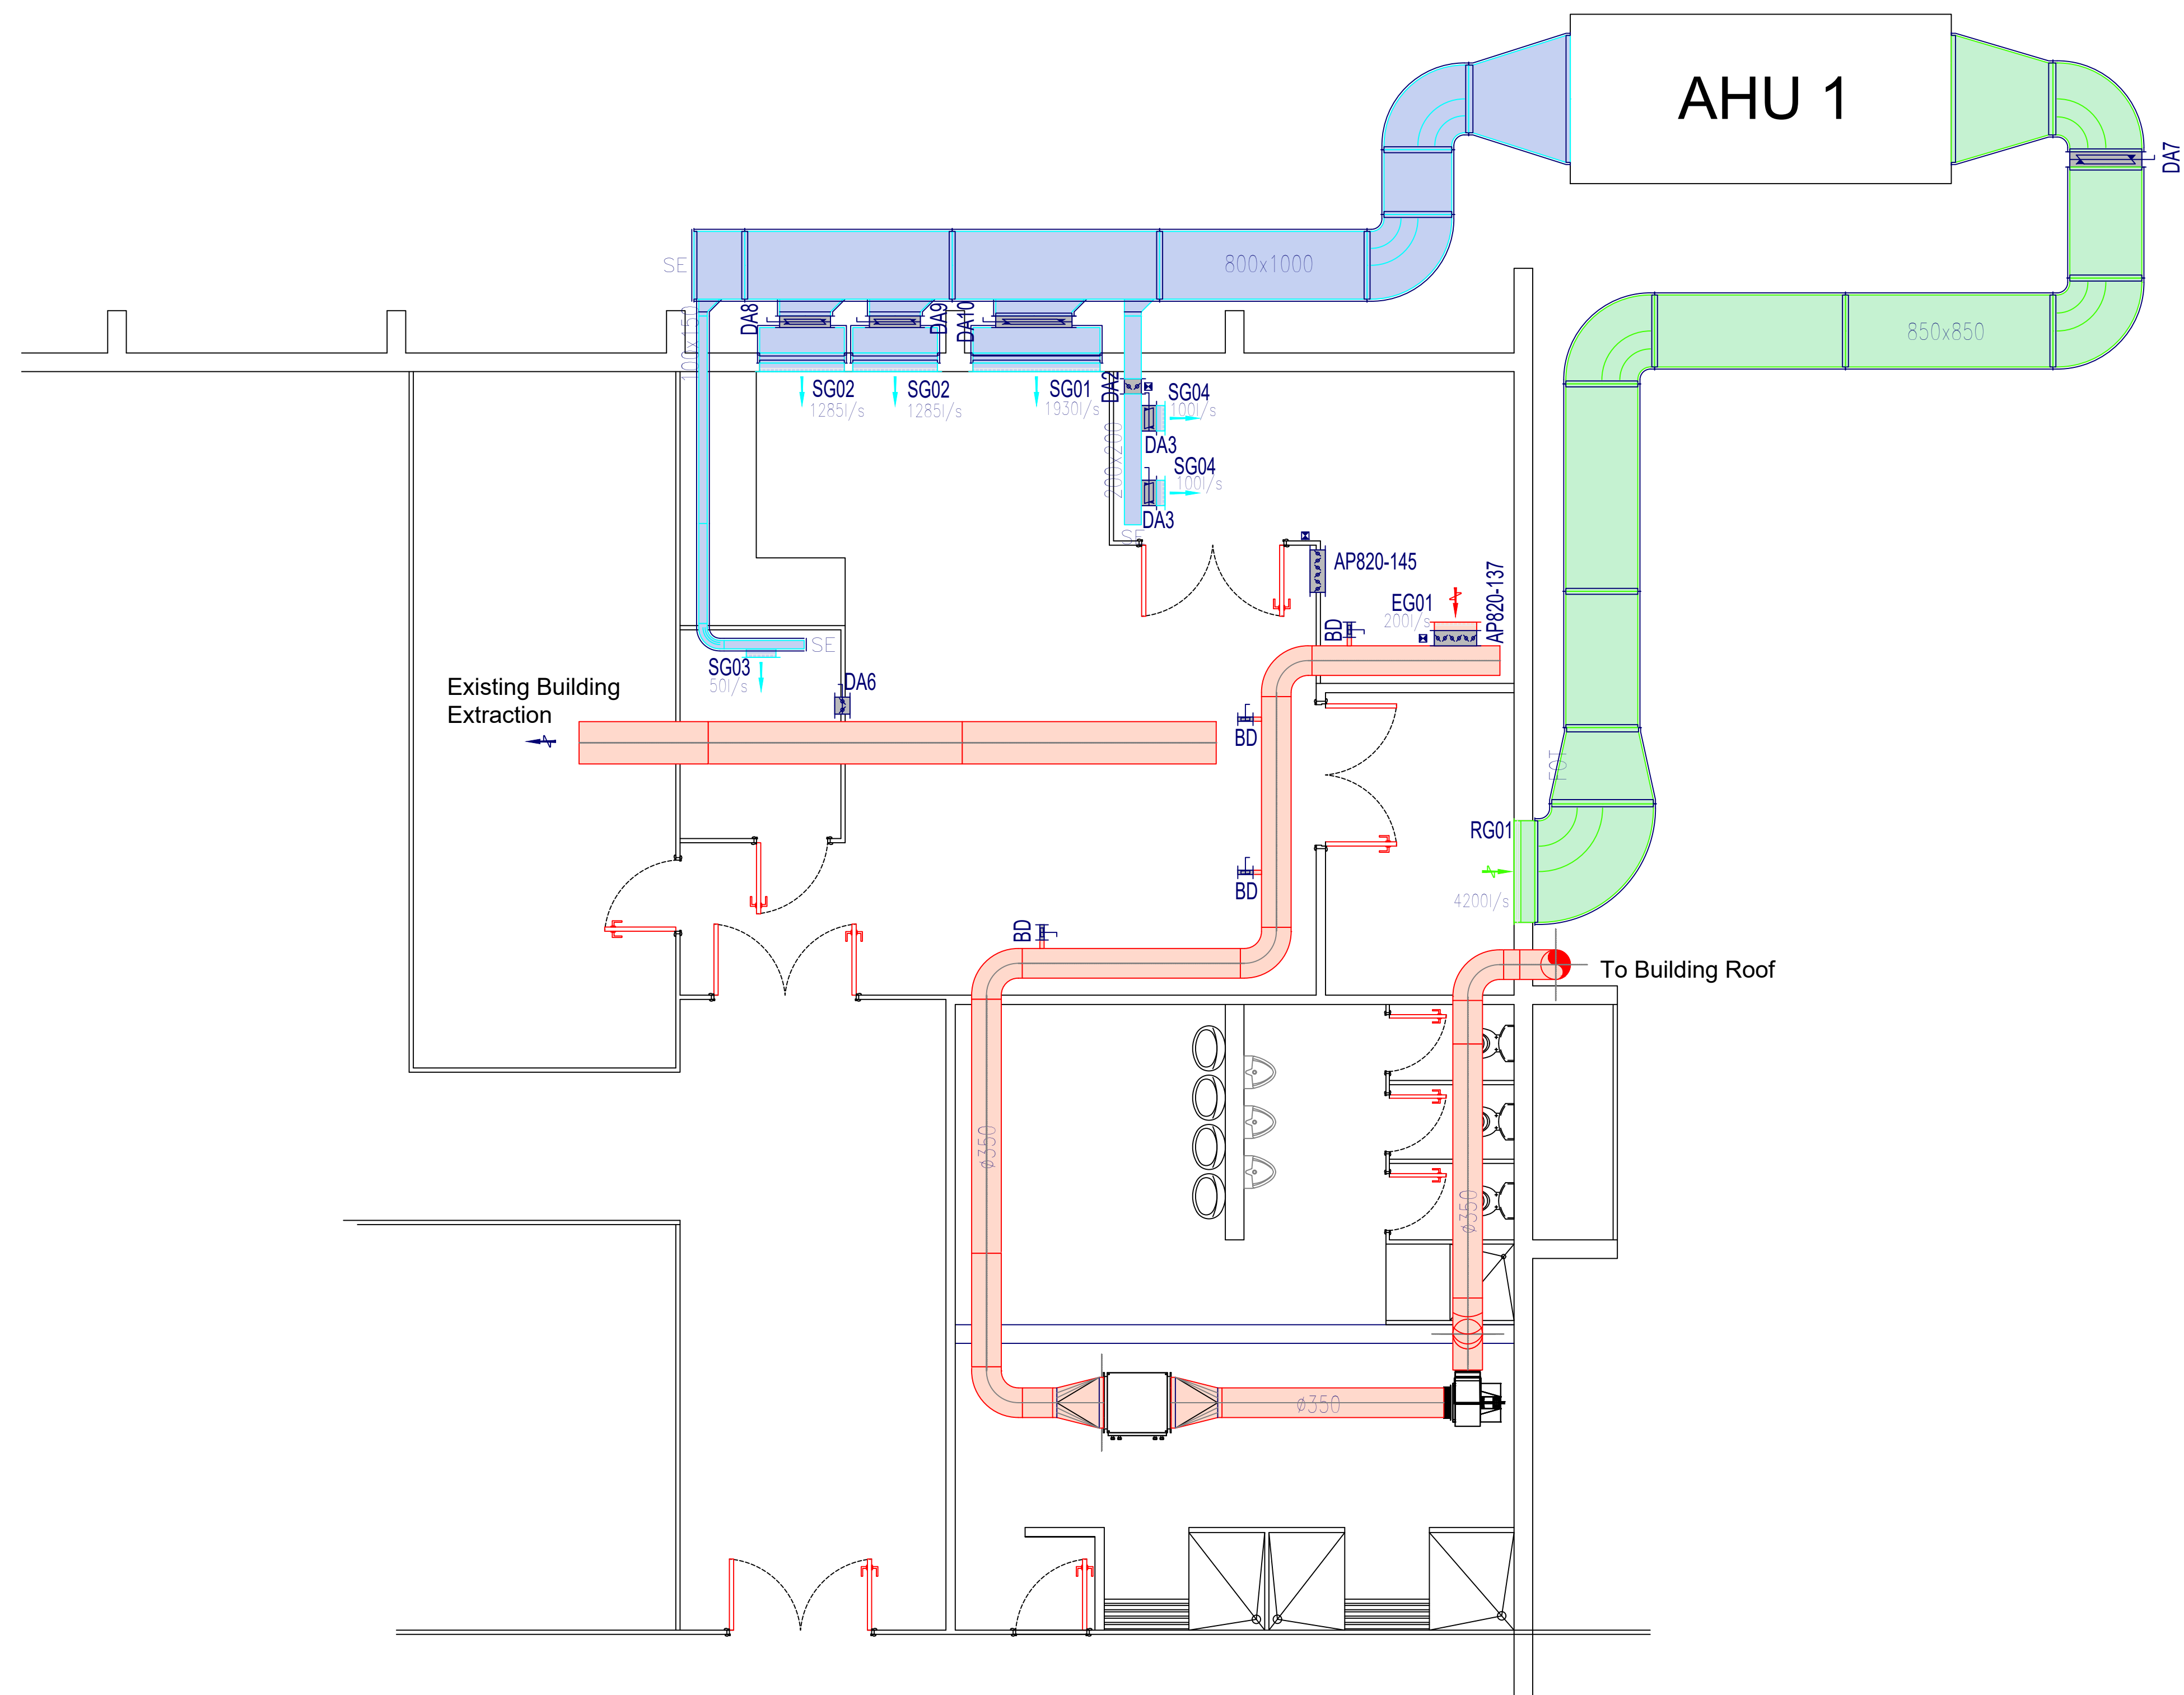


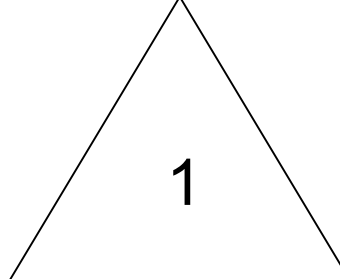

Notes: None.		PTFE PlasGas HVAC Layout		
	COPYRIGHT This drawing is the property of NECSA and may not, without written permission, be copied, communicated to a third party, or be used either wholly or in part for any purpose other than for which it is supplied	PTFE PlasGas Demonstration Facility		
		Drawing No.: ENS-FDP-DWG-24001		
		CONFIDENTIAL		