



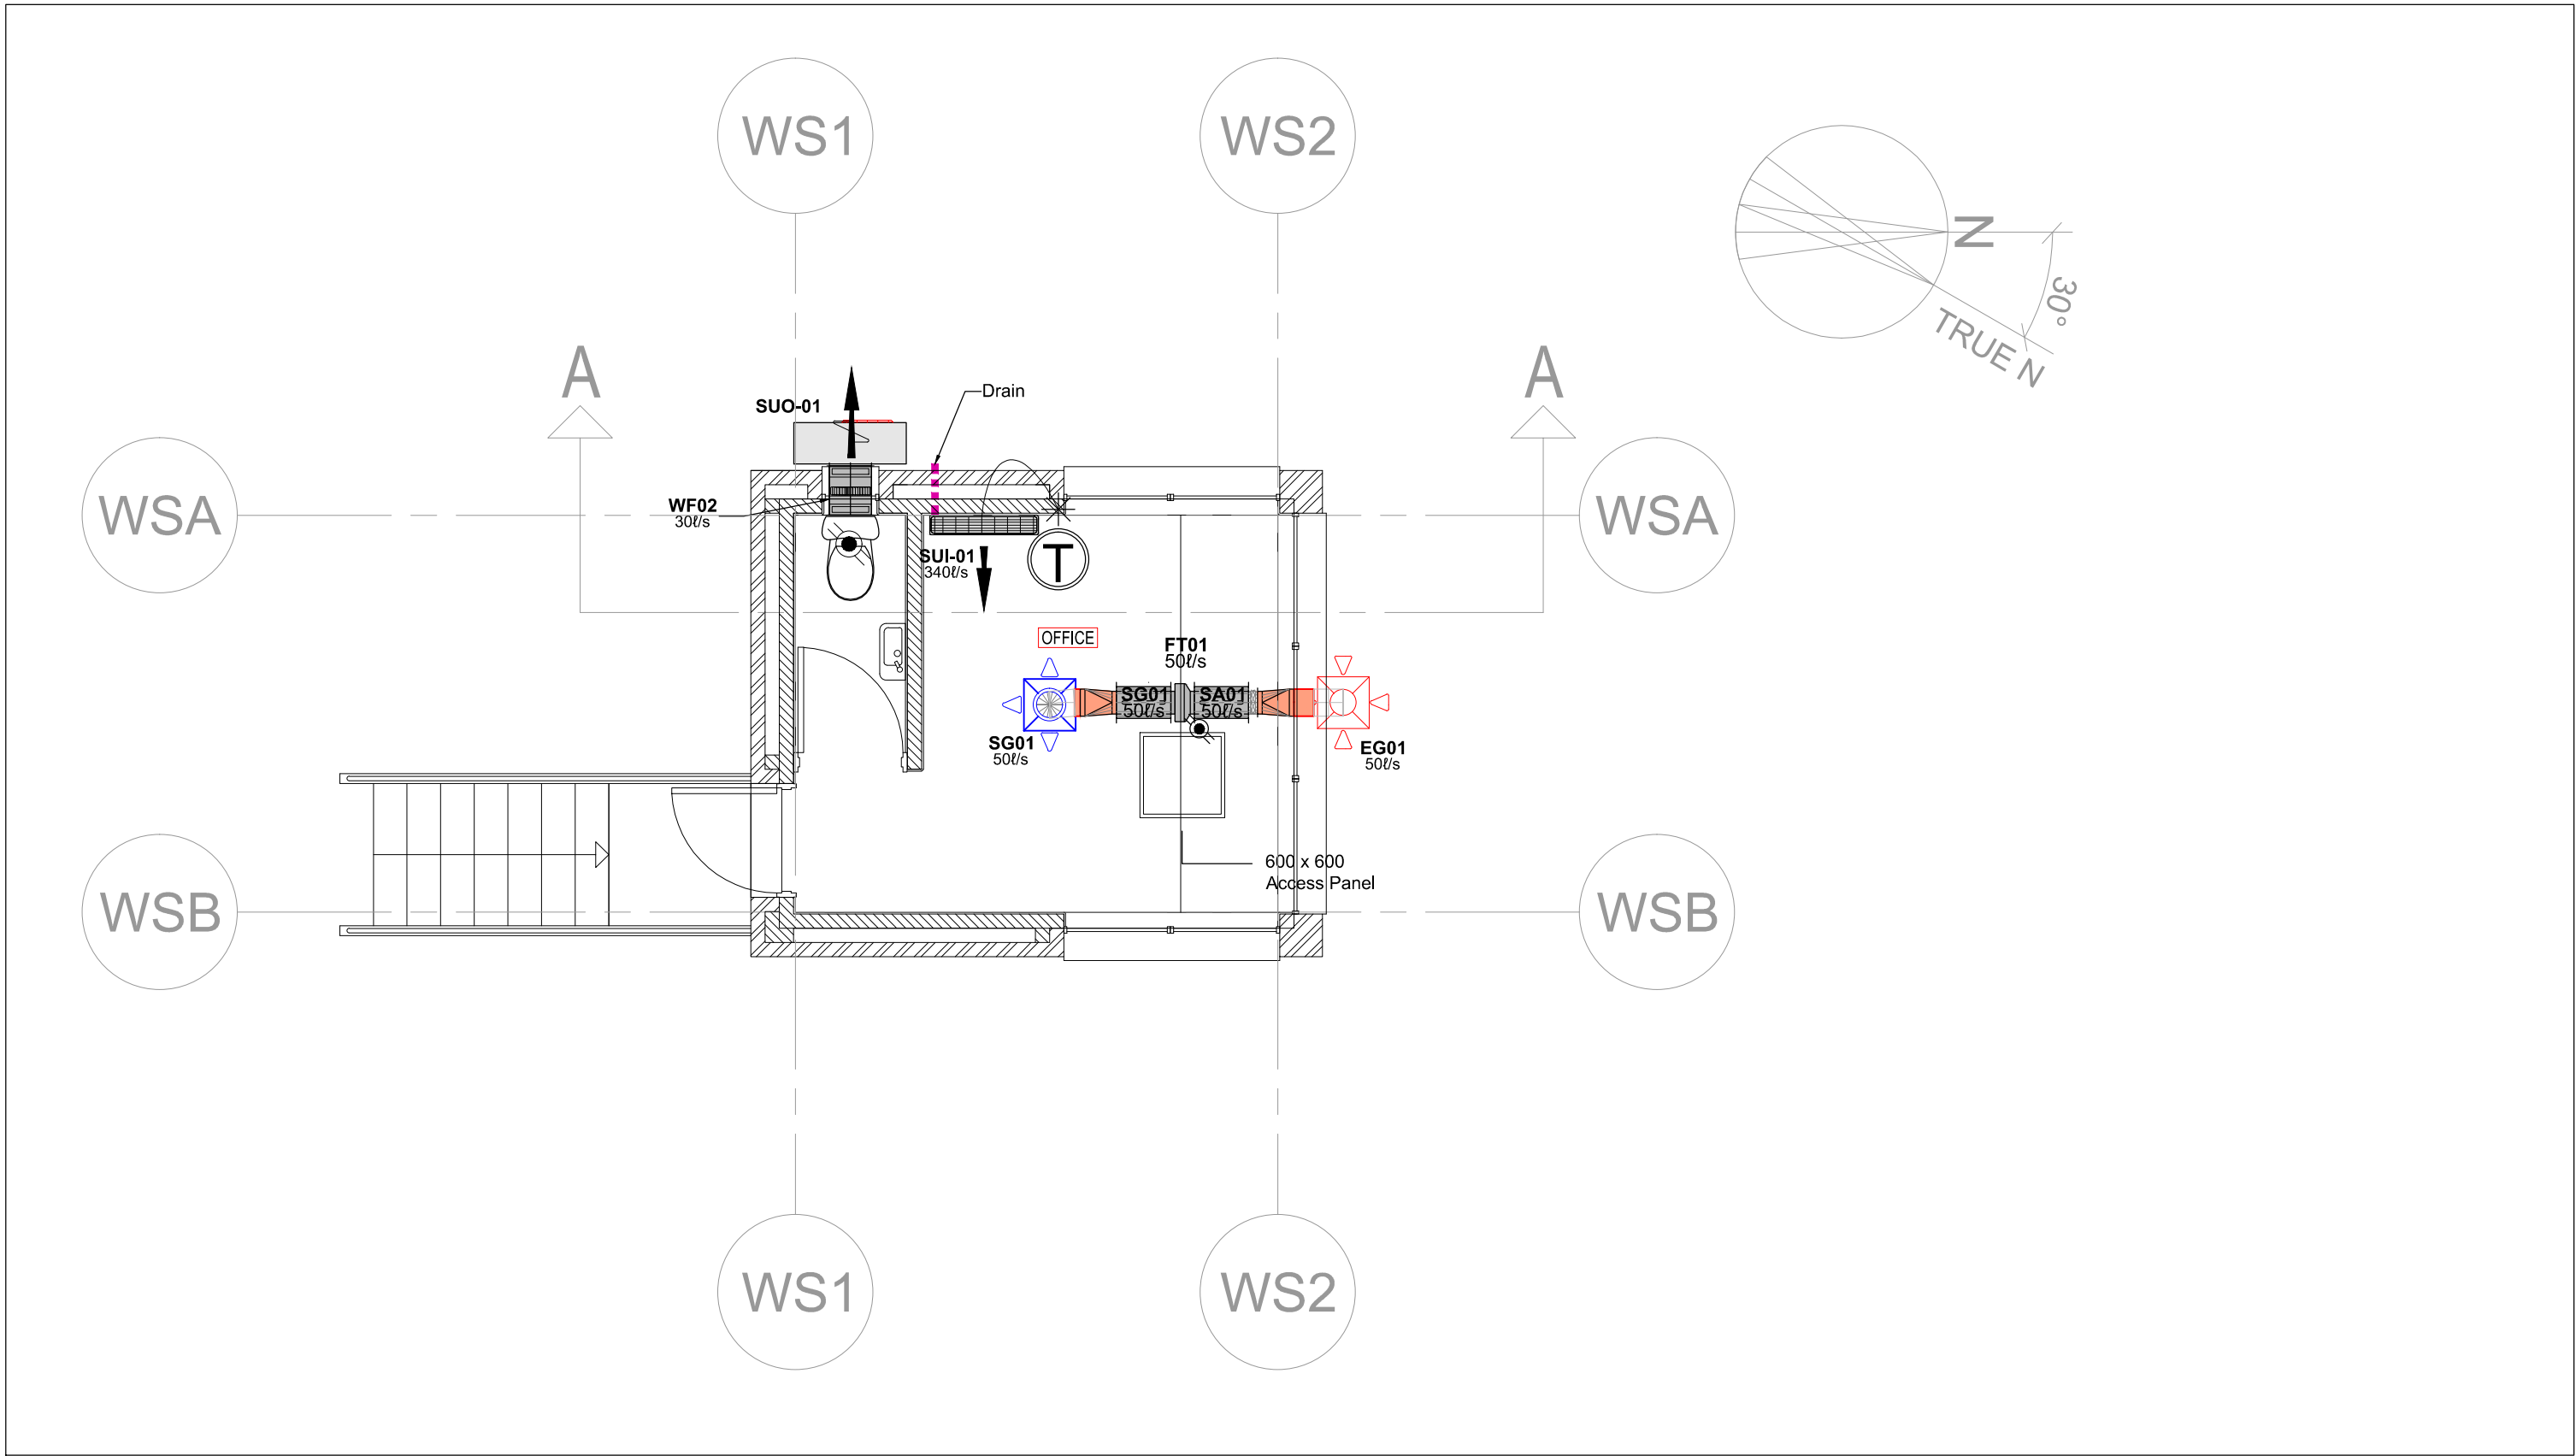

GROUND FLOOR PLAN
SCALE 1:50

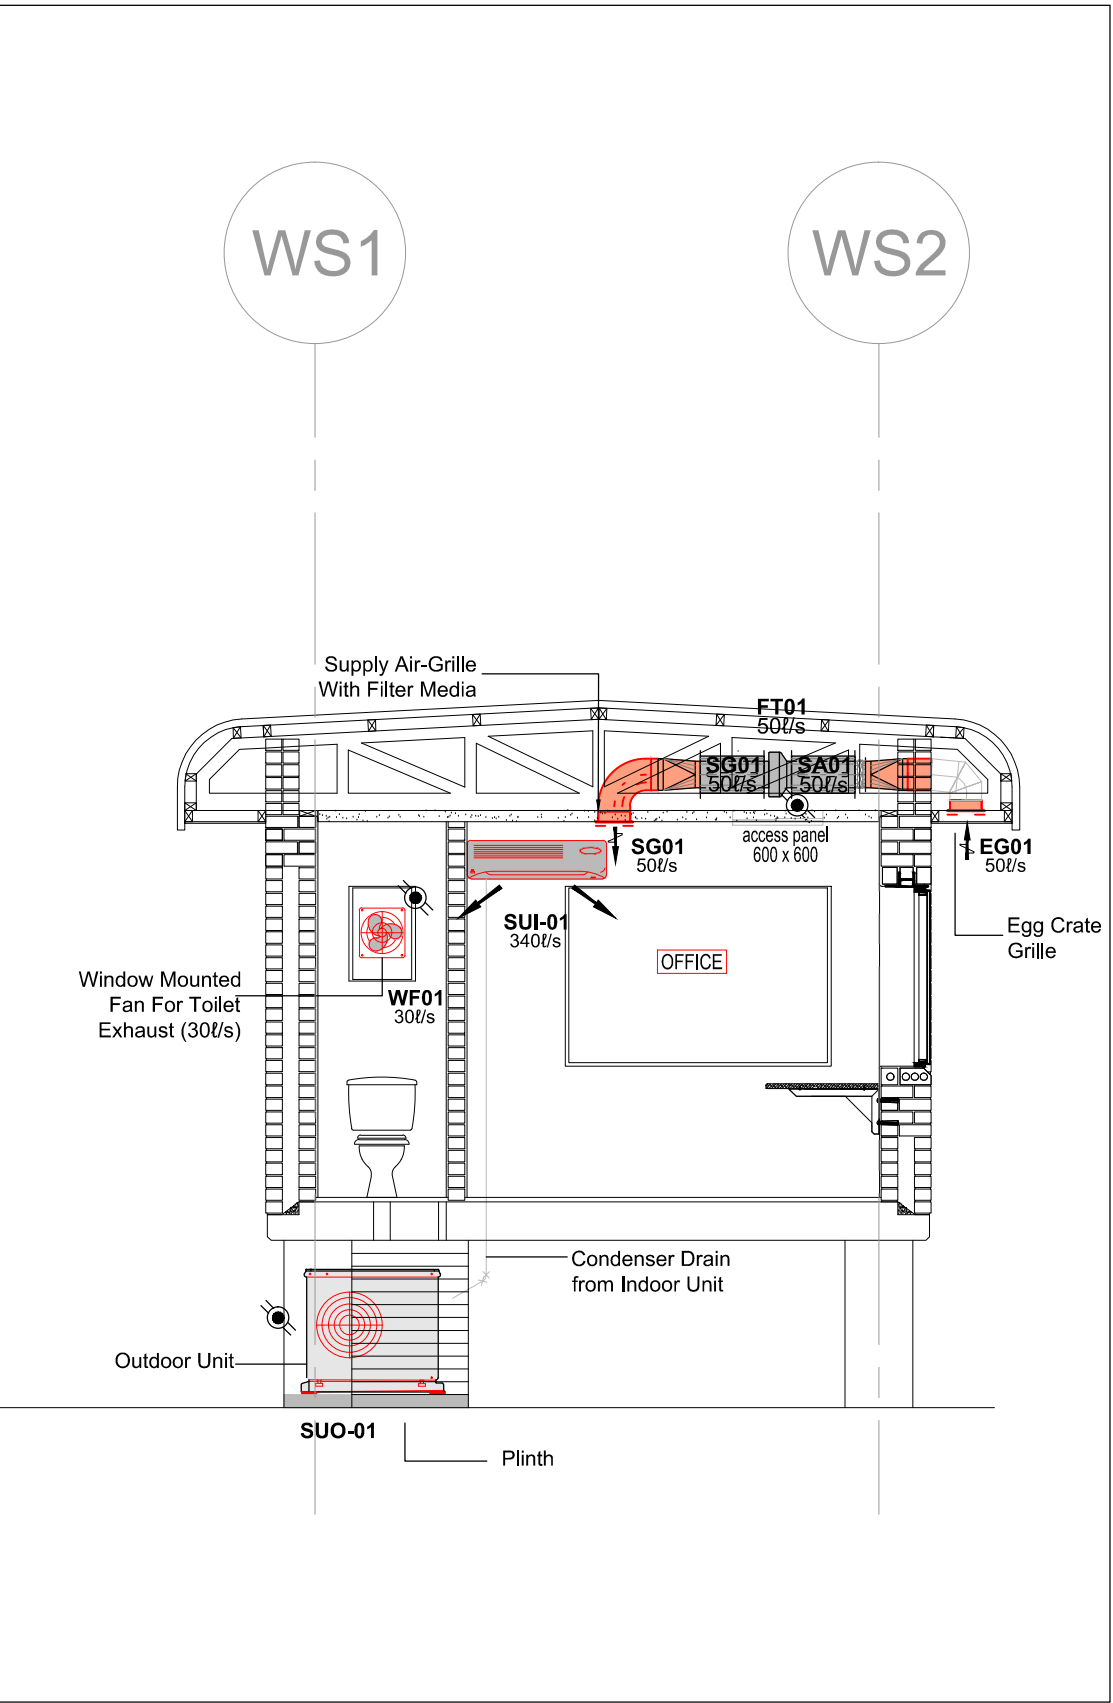

SECTION (A - A)
SCALE 1:50

ISSUED FOR INFORMATION

DM	A	03.02.2017	Issued for Information	DTC	JJB	DTC	-	ARCHITECT	07015-AE-23.101
D.O.	REV	DATE	** REVISION **		REV	CHKD	AUTH	KKS	REFERENCE DRAWINGS
DRG	REGISTR	-	-	AUTHORISED FOR ESKOM BY	DATE				
DESIGN	APPROVED	03.02.2017	DTC	-	-				
KKS	APP	-	-						
DO	AUTH	03.02.2017	DTC						
CHKD	BY	03.02.2017	JJB						
DRAWN	BY	03.02.2017	DM						
SCALE	1:100								

SHEET		REV
1		A

MEDUPI POWER STATION
WEIGH BRIDGE CONTROL
BUILDING
GROUND FLOOR HVAC
LAYOUT AND SECTION

08073 - AE - 4GF

0.84/50891