

O & M MAIN DISTRIBUTION BOARD

AC3/F/80/33

SWITCH LABEL
O & M MAIN DISTRIBUTION BOARD


BOARD LABEL
WORKSHOP AND STORES
LIGHTING DISTRIBUTION BOARD

PROVIDE 3-20A DP ELU WITHOUT O/L
PROTECTION FOR CIRCUIT NUMBERS 7
TO 9 IN ACCORDANCE WITH SANS 767

TOTAL LOAD

RED ϕ = 72 AMPS
WHITE ϕ = 69 AMPS
BLUE ϕ = 65 AMPS

DP - DENOTES DOUBLE POLE MCB

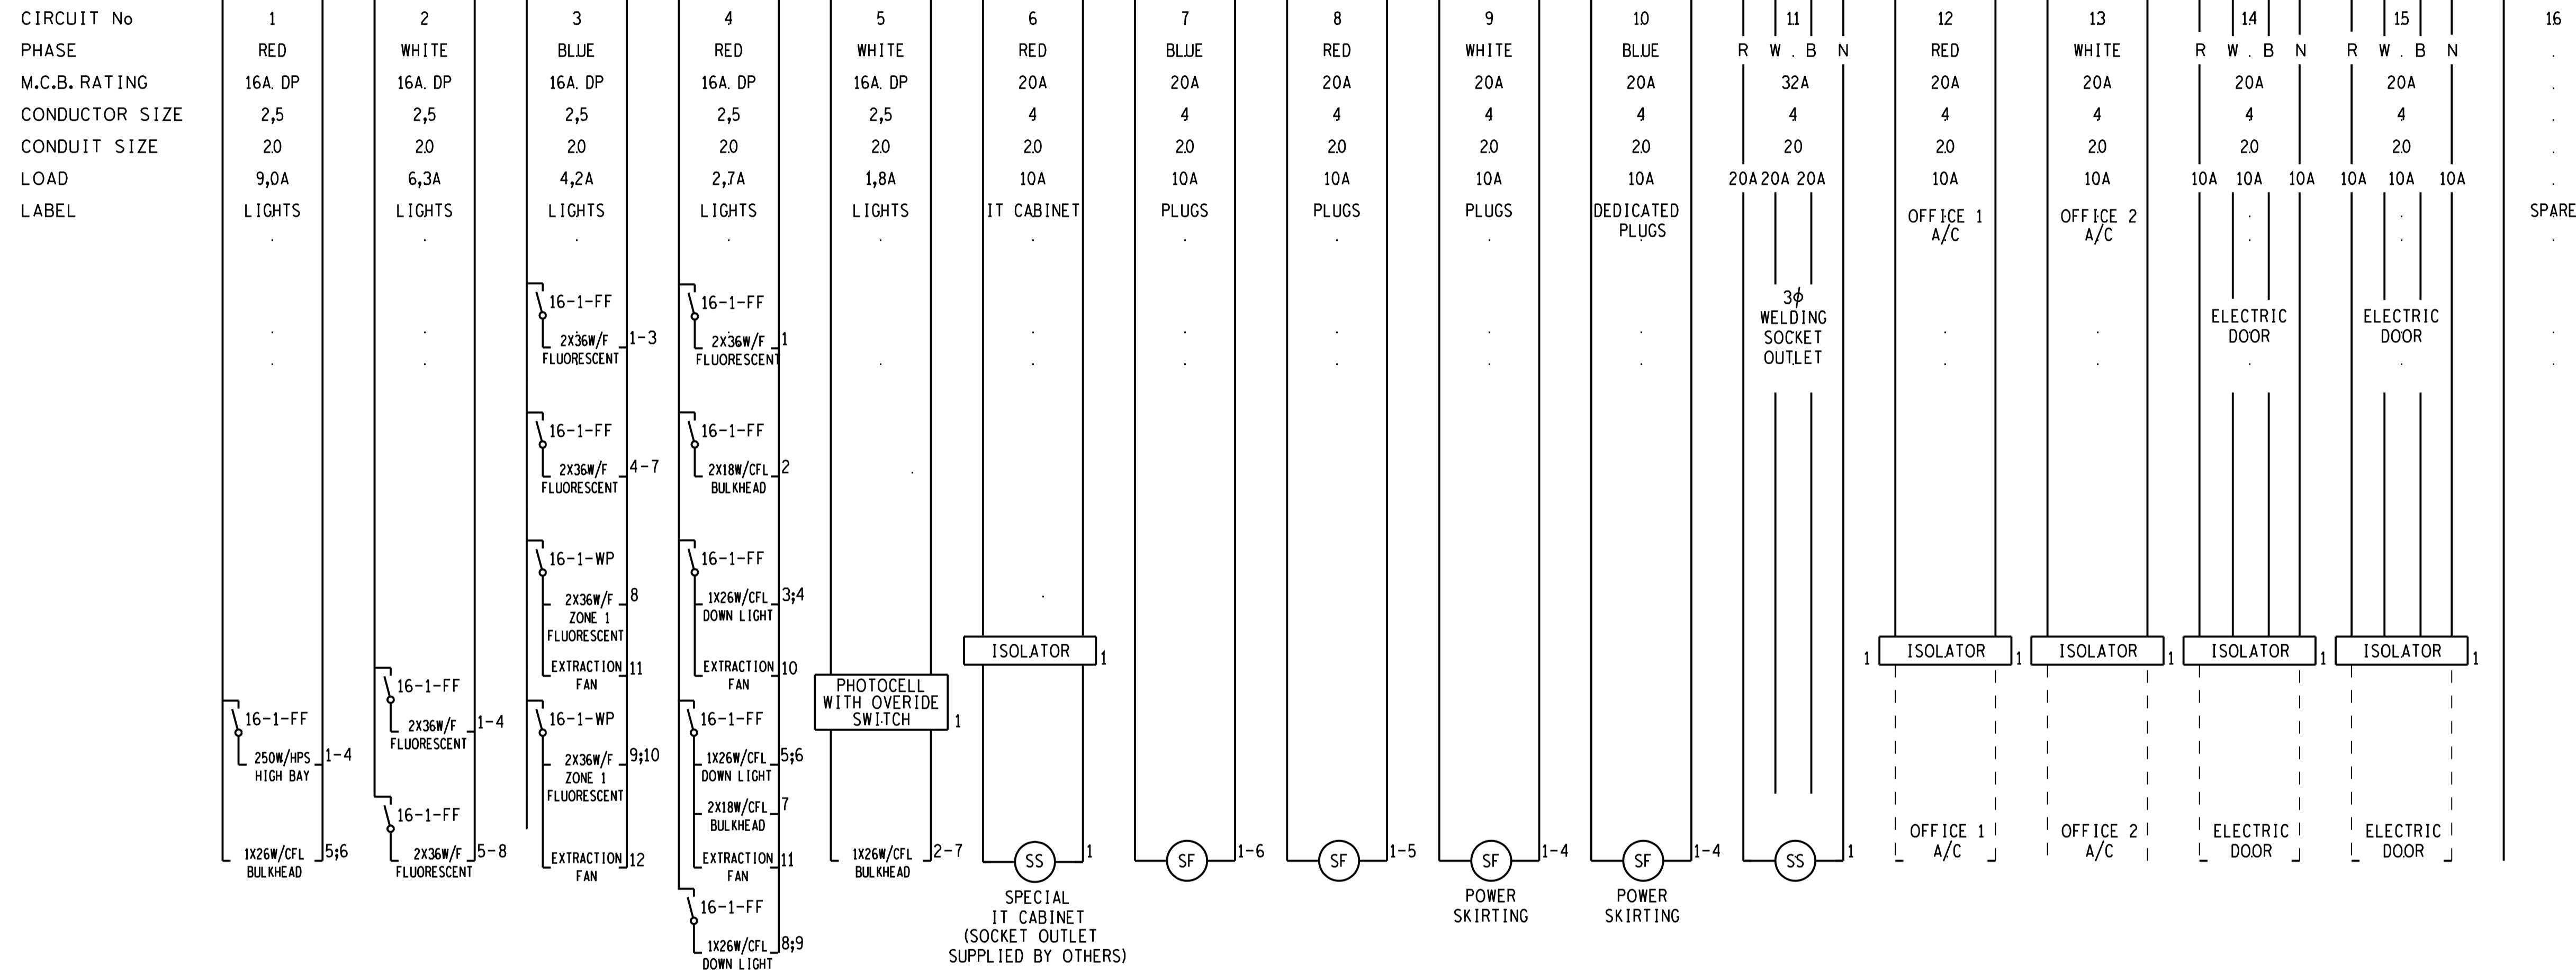

00 3	SEPT 2014	CIRCUITS 14, 15 REVISED.	DWN	ESB				
00 2	MAY 2014	CIRCUIT No 6 FOR IT CABINET ADDED	DWN	ESB				
00 1	MARCH 2014	CCT's 2 to 4, 7 to 10 & 12 to 15 REVISED.	SJS	ESB			18/SHT 4	O&M MAIN BOARD
00 0		FIRST ISSUE						SHEET LIGHTING LAYOUT
** REVISION **								
D.O.	REV	DATE	INDEX REFERENCE	W1.3	REV BY	CHKD BY	AUTH BY	KKS APP
DRG REGISTR								0.95
DESIGN APPROVED	13 04 2011	ESB						REFERENCE DRAWINGS
KKS APP								
DESIGN AUTH	13 04 2011	SJS						
CHKD BY	11 04 2011	ESB						
DRAWN BY	16 04 2011	DvG						
SCALE								

WIND ENERGY FACILITY
WORKSHOP AND STORES
LIGHTING SCHEMATIC DIAGRAM

Eskom 0.95/18

SHEET	2
REV	3