


Notes
 All Water pipes to connect to the main line according to Eng drawings
 All roof covering and installation according to specification

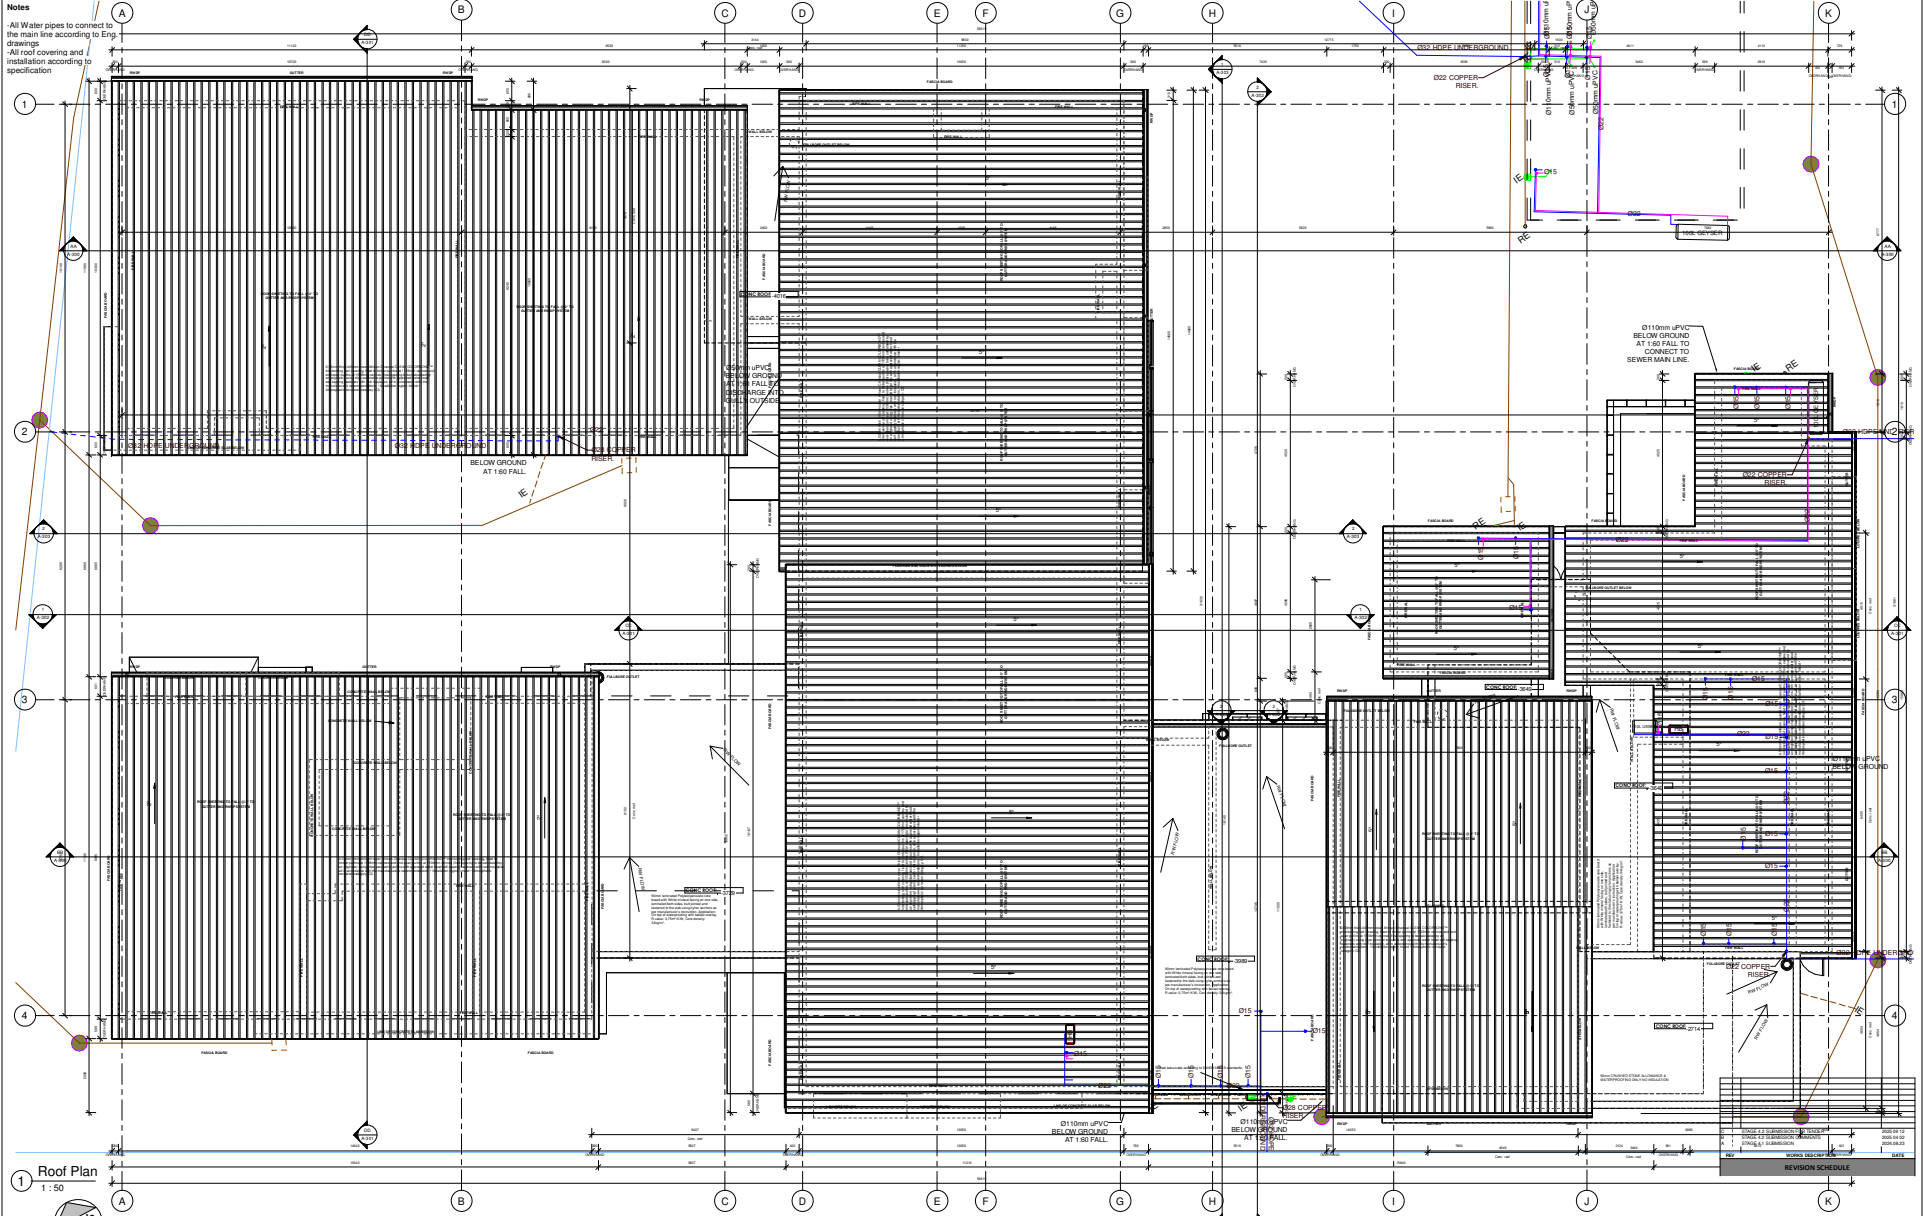

1 Roof Plan
1:50

NO.	DESCRIPTION	DATE
1	ISSUED FOR TENDER	2025 09 12

FOR TENDER

A0		CLIENT SERVICE BUREAU OF FIRE PROTECTION AND SAFETY SERVICES 111 CONSTITUTION AVENUE MANILA, PHILIPPINES TEL: +63 2 8866 8719	CONSULTANT 	SUITE NO. 508/7/FLOOR 1111 CONSTITUTION AVENUE MANILA, PHILIPPINES TEL: +63 2 8866 8719	COMMENTS THE GENERAL BUILDING REGULATORY CODE AND ALL THE RULES AND REGULATIONS OF THE BUREAU OF FIRE PROTECTION AND SAFETY SERVICES SHALL BE STRICTLY OBSERVED.	DESCRIPTION STATION BLOCK ROOF PLAN	PROJECT NUMBER 19149/1/27/28(22)	PROJECT NAME MARITE SAPS	PROJECT LOCATION C	DATE 2025 09 12
	DATE 2025 09 12	SCALE 1:50	DESIGNER DW	CHECKER KSP	DATE 2025 09 12	PROJECT NUMBER 19149/1/27/28(22)	PROJECT NAME MARITE SAPS	PROJECT LOCATION C	DATE 2025 09 12	