

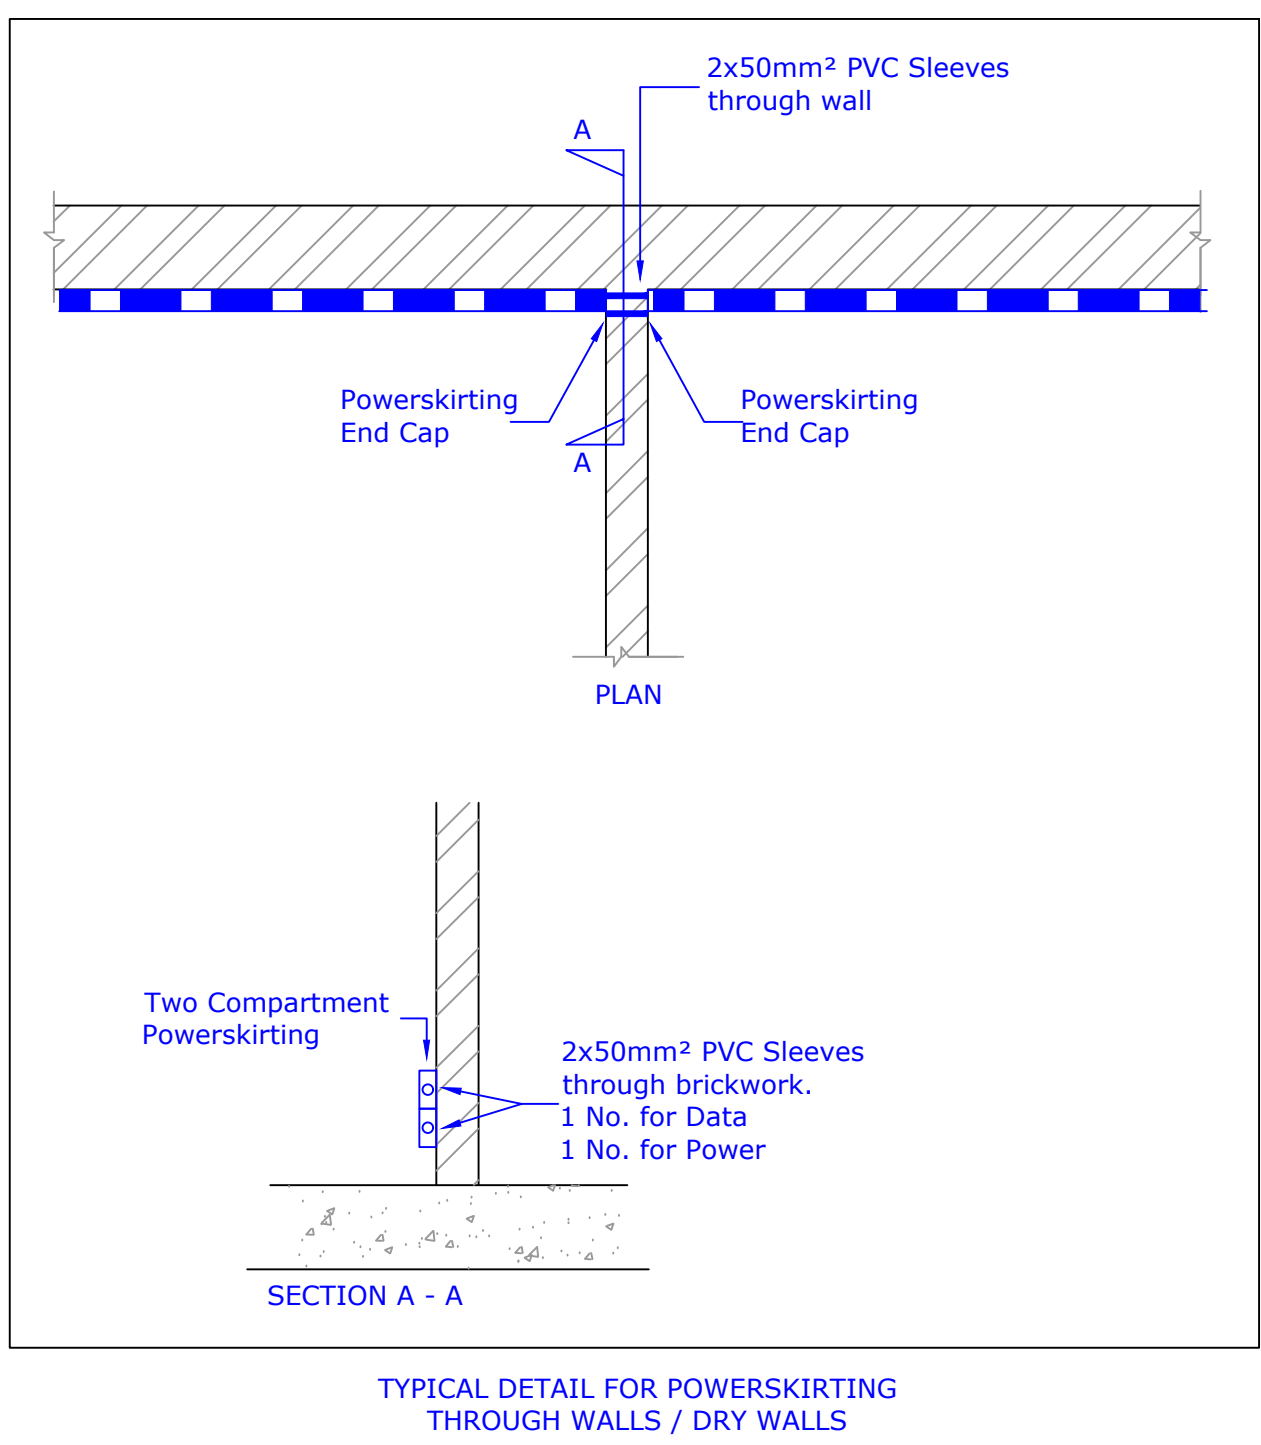
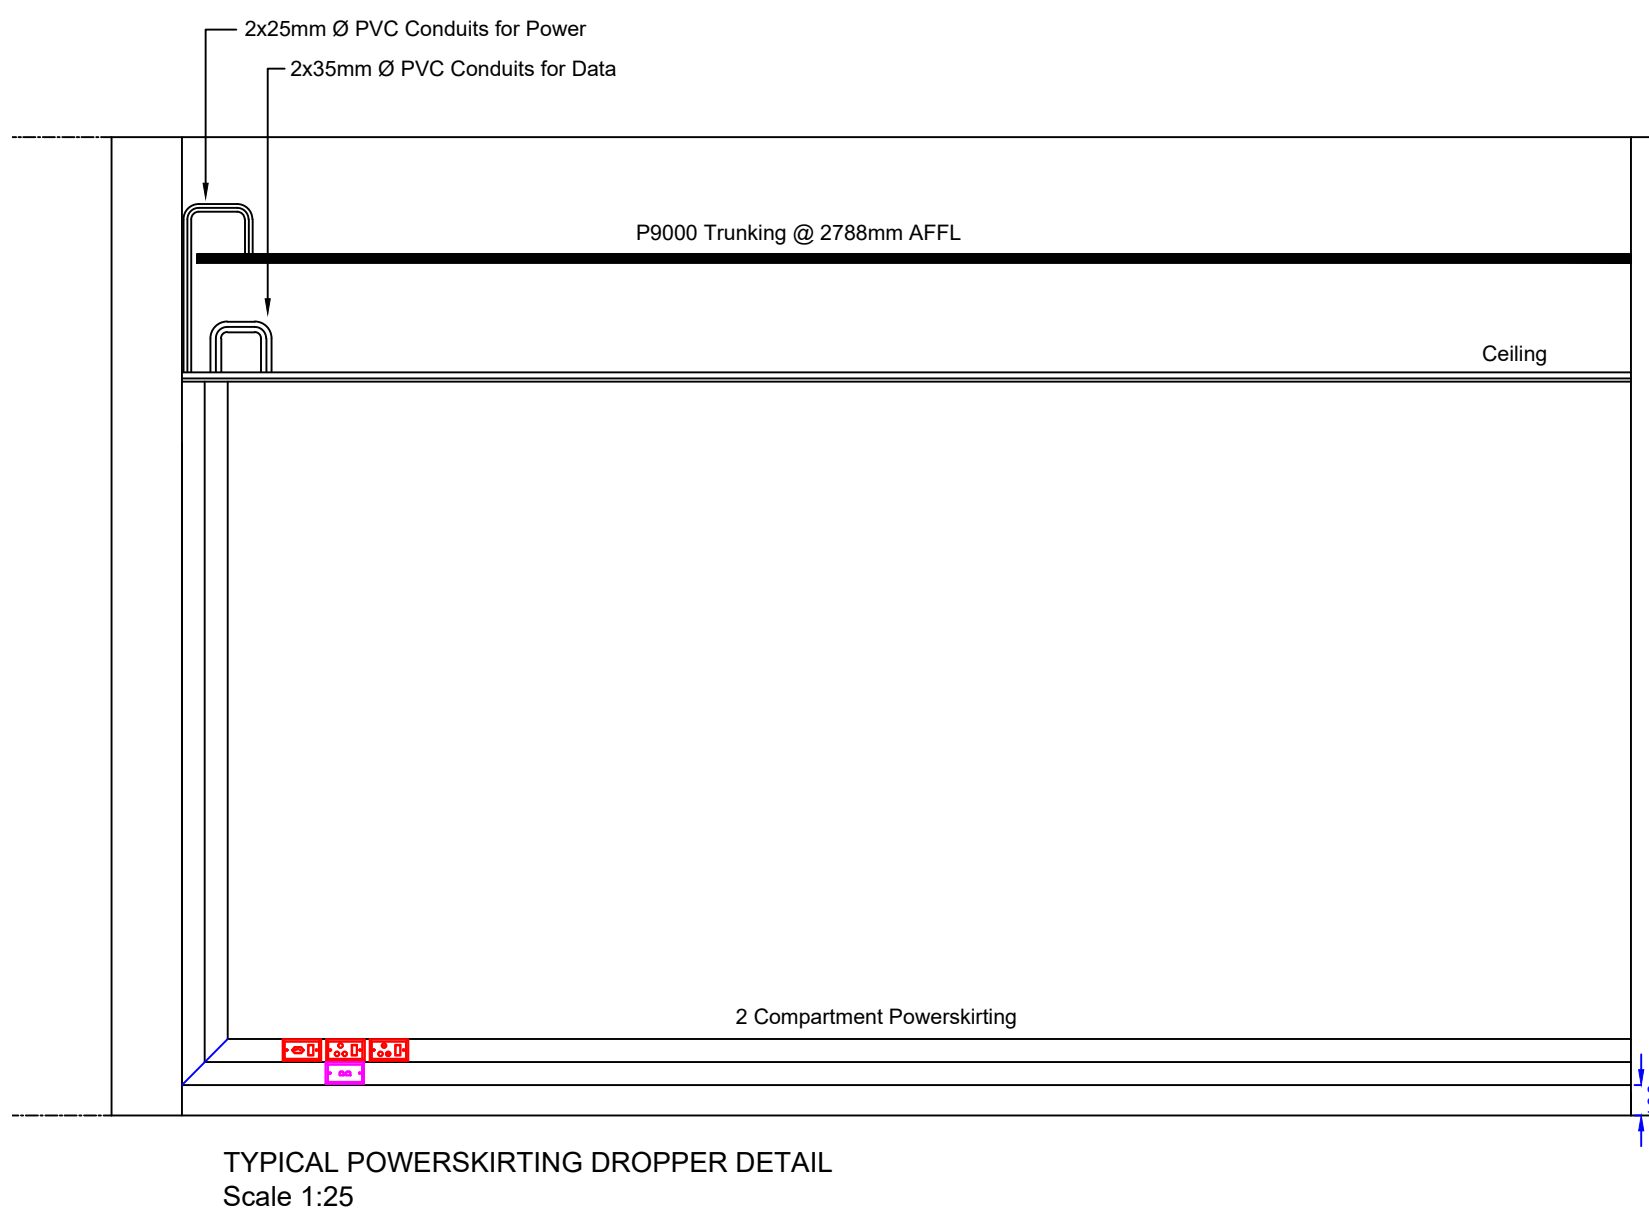


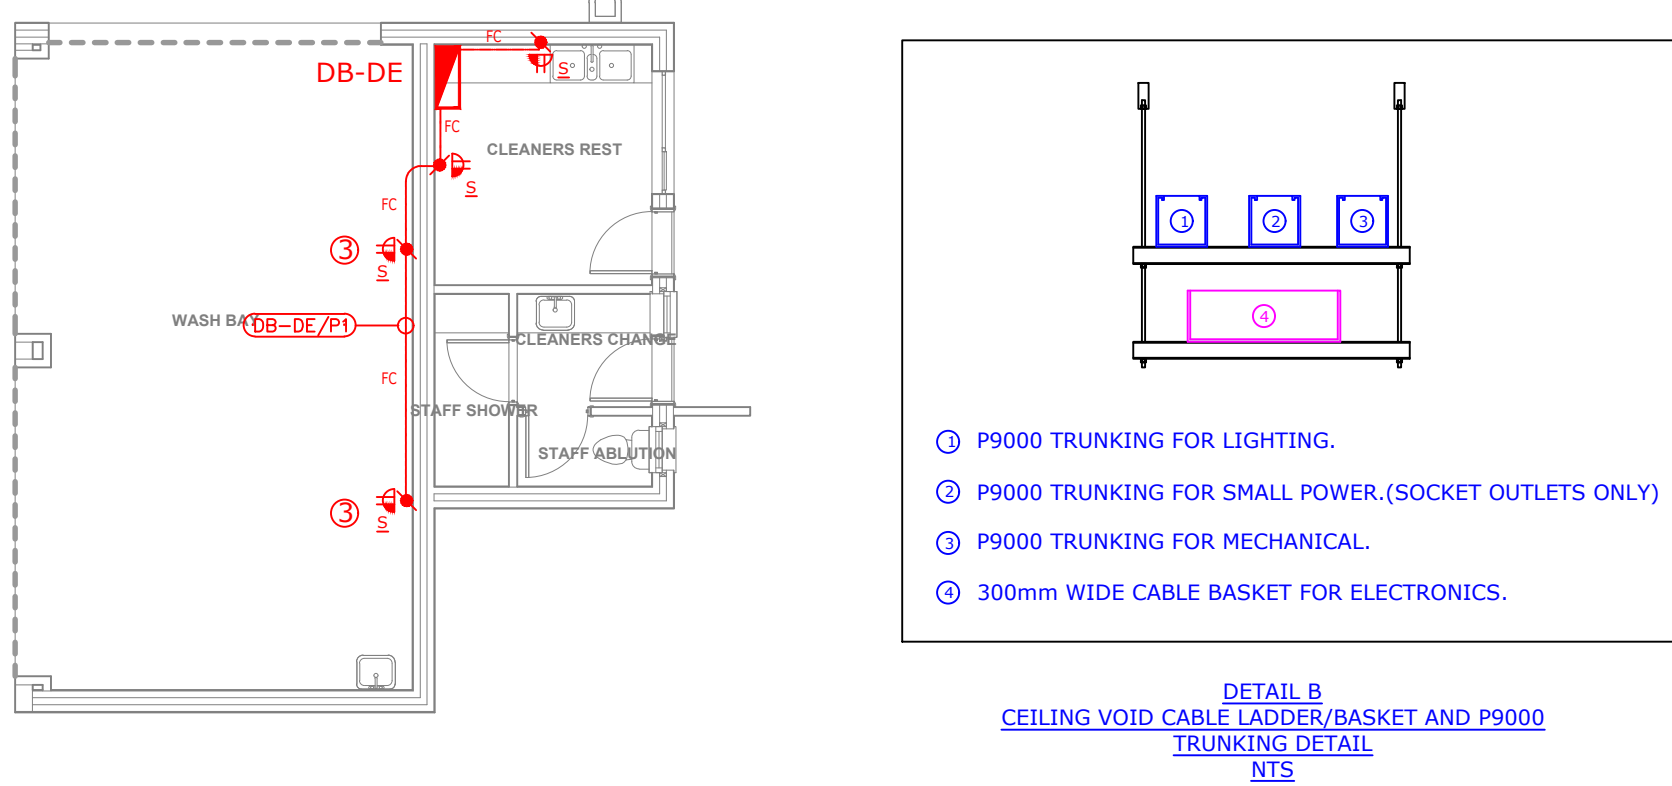

B	12/11/24	CW	Revised to Client's Request	MK
A	20/09/24	CW	Powerskirting Revised	MK
Q	13/09/24	CW	Original Issue	MK
REV.	DATE	BY	DESCRIPTION	CWM
REVISIONS				

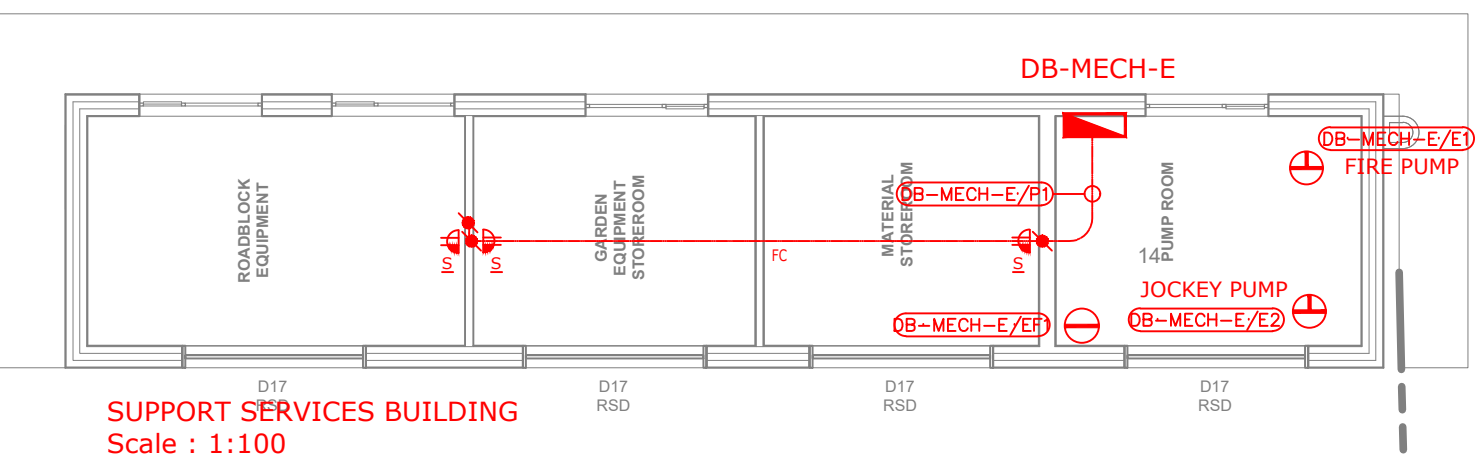


 Approved in Principle
 Justin McKelvie-King
 Pr Eng : 20120548

PROJECT/SPECIES			
Makhaza Police Station Electrical Installation			
TITLE			
Ground Floor Small Power Layout			
ENGINEER:	DRAWN BY:	DATE:	CHECKED: SCALE:
KM	CW	19/07/24	KM 1:100
PROJECT NO:		DRAWING NO:	PAPER SIZE: A0
32307		200	REV: B
FILE: 32308_200		LAYERS:	

[illegible]