


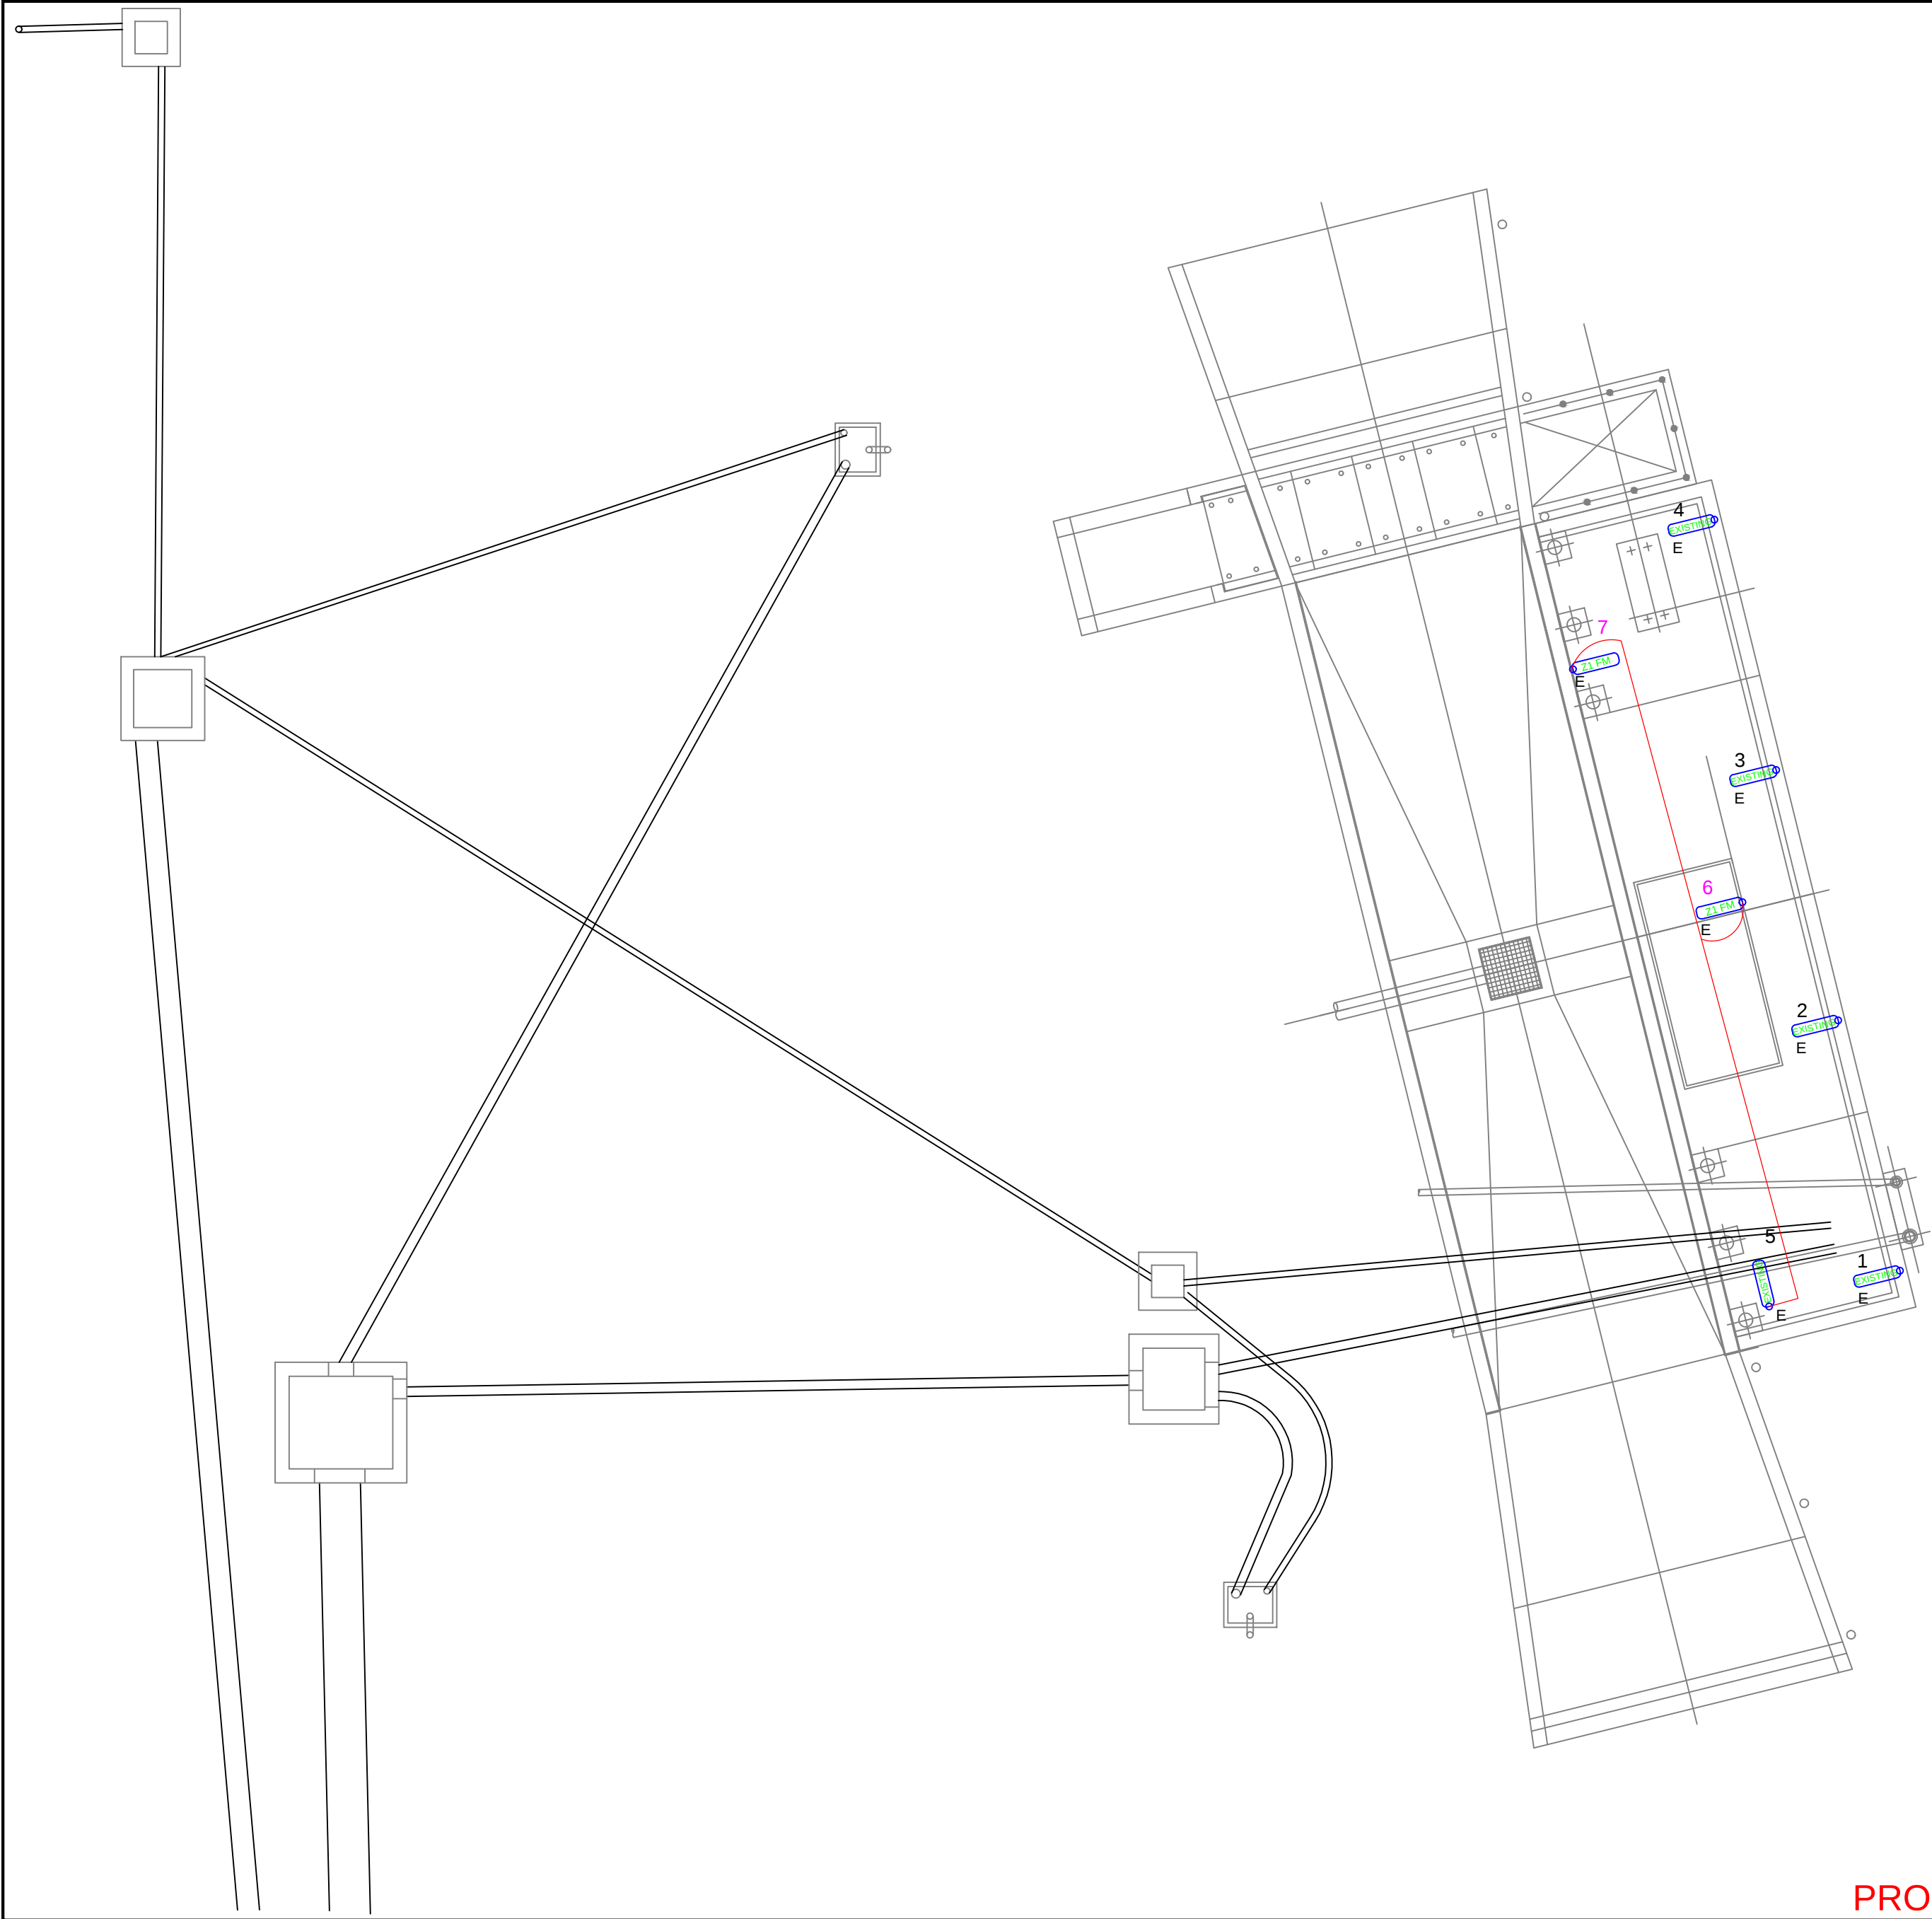

SYMBOL	DESCRIPTION	QTY	MAKE
Z1	SUITABLE ZONE 1 EX LED LUMINAIRE	2	TBC
Z2	SUITABLE ZONE 2 EX LED LUMINAIRE	0	TBC
RM	RAIL MOUNT	0	
FM	FLOOR MOUNT	2	
BM	BUND MOUNT	0	
	PROPOSED CABLE ROUTE		
E	EMERGENCY		

PROPOSAL



ROAD LOADING LIGHTING LAYOUT
HILLTOP DEPOT

REVISIONS			
PROJECT NAME			
LIGHTING UPGRADE			
DRAWN	W.D	REF.	
TRACED	CAD	DATE	28.07.21
CHECKED	K.N	APPROVED	Z.M
SCALE	NTS		
DRAWING No.			REV
PL121649			