


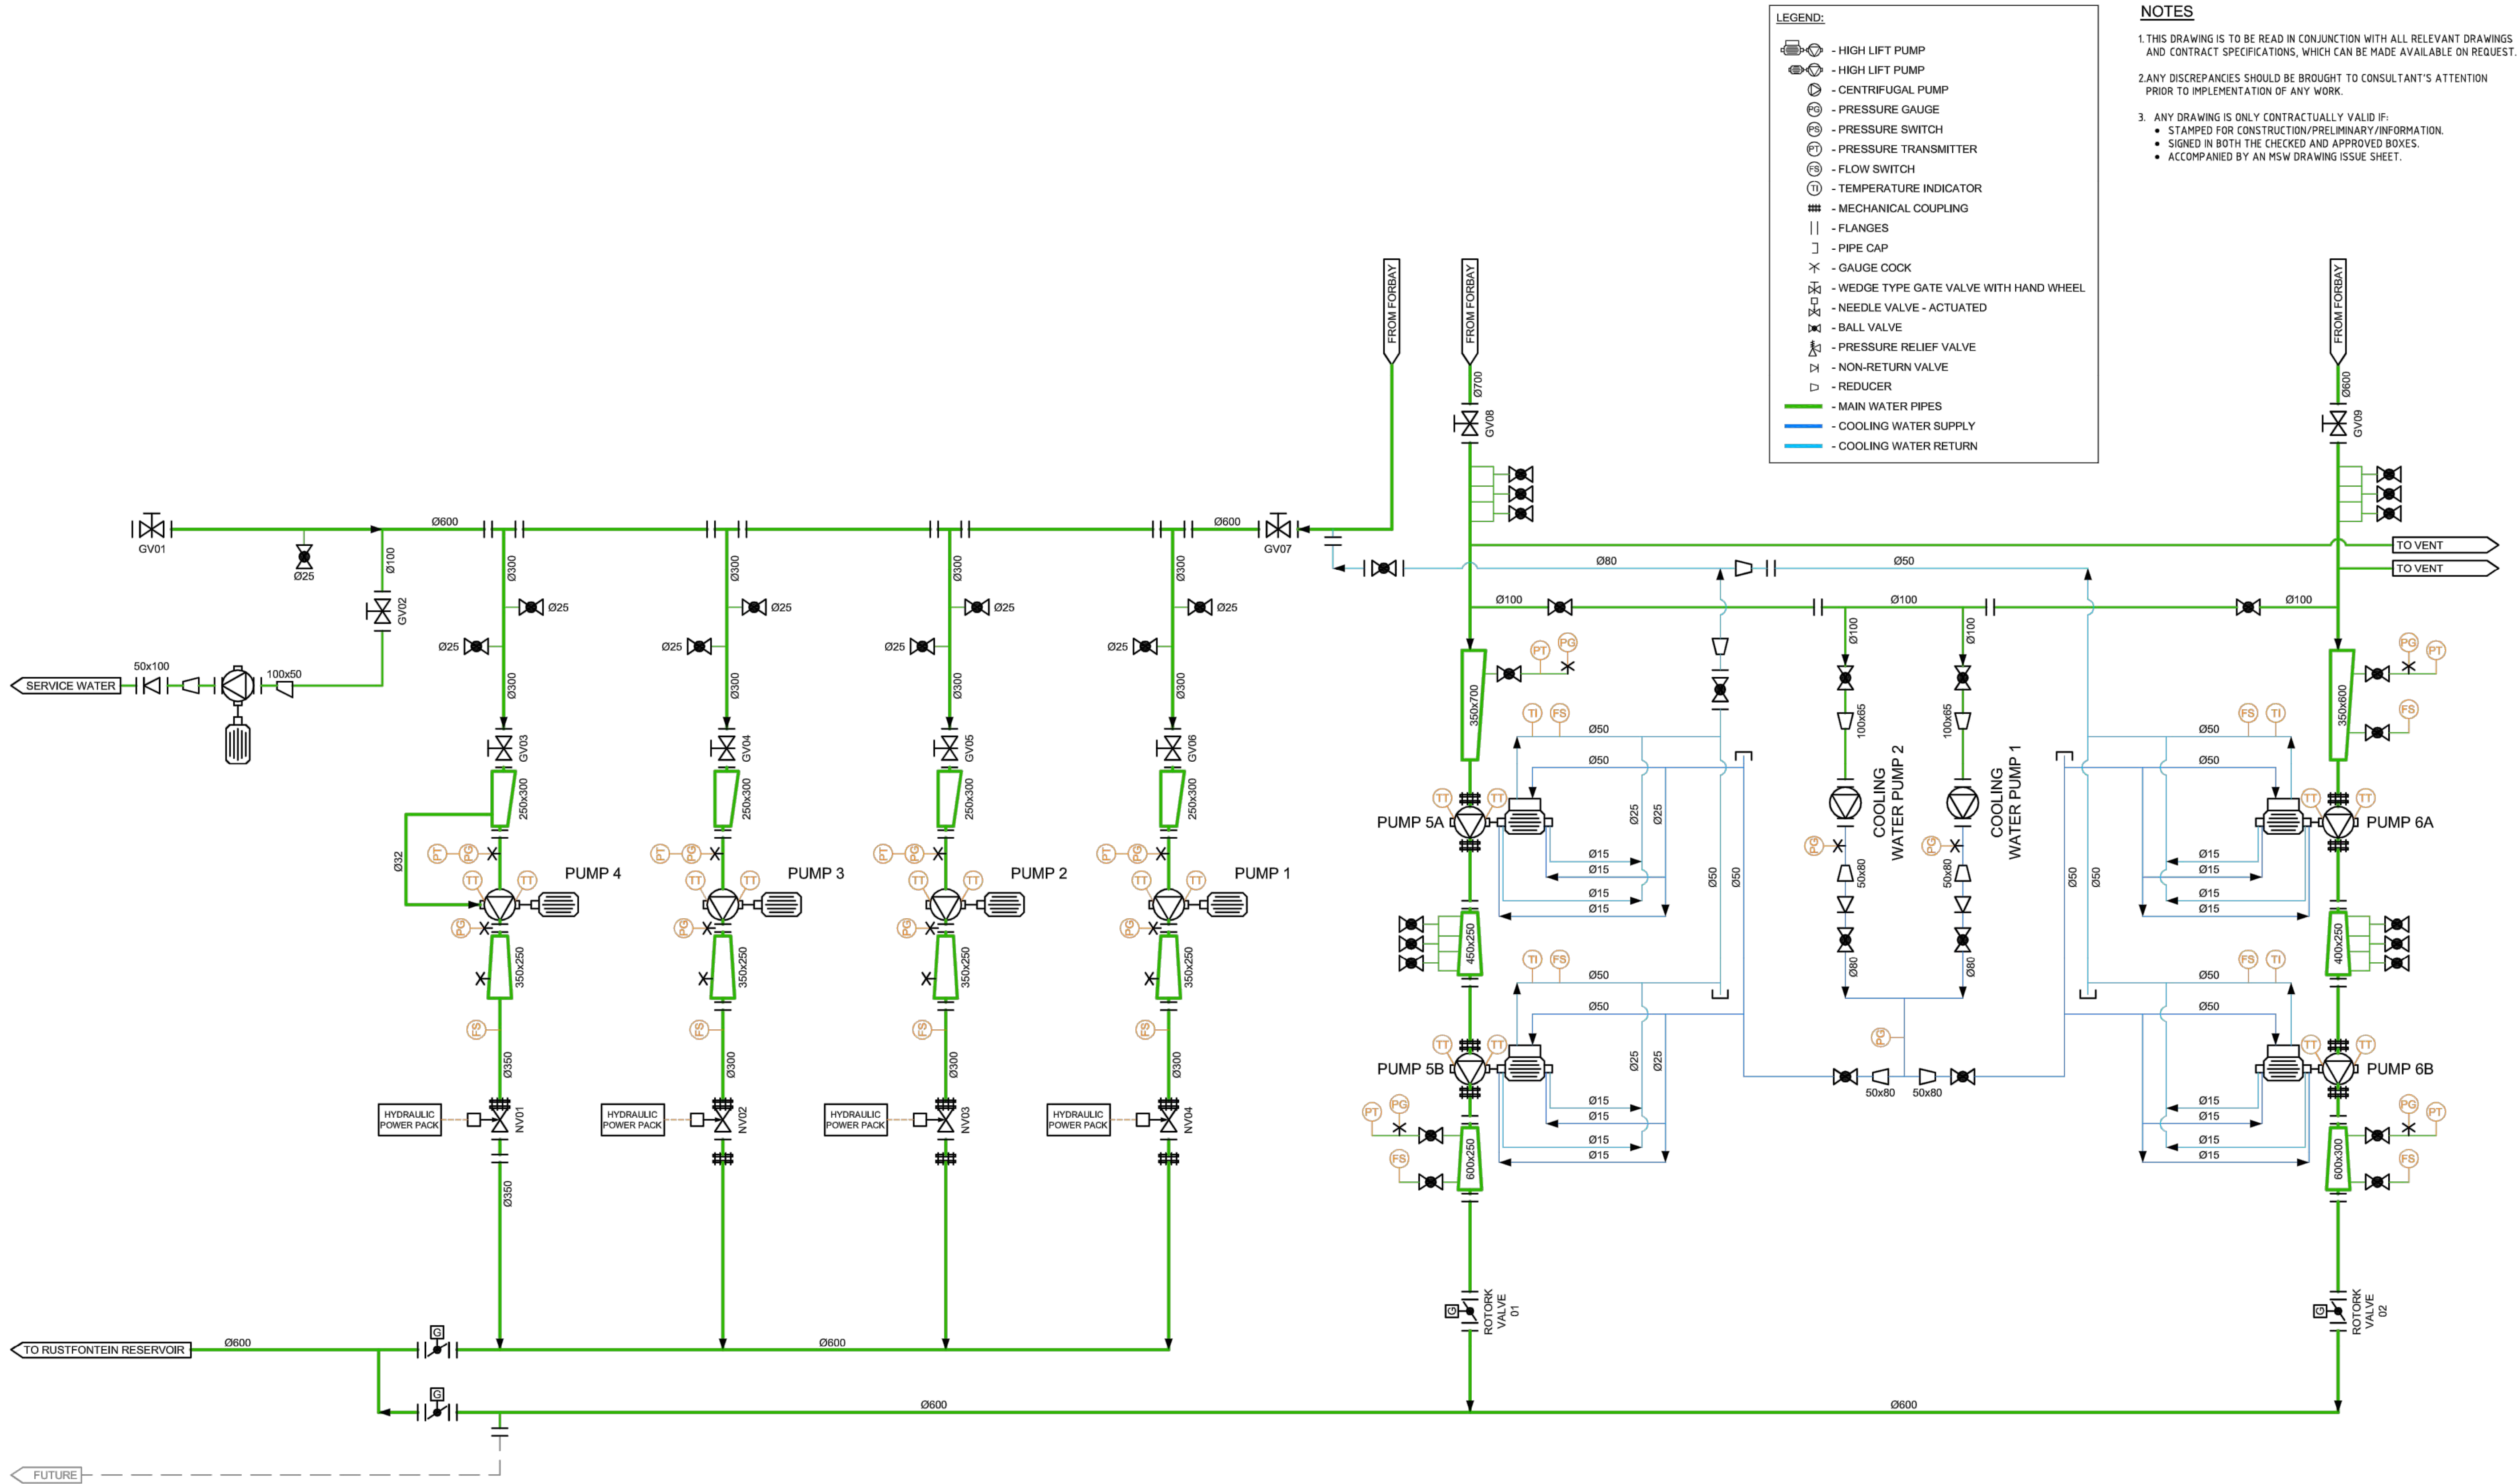

CLIENT:



1 Landros Mare Street
Polokwane Central
Tel: (015) 295 1800
Email: info@lepelle.co.za
Website: www.lepellewater.com

CONSULTANT:



16 Blue Jay
Rooihuiskraal Centurion, 0157
P.O. Box 31523
Braamfontein, 2017
Johannesburg
Tel: (012) 661 0283
Fax: (035) 789 0222
Email: lamsanm@sigodimarrah.co.za
Website: www.sigodimarrah.com

PROFESSIONAL ENGINEER:

M. MAPULANE

PROF. Reg No:
20160201

DATE:
2023-03-13

SIGNATURE:

DESIGN BY:

M. MAPULANE

DRAWN BY:

E. COETZEE

CHECKED BY:

M. MAPULANE

APPROVED BY:

M. MAPULANE

REVISIONS

REV	DATE	DESCRIPTION	BY
0	2023-03-13	ISSUED FOR TENDER	M.M

PROJECT NAME

UPGRADE OF OLIFANTSPOOT AND EBENEZER
WATER SUPPLY SCHEME

TITLE

EBENEZER PUMP STATION
P&ID


PROJECT STATUS:

TENDER DRAWING

DATE	SCALE	SHEET	REV	A1
2023-03-13	AS SHOWN	1 OF 1	0	A1

DWG NO

P1001-EB1M-INS-0100

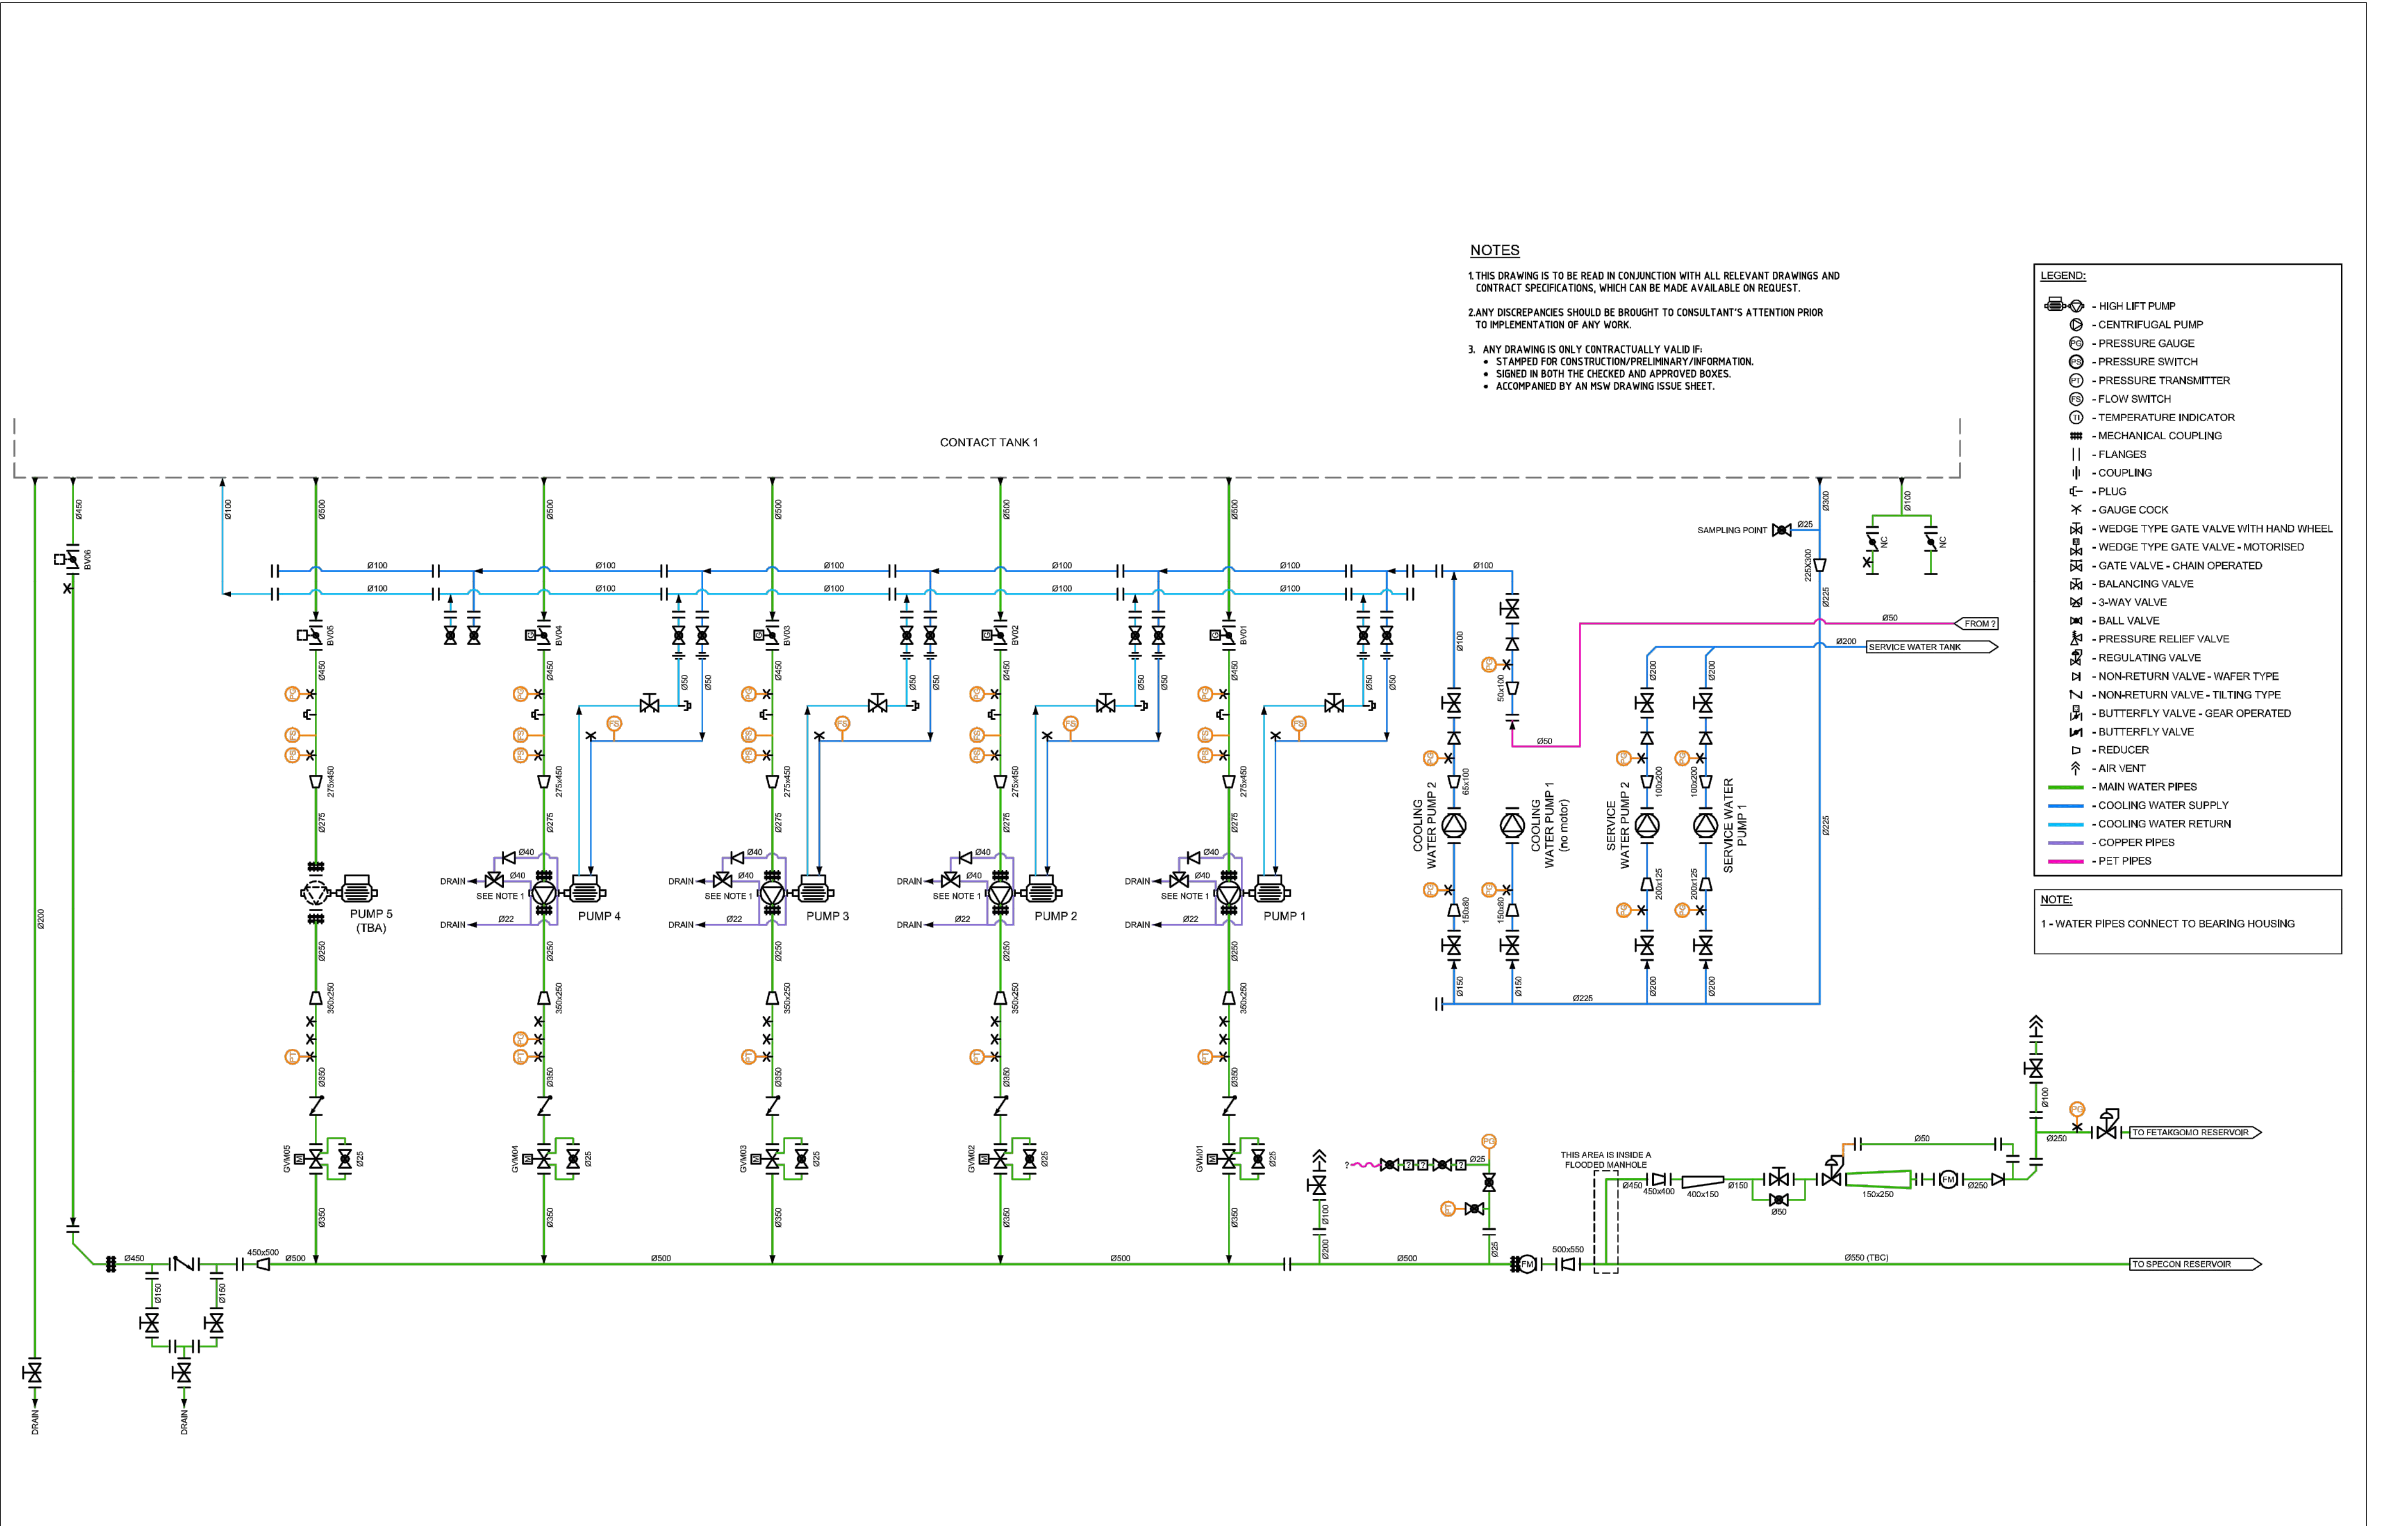

CLIENT:



1 Landros Mare Street
Polokwane Central
Tel: (015) 295 1800
Email: info@lepelle.co.za
Website: www.lepellewater.com

CONSULTANT:



16 Blue Jay
Rooihuiskraal Centurion, 0157
P.O. Box 31523
Braamfontein, 2017
Johannesburg
Tel: (012) 661 0283
Fax: (035) 789 0222
Email: lamsanam@sigodimarah.co.za
Website: www.sigodimarah.com

PROFESSIONAL ENGINEER:

M. MAPULANE
PROF. Reg No:
20160201

DATE:
2023-03-13

SIGNATURE:

DESIGN BY:

M. MAPULANE

DRAWN BY:

E. COETZEE

CHECKED BY:

M. MAPULANE

APPROVED BY:

M. MAPULANE

REVISIONS

REV	DATE	DESCRIPTION	BY
0	2023-03-13	ISSUED FOR TENDER	M.M

PROJECT NAME

UPGRADE OF OLIFANTSPOORT AND EBENEZER
WATER SUPPLY SCHEME

TITLE

OLIFANTSPOORT PUMP STATION 1
P&ID

PROJECT STATUS:

TENDER DRAWING

DATE	SCALE	SHEET	REV	A1
2023-03-13	AS SHOWN	1 OF 1	0	A1

DWG NO


P1001-OL1D-INS-0101

1. THIS DRAWING IS TO BE READ IN CONJUNCTION WITH ALL RELEVANT DRAWINGS AND CONTRACT SPECIFICATIONS, WHICH CAN BE MADE AVAILABLE ON REQUEST.

2. ANY DISCREPANCIES SHOULD BE BROUGHT TO CONSULTANT'S ATTENTION PRIOR TO IMPLEMENTATION OF ANY WORK.


3. ANY DRAWING IS ONLY CONTRACTUALLY VALID IF:

- STAMPED FOR CONSTRUCTION/PRELIMINARY/INFORMATION.
- SIGNED IN BOTH THE CHECKED AND APPROVED BOXES.
- ACCOMPANIED BY AN MSW DRAWING ISSUE SHEET.

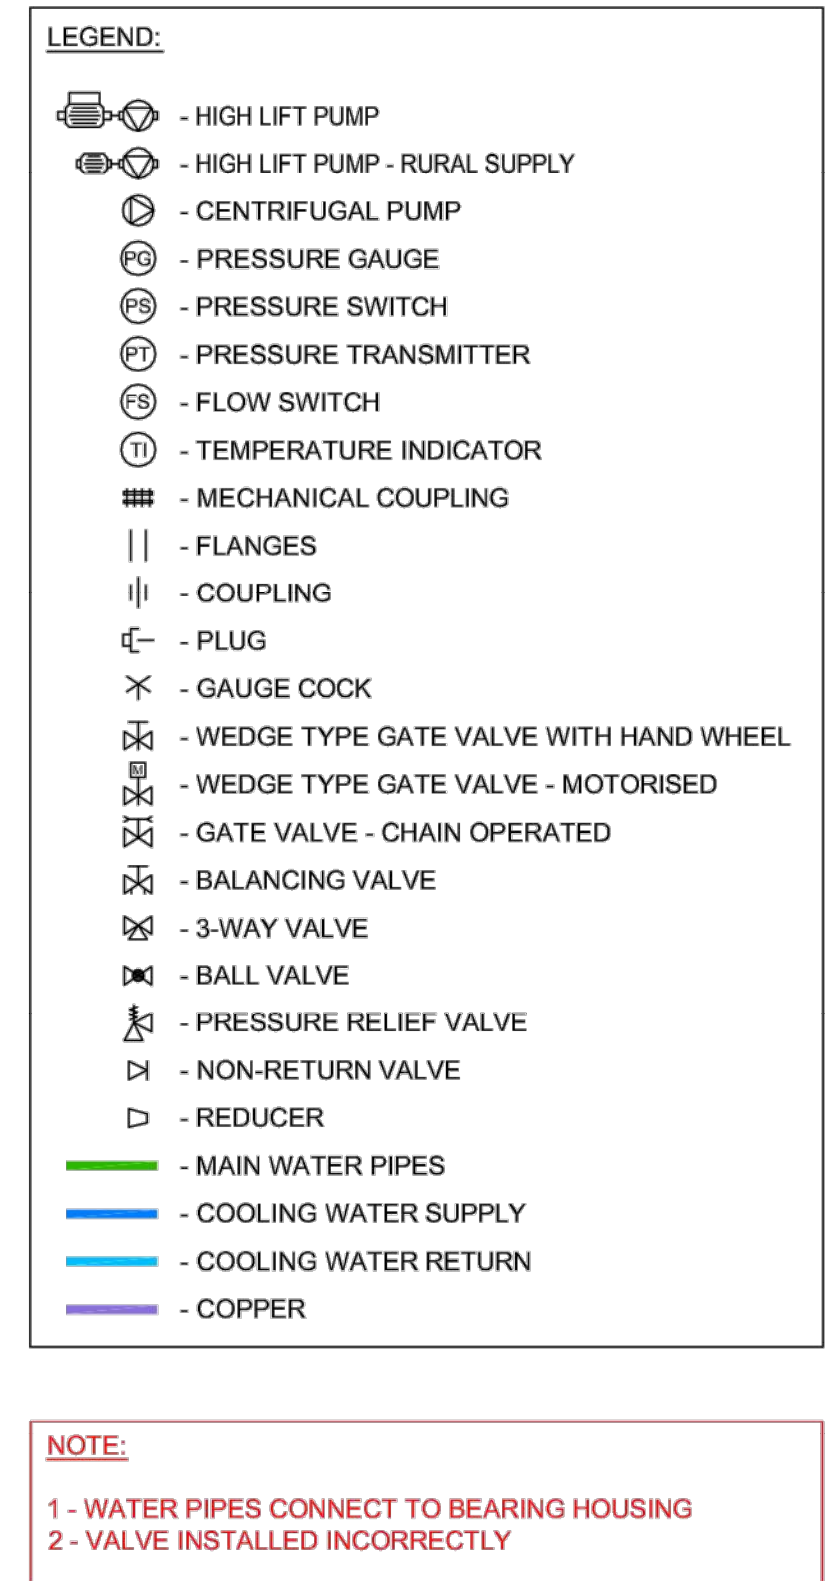

NOTES

1. THIS DRAWING IS TO BE READ IN CONJUNCTION WITH ALL RELEVANT DRAWINGS AND CONTRACT SPECIFICATIONS, WHICH CAN BE MADE AVAILABLE ON REQUEST.
2. ANY DISCREPANCIES SHOULD BE BROUGHT TO CONSULTANT'S ATTENTION PRIOR TO IMPLEMENTATION OF ANY WORK.
3. ANY DRAWING IS ONLY CONTRACTUALLY VALID IF:
- STAMPED FOR CONSTRUCTION/PRELIMINARY/INFORMATION.
 - SIGNED IN BOTH THE CHECKED AND APPROVED BOXES.
 - ACCOMPANIED BY AN MSW DRAWING ISSUE SHEET.

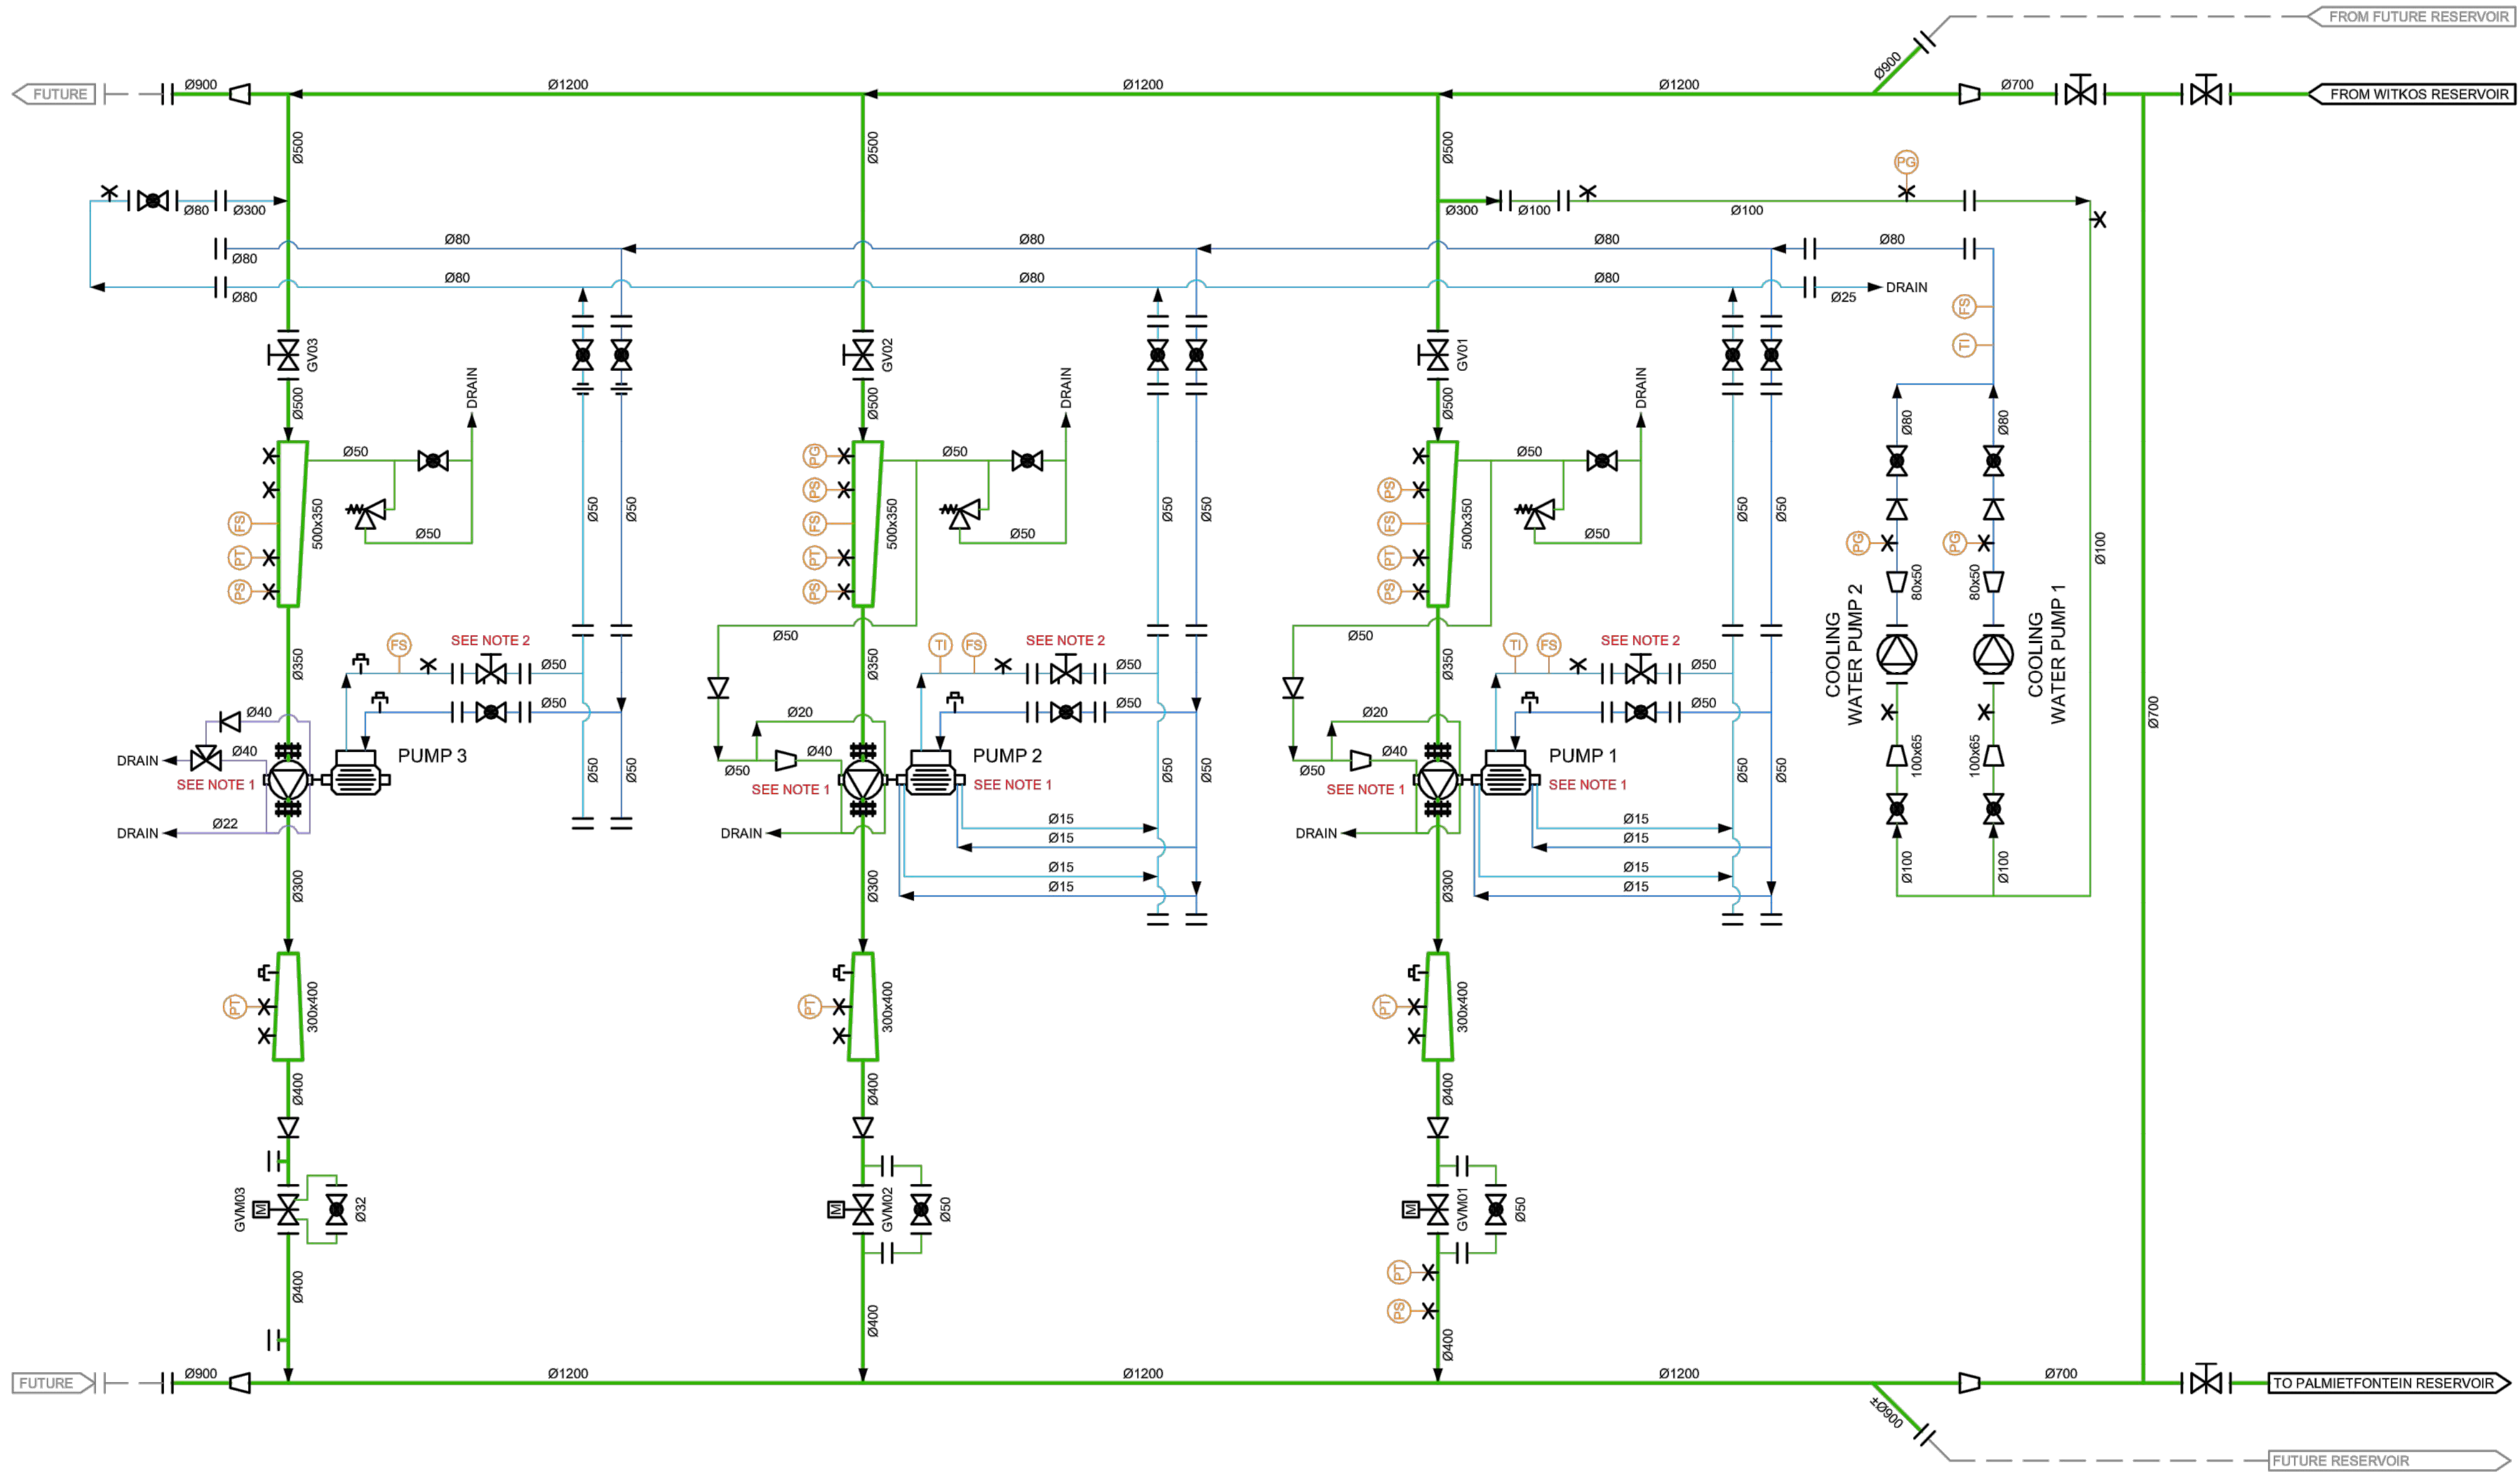

CLIENT:



1 Landros Mare Street
Polokwane Central
Tel: (015) 295 1800
Email: info@lepelle.co.za
Website: www.lepellewater.com

CONSULTANT:



16 Blue Jay
Rooihuiskraal Centurion, 0157
P.O. Box 31523
Braamfontein, 2017
Johannesburg
Tel: (012) 661 0283
Fax: (035) 789 0222
Email: lamsanam@sigodimarrah.co.za
Website: www.sigodimarrah.com

PROFESSIONAL ENGINEER:

M. MAPULANE
PROF. Reg No:
20160201

DATE:
2023-03-13

SIGNATURE:

DESIGN BY:

M. MAPULANE

DRAWN BY:

E. COETZEE

CHECKED BY:

M. MAPULANE

APPROVED BY:

M. MAPULANE

REVISIONS

REV	DATE	DESCRIPTION	BY
0	2023-03-13	ISSUED FOR TENDER	M.M

PROJECT NAME

UPGRADE OF OLIFANTSPOORT AND EBENEZER
WATER SUPPLY SCHEME

TITLE

OLIFANTSPOORT PUMP STATION 3
P&ID

PROJECT STATUS:

TENDER DRAWING

DATE	SCALE	SHEET	REV	A1
2023-03-13	AS SHOWN	1 OF 1	0	A1

DWG NO

P1001-OL1D-INS-0103