



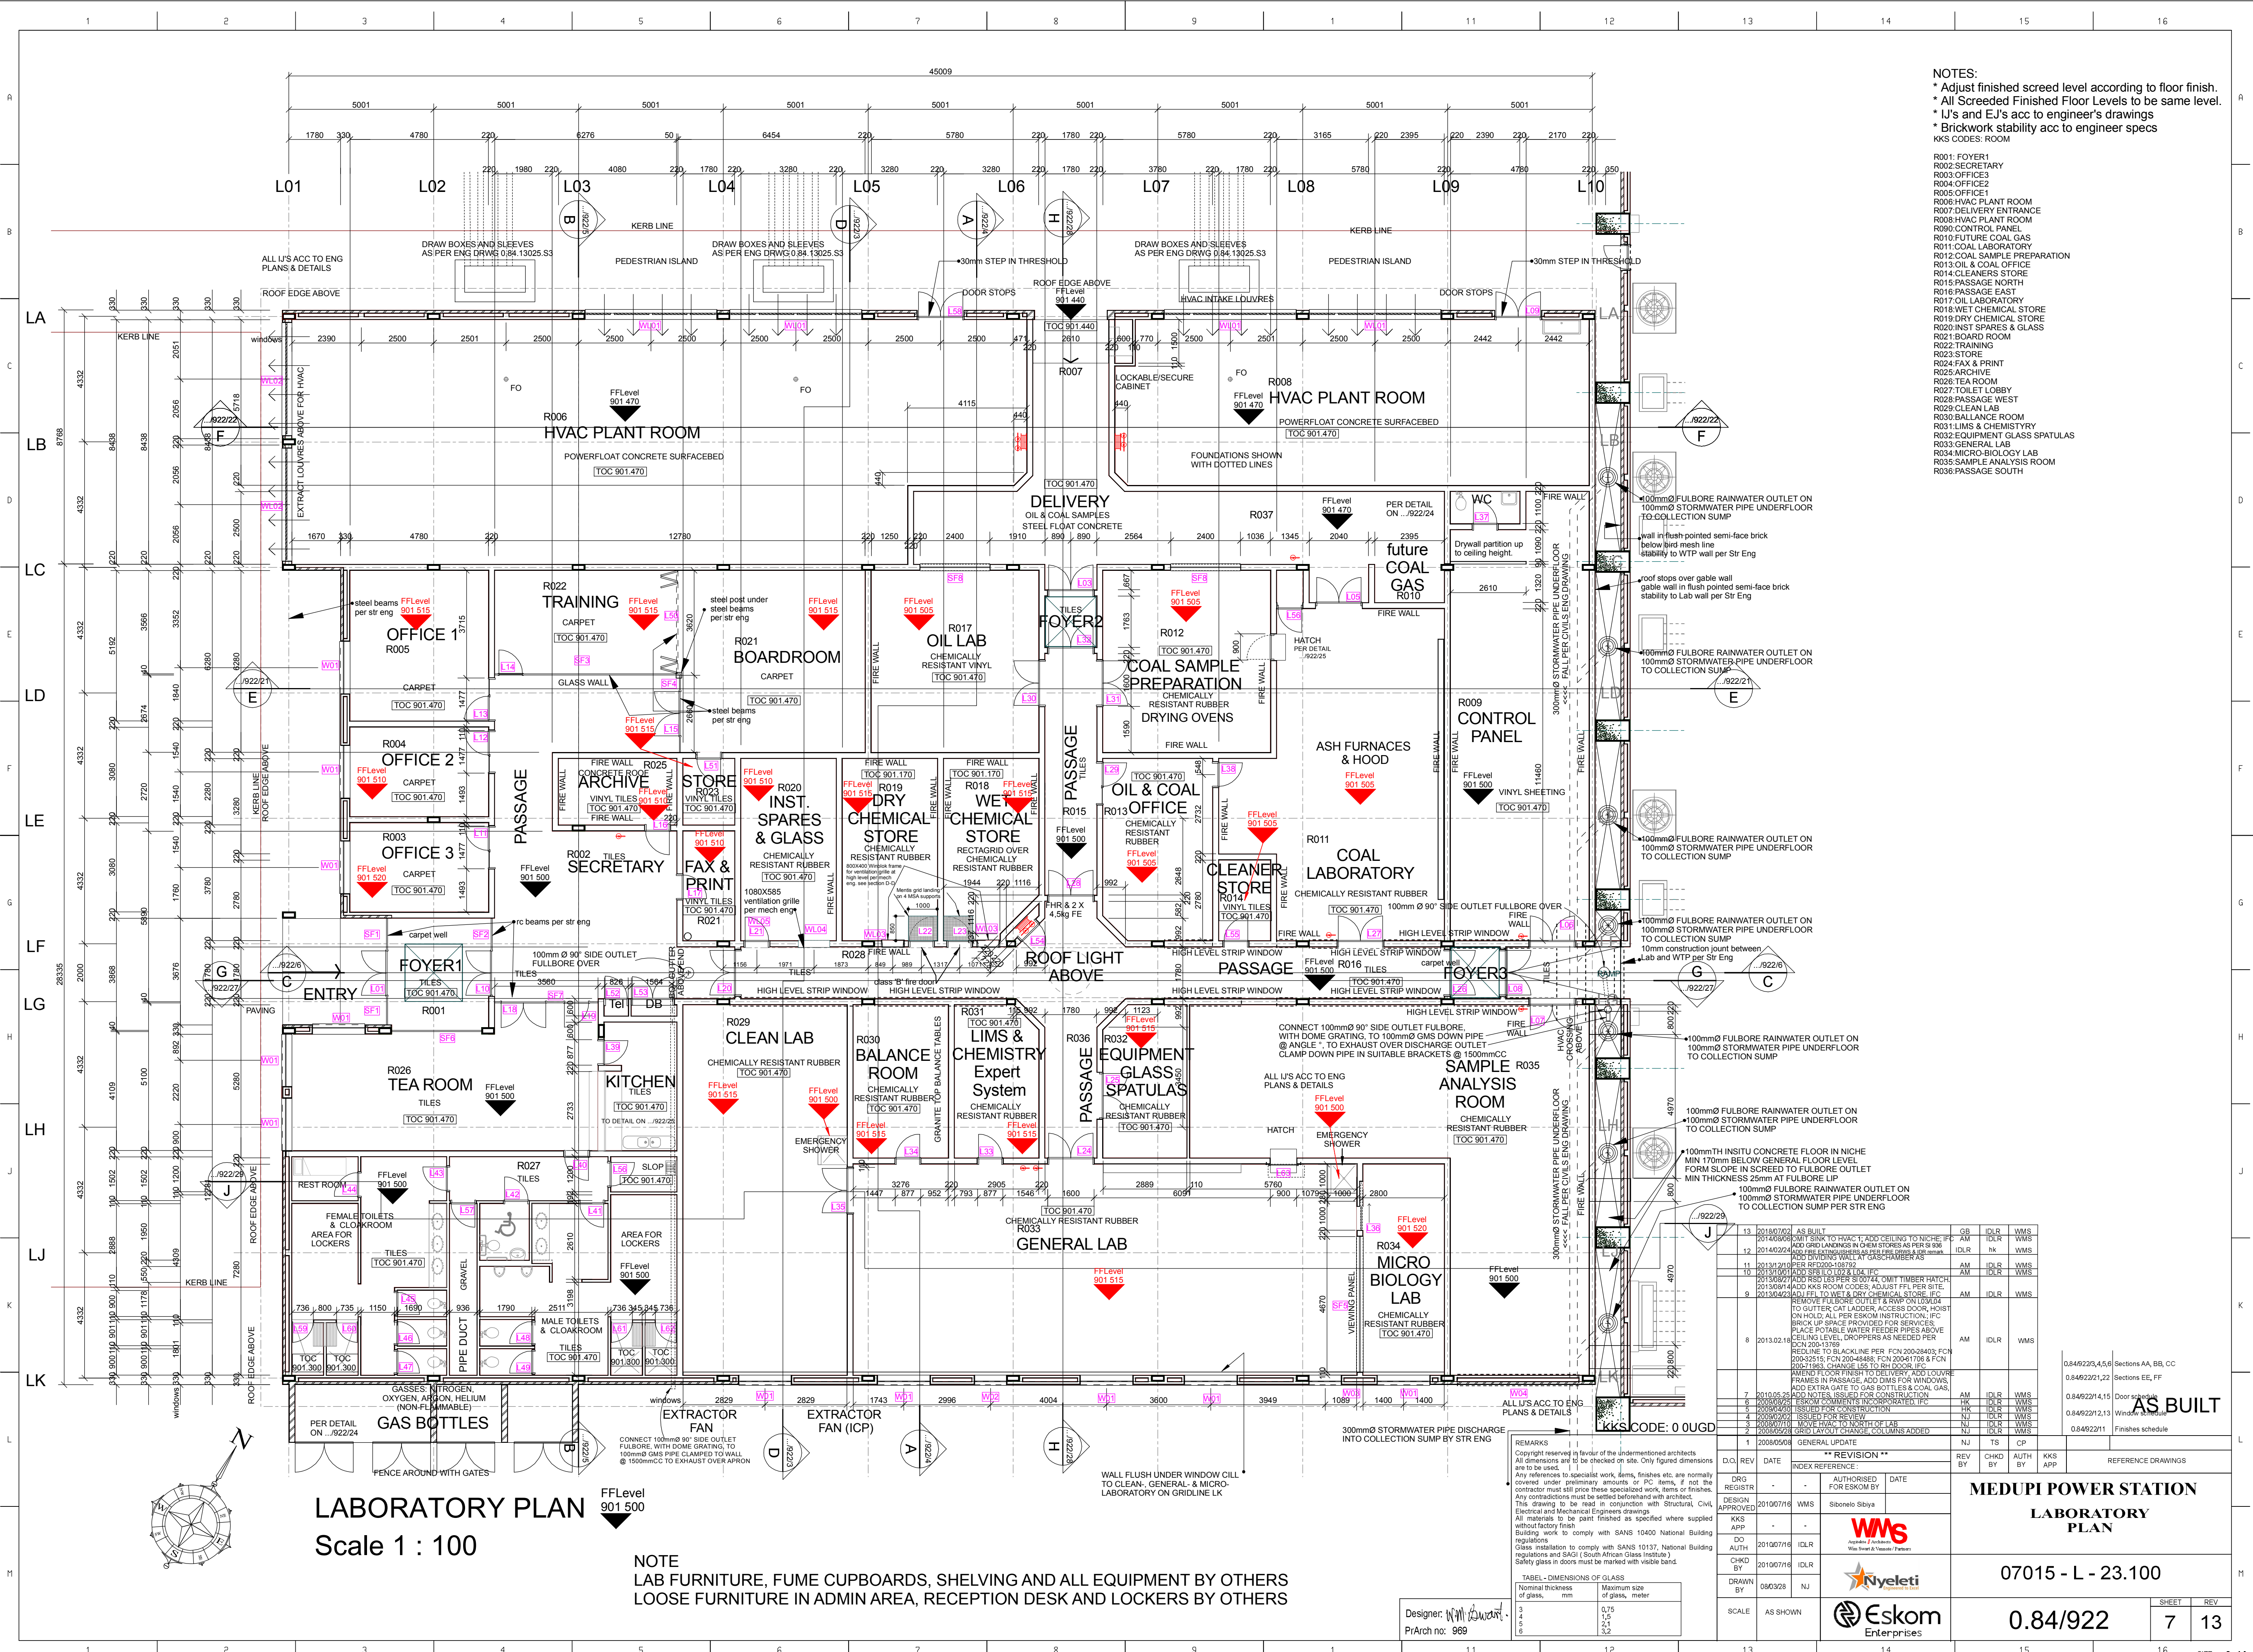

- NOTES:
- * Adjust finished screed level according to floor finish.
 - * All Screeded Finished Floor Levels to be same level.
 - * I's and E's acc to engineer's drawings
 - * Brickwork stability acc to engineer specs
 - KKS CODES: ROOM
- R001: FOYER1
 - R002: SECRETARY
 - R003: OFFICE3
 - R004: OFFICE2
 - R005: OFFICE1
 - R006: HVAC PLANT ROOM
 - R007: DELIVERY ENTRANCE
 - R008: HVAC PLANT ROOM
 - R009: CONTROL PANEL
 - R010: FUTURE COAL GAS
 - R011: COAL LABORATORY
 - R012: COAL SAMPLE PREPARATION
 - R013: OIL & COAL OFFICE
 - R014: CLEANERS STORE
 - R015: PASSAGE NORTH
 - R016: PASSAGE EAST
 - R017: OIL LABORATORY
 - R018: WET CHEMICAL STORE
 - R019: DRY CHEMICAL STORE
 - R020: INST SPARES & GLASS
 - R021: BOARD ROOM
 - R022: TRAINING
 - R023: STORE
 - R024: FAX & PRINT
 - R025: ARCHIVE
 - R026: TEA ROOM
 - R027: TOILET LOBBY
 - R028: PASSAGE WEST
 - R029: CLEAN LAB
 - R030: BALANCE ROOM
 - R031: LIMS & CHEMISTRY
 - R032: EQUIPMENT GLASS SPATULAS
 - R033: GENERAL LAB
 - R034: MICRO-BIOLOGY LAB
 - R035: SAMPLE ANALYSIS ROOM
 - R036: PASSAGE SOUTH

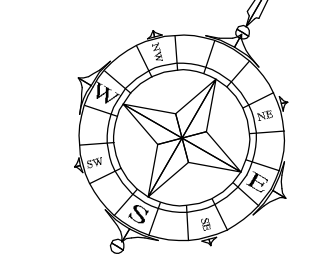

LABORATORY PLAN
Scale 1 : 100

NOTE
LAB FURNITURE, FUME CUPBOARDS, SHELVING AND ALL EQUIPMENT BY OTHERS
LOOSE FURNITURE IN ADMIN AREA, RECEPTION DESK AND LOCKERS BY OTHERS

Designer: N. M. M. M.
P/Arch no: 969

TABLE - DIMENSIONS OF GLASS

Normal thickness of glass, mm	Maximum size of glass, meter
3	0,75
4	1,0
5	2,1
6	3,2

13	2013/07/02	AS BUILT	GB	IDLK	WMS
12	2014/02/24	ADD TO HVAC 1-4 ADD CEILING TO NICHE-IFC	AM	IDLK	WMS
11	2013/12/10	ADD TO HVAC 1-4 ADD CEILING TO NICHE-IFC	AM	IDLK	WMS
10	2013/12/10	ADD TO HVAC 1-4 ADD CEILING TO NICHE-IFC	AM	IDLK	WMS
9	2013/04/23	ADD TO HVAC 1-4 ADD CEILING TO NICHE-IFC	AM	IDLK	WMS
8	2013/02/18	ADD TO HVAC 1-4 ADD CEILING TO NICHE-IFC	AM	IDLK	WMS
7	2013/02/18	ADD TO HVAC 1-4 ADD CEILING TO NICHE-IFC	AM	IDLK	WMS
6	2013/02/18	ADD TO HVAC 1-4 ADD CEILING TO NICHE-IFC	AM	IDLK	WMS
5	2013/02/18	ADD TO HVAC 1-4 ADD CEILING TO NICHE-IFC	AM	IDLK	WMS
4	2013/02/18	ADD TO HVAC 1-4 ADD CEILING TO NICHE-IFC	AM	IDLK	WMS
3	2013/02/18	ADD TO HVAC 1-4 ADD CEILING TO NICHE-IFC	AM	IDLK	WMS
2	2013/02/18	ADD TO HVAC 1-4 ADD CEILING TO NICHE-IFC	AM	IDLK	WMS
1	2013/02/18	ADD TO HVAC 1-4 ADD CEILING TO NICHE-IFC	AM	IDLK	WMS

MEDIPI POWER STATION
LABORATORY PLAN

07015 - L - 23.100

SHEET	REV
7	13