


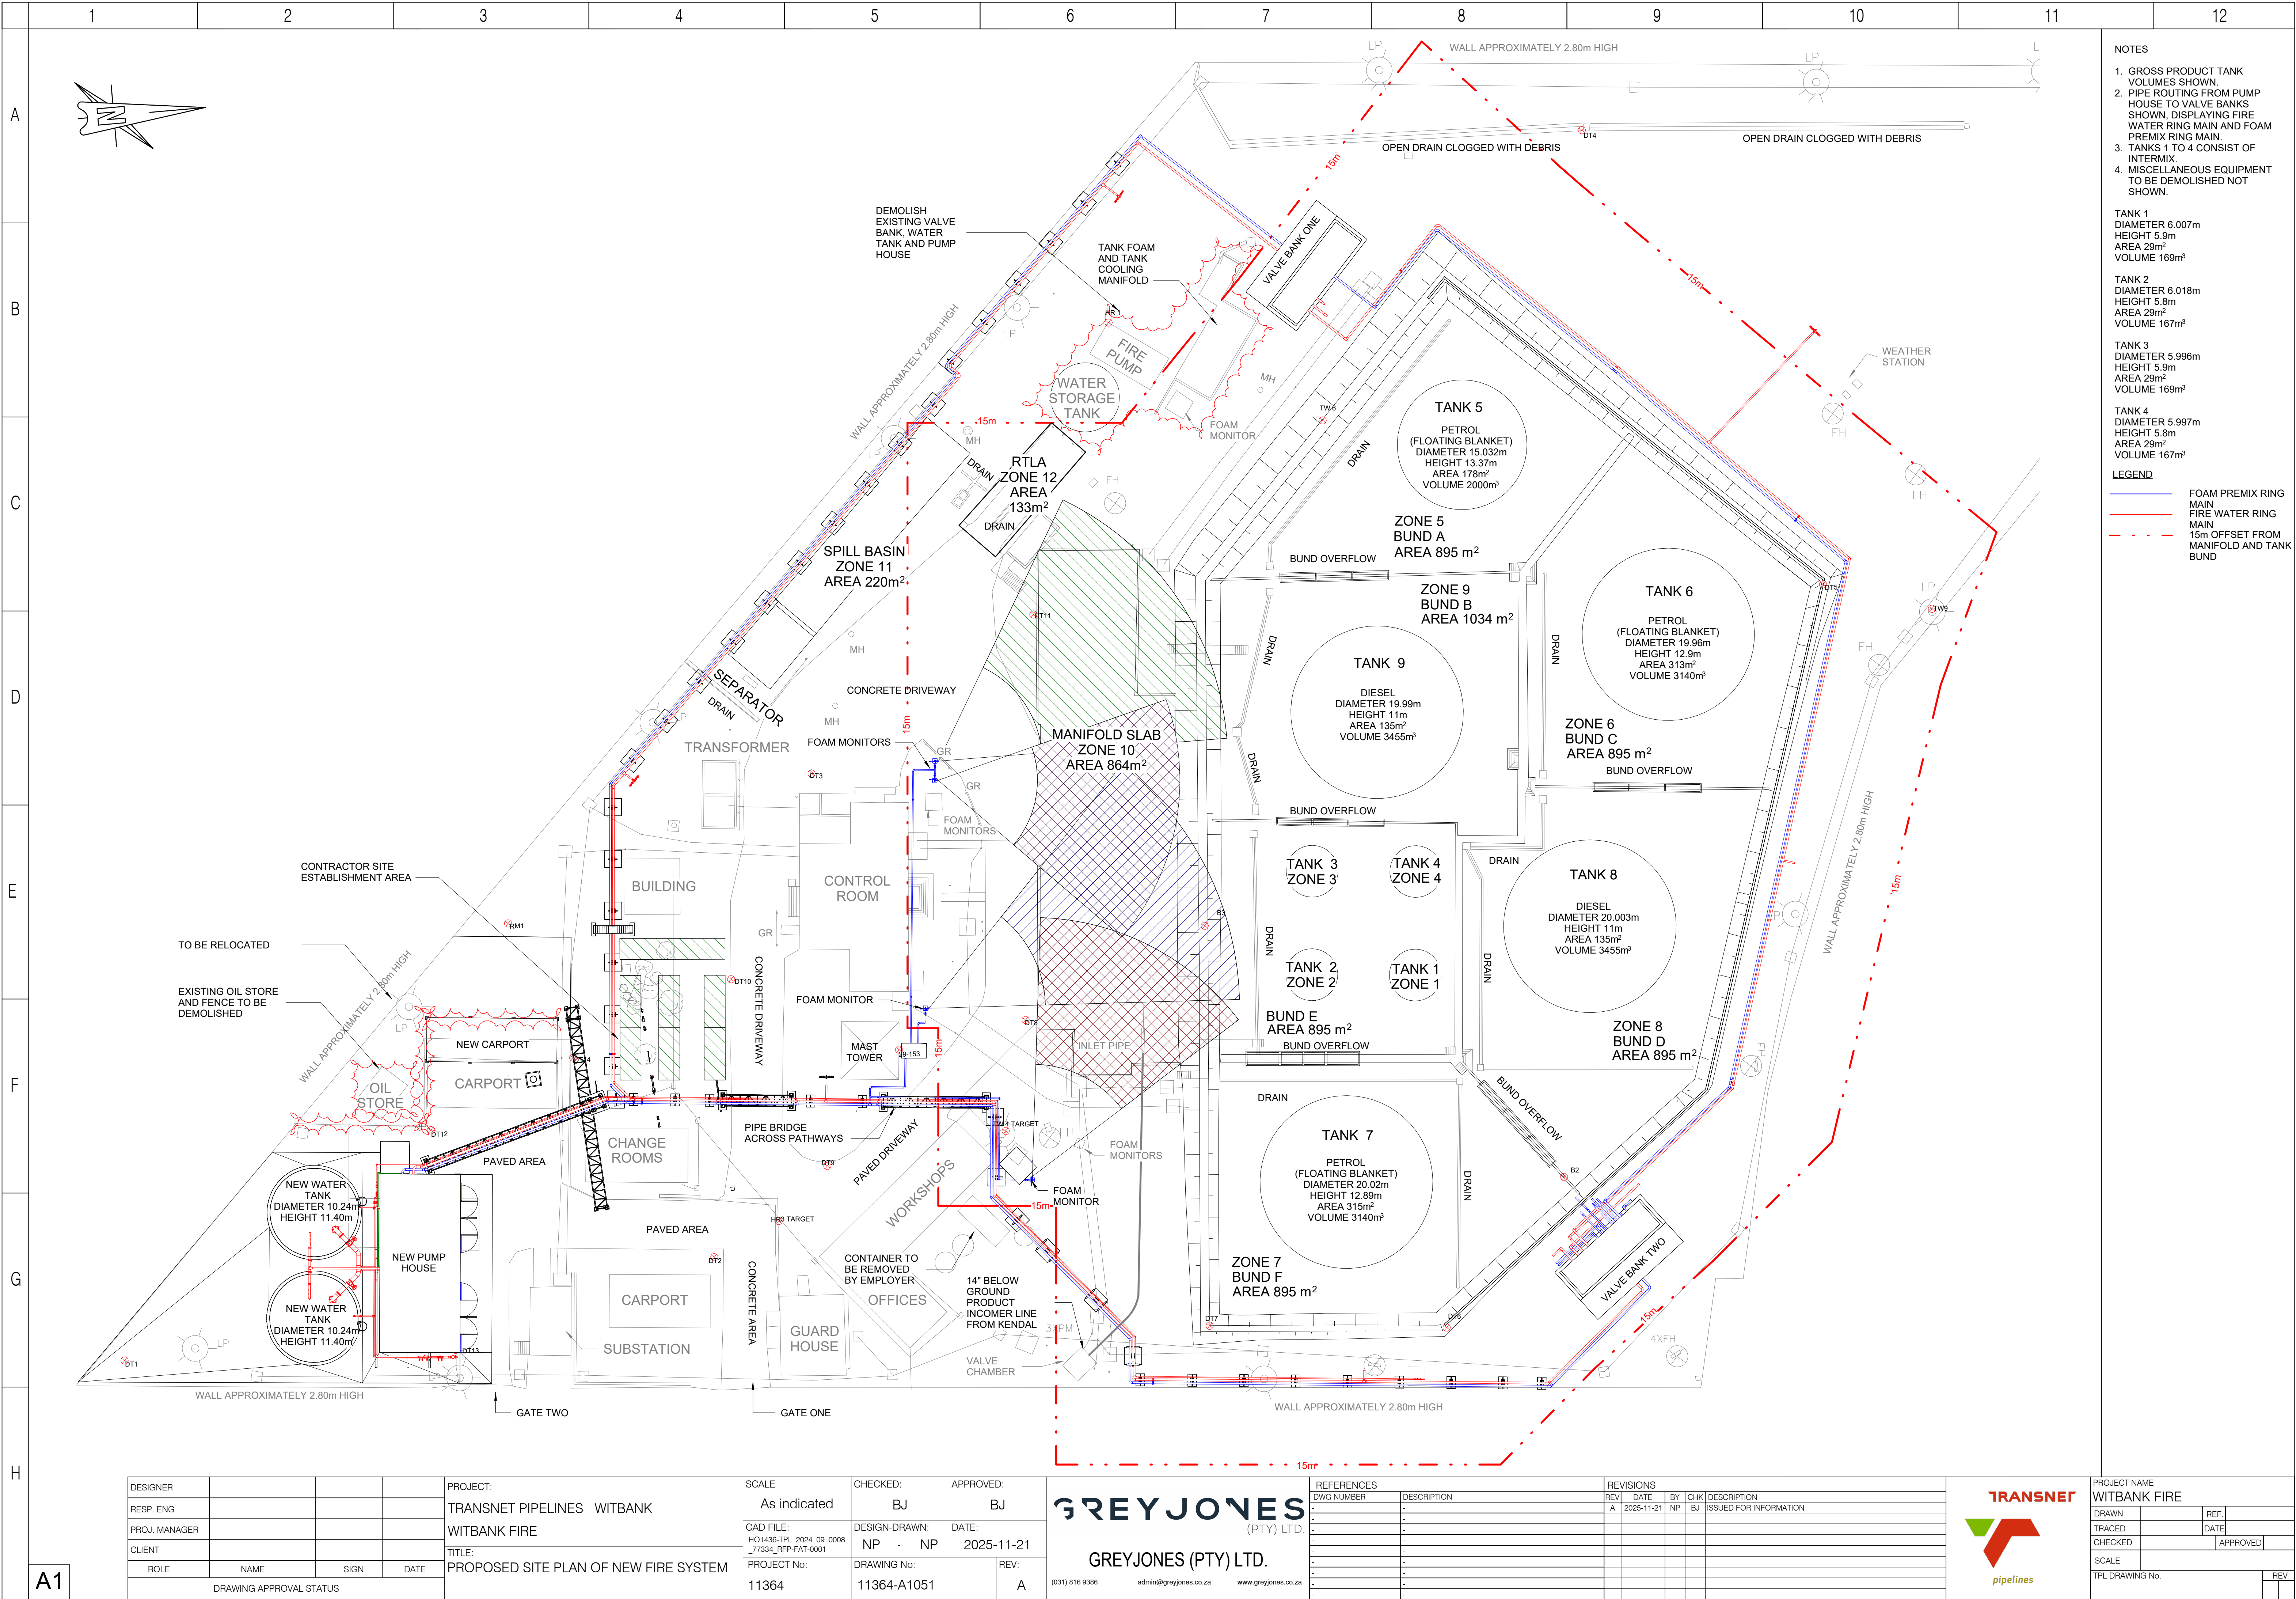

- NOTES
- GROSS PRODUCT TANK VOLUMES SHOWN.
 - PIPE ROUTING FROM PUMP HOUSE TO VALVE BANKS SHOWN, DISPLAYING FIRE WATER RING MAIN AND FOAM PREMIX RING MAIN.
 - TANKS 1 TO 4 CONSIST OF INTERMIX.
 - MISCELLANEOUS EQUIPMENT TO BE DEMOLISHED NOT SHOWN.
- TANK 1
DIAMETER 6.007m
HEIGHT 5.9m
AREA 29m²
VOLUME 169m³
- TANK 2
DIAMETER 6.018m
HEIGHT 5.8m
AREA 29m²
VOLUME 167m³
- TANK 3
DIAMETER 5.996m
HEIGHT 5.9m
AREA 29m²
VOLUME 169m³
- TANK 4
DIAMETER 5.997m
HEIGHT 5.8m
AREA 29m²
VOLUME 167m³
- LEGEND
- FOAM PREMIX RING MAIN
 - FIRE WATER RING MAIN
 - 15m OFFSET FROM MANIFOLD AND TANK BUND

DESIGNER			
RESP. ENG			
PROJ. MANAGER			
CLIENT			
ROLE	NAME	SIGN	DATE
DRAWING APPROVAL STATUS			

PROJECT:	TRANSNET PIPELINES WITBANK
	WITBANK FIRE
TITLE:	PROPOSED SITE PLAN OF NEW FIRE SYSTEM

SCALE	As indicated	CHECKED:	BJ	APPROVED:	BJ
CAD FILE:	HO1436-TPL 2024_09_0008	DESIGN-DRAWN:	NP	DATE:	2025-11-21
	77334_RFP-FAT-0001	NP	NP		
PROJECT No:	11364	DRAWING No:	11364-A1051	REV:	A

GREYJONES

(PTY) LTD.

GREYJONES (PTY) LTD.

(031) 816 9386

admin@greyjones.co.za

www.greyjones.co.za

REFERENCES		REVISIONS			
DWG NUMBER	DESCRIPTION	REV	DATE	BY	CHK
		A	2025-11-21	NP	BJ

TRANSNET

pipelines

PROJECT NAME

WITBANK FIRE

DRAWN

REF

TRACED

DATE

CHECKED

APPROVED

SCALE

TPL DRAWING No.

REV

