


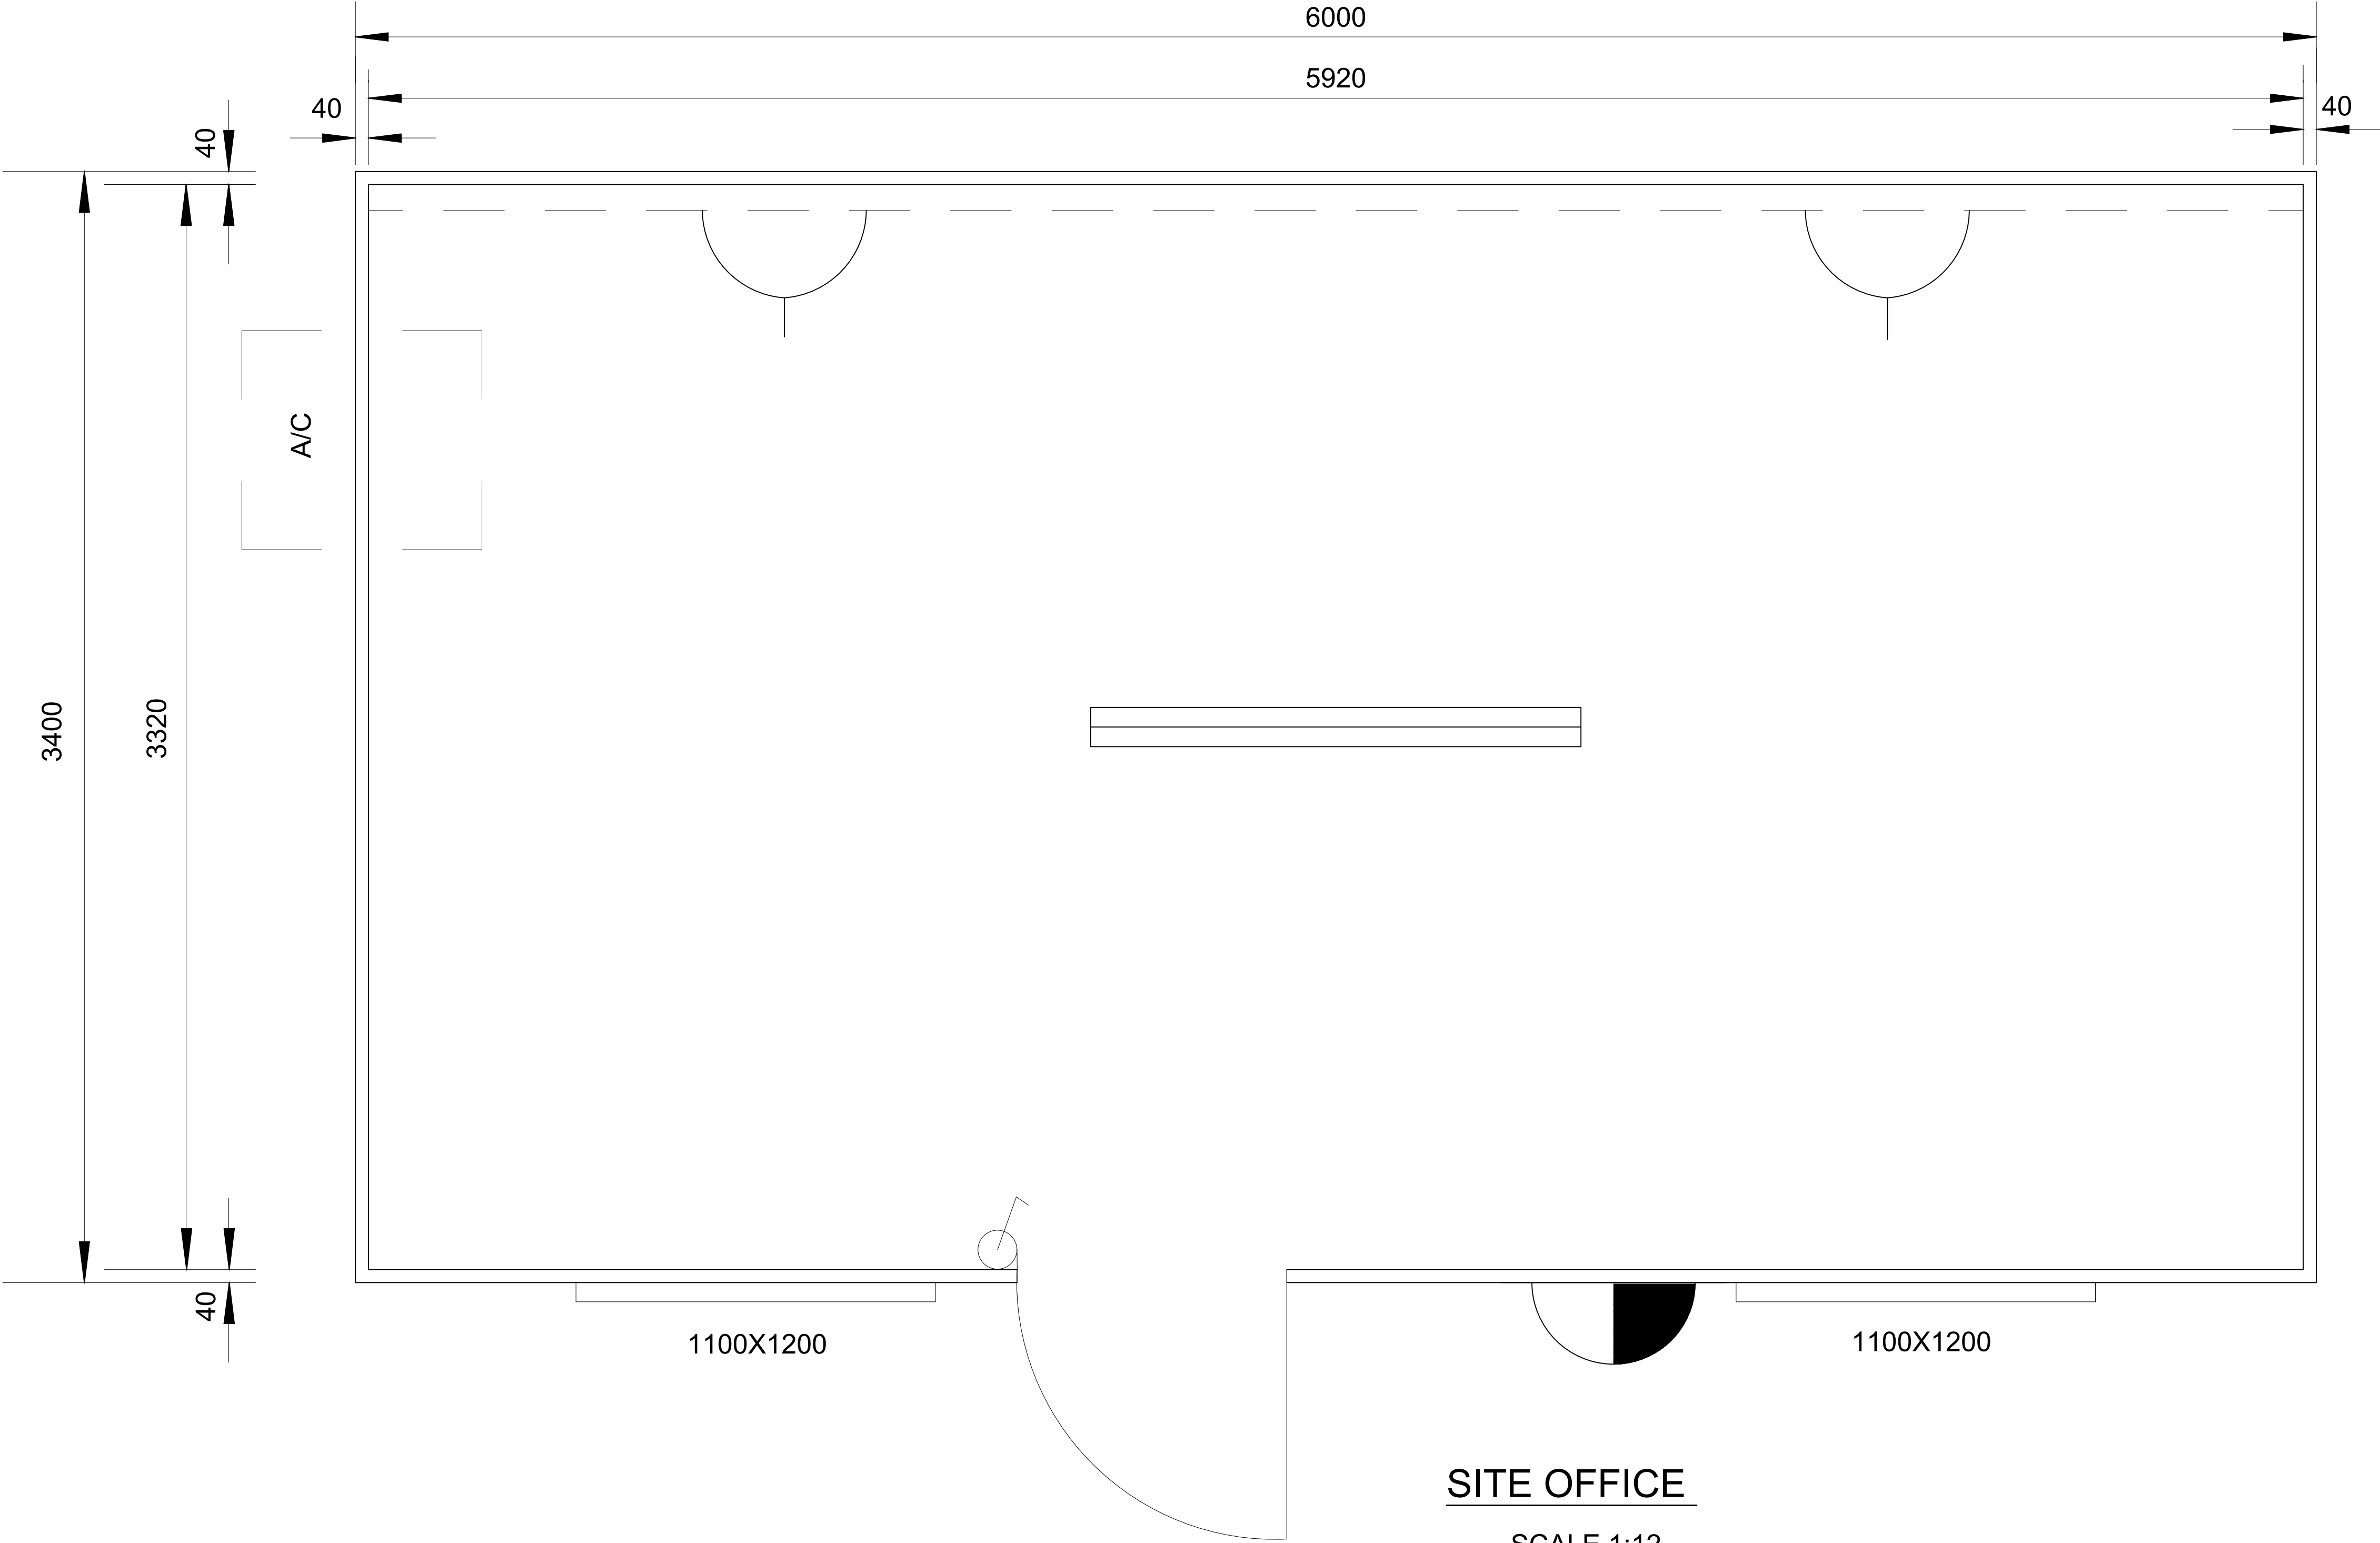


ELECTRICAL LEGEND

- FLUORESCENT LIGHTING
- SECURITY LIGHTING
- PLUG POINT
- SWITCH POINT
- AIR CONDITIONER

NOTES

- DOORS**
INTERIOR WALL PLY C/DECK
EXTERIOR WALL PLY C/DECK
- ELECTRICITY**
D.B220V
NORMAL TRUNKING
- OTHER**
IND. VINYL
- OFFICE FURNITURE
AS PER THE BID SPECIFICATION

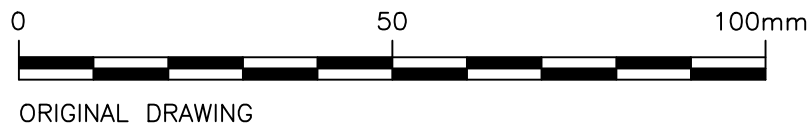

No.	REFERENCE DRAWINGS
-----	--------------------

0	ISSUED FOR TENDER	06/23	CM	SM
△	REVISIONS	DATE	CHKD	APPRV
ONLY REVISIONS MARKED THUS △ ARE VALID				

DESIGNED	B. MLALAZI
CHECKED	G. MLAMBO
DRAWN	B. MLALAZI
CHECKED	G. MLAMBO
PROJ. ENG.	G. MLAMBO



TEL: (033) 346 0689
FAX: (033) 346 0692
E-mail: ziyanda@ziyandaconsulting.co.za

APPROVED: S. MGUTSHINI
(PR ENG REG. No. 20040208)

PO BOX 809
HILTON
PIETERMARITZBURG
3245



APPROVED: _____

PROJECT/DRAWING TITLE

UMKHANYAKUDE DISTRICT MUNICIPALITY

THEMBALETHU SANITATION PROJECT

CONSTRUCTION OF CIVIL WORKS FOR THE UPGRADE OF THE MKUZE WASTEWATER TREATMENT WORKS AT MKUZE

SITE OFFICE PLAN

DRAWING STATUS

ISSUED FOR TENDER

ORIGINAL SCALE

AS SHOWN ON A1

ALT. DWG. No.	CONTRACT No.
SHT. No.	PROJECT No.
DRAWING No.	
REVISION	

079(07) - D13

0