


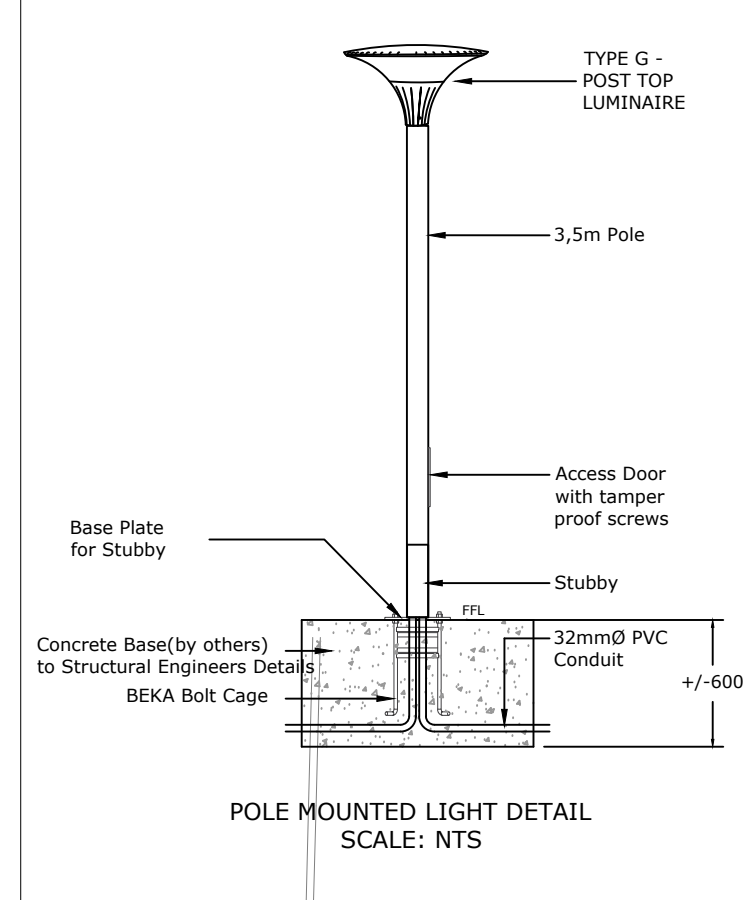

GENERAL NOTES


This drawing is issued for Electrical purposes only, and should be read in conjunction with the Electrical Specification. Setting out of Electrical and Electronic accessories are to be as indicated on Architects details.

Refer to Architects and Structural Drawings for all building dimensions, latest building revisions and services.

Do not scale this drawing.

All work to comply with relevant Standards, Codes of Practice, Specification and Regulations.

Notwithstanding anything to the contrary, all rights reserved. No part of this drawing may be reproduced in any material form (including photo-copying or storage in any medium or by electronic means and whether or not transiently or incidentally to some other use of this drawing). In addition, this drawing may not be used for any purpose or reason other than for which it was originally issued, without written permission of the author.

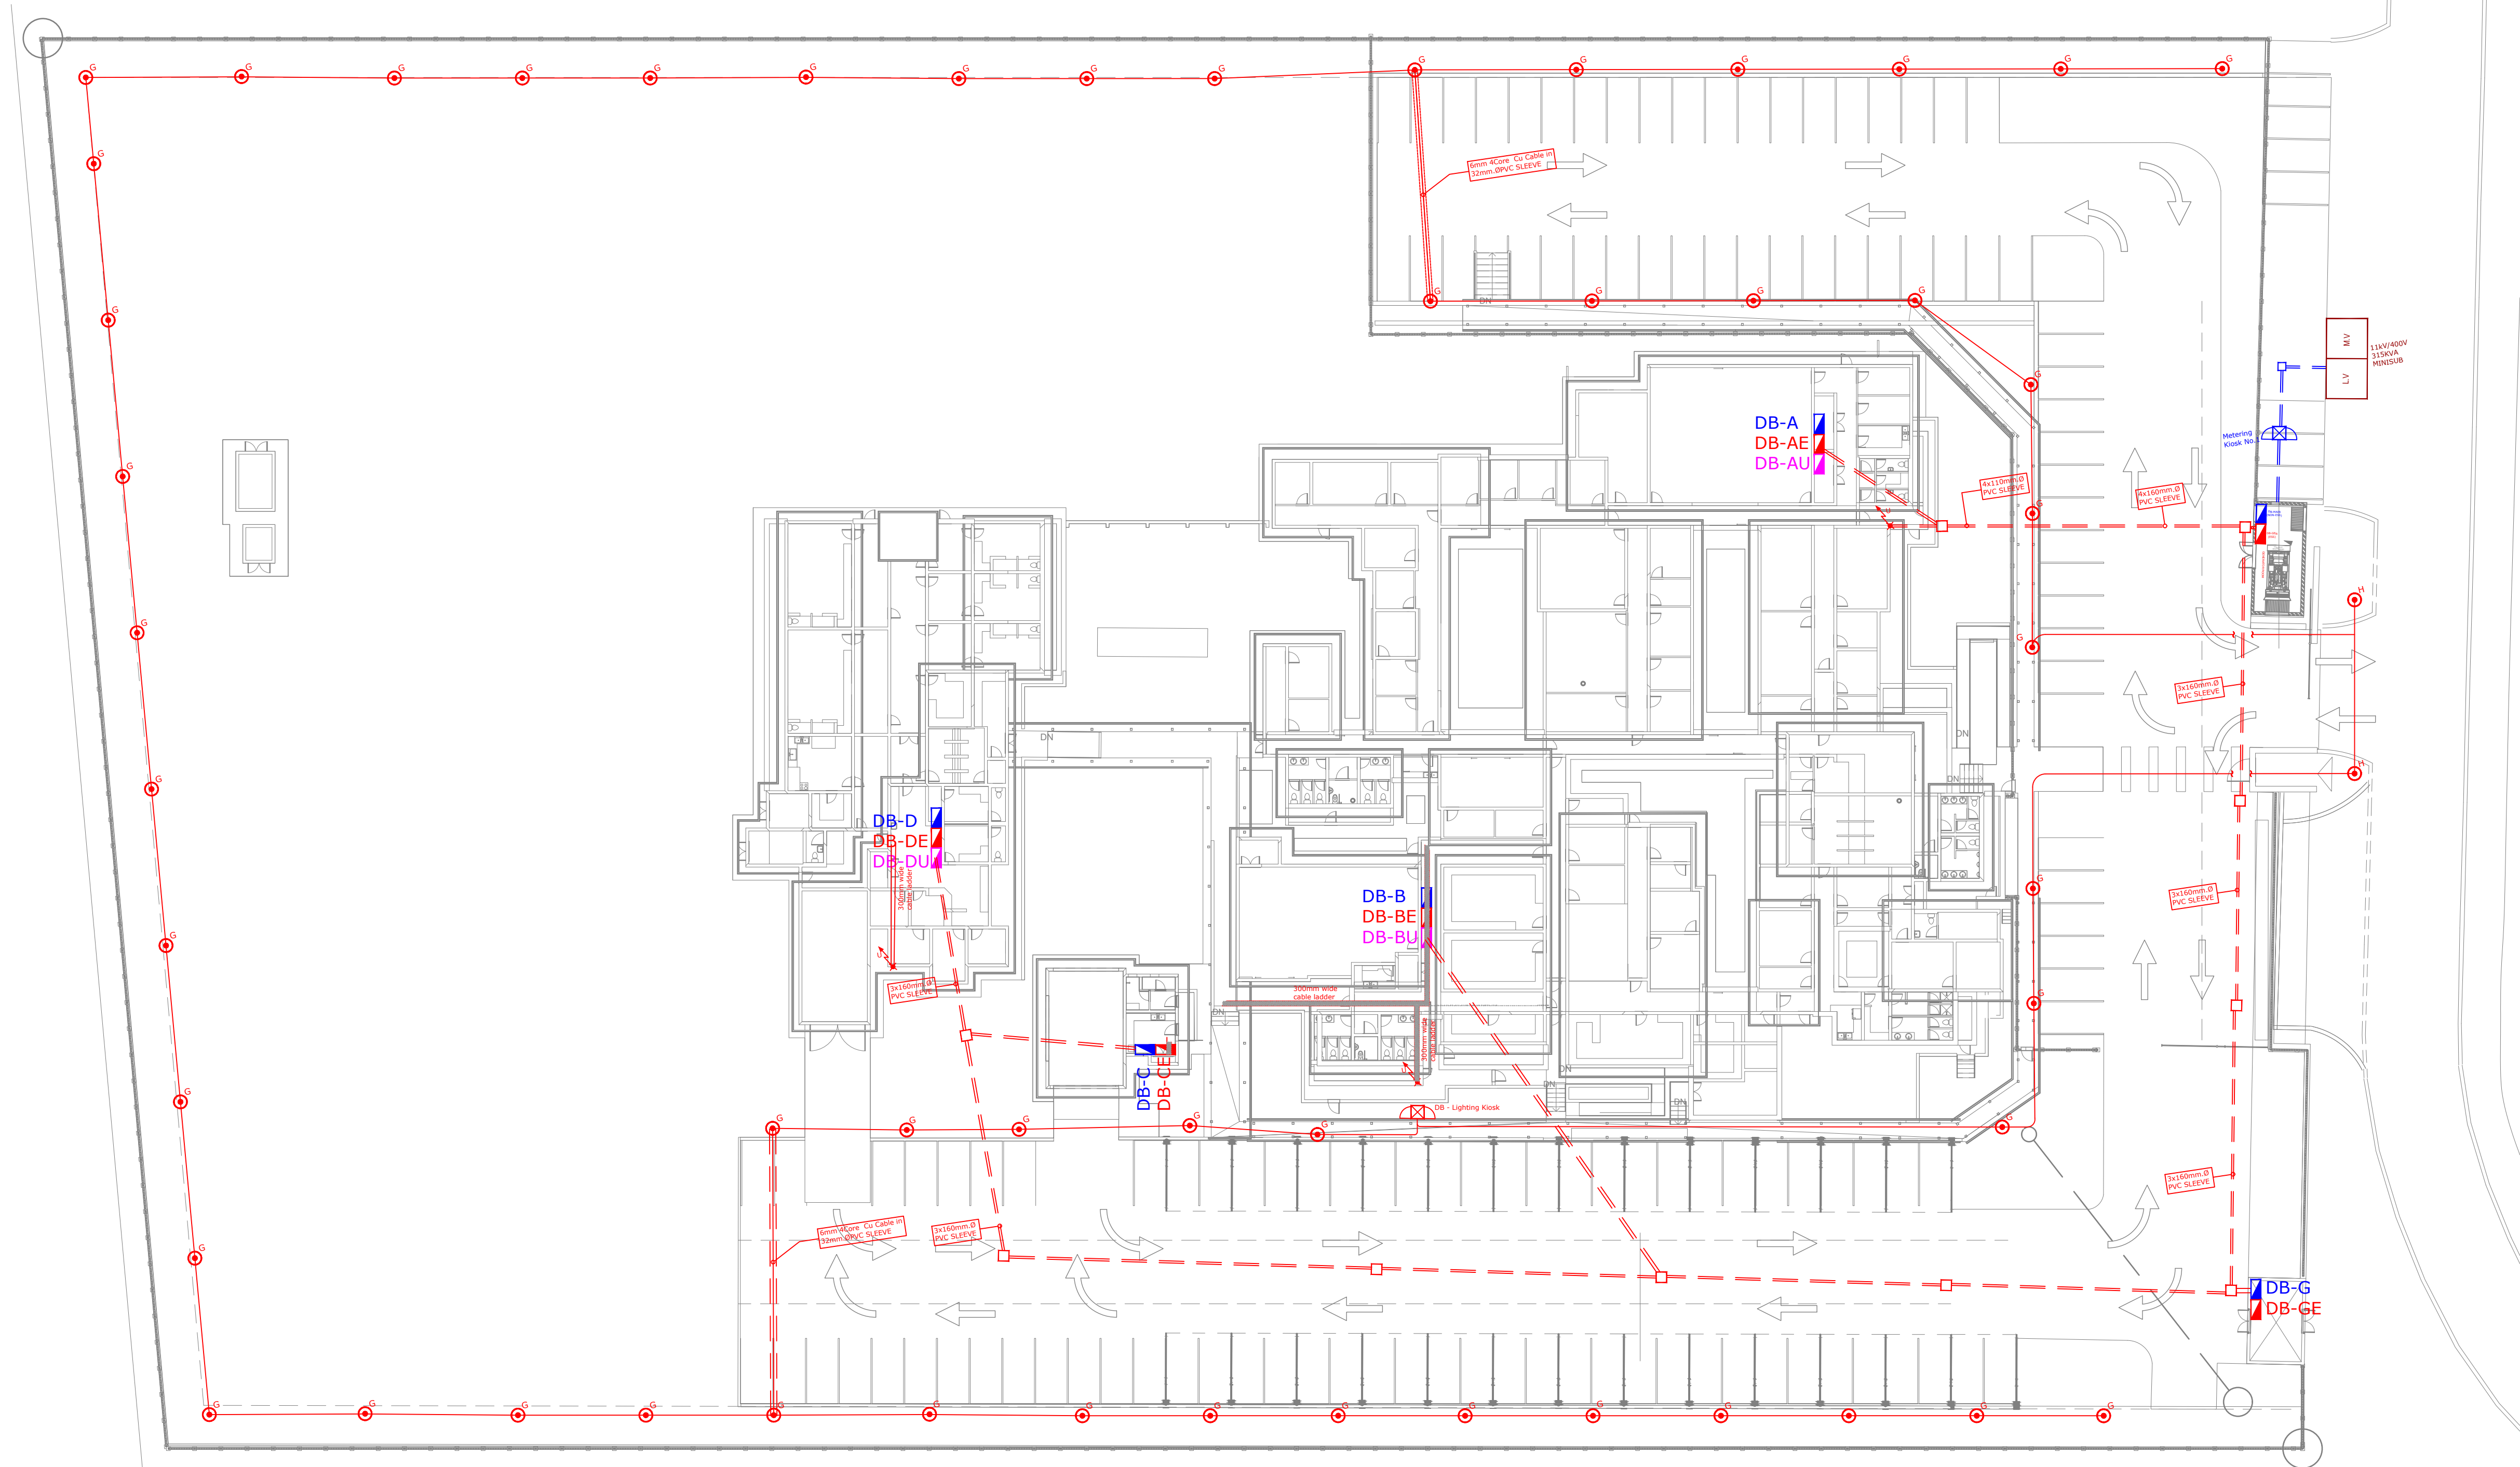

NOTES: (1) - Contractor to ensure max distance between draw boxes 20 metres notwithstanding anything to contrary. (2) - Draw boxes required after every second 90 deg. bend or 180 deg. total of slow bends. (3) - All unwired conduits to be provided with draw wires. These will be withdrawn and checked at random. (4) - Cast in conduits to be spaced 35mm. minimum.			
100x100 CONDUIT BOX. 100x100 CONDUIT BOX AT 500AFTL. 100x100 CONDUIT BOX AT 1400AFTL. 100x50 CONDUIT BOX. 100x50 CONDUIT BOX AT 300AFTL. 100x50 CONDUIT BOX AT 1400AFTL. ROUND CONDUIT BOX. CLUSTER BOX (SIZE AS NOTED).	ROUND DRAW BOX. 100x100 DRAW BOX. 100x50 BOX BEHIND POWER SKIRTING. CONDUIT TURNED UP (7° FOR DOWN). DOWN CONDUCTOR TO EARTH OR EARTH TIE.	ROUND CONDUIT BOX FOR: DM - DOOR MONITOR. CM - CAMERA. AA - ACCESS ALARM. AC - ACCESS CONTROL. CR - CARD READER. COM - COMMUNICATION/INTERCOM. BOM - BACK GROUND MUSIC. EL - ELECTRIC LOCK/STRIKE.	20mm. DIA. CONDUIT. 25mm. DIA. CONDUIT. 32mm. DIA. CONDUIT. 50mm. DIA. CONDUIT. SECTION OF CONDUIT OMITTED FOR CLARITY. SURFLEX. TWIN AND EARTH CABLE ROUTE. OVERHEAD CAST-IN. OVERHEAD ON SURFACE OR LAID ON CEILING. FLOOR SLAB CAST-IN. FLOOR SURFACE (IN FLOOR VOID). POWER SKIRTING. TRUNKING. CABLE SLEEVE. CABLE TRAY/LADDER. SQUARE GALV. STEEL DRAW TRAY SIZE AS SHOWN. TELEPHONE JUNCTION BOX. INTERCOM JUNCTION BOX. DATA/COMMS JUNCTION BOX. SECURITY, ETC. JUNCTION BOX. DISTRIBUTION BOARD POSITION. DB-1 BOARD DESIGNATION NUMBER. 16A SANS 164-1 SWITCHED SOCKET OUTLET (SSO). 16A SANS 164-1 DOUBLE SSO. 16A SANS 164-2 SSO ON PEDESTAL. 16A SANS 164-2 3 PIN SSO. 16A SANS 164-1 & 164-2 COMBINATION SSO. 16A SANS 164-4 RED SSO (7° SHAVED EARTH PIN). 16A SANS 164-4 RED SSO ON PEDESTAL. 3 PHASE C-FORM SSO. 2 POLE ISOLATOR. 3 POLE ISOLATOR. 4 POLE ISOLATOR. 6A SANS 164-3 U/S SOCKET OUTLET. SINGLE LEVER ONE WAY LIGHT SWITCH. INTERMEDIATE LIGHT SWITCH. TWO WAY LIGHT SWITCH. MOTION SENSOR. LINEAR LUMINAIRE. BULKHEAD/DOWNLIGHTER, ETC. WALL MOUNTED LUMINAIRES. POLE MOUNTED LUMINAIRE. TELEPHONE POINT. TELEPHONE POINT ON PEDESTAL. DIRECT OUTSIDE LINE TELEPHONE POINT (CALL BOX). TV OUTLET. DATA/COMMS OUTLET. BELL PUSH. BELL OUTLET. SIGN POINT. CLOCK OUTLET. PHOTOCELL. REFERENCE TO QUANTITY i.e. 3No. REFERENCE TO A DETAIL i.e. DETAIL 2. REFERENCE TO AN ELECTRICAL NOTE i.e. NOTE 4. REFERENCE TO A STANDARD DRAWING i.e. STANDARD DRAWING No.34. CABLE NUMBER - REFER CABLE SCHEDULE FOR DETAILS. LUMINAIRE TYPE "B" - REFER LUMINAIRE SCHEDULE.

REV	DATE	BY	DESCRIPTION	CHK
D	09/07/24	NG	Detail A Added	
C	01/07/24	MH	DB-E Removed	
B	20/5/24	MH	Perimeter lighting Added	
A	6/5/24	MH	General revision	
O	8/6/23	CG	Original Issue	
REVISIONS				



IBUYA PROJECTS
"EMPOWERING DEVELOPMENT"

BLOCK D
ESSEX PARK
48 ESSEX TERRACE
WESTVILLE
P.O. BOX 1692
WANDERBEEK 3631

TEL: +27 (0)31 2667831
FAX: +27 (0)31 2667831
E-mail: ibuya@ibuya.co.za

PROJECT/SERVICES			
Ikageng Police Station			
Electrical Installation			
Site Plan cable reticulation			
ENGINEER:	DRAWN BY:	DATE:	CHECKED:
S Nzama	NG	8/6/23	1:300
PROJECT No:	DRAWING No:	SHEET:	REV:
23029	001		D
FILE:	LAYERS:		