



SD1

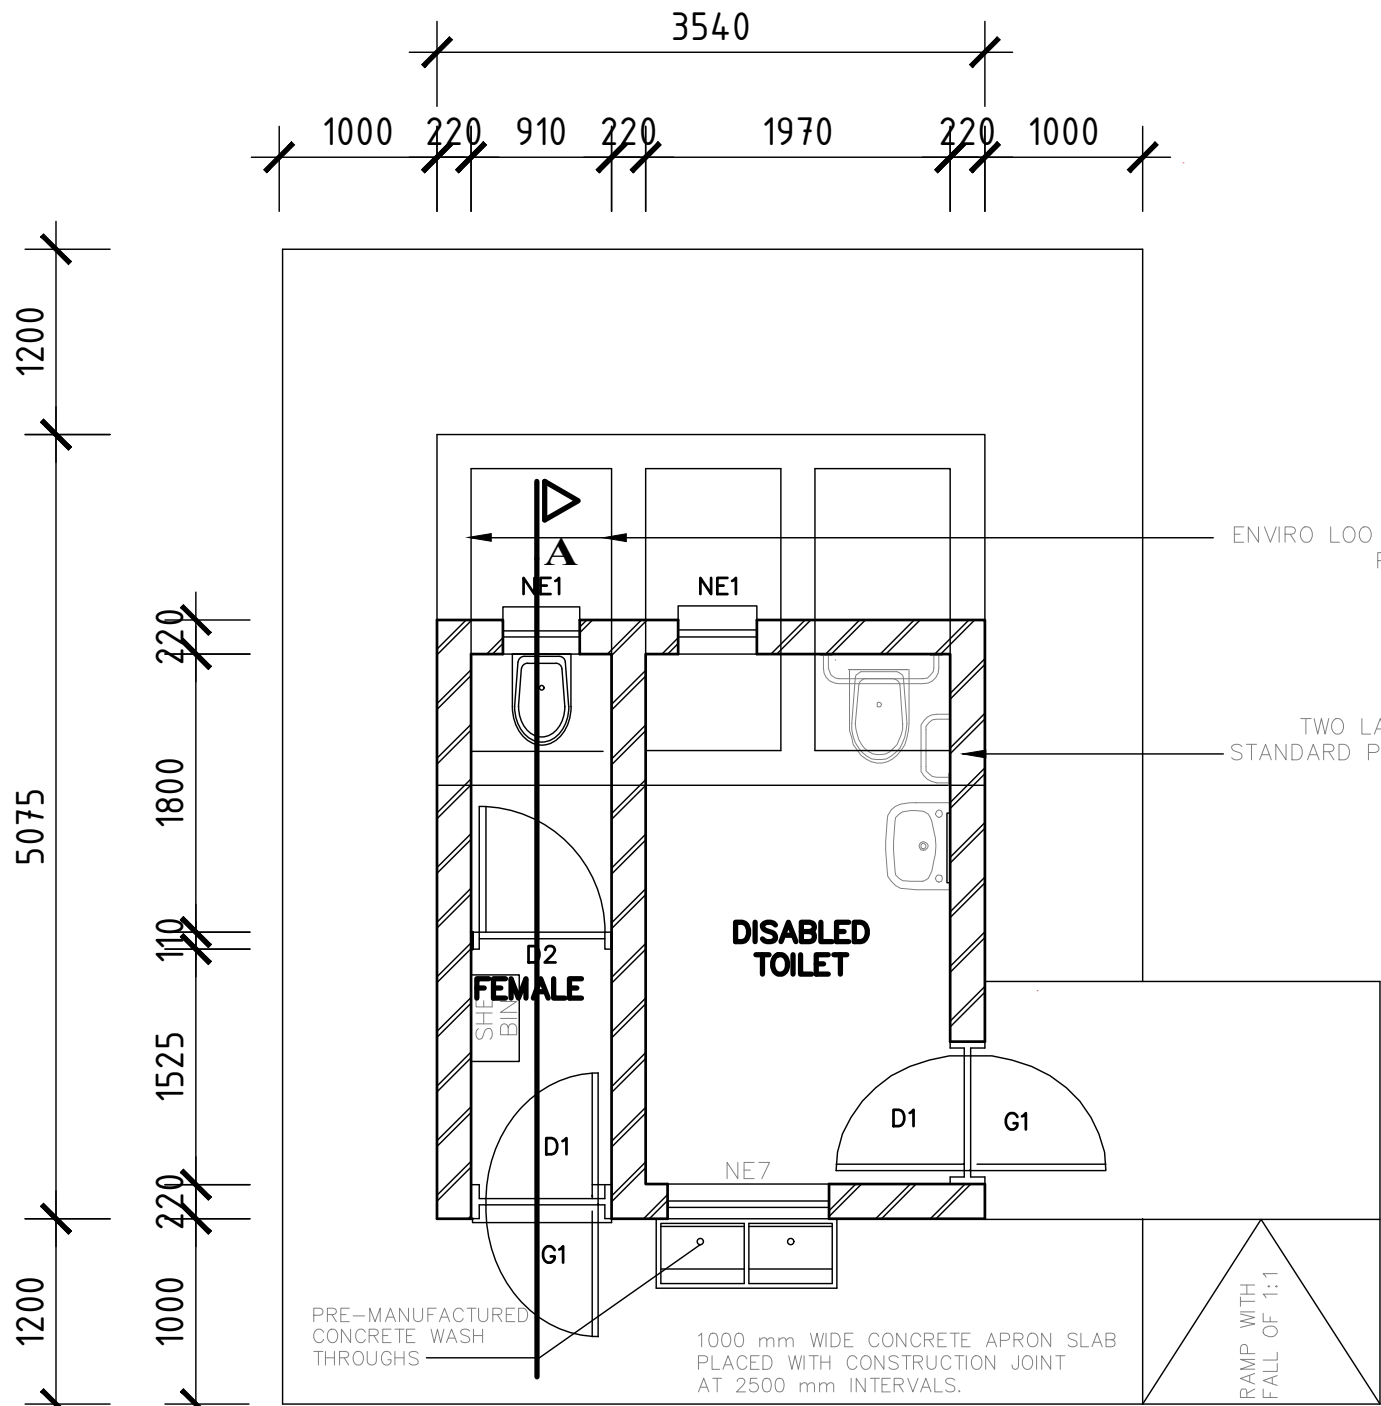

Architectural drawing of the front elevation of a building. The drawing shows a brick wall with a large door on the left and a window on the right. The door has vertical fluting. The window is a double-hung style with a decorative lintel. Above the window is a small decorative element. The drawing is labeled "FRONT" and "SCALE 1:50". There are also labels for "NCL" (Natural Ground Level) and "FFL (2 BRICKS ABOVE GROUND LEVEL)".

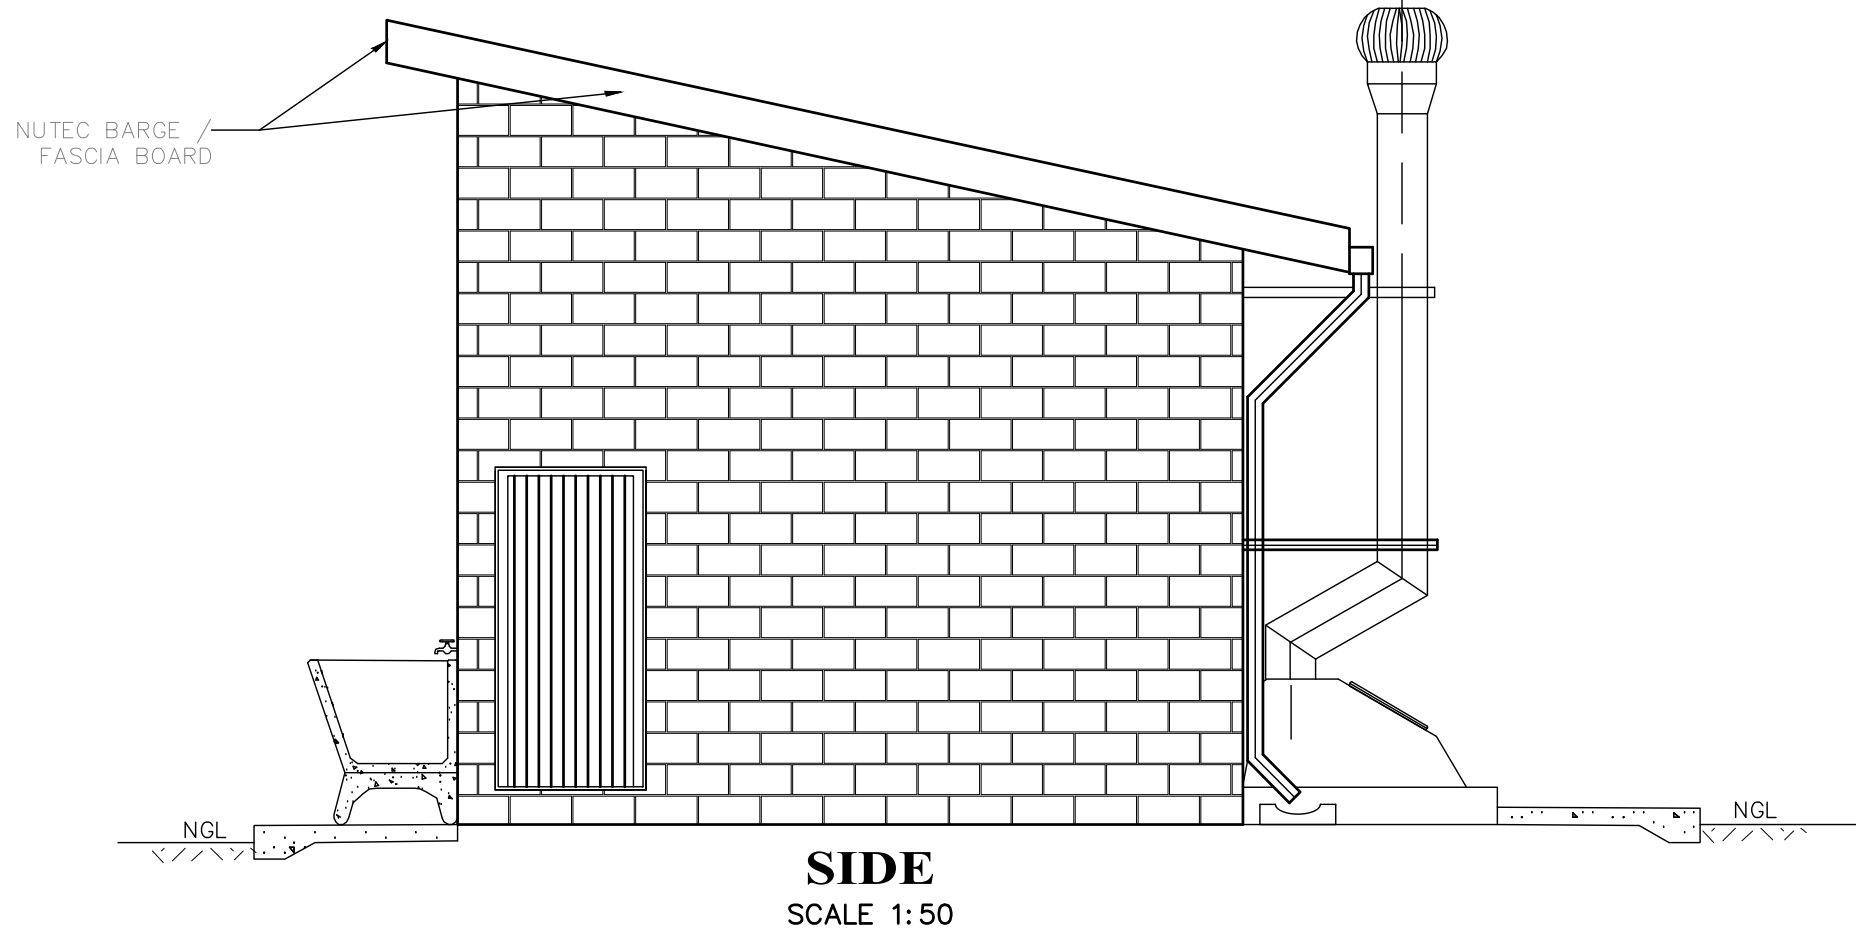

GENERAL NOTES:

1. ALL WORK TO BE CARRIED OUT IN ACCORDANCE WITH THE NATIONAL BUILDING REGULATION AND SABS 0400 OF 1990
2. CONTRACTOR TO READ ONLY FIGURED DIMENSION
3. CONTRACTOR TO VERIFY ALL DIMENSION ON SITE BEFORE COMMENCING WITH ANY WORK.

GENERAL NOTES:

* ALL DIMENSIONS AND LEVELS ARE TO BE VERIFIED ON SITE PRIOR TO COMMENCING SETTING OUT , WORKSHOP DRAWINGS OR CONSTRUCTION .

* FIGURED DIMENSIONS ONLY TO BE USED .

* DISCREPANCIES , ERRORS AND OMISSIONS ARE TO BE REPORTED TO ARCHITECTS IMMEDIATELY THEY BECOME EVIDENT .

* SHOP DRAWINGS TO BE SUBMITTED FOR APPROVAL PRIOR TO MANUFACTURE OR INSTALLATION .

* COPYRIGHT AND RIGHT OF REPRODUCTION OF THIS DRAWINGS OR ANY PORTION THEREOF IS RESERVED MIA ARCHITECTS .

Revisions During Construction			
Rev # :	Issue Date:	Revision description:	Sign:

Revisions Prior to Construction			
Rev # :	Issue Date:	Revision description:	Sign:

Issued for:

Tender - Contract Measurement	X	Construction Client Approval Municipal Approval
-------------------------------	---	---

Detail Symbols

Sector annotation
Location
North-point orientation
Drawing Name:
Scale:
Planning location
Drainage location

Kruger Office Park, Unit 6
100 Marshall Street
Polokwane, 0699
Tel: (015) 291 1005 | Fax: (086) 560 4404
www.srsqs.co.za

Client:

A leading developmental NGO
the mvula trust LIMPOPO

Client project number: CLUSTER 04

Project Title:

PROPOSED NEW WATER, SANITATION AND FENCING FOR THE MVULA TRUST MMATSHIPI SECONDARY SCHOOL
EMIS No.: 904220910

Site information:

UTJANE VILLAGE,
MAUNE CIRCUIT

Project Architect:

Project Co-ordinator/Manager:

Project Architectural Technician:

Drawing Title:

**ENVIROLOO PROTOTYPE -
FEMALE 1 SEAT,
DISABLED 1**

Project number:	Drawing number:	Project Stage:	Drawing Revision:
-	102	Constr	0
Scale: AS SHOWN	Drawn: TM	Checked: RM	
First issue date: 2022/06/30	Latest issue date: 2022/08/16		