



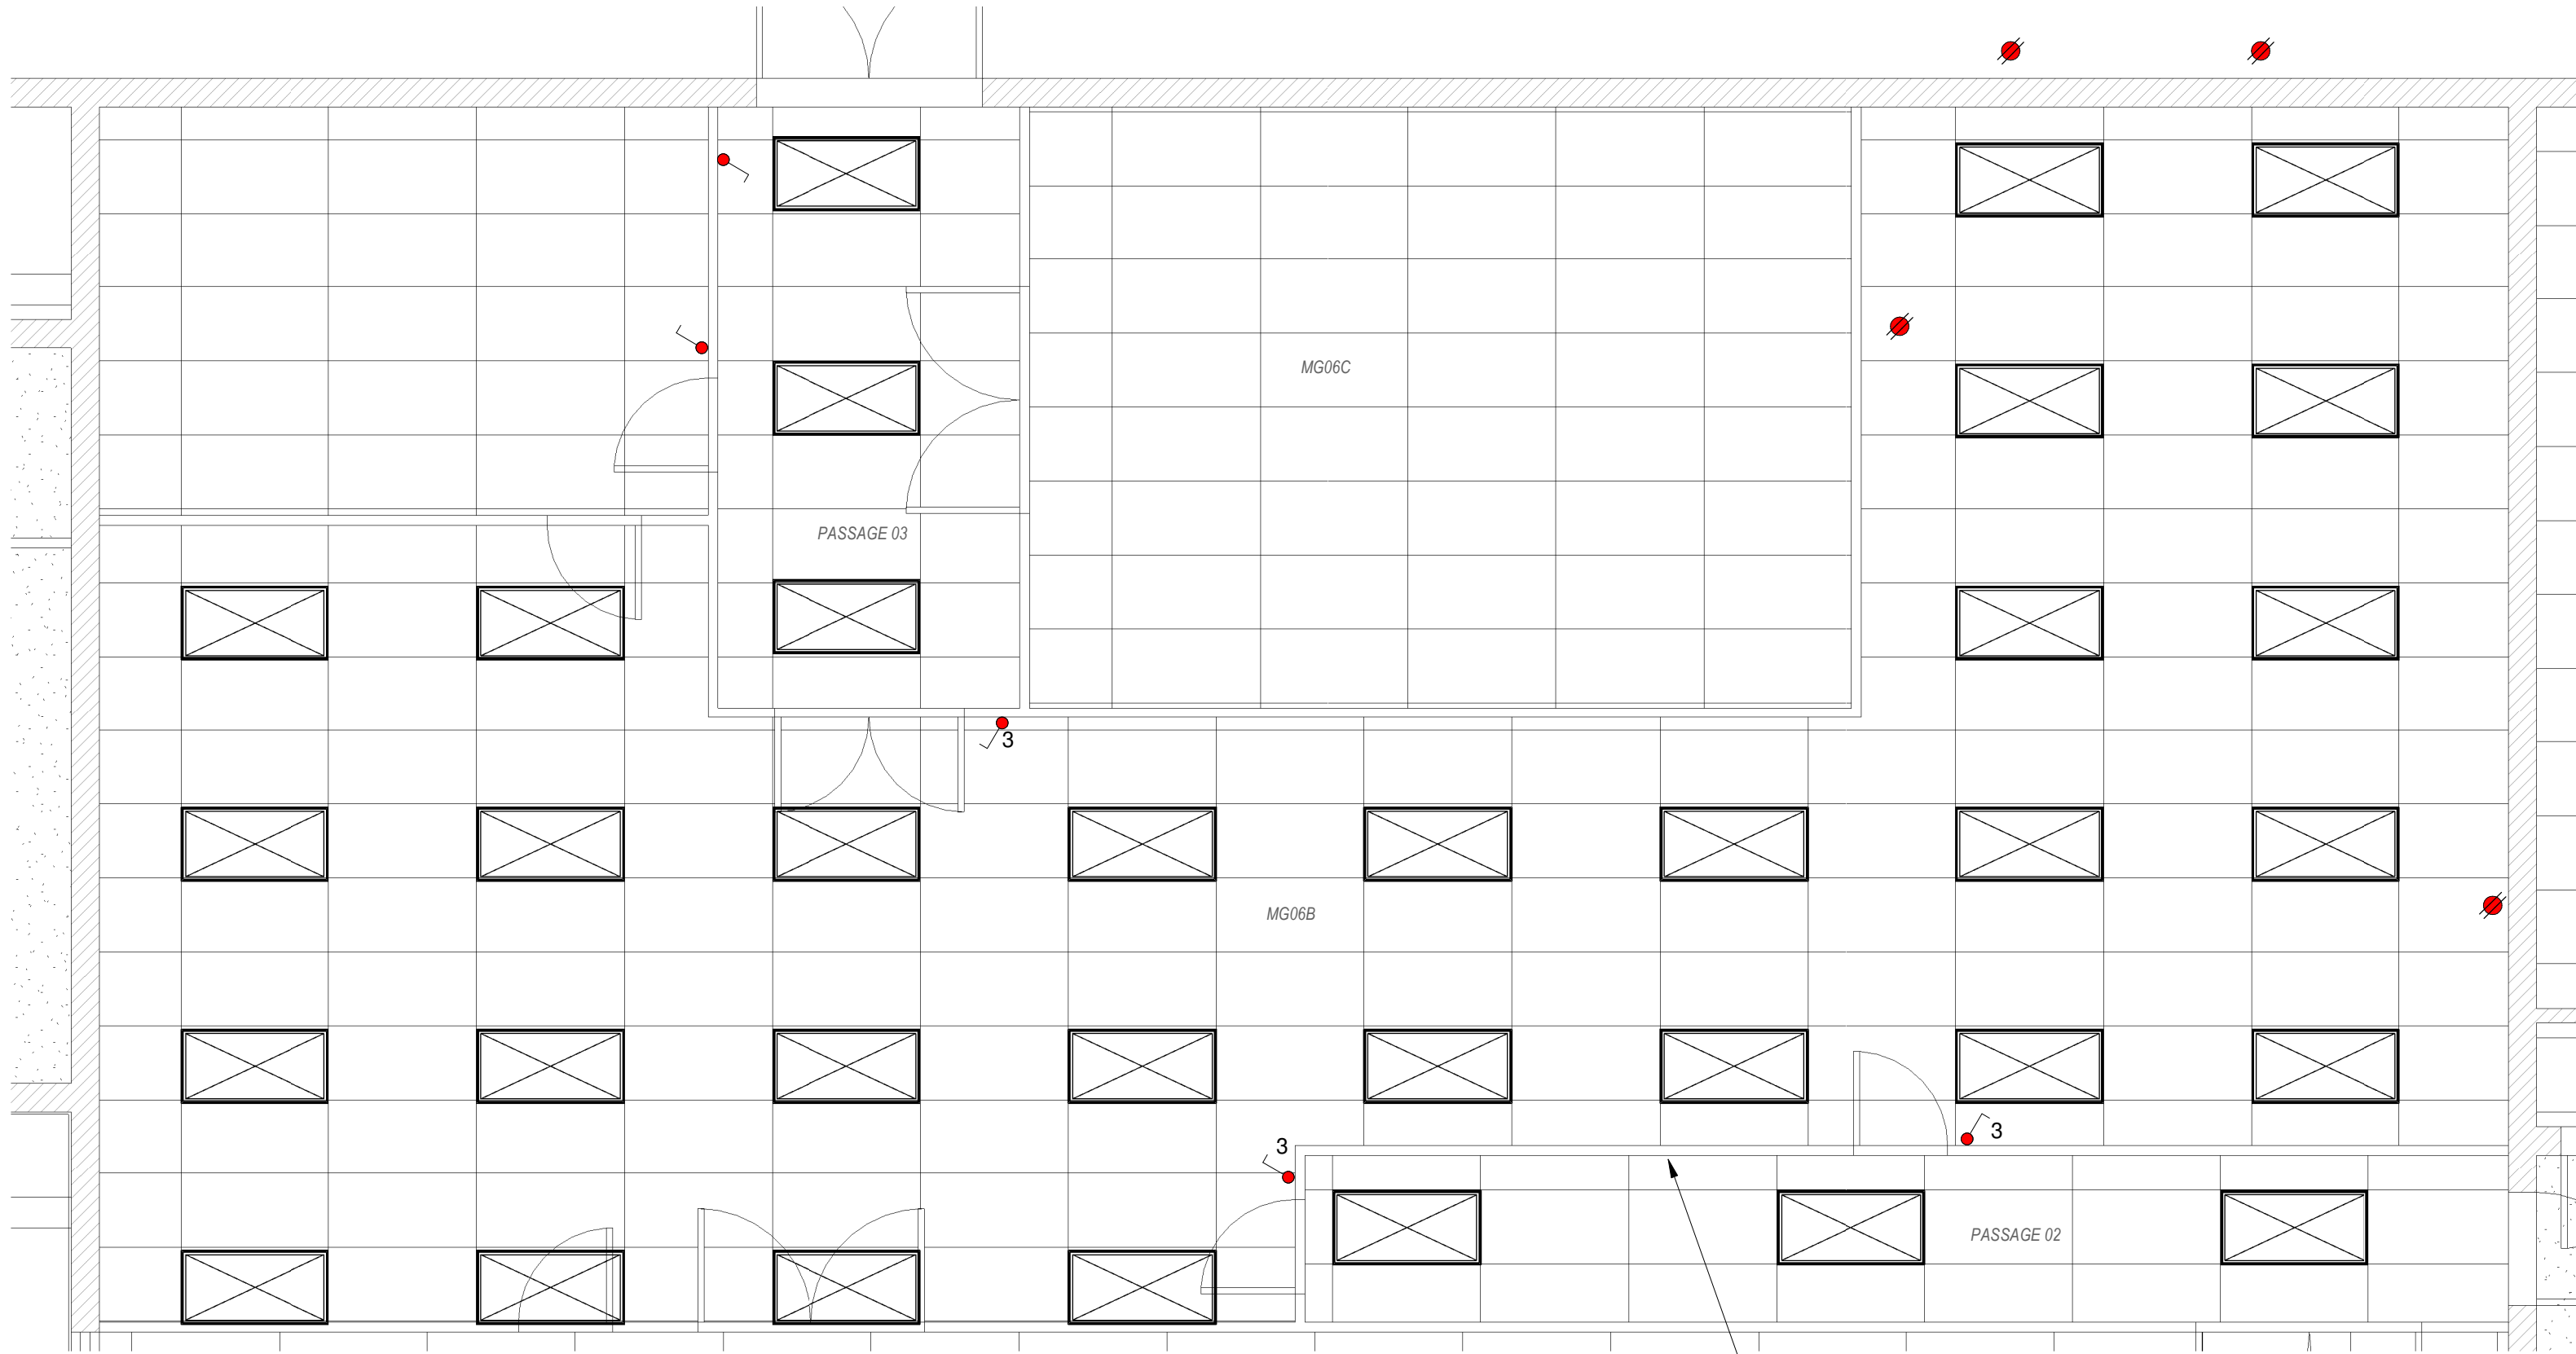


1 MG06B LIGHTING LAYOUT
1 : 50

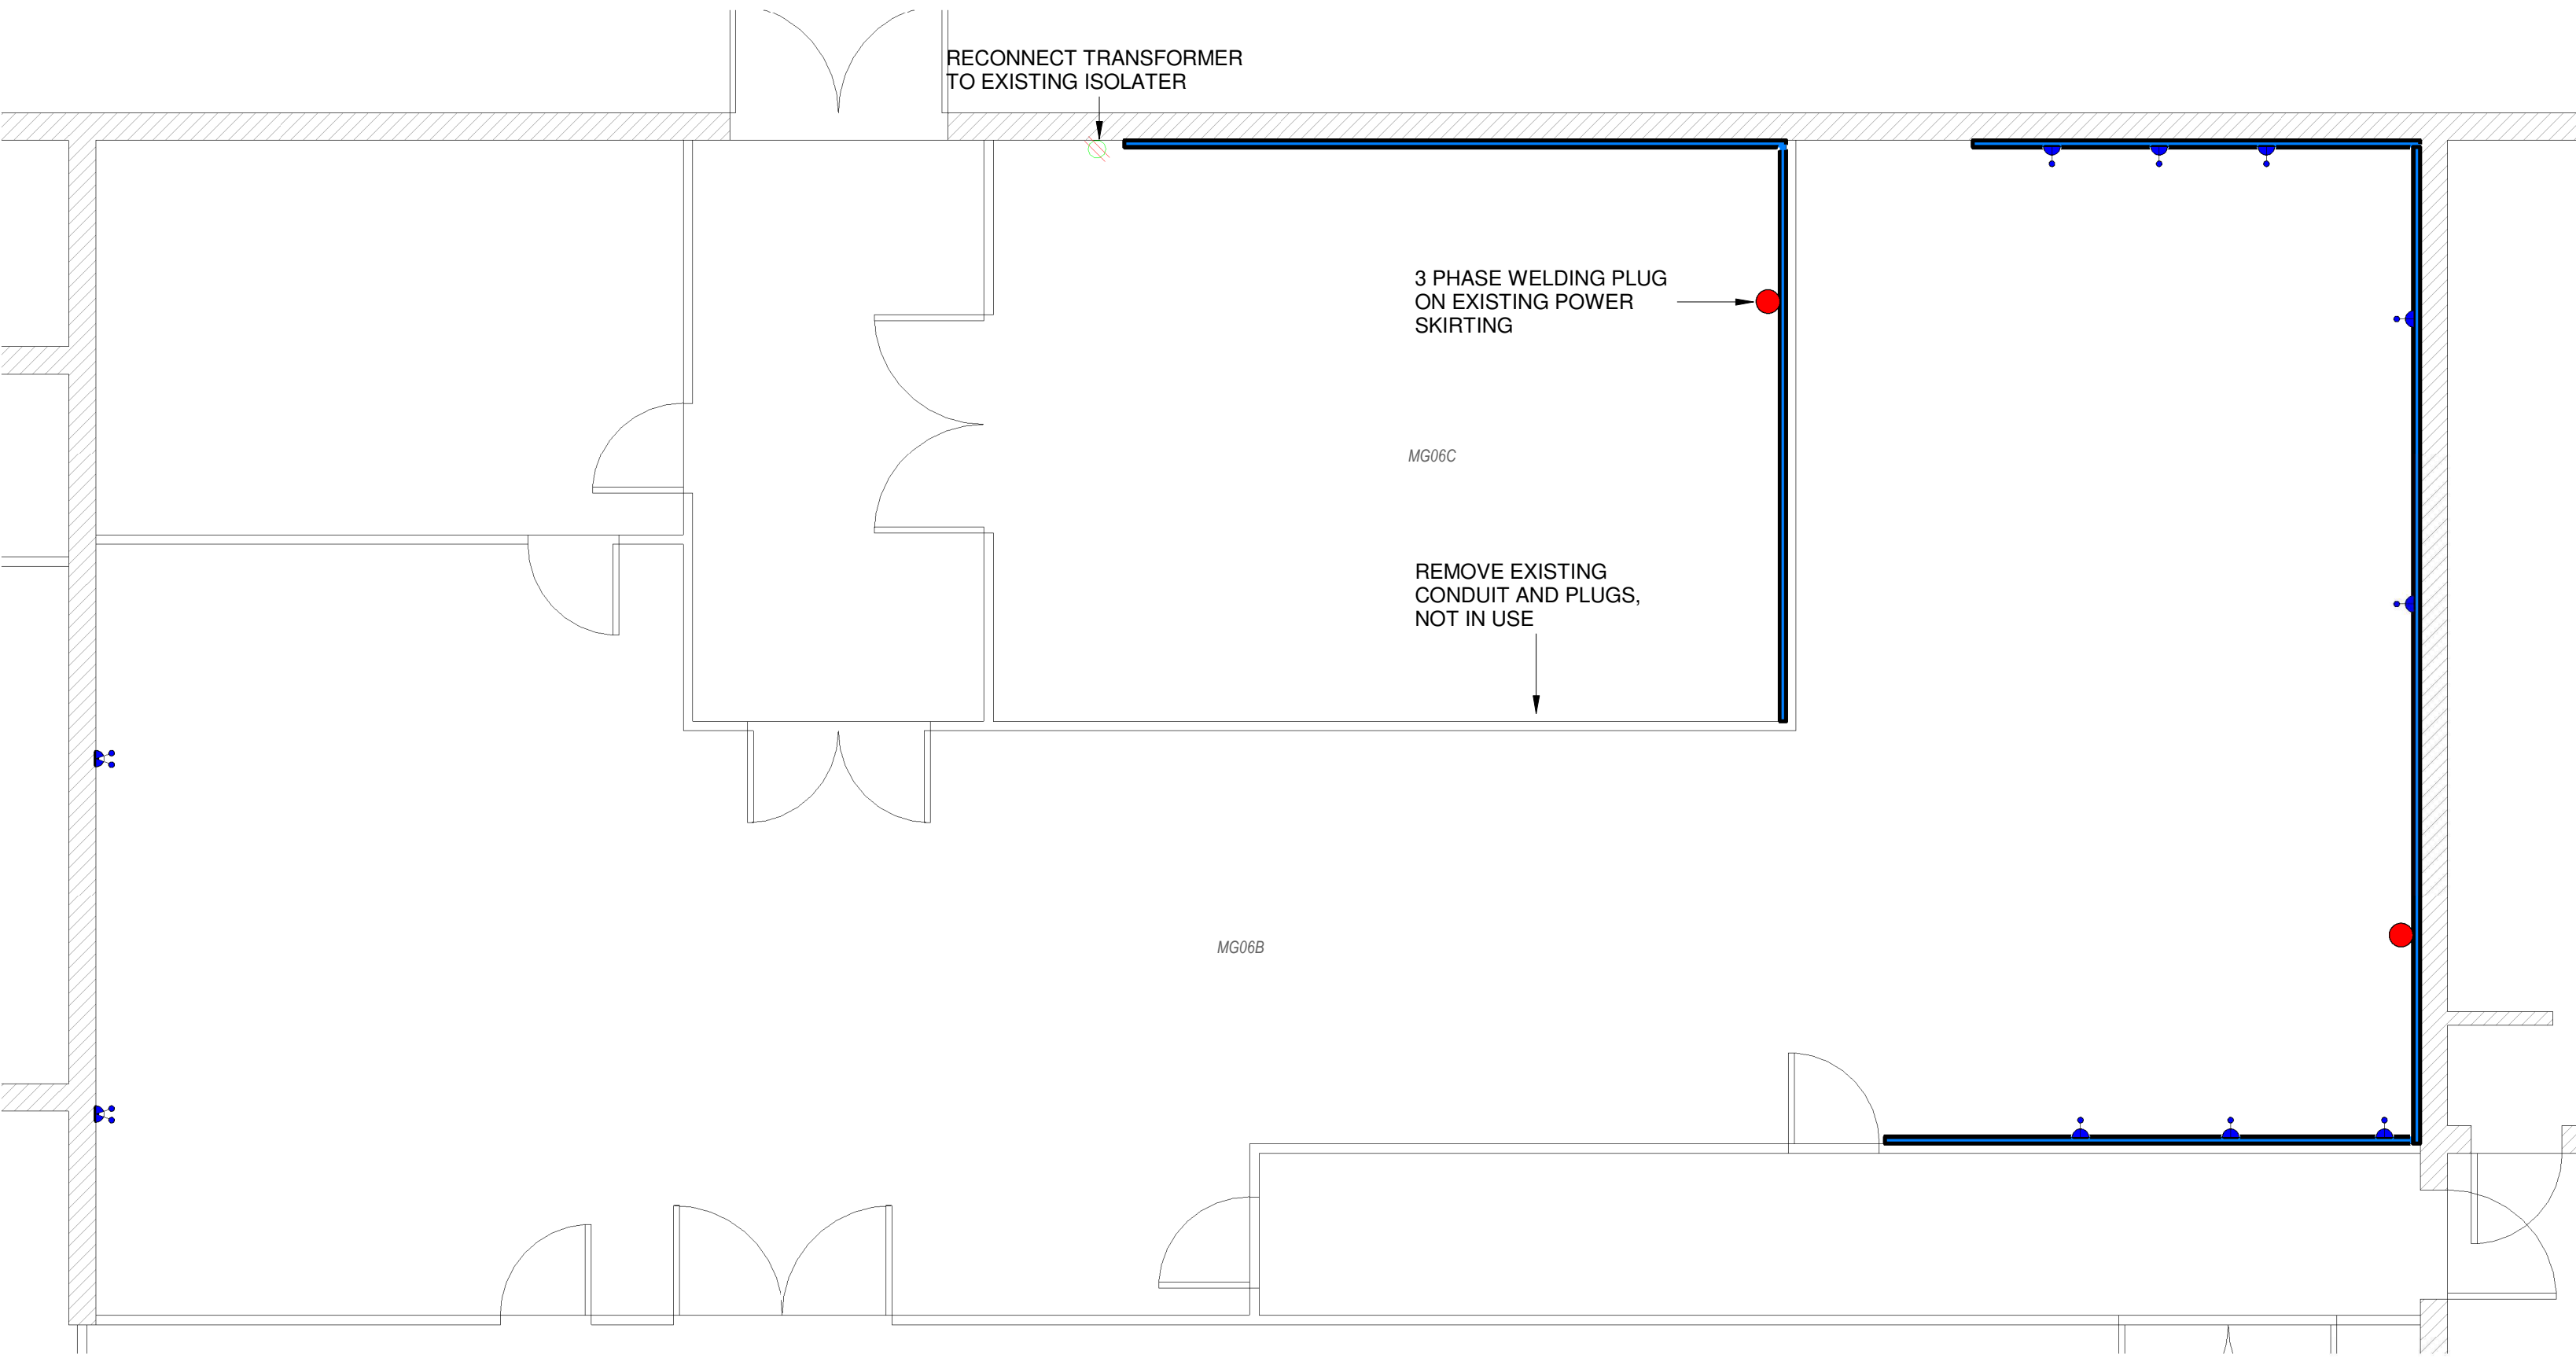


2 MG06B POWER LAYOUT
1 : 50

1200x600 LED PANEL

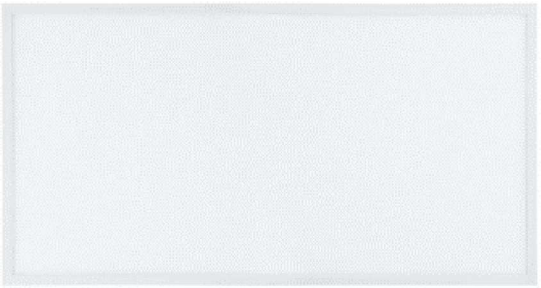

SWITCH SOCKET

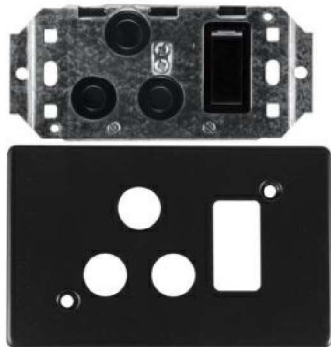

3 PHASE 32A CB



 



LIGHT SWITCH



BLACK DOUBLE SOCKET



1 TIER POWER SKIRTING

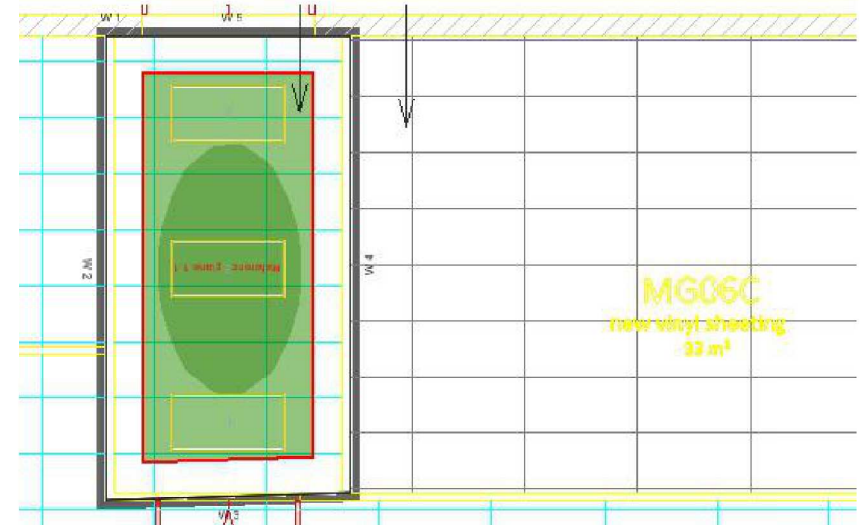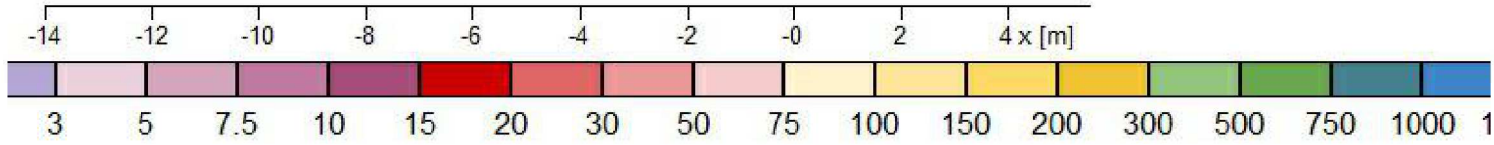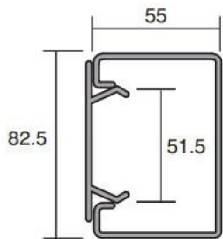

ISSUED FOR TENDER

APPROVED
NAME _____ SIGNATURE _____
PR. NO. _____ DATE _____

LEGEND		
ICON	DESCRIPTION	QTY
	50w LED PANEL 1200x600 6500K FRAME BLACK POWDER COATED	34
	LIGHT SWITCH	2
	3 WAY LIGHT SWITCH	3
	16A SWITCH SOCKET IN POWER SKIRTING	8
	BLACK DOUBLE SOCKET	2
	1 TIER POWER SKIRTING	
	3 PHASE 400V 32A + N + PE RCD	2
	SINGLE PHASE ISOLATOR	4

TENDER REVISIONS				
REV	DATE	DESCRIPTION	BY	
0A	2024-08-23	ISSUED FOR TENDER	DK	

CLIENT _____ ARCHITECT _____

SABS ADOQ
AFRICAN DYNAMIC QUALITY
ENGINEERING PROJECTS

CONSULTANT

ADOQ
AFRICAN DYNAMIC QUALITY
ENGINEERING PROJECTS

info@adqengineering.co.za
Tel: 012 030 0355

www.adqengineering.co.za

PROJECT DESCRIPTION
SABS PRETORIA

DRAWING TITLE
MG06B & MG06C LIGHTING & POWER LAYOUT

DATE 2024-02-06	DRAWN BY D. KRUGER
CHECKED BY A. JEEVA	DESIGNED BY A. JEEVA
DRAWING SIZE A1	SCALE As indicated
DRAWING NUMBER P23072-TN-ELE-201	REV 0A