




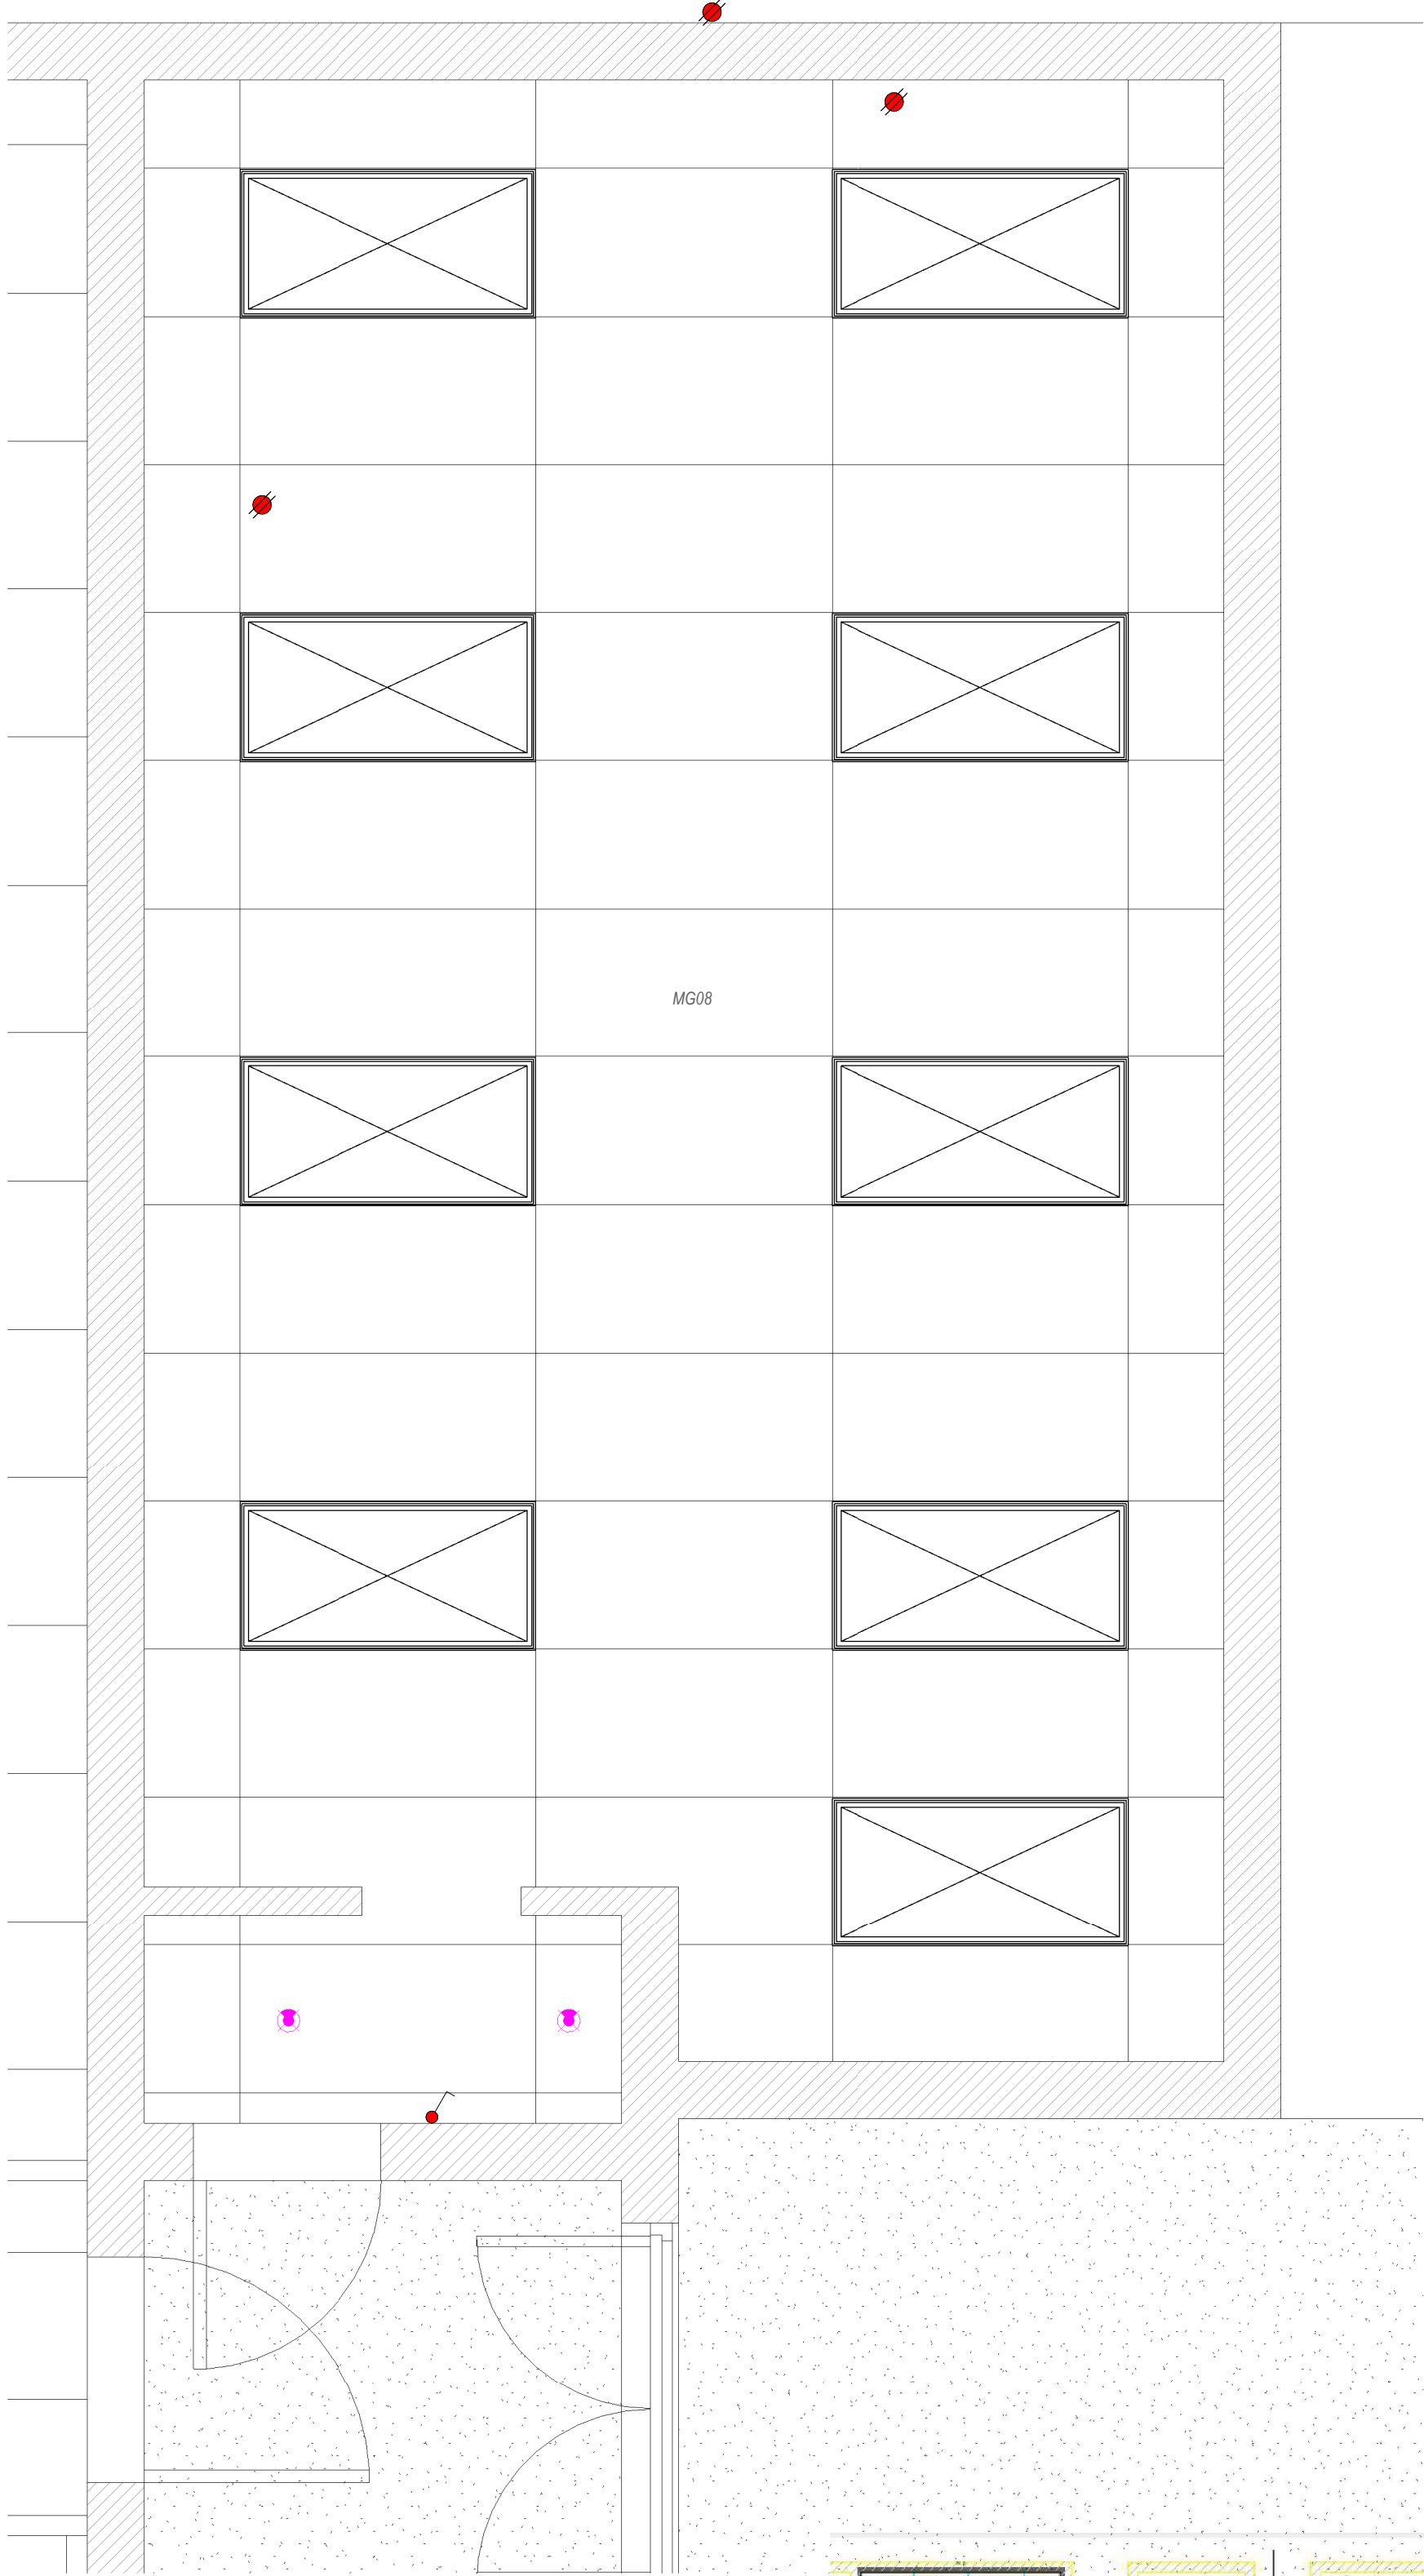

1 MG08 LIGHTING LAYOUT
1 : 25

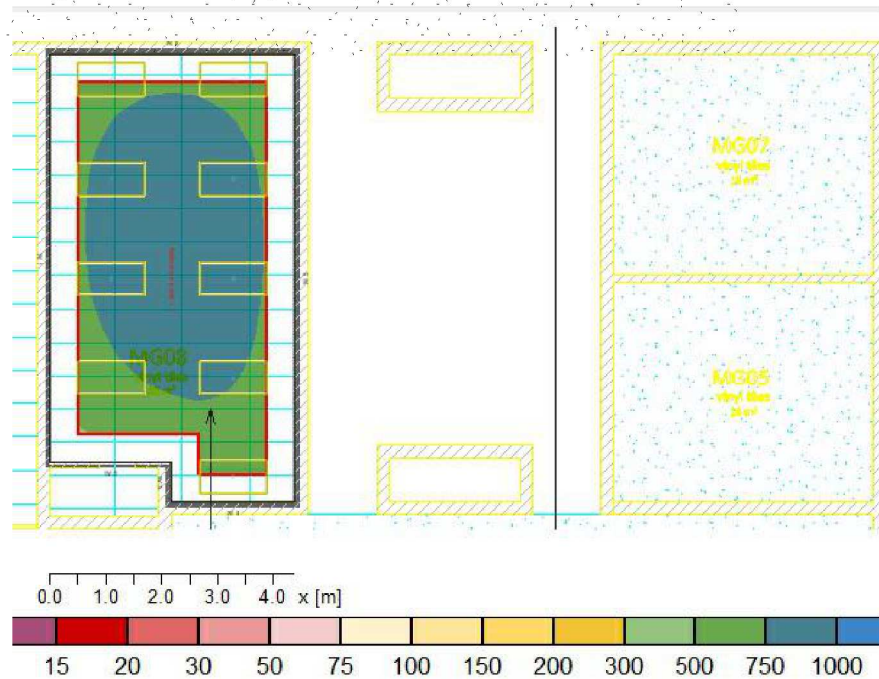

2 EG04 LIGHTING LAYOUT
1 : 25

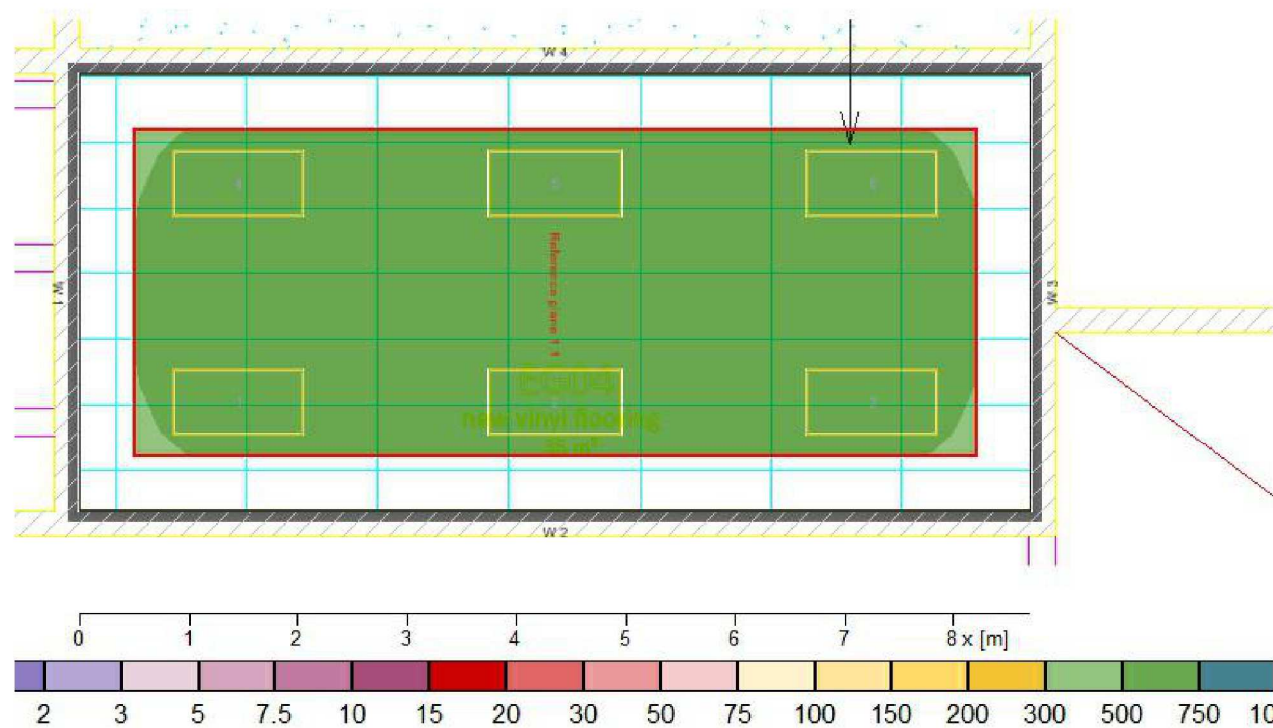

LIGHT SWITCH



1200x600 LED PANEL



ISSUED FOR TENDER

APPROVED
NAME _____ SIGNATURE _____
PR. NO. _____ DATE _____

LIGHTING LEGEND		
ICON	DESCRIPTION	QTY
	50w LED PANEL 1200x600 6500K FRAME BLACK POWDER COATED	15
	16w LED DOWNLIGHT BLACK POWDER COATED	2
	LIGHT SWITCH	1
	2 WAY LIGHT SWITCH	2
	SINGLE PHASE ISOLATOR	6

TENDER

REVISIONS			
REV	DATE	DESCRIPTION	BY
0A	2024-08-23	ISSUED FOR TENDER	DK

CLIENT ARCHITECT



CONSULTANT



info@adqengineering.co.za
Tel: 012 030 0355
www.adqengineering.co.za

PROJECT DESCRIPTION

SABS PRETORIA

DRAWING TITLE

MG08 & EG04 LIGHTING LAYOUT

DATE 2024-02-06 DRAWN BY D. KRUGER

CHECKED BY A. JEEVA DESIGNED BY A. JEEVA

DRAWING SIZE A1 SCALE As indicated

DRAWING NUMBER P23072-TN-ELE-202 REV 0A