




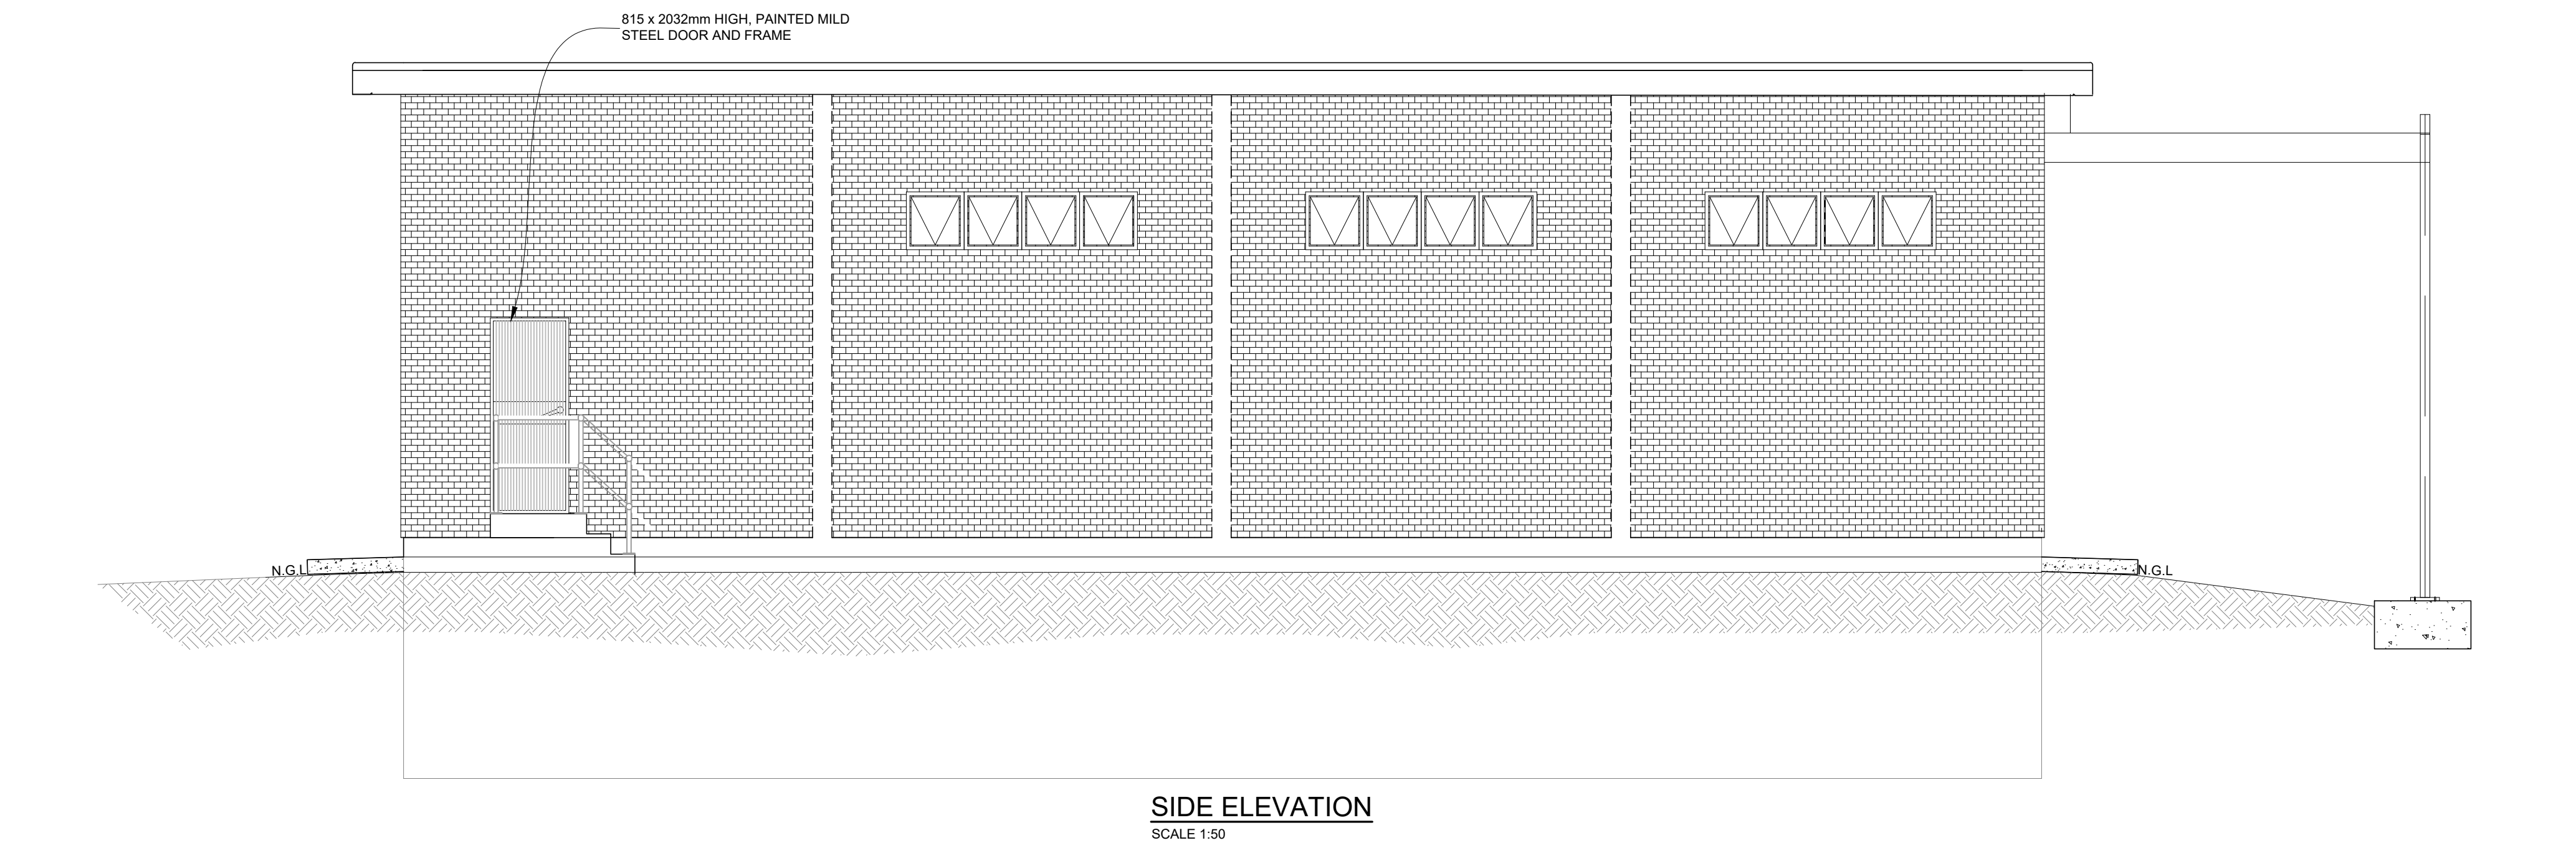


SIDE ELEVATION
SCALE 1:50

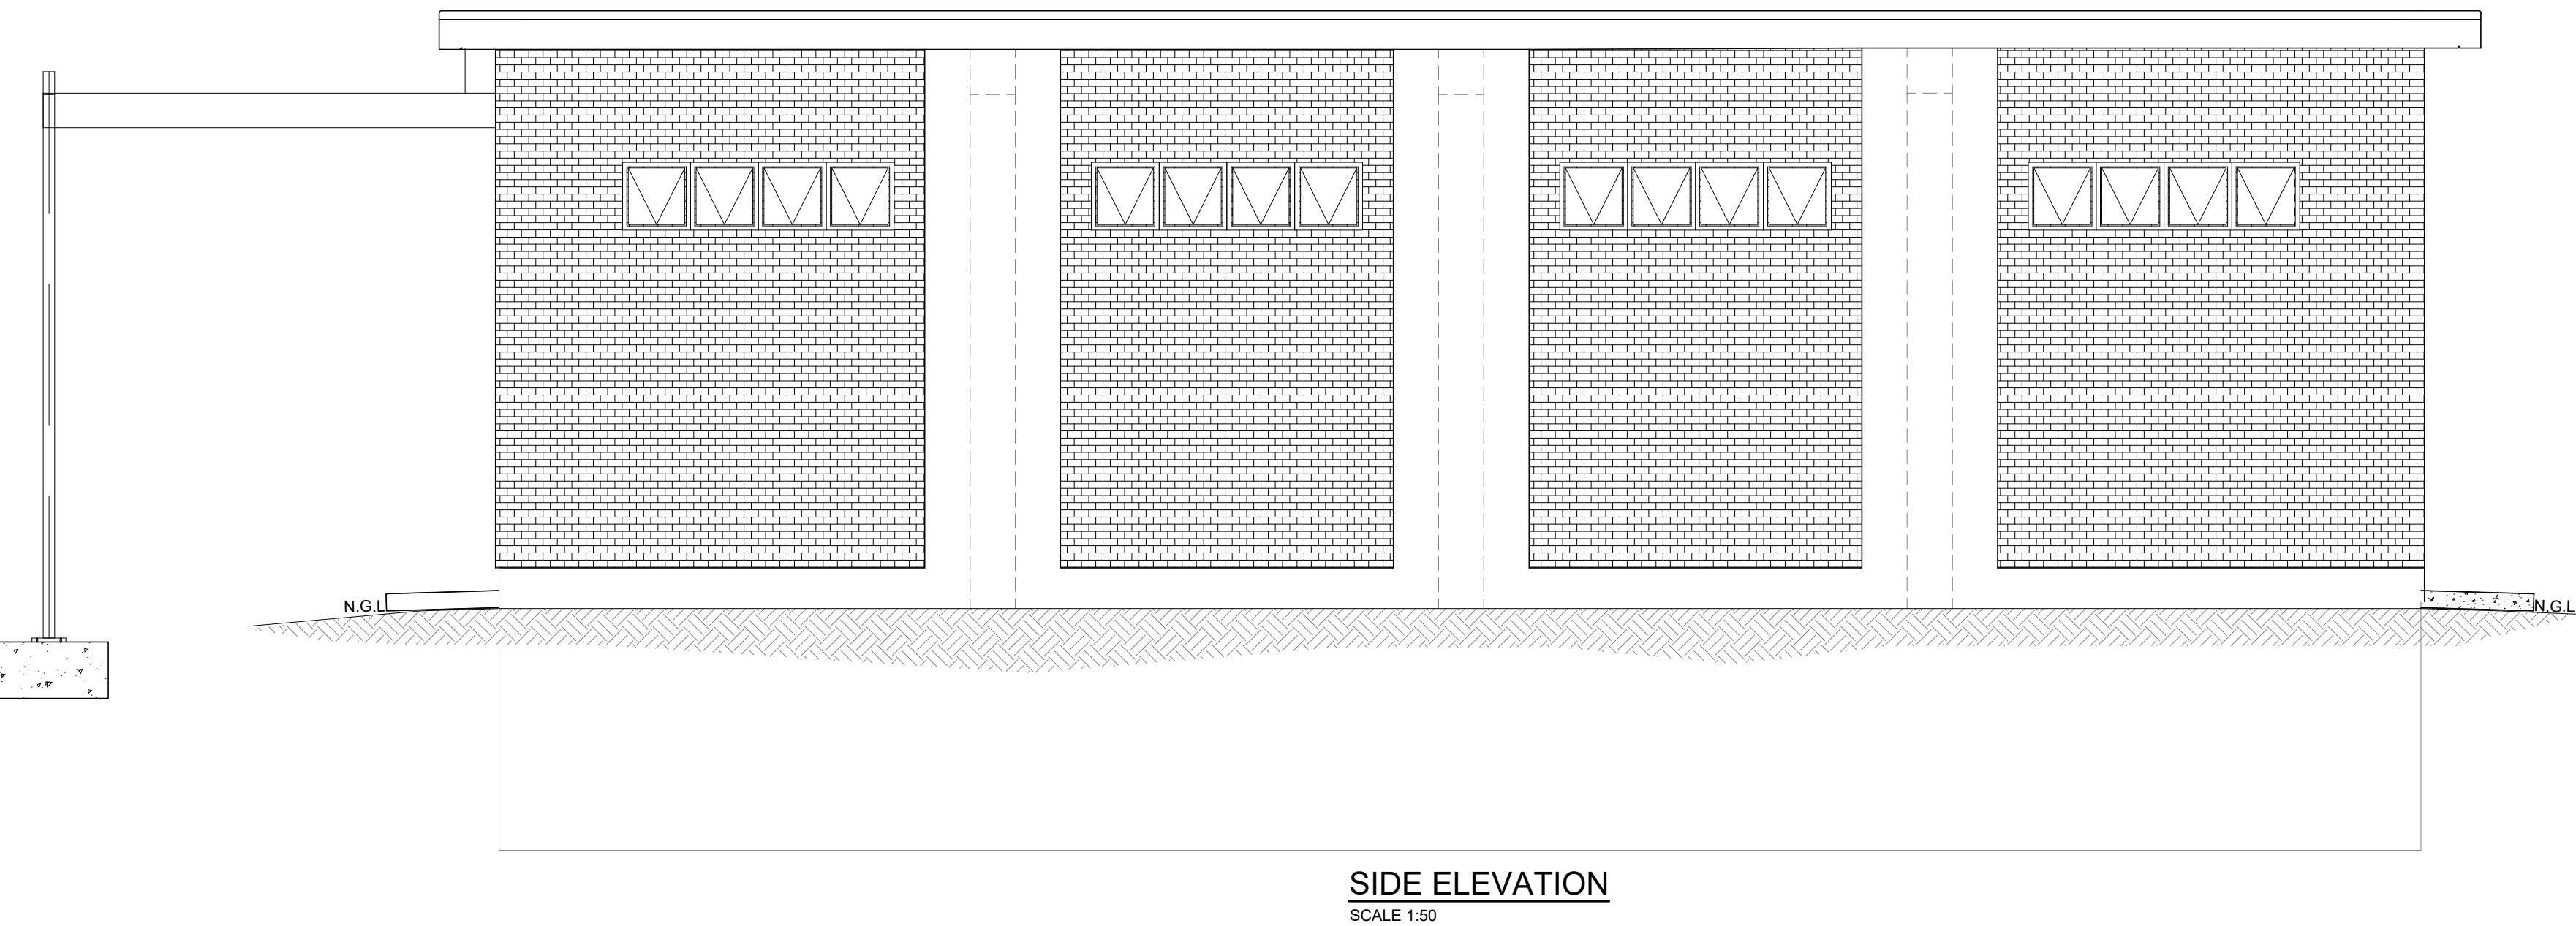

SIDE ELEVATION
SCALE 1:50

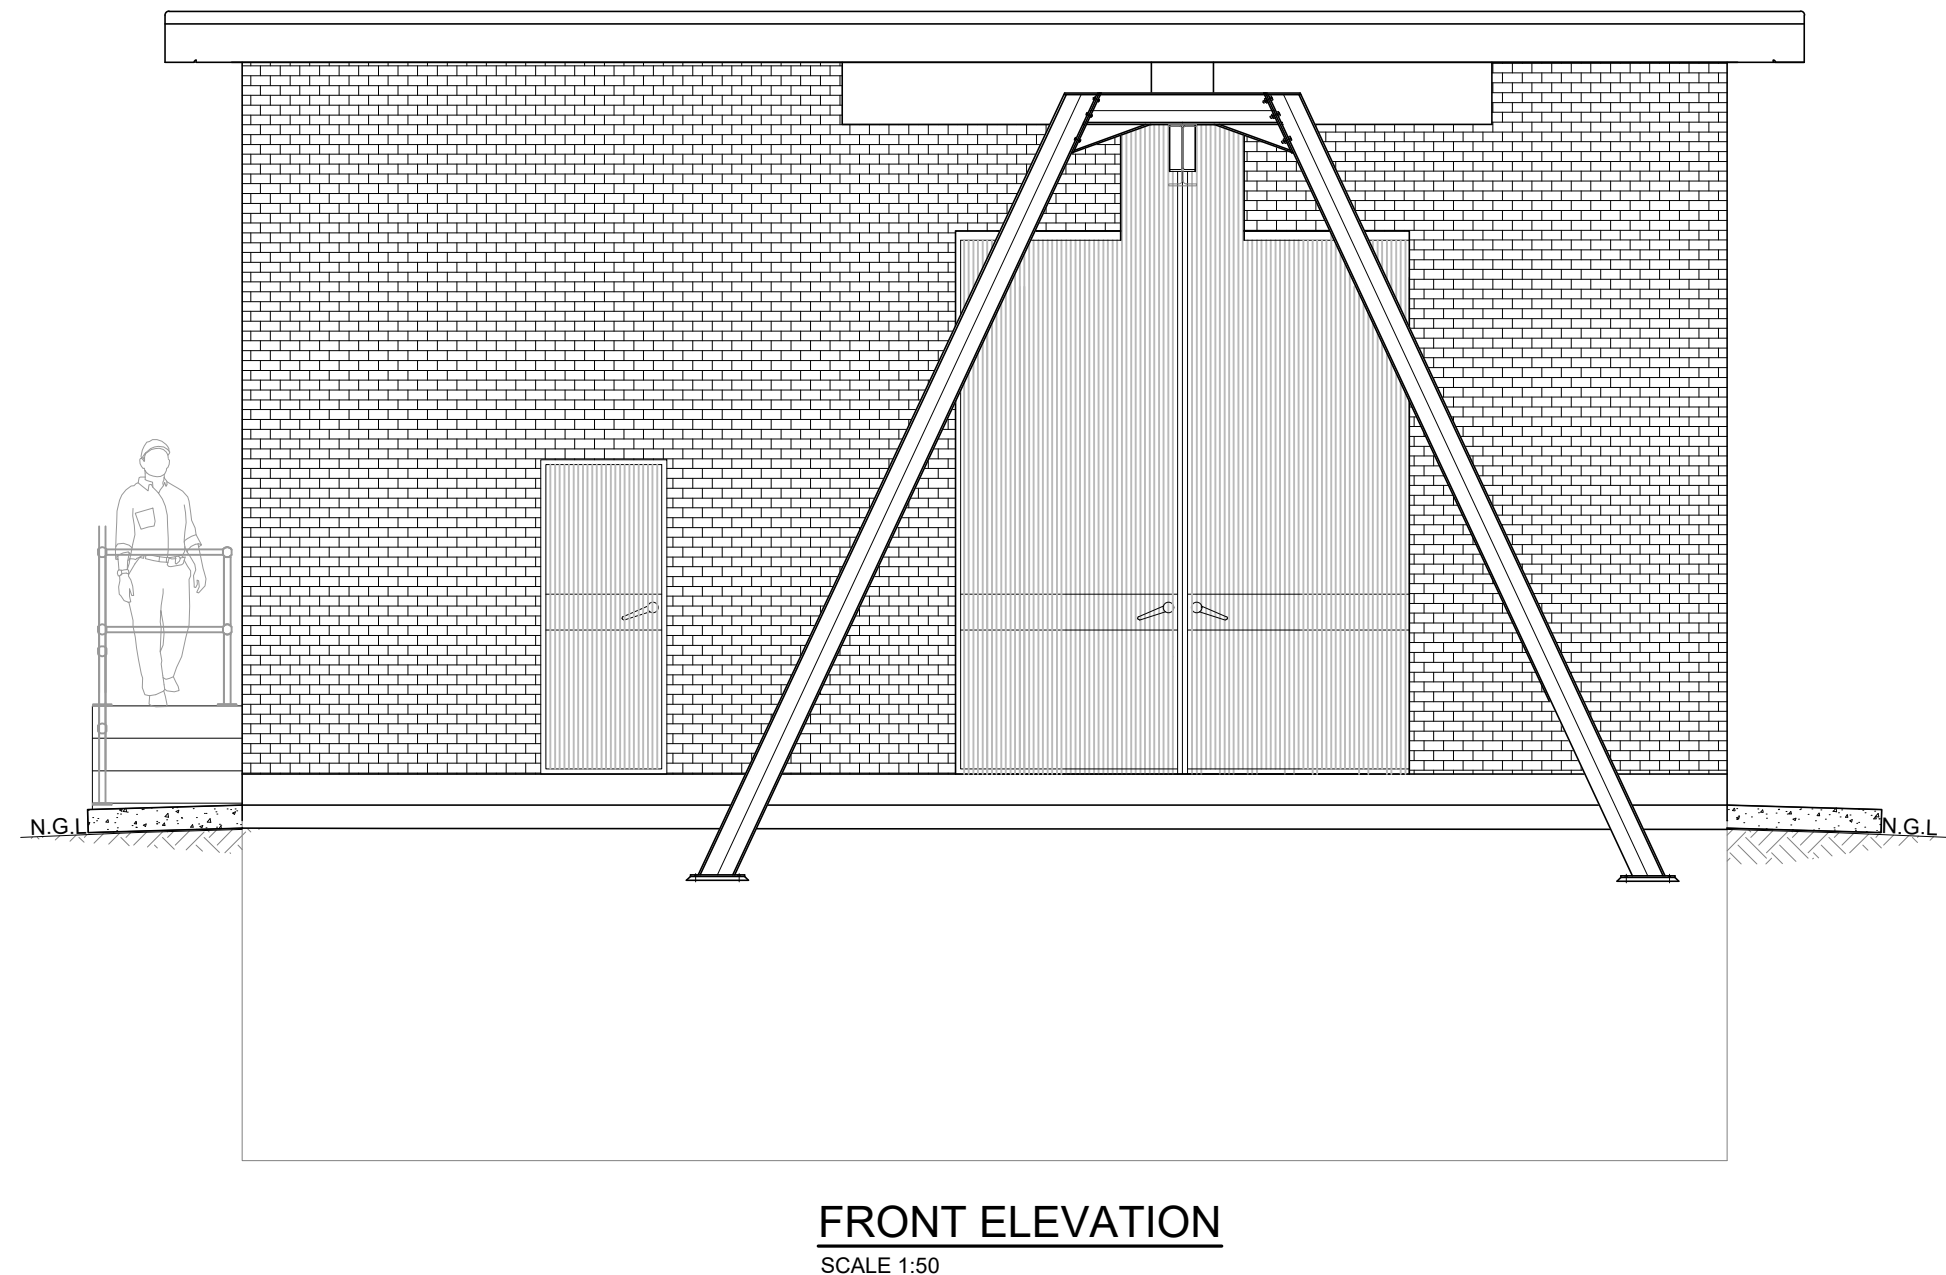

FRONT ELEVATION
SCALE 1:50

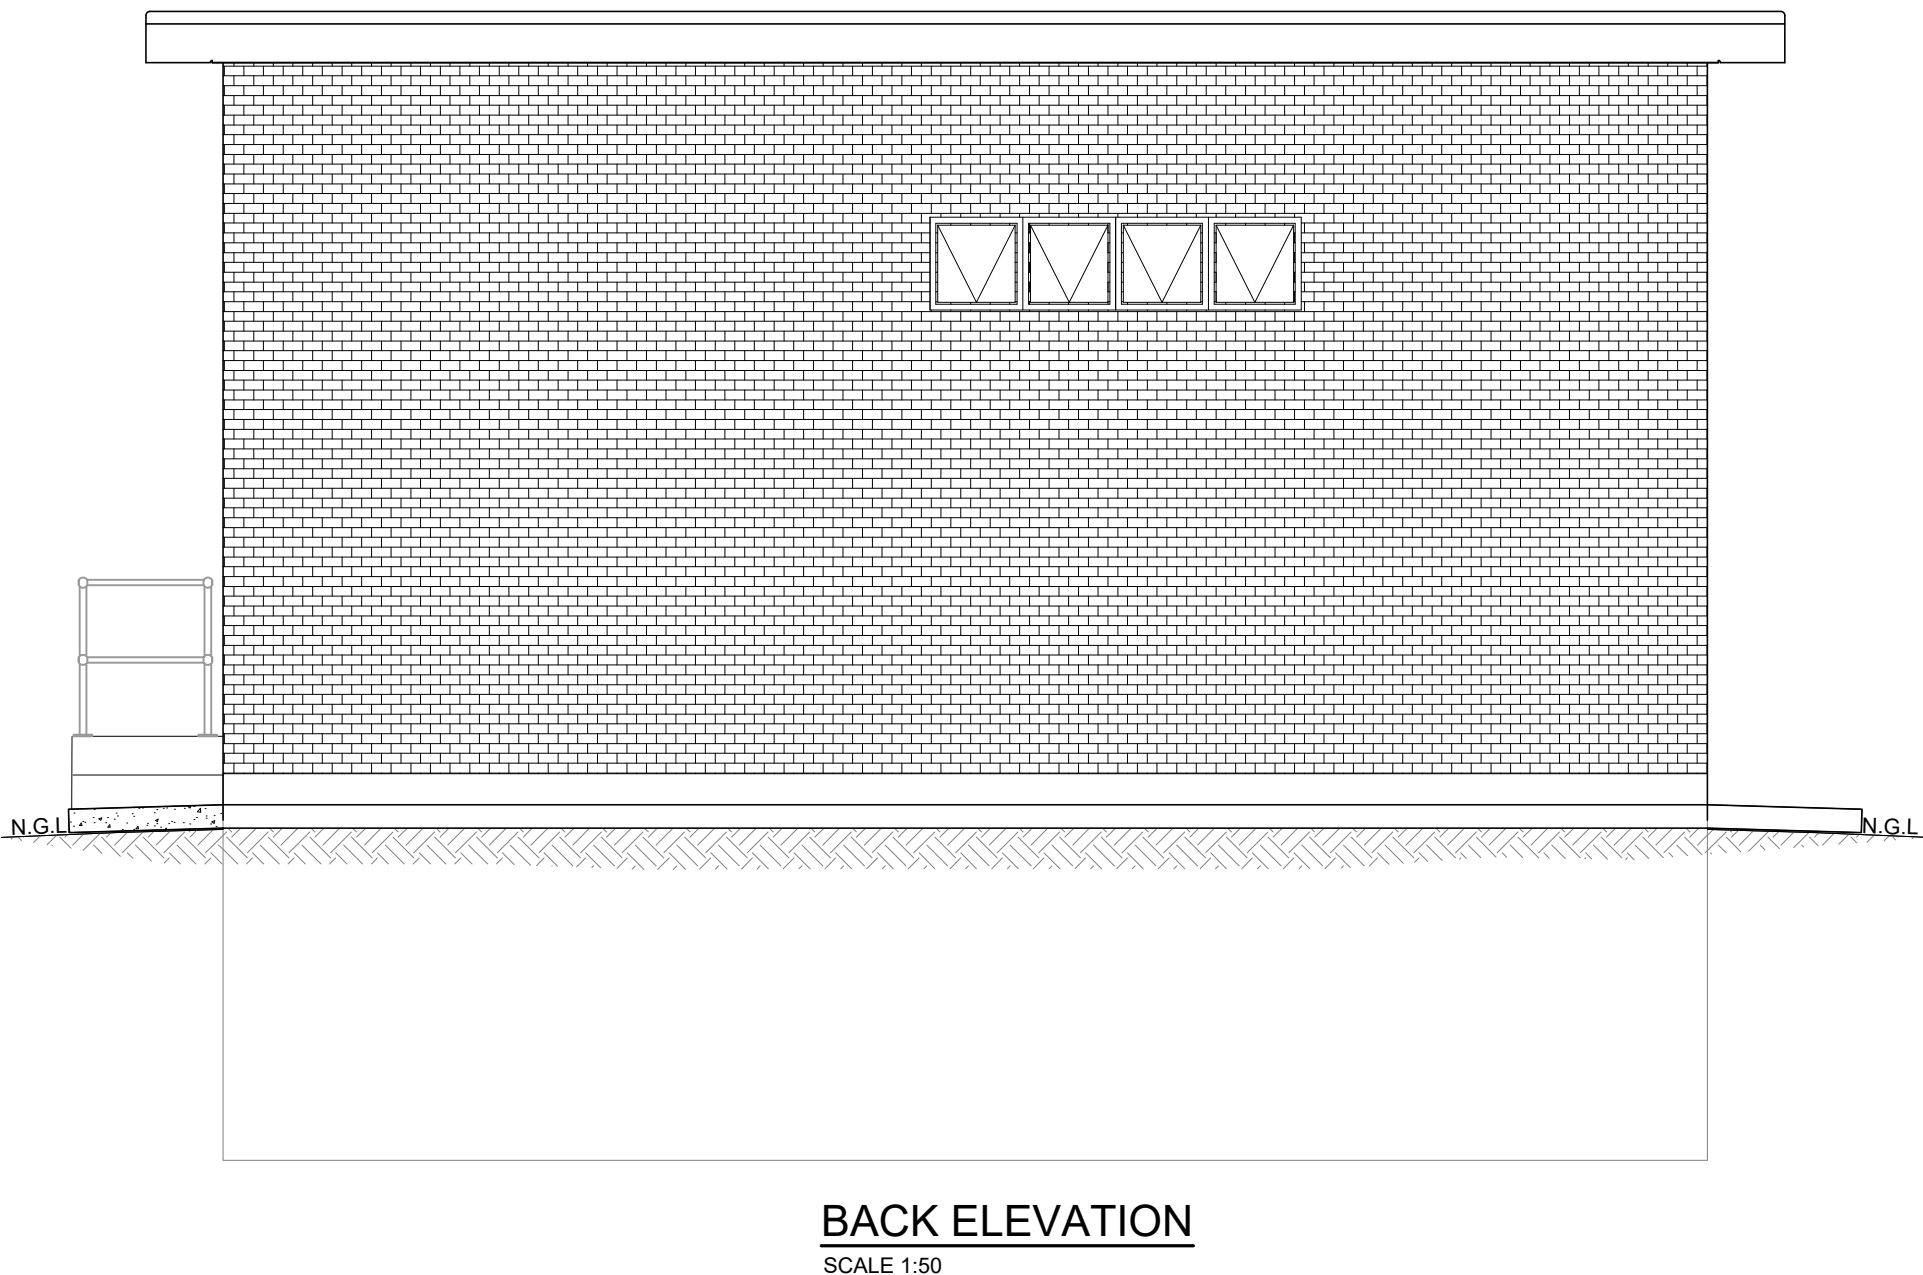

BACK ELEVATION
SCALE 1:50

RAW WATER PUMP STATION ELEVATIONS
SCALE 1:50

NOTES:

FOR TENDER PURPOSES

COPYRIGHT RESERVED

Rev. Her.	Description Beskrywing	Date Datum	By Deur
-----------	------------------------	------------	---------

AMENDMENTS/WYSIGING

SERVICE	DIENS
---------	-------

WATER

DESIGNED/ONTWERP	J. LUCKHOFF
DRAWN/GETEKEN	I.NEL
CAD FILE NAME/CAD LÊER NAAM	N3110W6101RA-104RA-M6101RA-301RA.dwg
CHECKED/NAGESIEN	W.J. STRYDOM (jnr)
APPROVED/GOEDGEKEUR	W.J. STRYDOM (jnr)

ENDECON
UBUNTU (PTY) LTD
ENGINEERING CONSULTANTS
P.O. BOX 10345
NELSPRUIT
1200
Tel: (013) 755 1190
Fax: (013) 755 4904

CLIENT KLIËNT



Nkangala District Municipality

PROJECT PROJEK

**LOSKOP REGIONAL BULK
WATER SUPPLY SCHEME:
WORK PACKAGE 1**

TITLE TITEL

**RAW WATER BOOSTER PUMP
STATION : 1 : ELEVATIONS**

DATE/DATUM	DECEMBER 2021
SCALE/SKAAL	1:50

SCALE REF.	SKAAL VERWYS.
4 2 0 2 4 3 1 1 3	

CONSULTANT DWG. NO.	KONSULTANT TEK. NR.
N/3110/W/6/103	

CLIENT DWG. NO.	KLIËNT TEK. NO.
-----------------	-----------------