


REVISIONS

2014-02-08 REV.1
ISSUE FOR CONSTRUCTION (TITLE REVISED)
2014-02-23 REV.2
SEE ROOF OVERHANG DETAIL

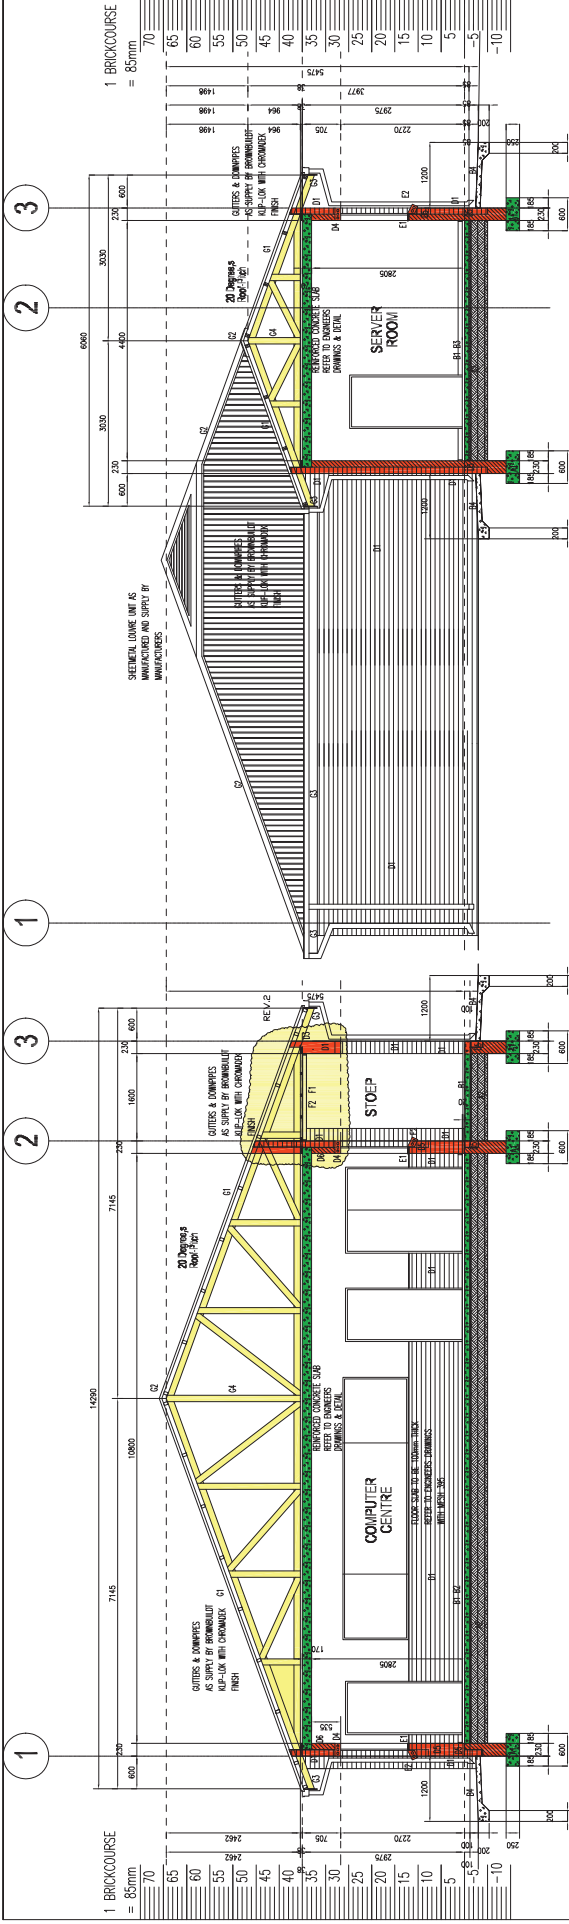


SECTION A-A:

Scale 1:50.

SECTION B-B:

Scale 1:50.

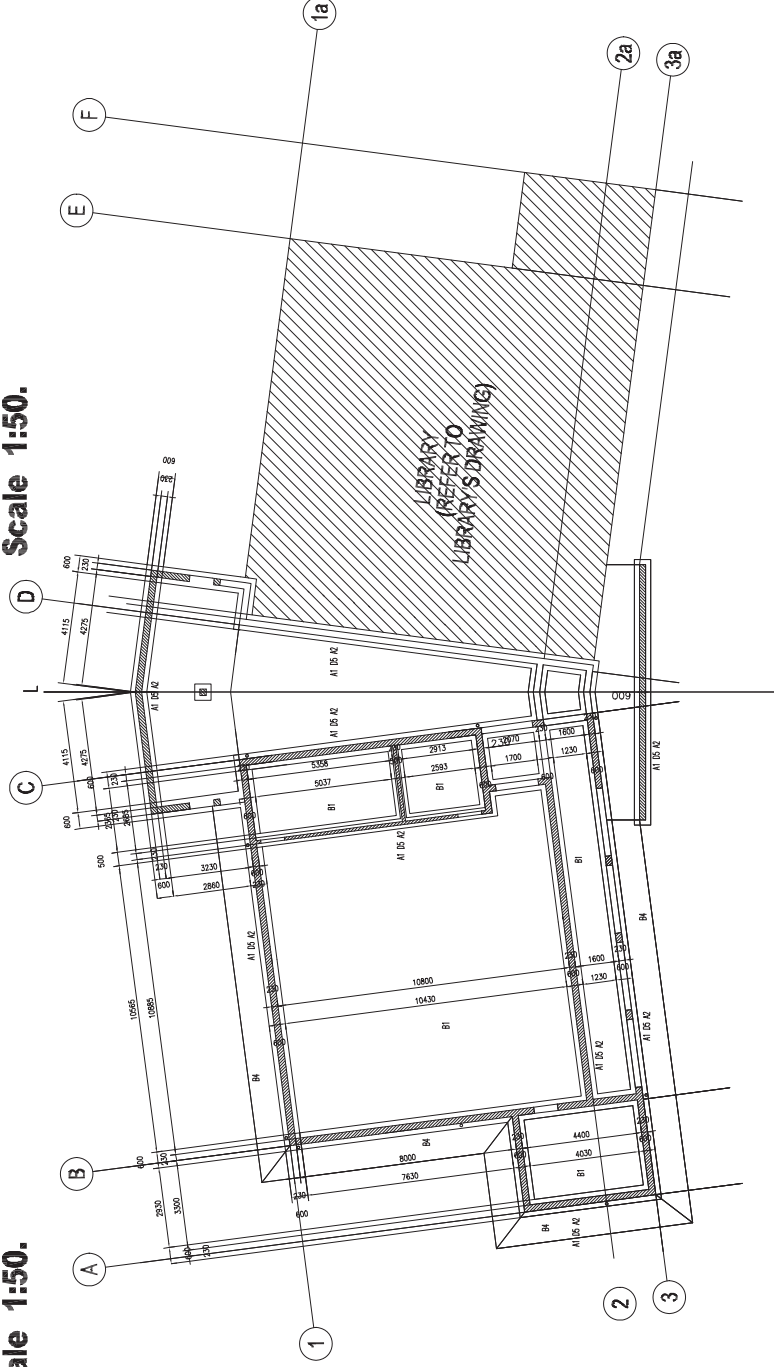

FOUNDATION PLAN:

Scale 1:100.

DRAWINGS NOT TO BE SCALED
CLIENT DEPARTMENT: LIMPOPO DOE



IMPLEMENTING AGENT: IDT LIMPOCO



PRINCIPAL AGENT



ARCHITECTURAL CONSULTANT



PROJECT DESCRIPTION

PROJECT LOCATION	NEW, UPGRADES, ADDITIONS & REHABILITATION OF SCHOOLS PROGRAMME IN LIMPOPO PROVINCE 2013-14	DRAWING DESCRIPTION
------------------	--	---------------------

COMPUTOR CENTRE

DRAWING SCALE

AS SHOWN

239-W003C1 REV.2

DRAWINGS NOT TO BE SCALED
CLIENT DEPARTMENT: LIMPOPO DOE




M-Design Architectural Consultants
 MOT Commercial Support Services CE to M-Design
 Registration Number: 200007377423
 211, Agfing Street, Tampere, 06500
 P.O. Box 337, Tampere
 Tel: 09 333 3333 Fax: 09 333 3333 Mobile: 09 2 448 3999
 E-Mail: m-design@comnet.fi

PROJECT DESCRIPTION
**NEW, UPGRADES, ADDITIONS
& REHABILITATION OF SCHOOLS
PROGRAMME IN
LIMPOPO PROVINCE 2013-14**

DRAWING DESCRIPTION
COMPUTER CENTRE

DRAWING SCALE
AS SHOWN
DRAWING NUMBER

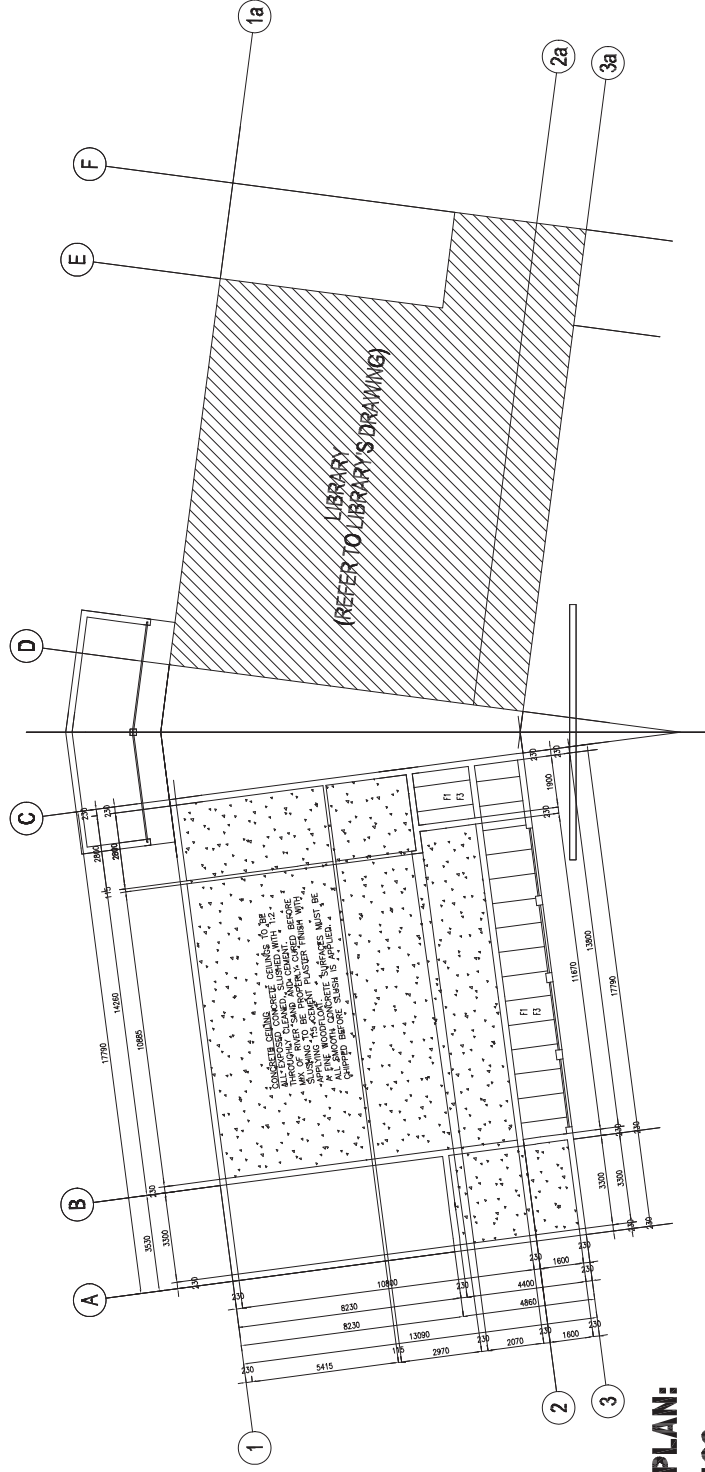

CEILING PLAN:
Scale 1:100.



education
Department of Education
REPUBLIC OF SOUTH AFRICA

IMPLMENTING AGENT: IDT LIMPOPO

QS **PRO**
Measurable Precision
QUANTITY SURVEYORS
ARCHITECTURAL CONSULTANT

M-Design
ARCHITECTURAL CONSULTANTS
MDT Construction Support Services CO in M-Design
Registration Number: 000037717423
Suite C1, Aquatic Street, Traralgon, 3845
P.O. Box 1914, Traralgon, 3845
Tel: (011) 357 5009 / Fax: (011) 354 7050 Mobile: 062 446 3399
E-Mail: m-design@comcast.au or 24

AS SHOWN



ELECTRICAL LEGEND	
	CEILING LIGHT FIXTURE
	RECESSED CEILING LIGHT FIXTURE
	RECESSED DROP CEILING LIGHT FIXTURE
	DOUBLE WALL LIGHT FIXTURE
	FLUORESCENT LIGHT FIXTURE
	SWITCH
	OUTLET
	TELEPHONE PORT
	120V AC OUTLET
	240V AC OUTLET
	LIGHT SWITCH

DRAWINGS NOT TO BE SCALED
CLIENT DEPARTMENT: LIMPOPO DOE




PROJECT DESCRIPTION
NEW, UPGRADES, ADDITIONS
& REHABILITATION OF SCHOOLS
PROGRAMME IN
LIMPOPO PROVINCE 2013-14


DRAWING DESCRIPTION
COMPUTER CENTRE

DRAWING SCALE
AS SHOWN

DRAWING NUMBER
239-W006C1 REV.1

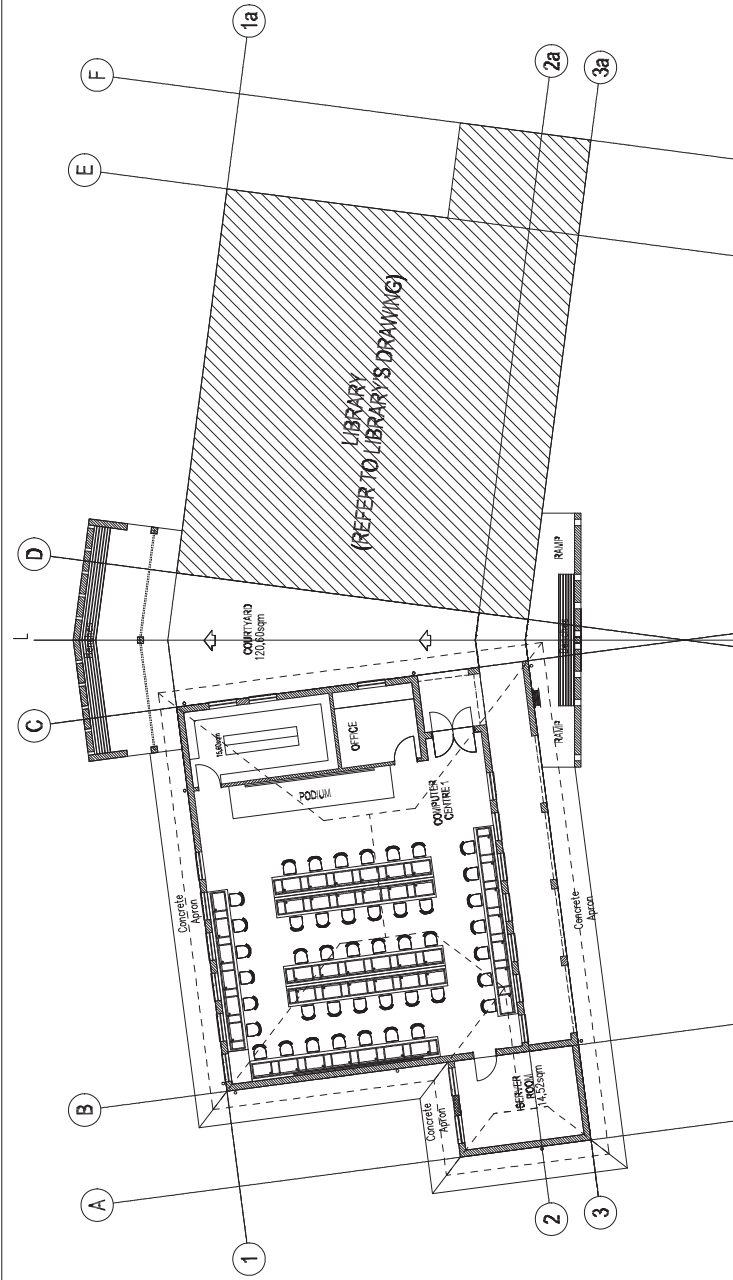

**GROUND FLOOR PLAN:
WATER RETICULATION:
1 x COMPUTER CENTRE:
Scale 1:100.**

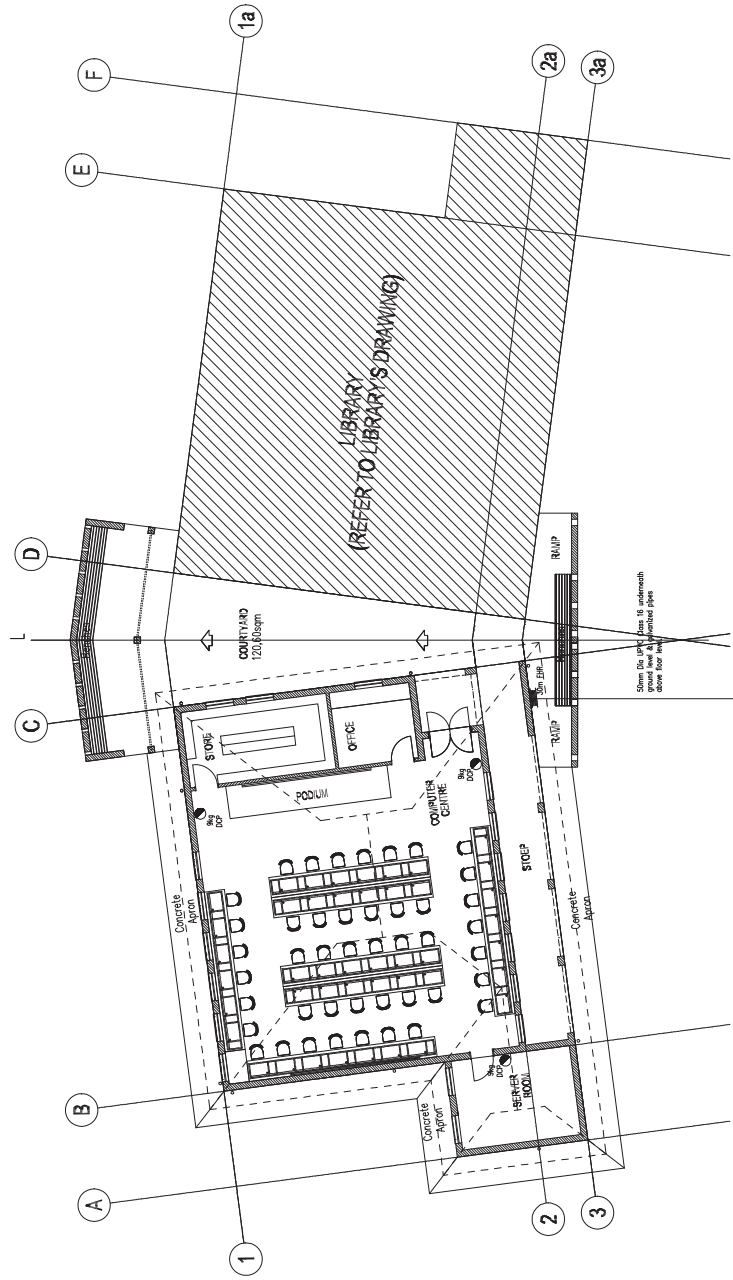

**GROUND FLOOR PLAN:
FIRE EQUIPMENT LAYOUT:
1 x COMPUTER CENTRE:
Scale 1:100.**

NOTE:
ALL FIRE EQUIP. SIZES: ACCORDING
TO SANS STANDARDS 1041:1:2001





239-W003S REV.2

DRAWINGS NOT TO BE SCALED
CLIENT DEPARTMENT: LIMPOPO DOE



PROJECT DESCRIPTION
NEW, UPGRADES, ADDITIONS
& REHABILITATION OF SCHOOLS
PROGRAMME IN
LIMPOPO PROVINCE 2013-14

DRAWING DESCRIPTION


SCIENCE LAB

DRAWING SCALE


AS SHOWN

DRAWING NUMBER


239-W004S REV.1

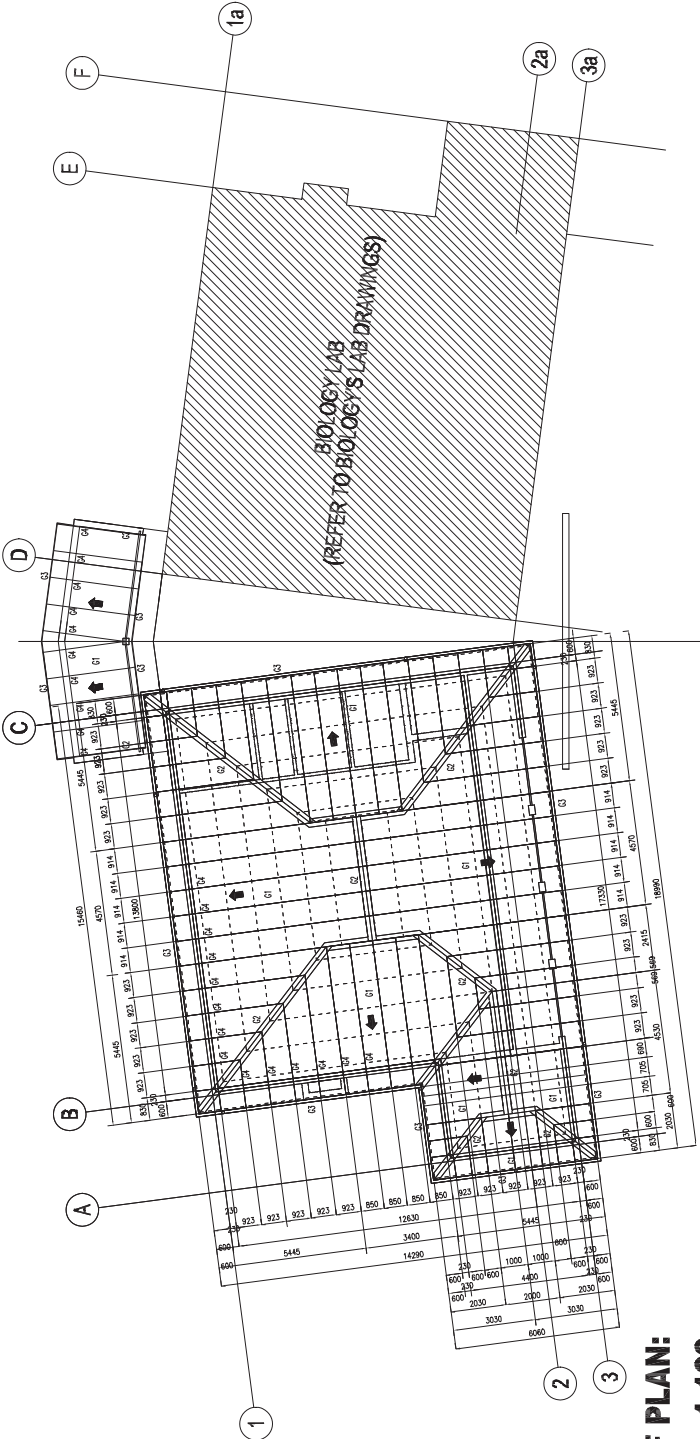


ROOF PLAN:
Scale 1:100.

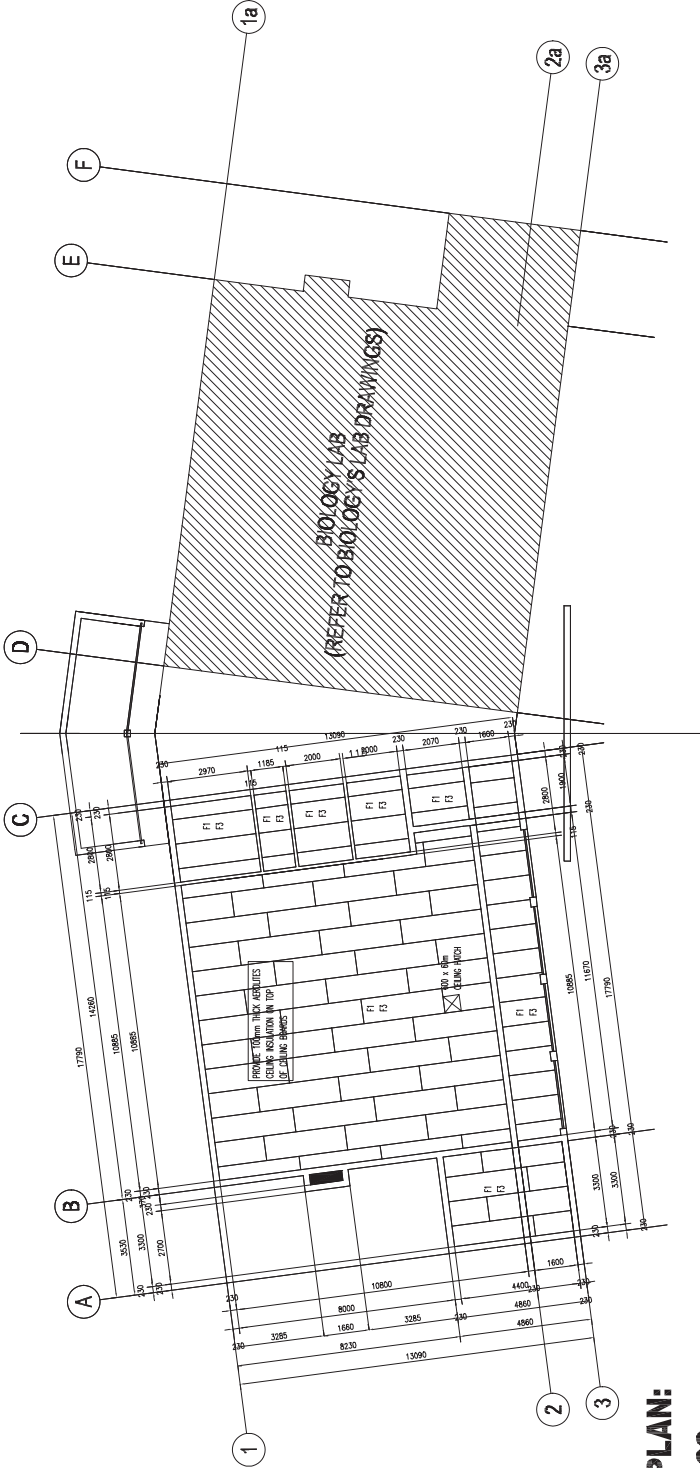

CEILING PLAN:
Scale 1:100.

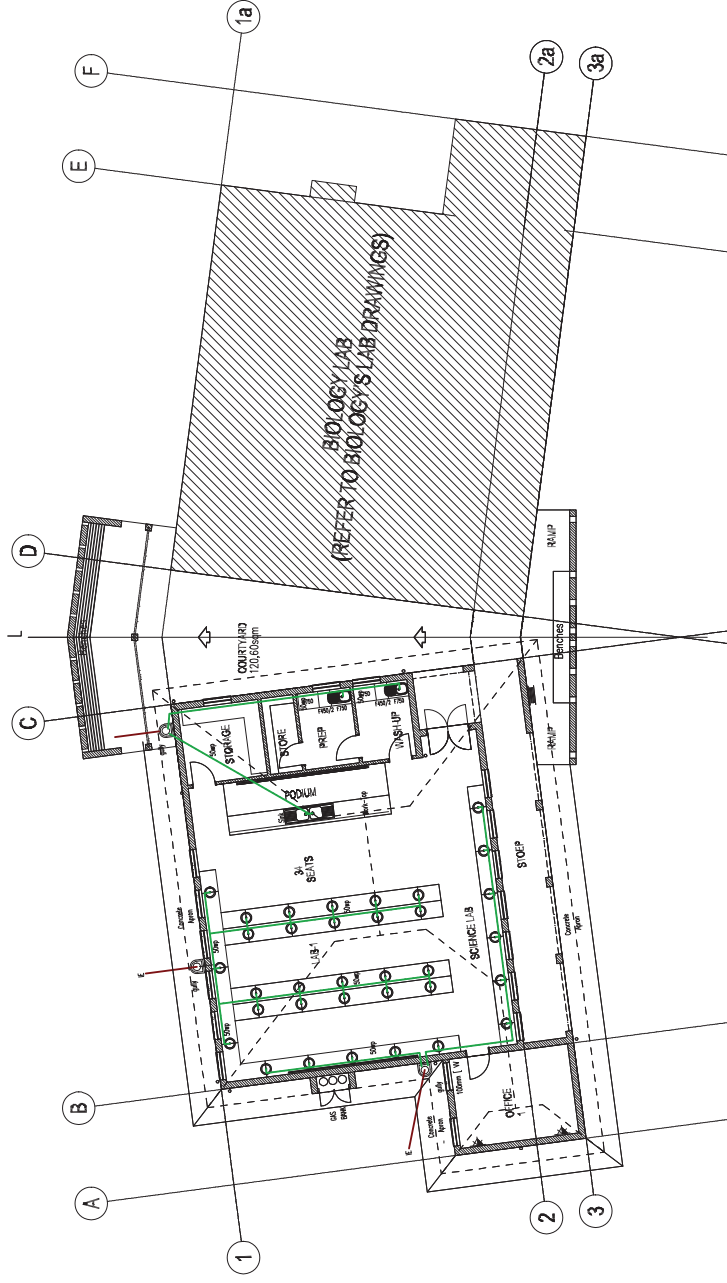

**GROUND FLOOR PLAN:
SEWER DRAINAGE LAYOUT:
SCIENCE LABORATORY:
Scale 1:100.**

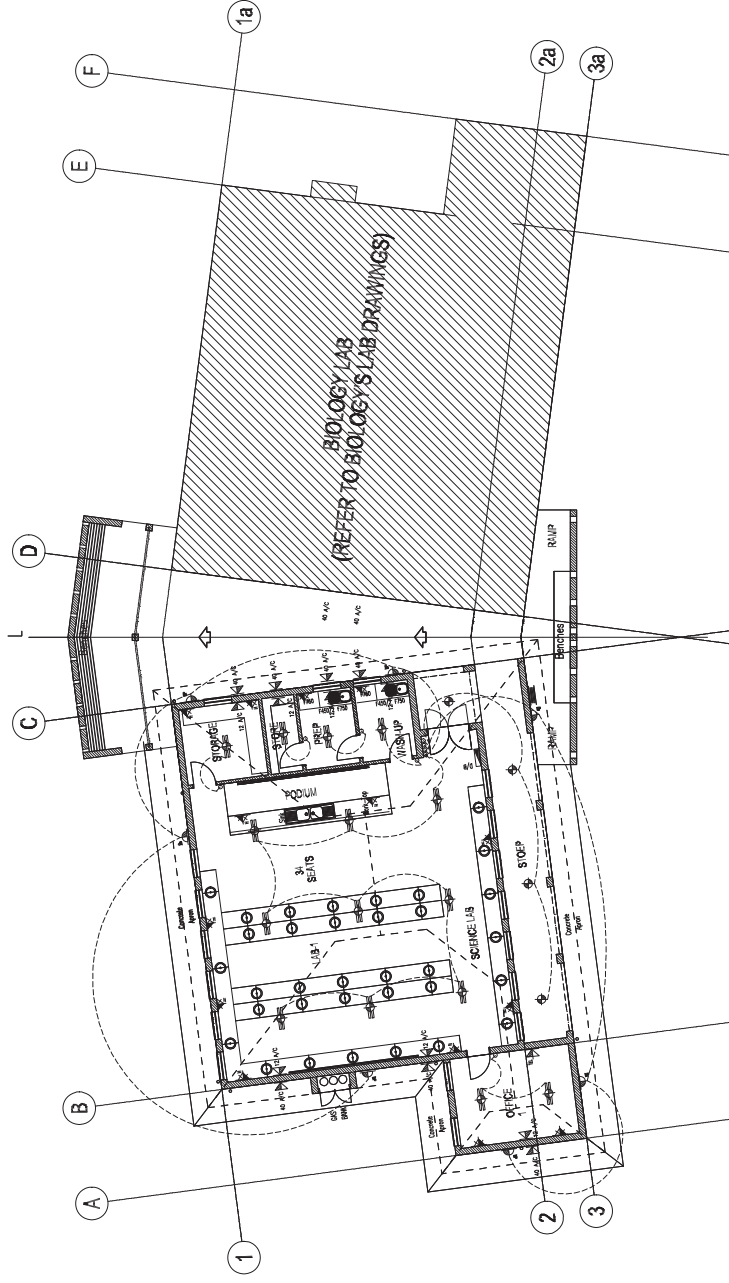

**GROUND FLOOR PLAN:
ELECTRICAL LAYOUT:
SCIENCE LABORATORY:
Scale 1:100.**

DRAWINGS NOT TO BE SCALED
CLIENT DEPARTMENT: LIMPOPO



PROJECT DESCRIPTION
NEW, UPGRADES, ADDITIONS
& REHABILITATION OF SCHOOLS
PROGRAMME IN
LIMPOPO PROVINCE 2013-14

DRAWING DESCRIPTION
SCIENCE LAB
DRAWING SCALE
AS SHOWN
DRAWING NUMBER
239-W005S REV.1

DRAWINGS NOT TO BE SCALED
CLIENT DEPARTMENT: LIMPOPO DOE




PROJECT DESCRIPTION
NEW UPGRADES, ADDITIONS
& REHABILITATION OF SCHOOLS
PROGRAMME IN
LIMPOPO PROVINCE 2013-14


DRAWING DESCRIPTION
SCIENCE LAB

DRAWING SCALE
AS SHOWN

DRAWING NUMBER
239-W006S REV.1

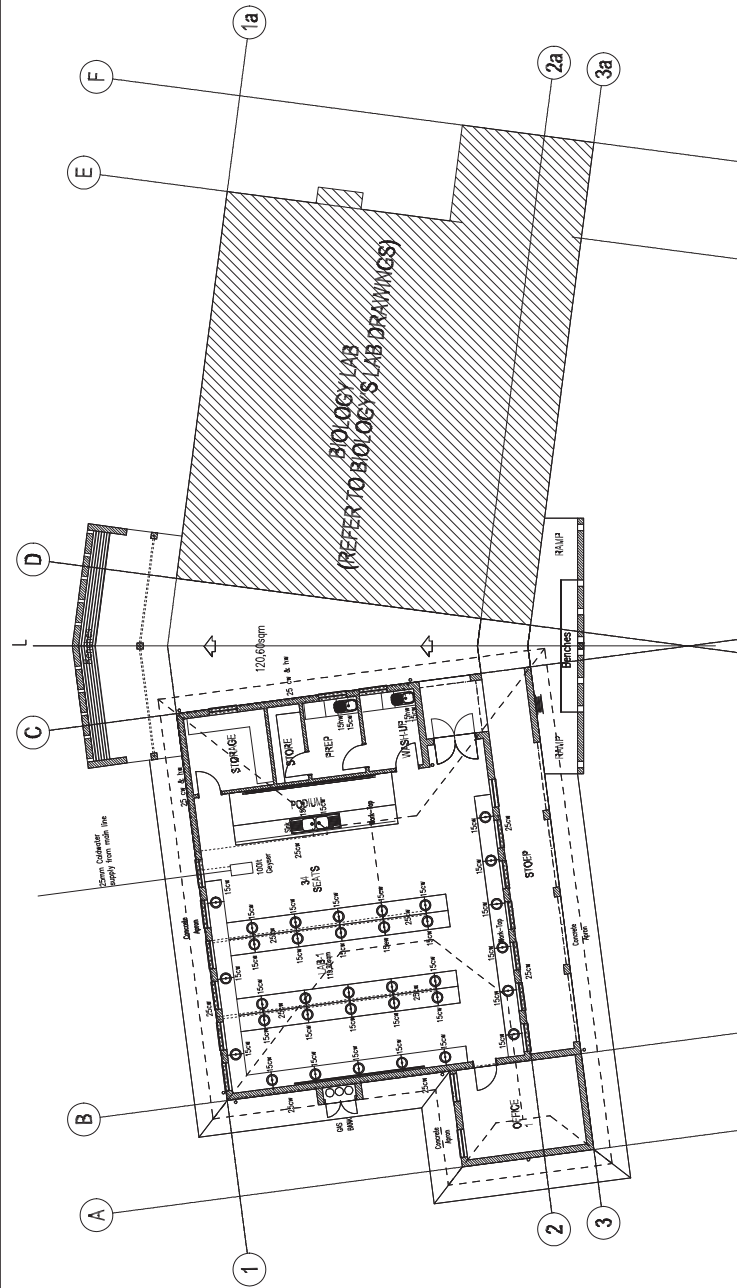

**GROUND FLOOR PLAN:
WATER RETICULATION:
SCIENCE LABORATORY:
Scale 1:100.**

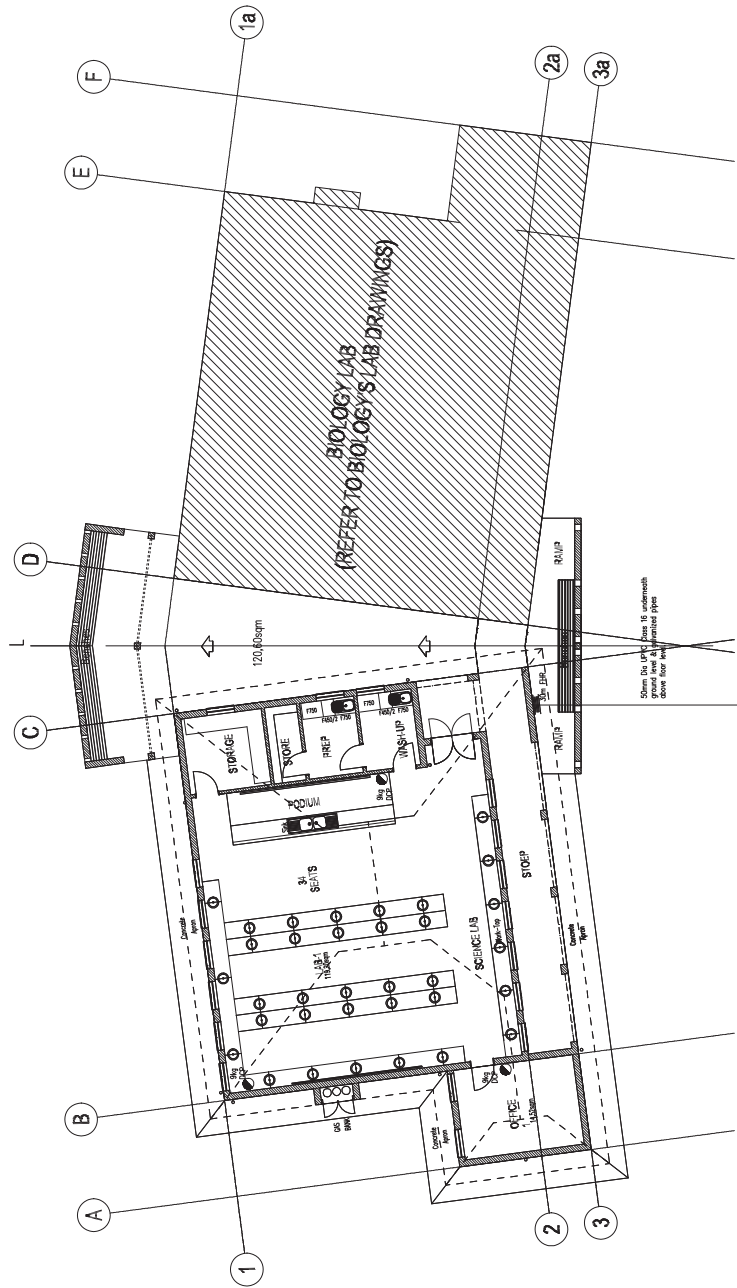

**GROUND FLOOR PLAN:
FIRE EQUIPMENT LAYOUT:
SCIENCE LABORATORY:
Scale 1:100.**

NOTE:
ALL FIRE EQUIPE SIGNAGE ACCORDING
TO SANS STANDARDS 159 & 158mm