


SPECIAL NOTES:

MINIMUM REQUIRED LIGHTING LUX
LEVELS AS PER PL 682 SPEC

- NOTES:
- 1. RACKING TO COMPLY WITH TPL SPECIFICATION PL727.
 - 2. RACKING MATERIAL: GALVANISED STEEL LADDER RACK.
 - 3. RACKING TO BE INSTALLED 300mm CLEAR OF FLANGES (TO ALLOW FOR FLOGGING ACCESS).
 - 4. INSTRUMENT AND ELECTRICAL RACKS TO CROSS AT 90 DEGREES.
 - 5. DOUBLE BANKING OF CABLES ON RACKS IS PERMITTED.
 - 6. ONLY MAIN RACKING RETICULATION ROUTES ARE SHOWN. SECONDARY RACKING AND ANGLE IRON DROPPERS TO BE SITE RUN.

SYMBOL	DESCRIPTION	QTY	MAKE
Z1	SUITABLE ZONE 1 EX LED LUMINAIRE	0	TBC
Z2	SUITABLE ZONE 2 EX LED LUMINAIRE	8	TBC
RM	RAIL MOUNT	8	
FM	FLOOR MOUNT	0	
BM	BUND MOUNT	0	
	PROPOSED CABLE ROUTE		

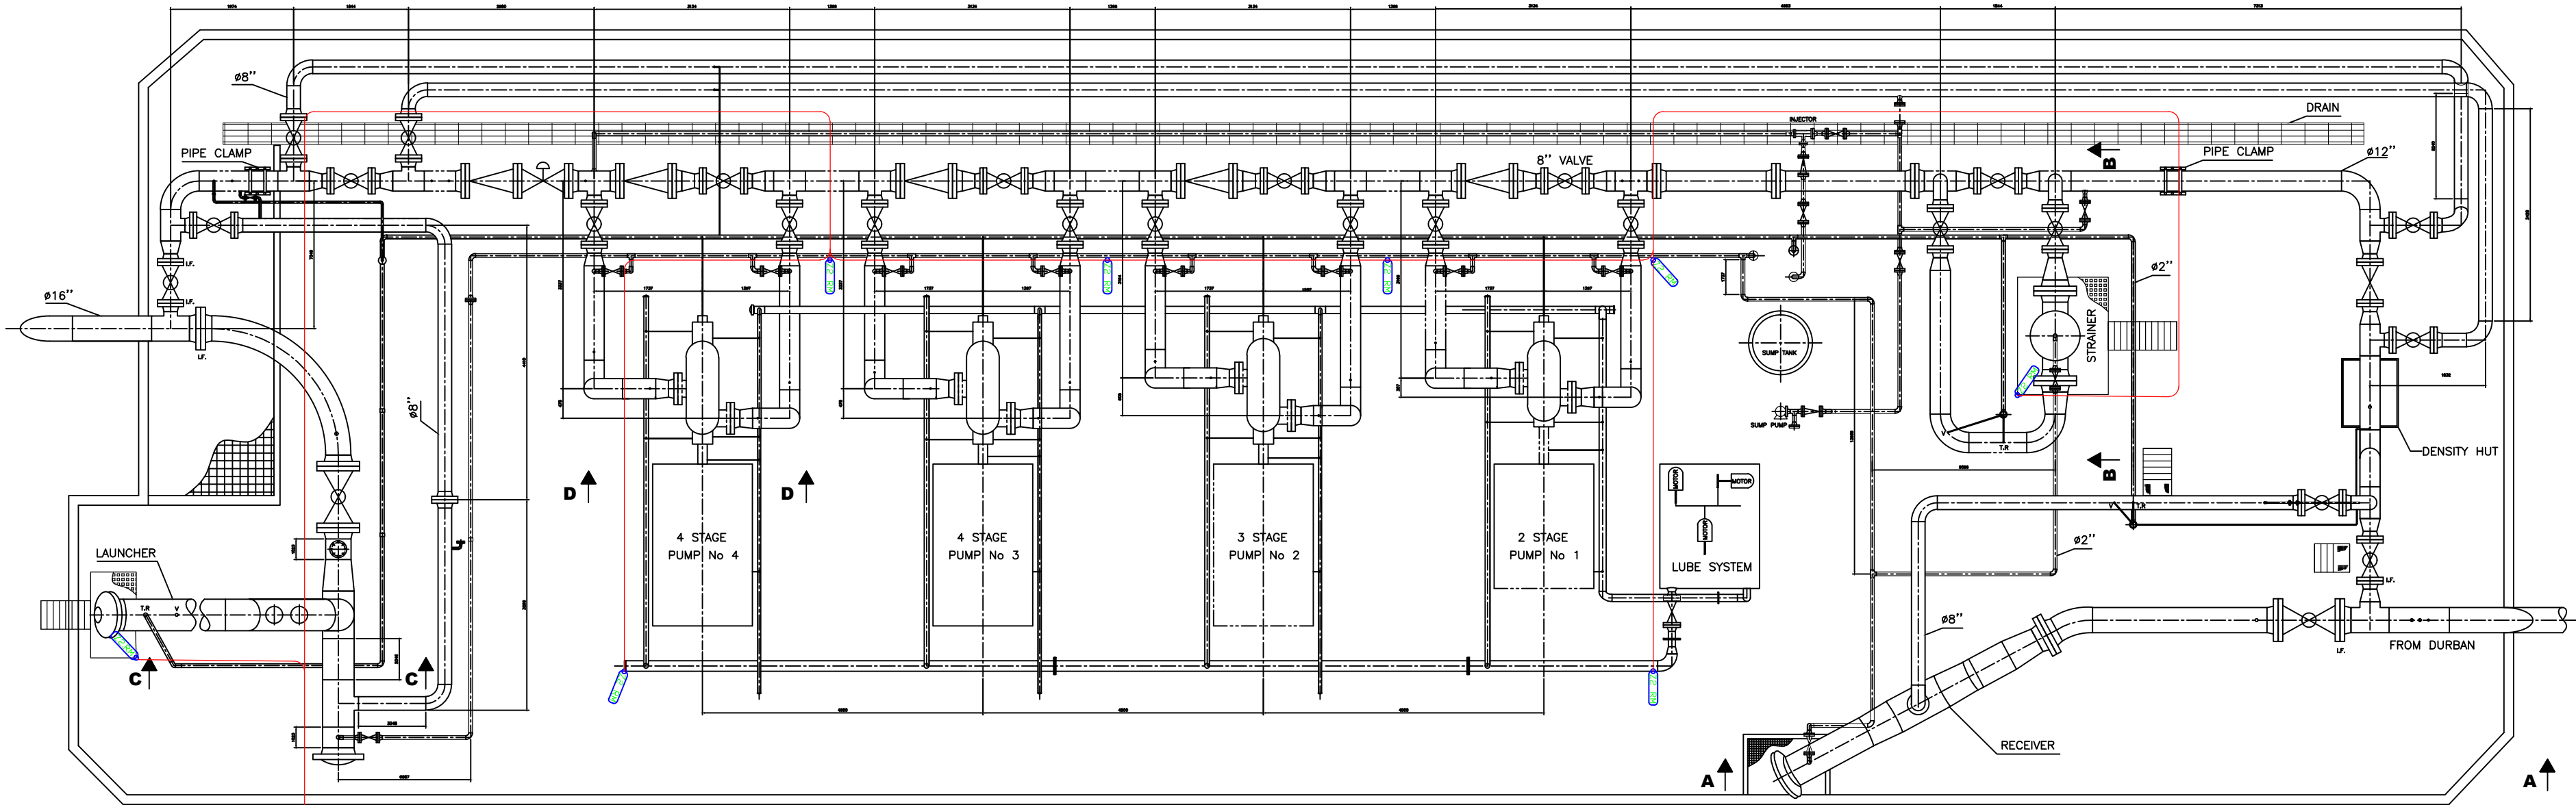

PLAN LAYOUT

SUBSTATION	CONTROL ROOM
FED FROM DBA MAIN DB Q34 & Q35	

PROPOSAL



MANIFOLD LIGHTING LAYOUT
HILLCREST DEPOT

REVISIONS		
PROJECT NAME LIGHTING UPGRADE		
DRAWN	W.D	REF.
TRACED	CAD	DATE 06.07.21
CHECKED	K.N	APPROVED Z.M
SCALE	NTS	
DRAWING No.		REV
PL121648		