



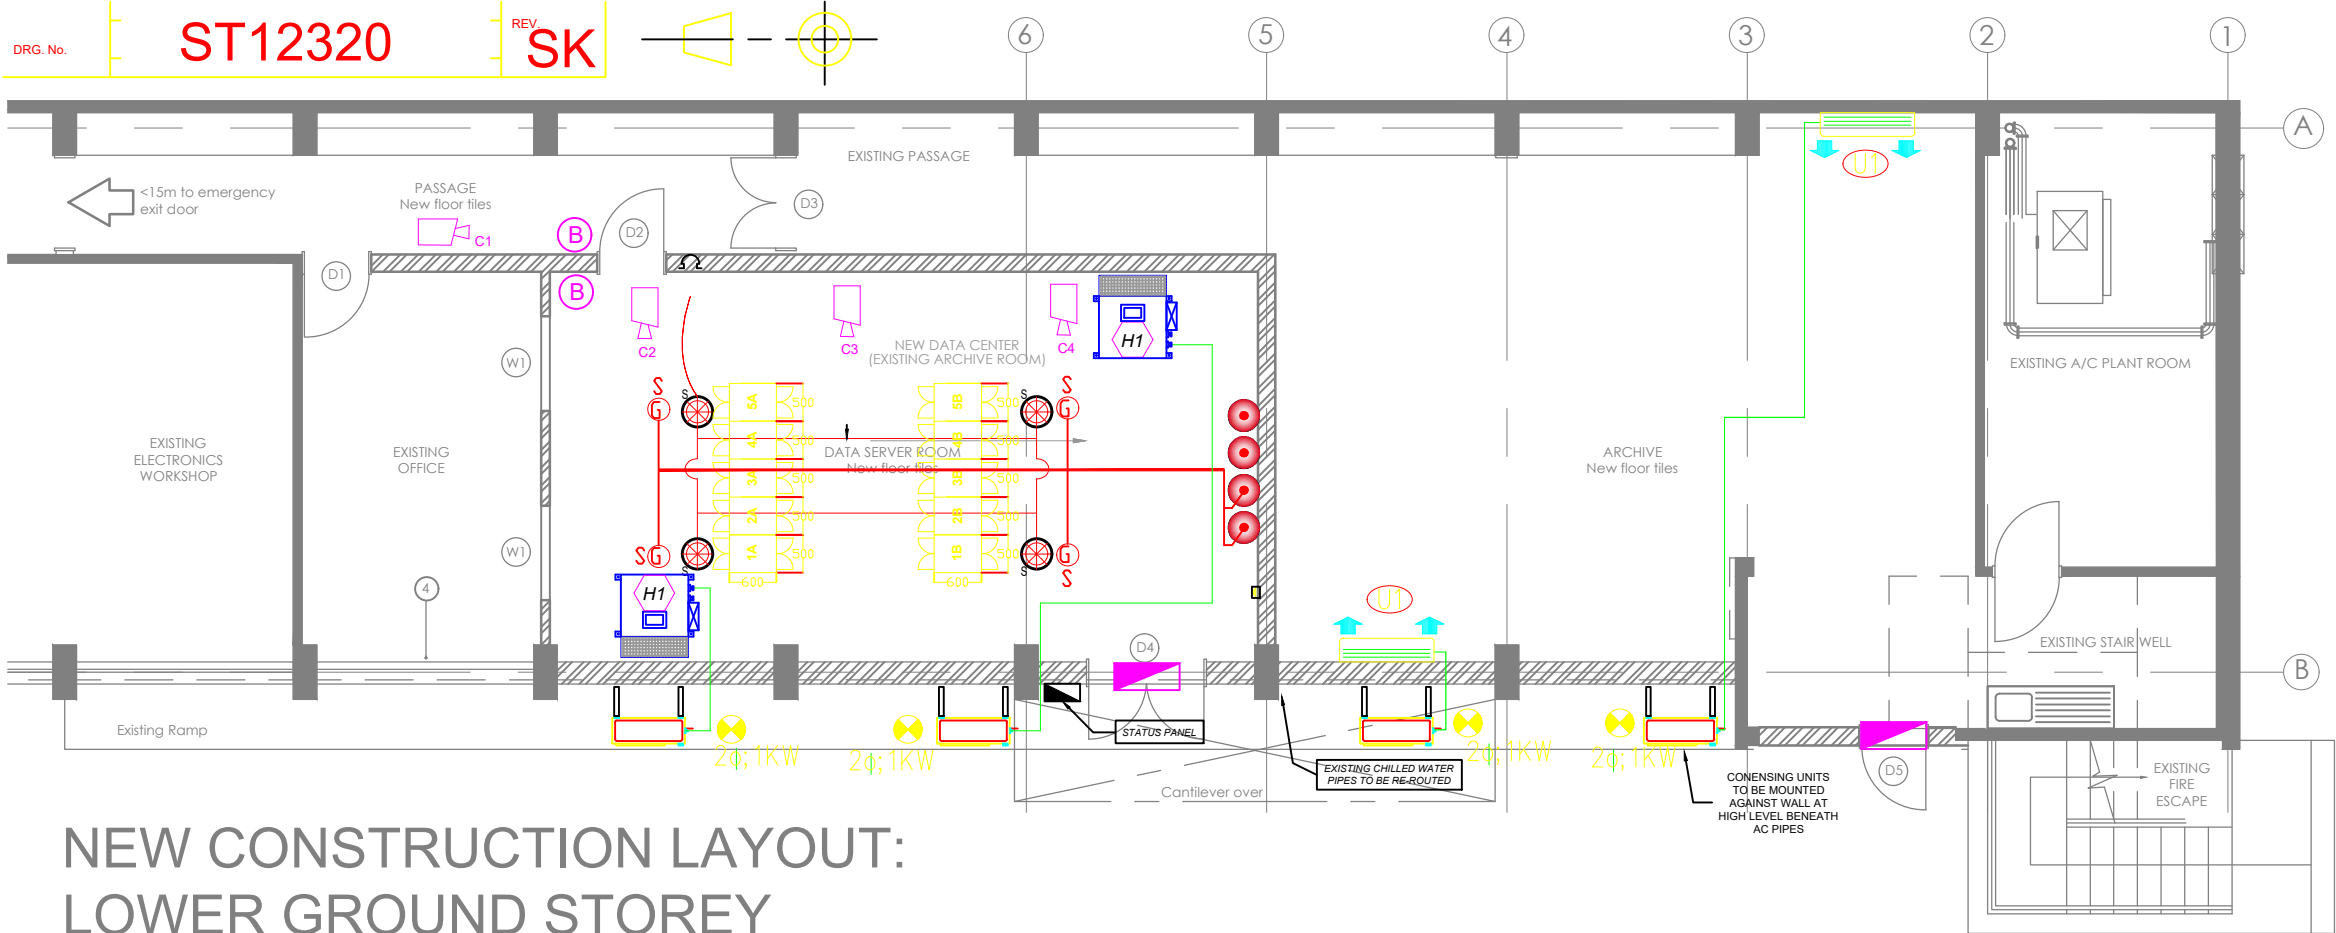

NEW CONSTRUCTION LAYOUT:
LOWER GROUND STOREY

SCALE 1 : 100

- LEGEND**
- (B) = BIOMETRIC READER
 - CCTV CAMERA
 - EMERGENCY DOOR MONITORING

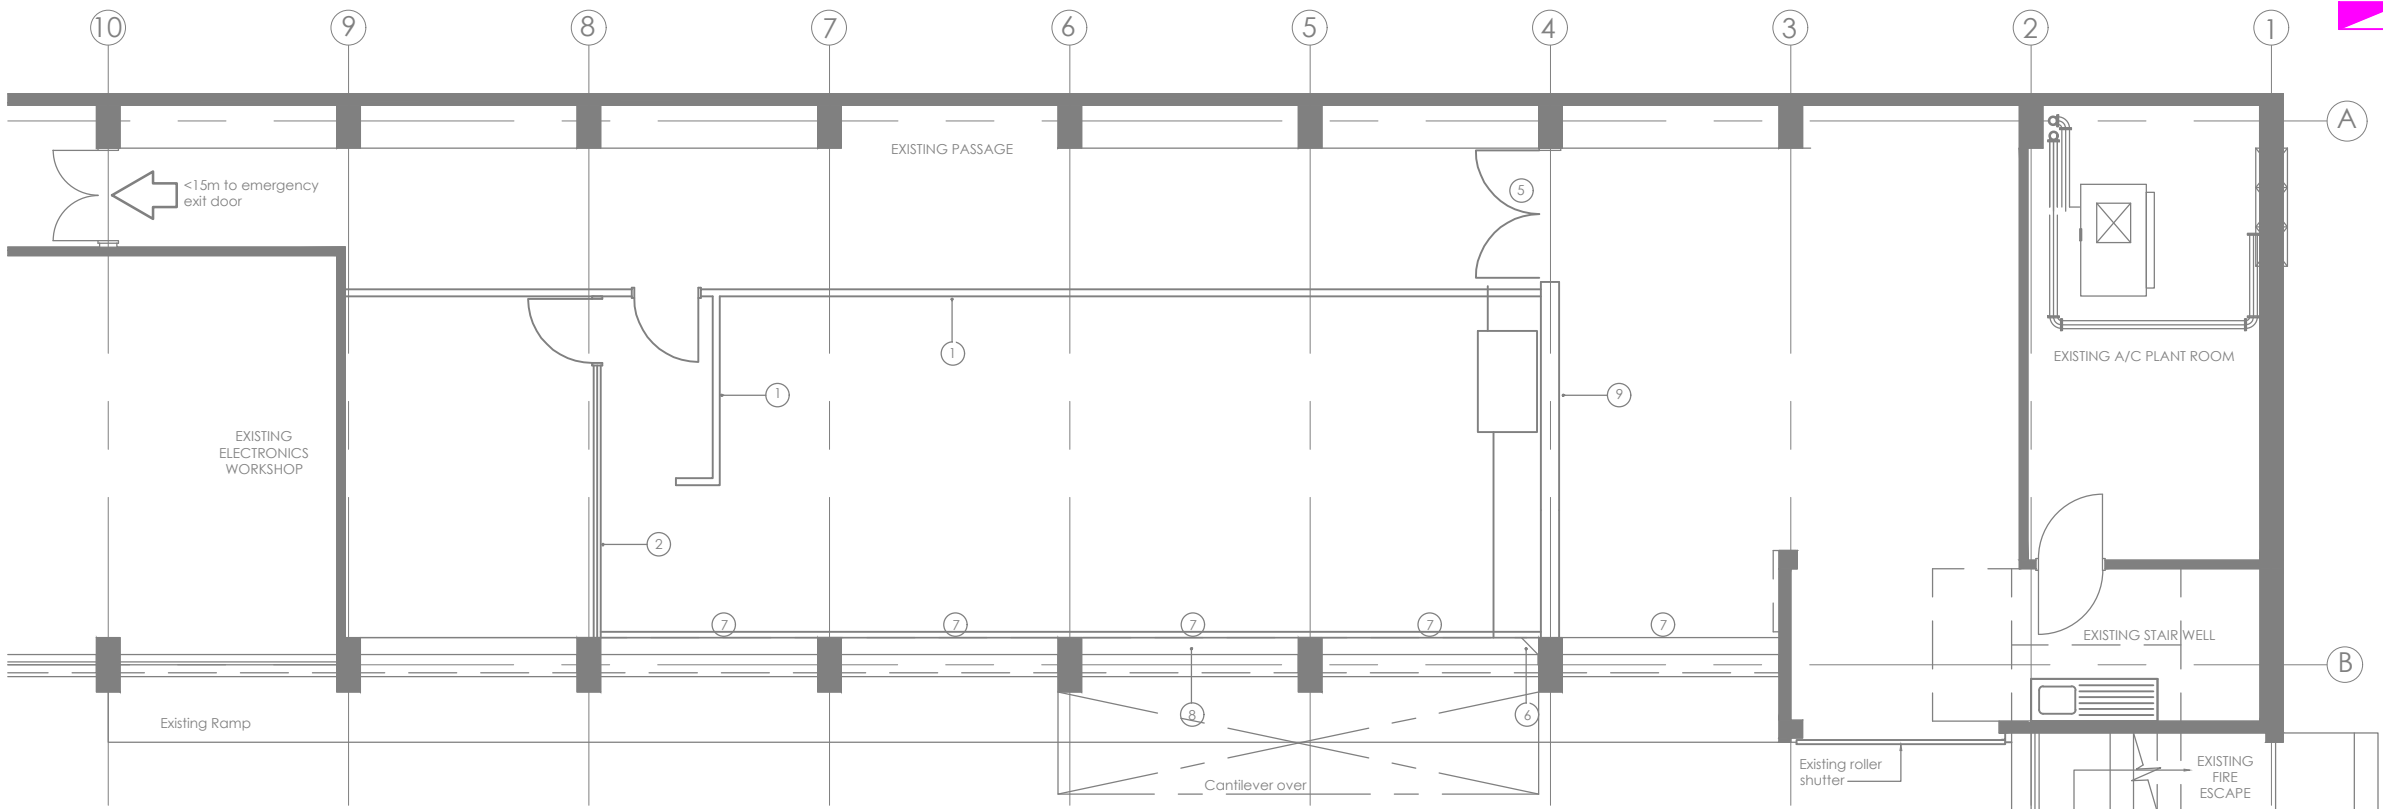

DEMOLITION LAYOUT:

REVISIONS			
NO.	DESCRIPTION	DAT.	APPVD.

DETAIL NO.	PART OF	WHERE USED	QTY.
Studio Technology Private Bag X1 Auckland Park 2006 Studio Technology ENGINEERING SERVICES SABC Tel:(011)714-9111 FAX:(011)714-5885 SABC Copyright C A DIVISION OF THE SABC DATE 2022-11-23			
DO NOT SCALE THIS DRG.		DRAWN	MK
TOLERANCES		CHECKED	
NO DEC PLACE ±0,5 ONE DEC PLACE ±0,2		ENG.	
		APPVD.	
TITLE			
BLOEMFONTEIN DATA CENTRE SECURITY LAYOUT			
DEPT.	DRAWING NO.	REV.	
	ST12320	SK	
SCALE	N/A	SHEET	1 OF 0