


REVISIONS			
NO.	DESCRIPTION	DAT.	APPRV.
A1	ISSUED FOR TENDER	13.04.23	S.T
F1 70W RECESSED FLUORESCENT LED PANEL 1200X600 F2 40W SURFACE MOUNTED LED PANEL 1200X300 FRAME. SINGLE LEVER LIGHT SWITCH MOUNTED @900mm AFFL. SINGLE LEVER 2 WAY LIGHT SWITCH MOUNTED @900mm AFFL.			

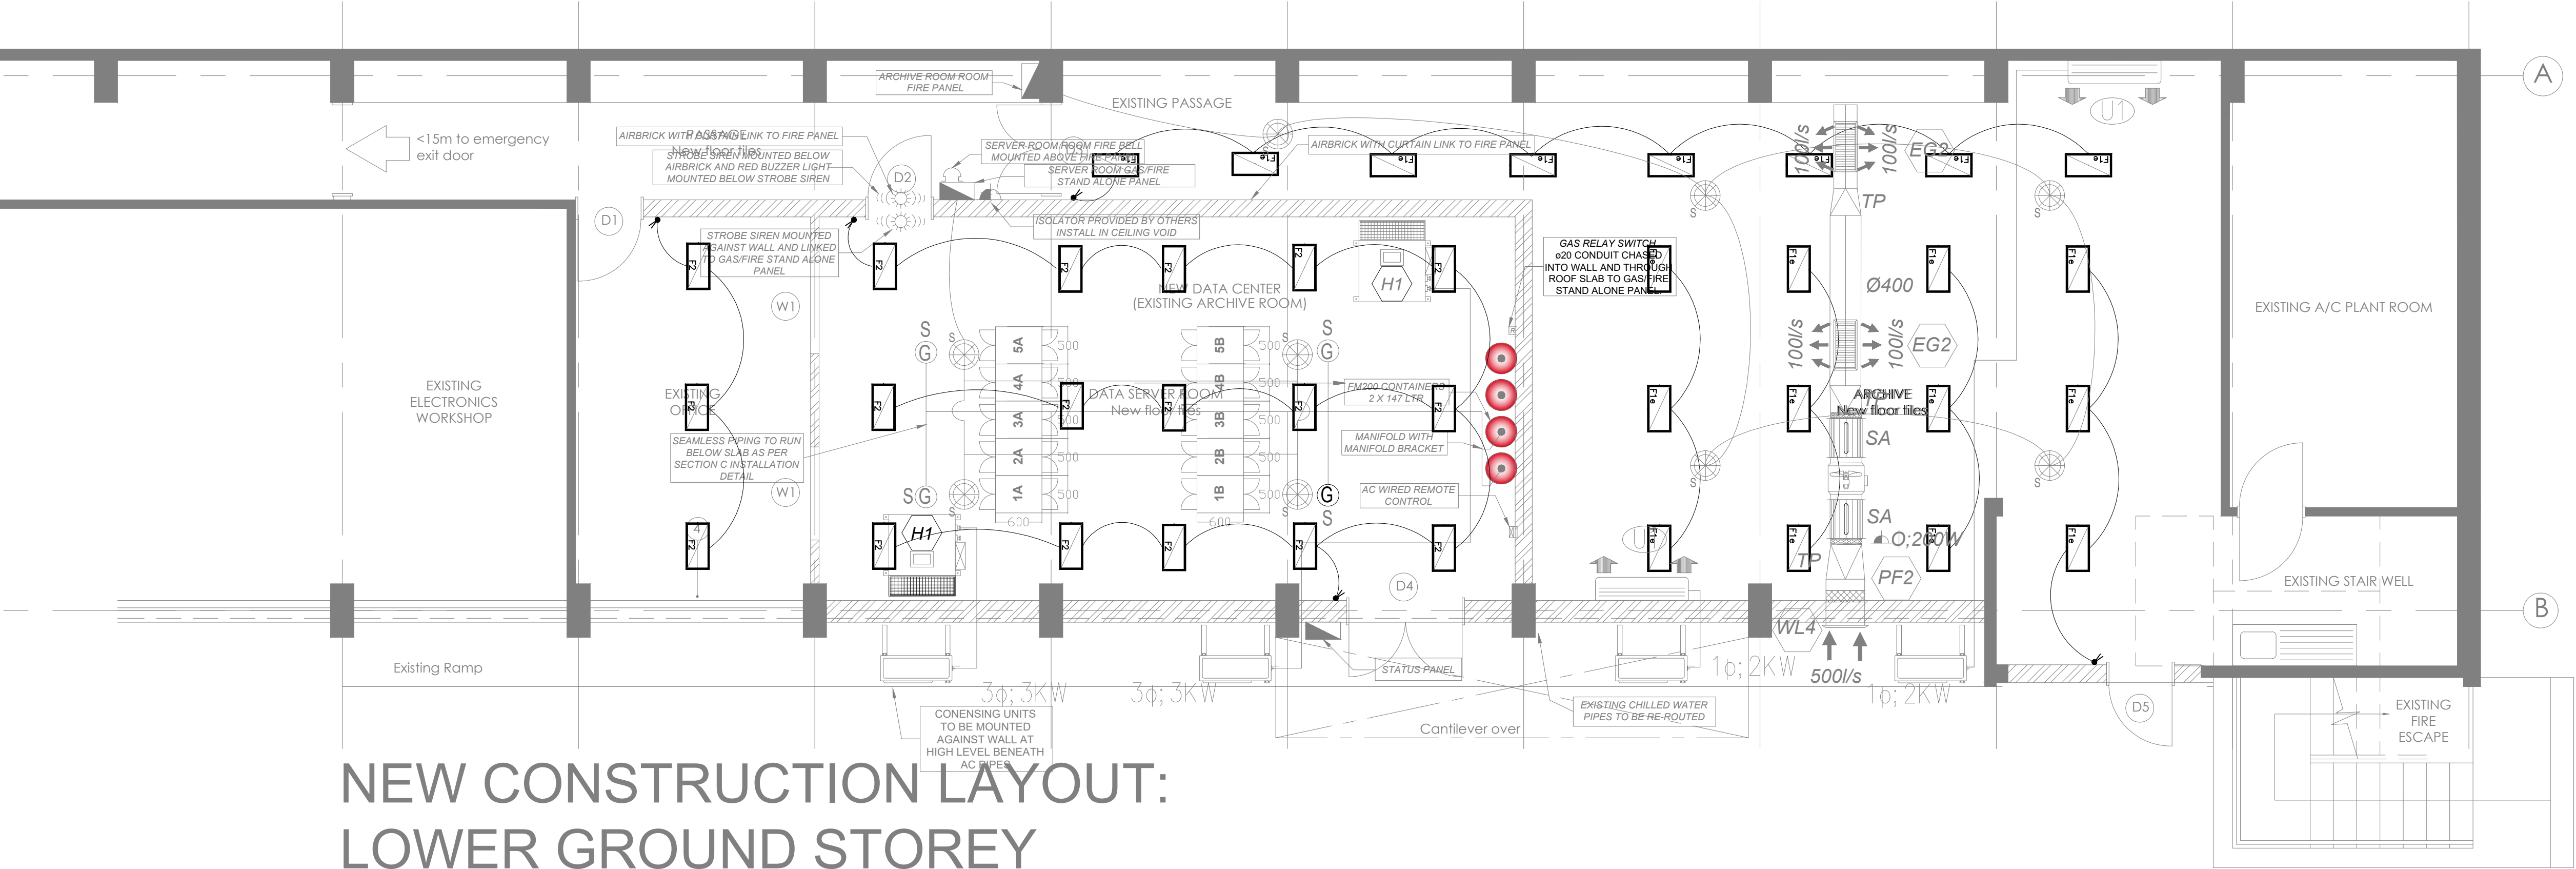

NEW CONSTRUCTION LAYOUT:
LOWER GROUND STOREY

SCALE 1 : 100

QTY	ITEM No.	PART No.	DESCRIPTION	MANUF.
MATERIAL LIST				
Studio Technology Private Bag X1 Auckland Park 2006			TITLE / TITLE	
Studio Technology SABC ENGINEERING SERVICES Tel: (011) 714-9111 Fax: (011) 714-5885 SABC Copyright © A DIVISION OF THE SABC			SABC BLOEMFONTEIN LOWER GROUND FLOOR DATA CENTRE ELECTRICAL INSTALLATION LIGHTING LAYOUT	
DO NOT SCALE THIS DRG.		DRAWN	S.T	DATE 08-11-22
TOLERANCES		CHECKED	S.T	
NO DEC PLACE ±0,5 ONE DEC PLACE ±0,2		ENG.	S.T	
		APPRVD.		
DEPT.			DRAWING NO.	REV.
			ST15063	A1
SCALE			1:100	SHEET 1 OF 2