


REVISIONS			
NO.	DESCRIPTION	DATE	APPROV.
A1	ISSUED FOR TENDER	13.04.23	S.T

	DOUBLE SWITCHED SOCKET OUTLET FLUSH MOUNTED AT 300mm AFFL, MEASURED TO CENTER OF OUTLET. (Unless Otherwise Indicated)
	20A DOUBLE POLE ISOLATOR.
	INTERNATIONAL SOCKET OUTLET. MOUNTED AT 300mm AFFL, MEASURED TO CENTER OF OUTLET. (Unless Otherwise Indicated)
	4x2 STEEL BOX AT 1000mm AFFL FOR BIOMETRIC CARD READER.
	COMMUNICATIONS POINT FOR TELEPHONE. FLUSH MOUNTED.
	COMMUNICATIONS POINT FOR DATA. FLUSH MOUNTED.
	CABLE BASKET AS SPECIFIED.
	32A 3-PIN CEE-FORM OUTLET.
	TRIPLE POLE ISOLATOR.

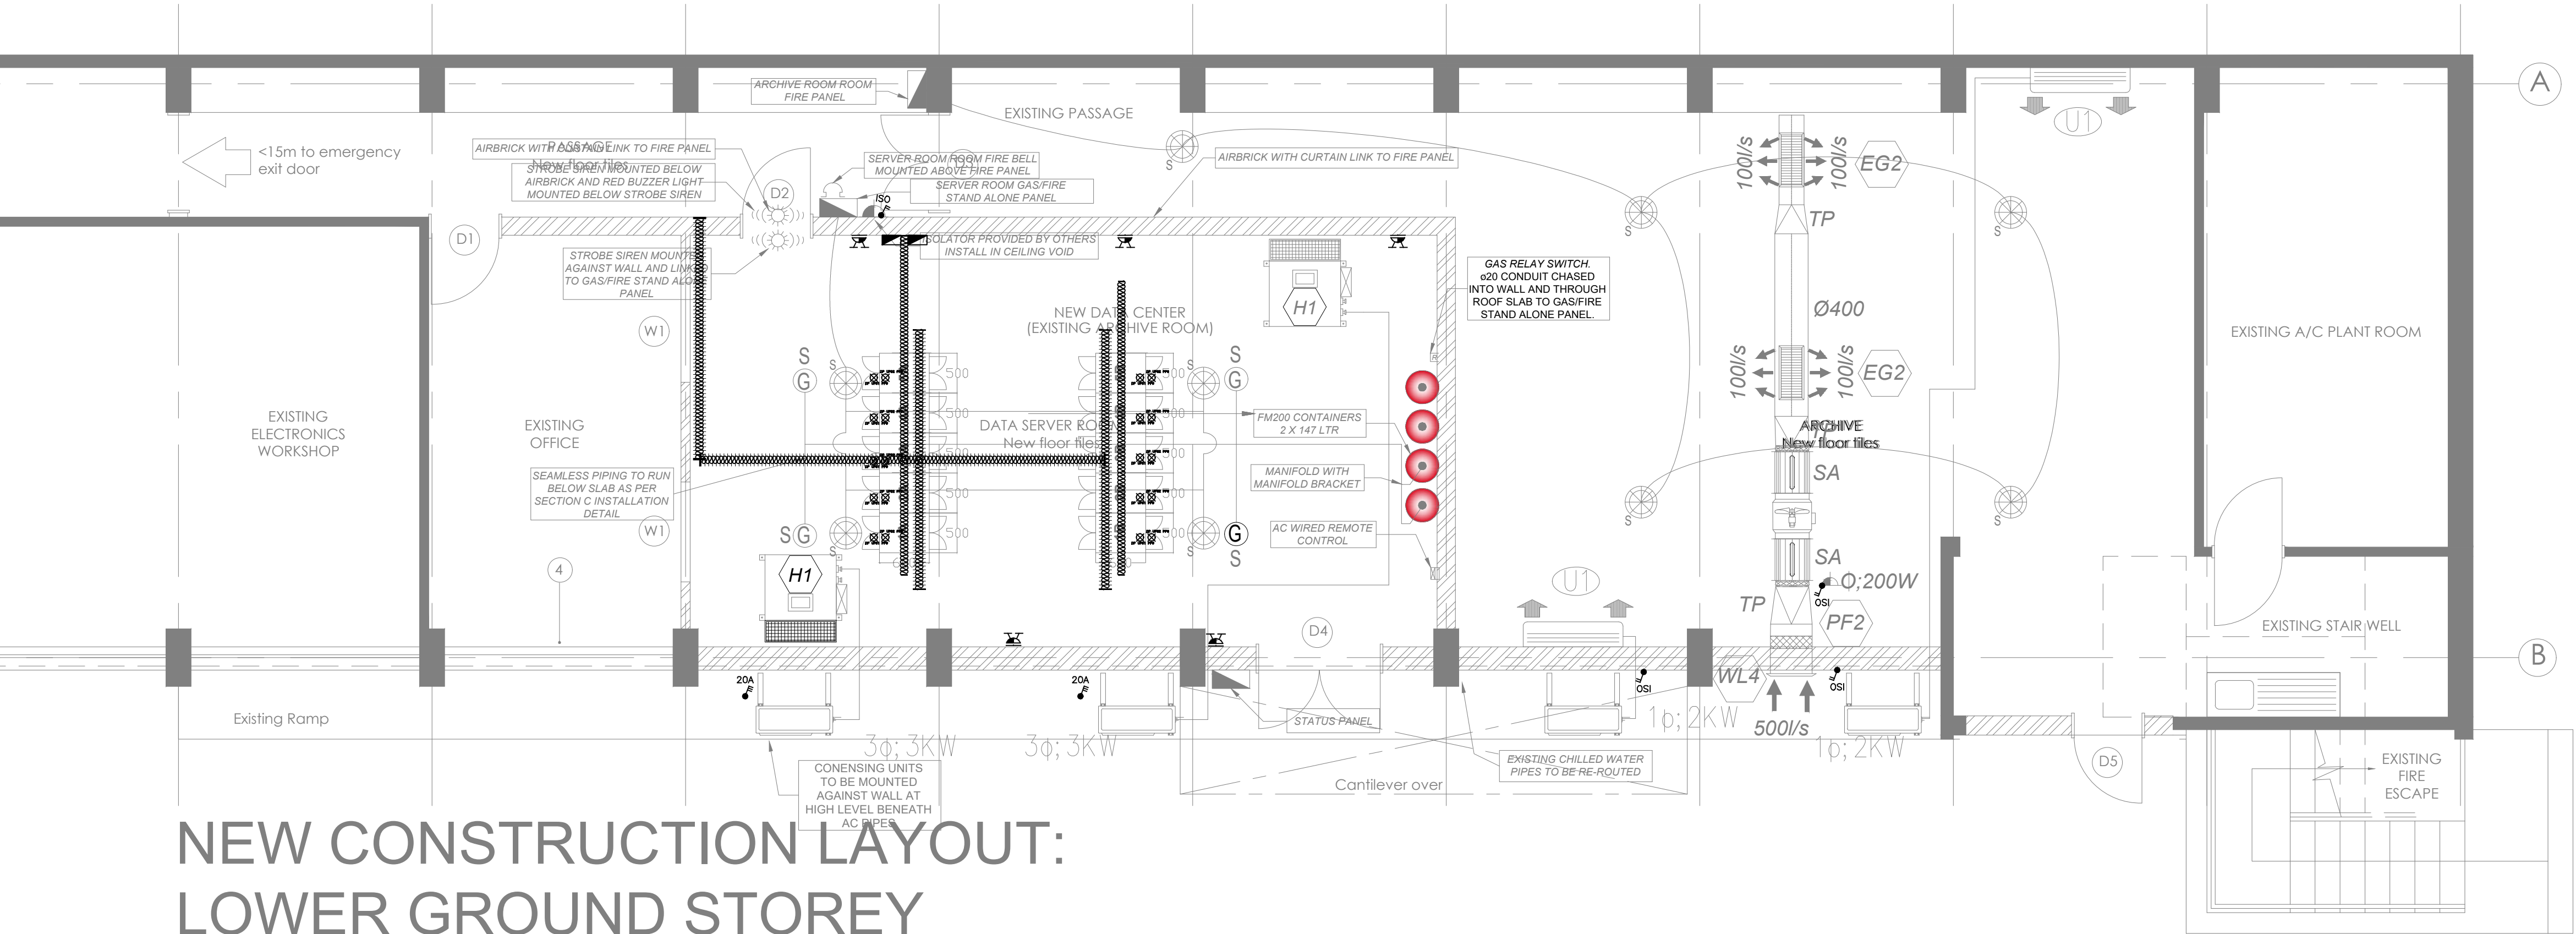

NEW CONSTRUCTION LAYOUT:
LOWER GROUND STOREY

SCALE 1 : 100

QTY	ITEM No.	PART No.	DESCRIPTION	MANUF.
MATERIAL LIST				
TITLE / TITEL				
Studio Technology Private Bag X1 Auckland Park 2006			 SABC Tel: (011) 714-9111 Fax: (011) 714-5885 SABC Copyright © A DIVISION OF THE SABC	
ENGINEERING SERVICES			SABC BLOEMFONTEIN LOWER GROUND FLOOR DATA CENTRE ELECTRICAL INSTALLATION POWER LAYOUT	
DO NOT SCALE THIS DRG.		DRAWN	S.T	DATE 08-11-22
TOLERANCES		CHECKED	S.T	
NO DEC PLACE ±0,5 ONE DEC PLACE ±0,2		ENG.	S.T	
		APPROV.		
DEPT.			DRAWING NO.	
			ST15063	
			A1	
SCALE			1:100	
SHEET			2 OF 2	