


LEGEND	
	Bulk water
	Water connection
	Bulk stormwater
	Stormwater
	Bulk sewer
	Drainage
	Bulk electricity
●	Data cable
SWP	Stormwater pipe
SWMH	Stormwater manhole
SP	Sewer pipe
MH	Sewer manhole
FH	Fire Hydrant

REFERENCE DRAWINGS	
This drawing is to be read in conjunction with architects drawings:	
Drawing: 0368-1/CA/1100 TYPICAL B STATION: Plans, Sections & elevations	
Drawing: 0368-1/CA/4400 TYPICAL KIOSK: Plans, sections & elevations	
Drawing: 0368-1/CA/4401 TYPICAL GENERATOR ROOM: Plans, sections & elevations	
Also refer to drawing: 0368-1/CA/5000 STATION MATRIX for a list of station names, types, & locations	
Also refer to all relevant Structural Engineers and Fire Consultants drawings.	

LAND USE INFORMATION	
<b>ZONING</b> Road	
<b>COVERAGE</b> Generator room: 18sqm Station Platform 1: 224sqm Station Platform 2: 167sqm Total: 589sqm	
<b>FLOOR AREAS</b> Generator room: 18sqm Station Platform 1: 169sqm Station Platform 2: 129sqm Link : 143sqm Total: 459sqm	
<b>HEIGHT RESTRICTION</b> Not applicable	
<b>BUILDING LINES</b> Not applicable	

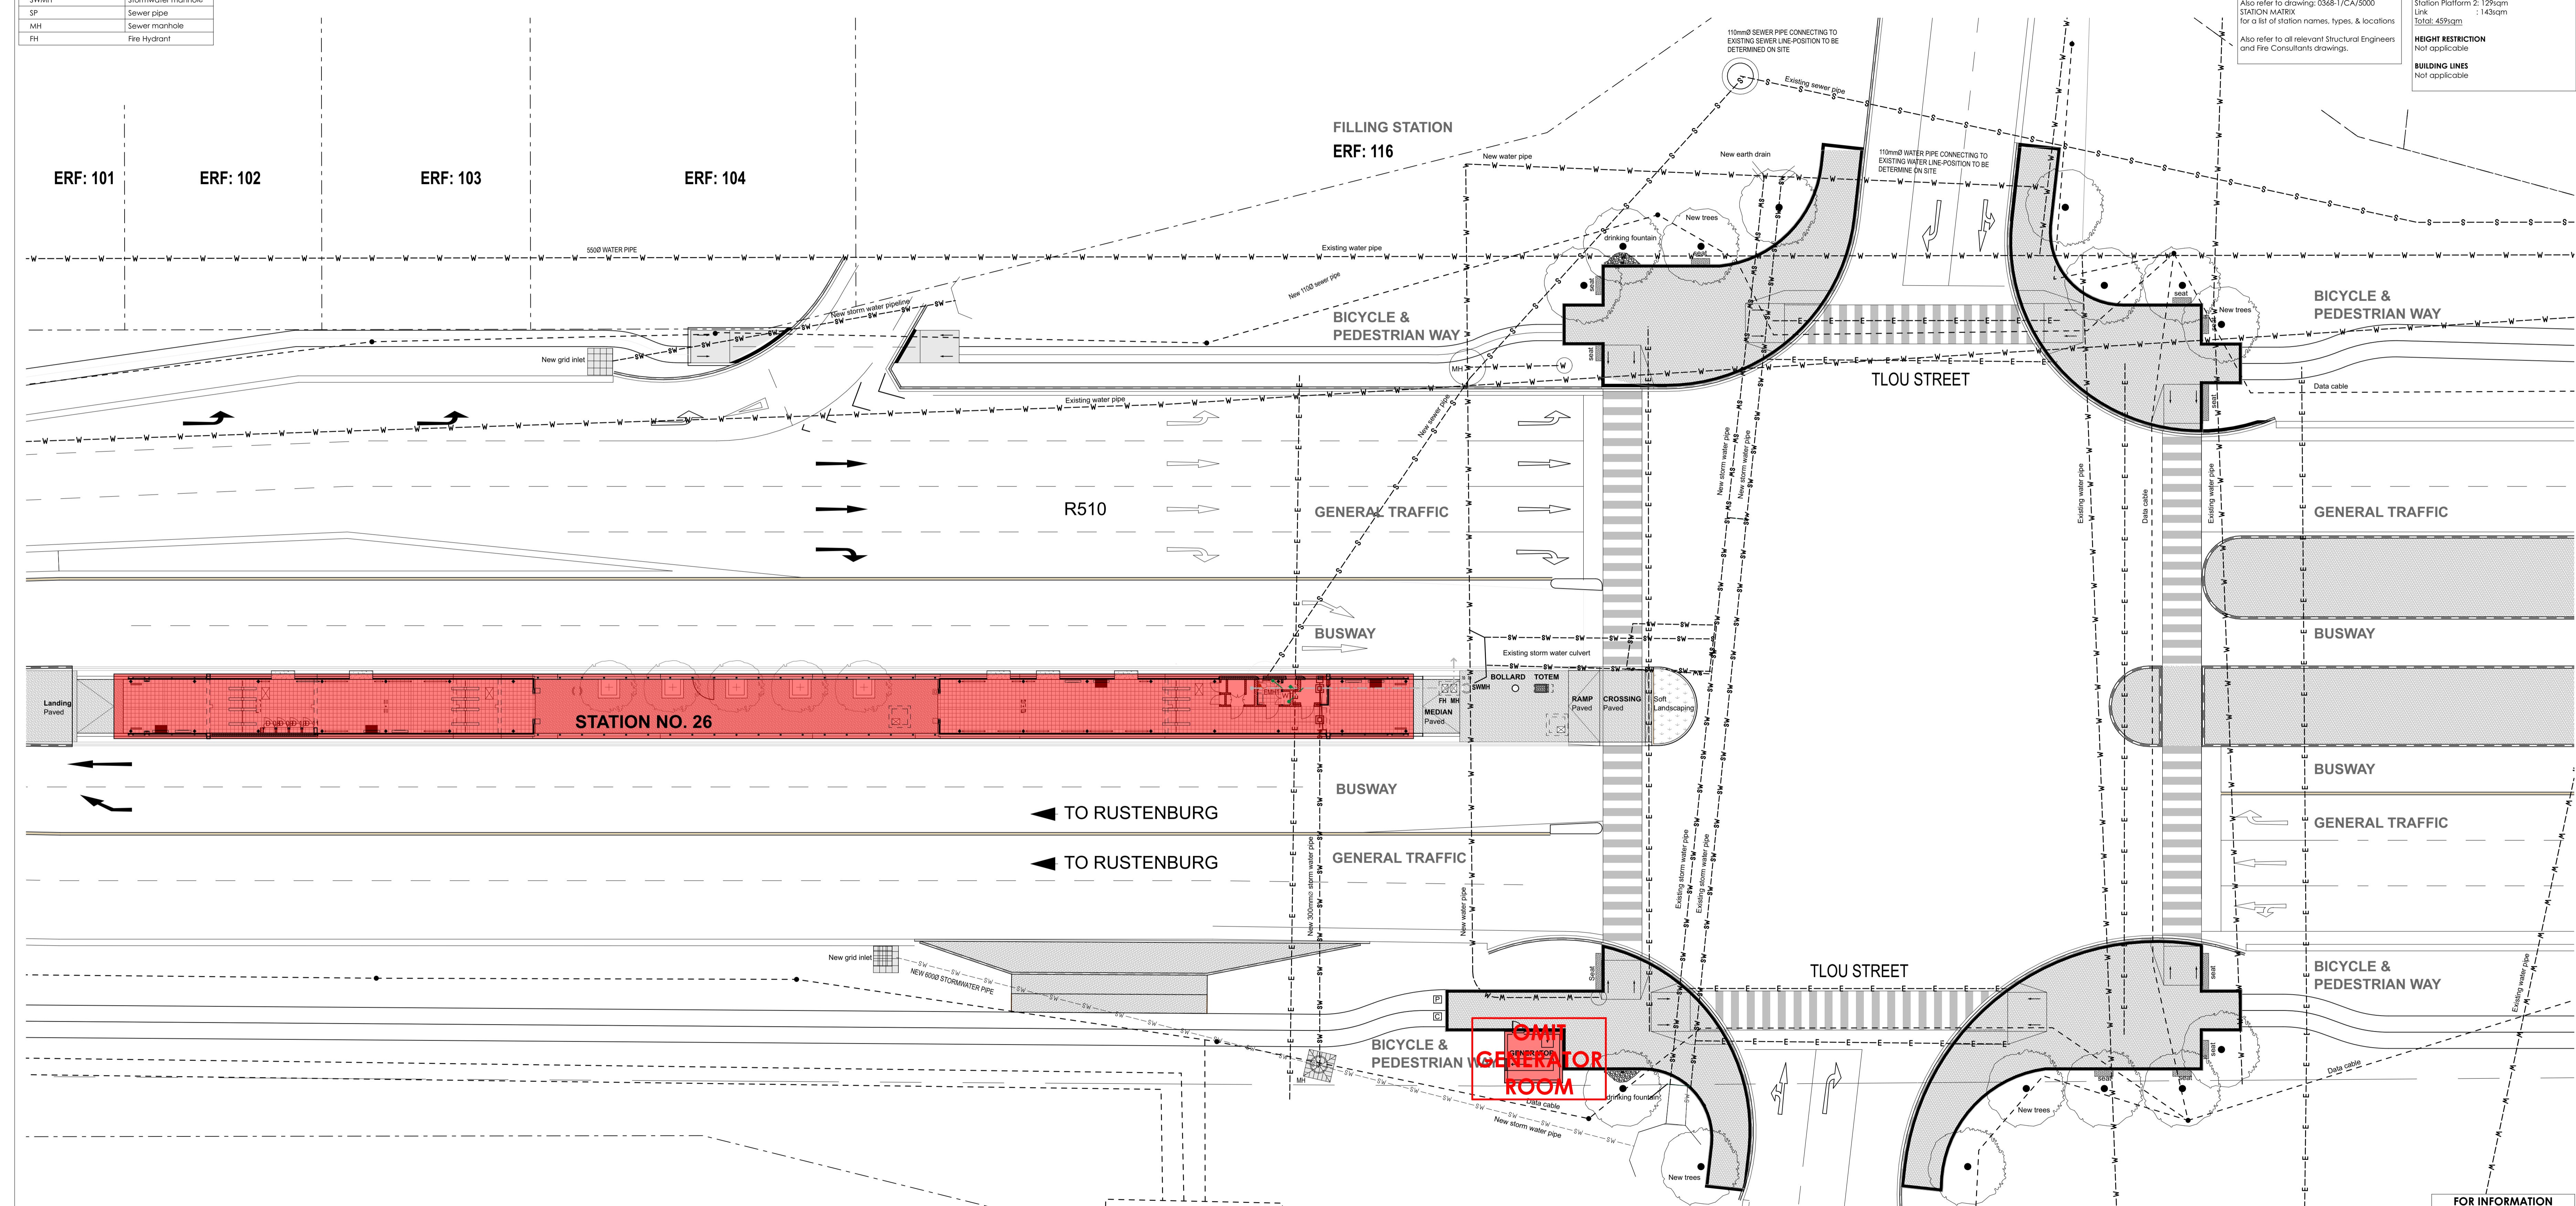

REV	DESCRIPTION	DATE	REV BY	CHKD
10	For Information	18-02-2019	ZC	ZC
0	Council Approval	18-08-2014	TE	KW

DRG. No.	DRAWING TITLE
	REFERENCE DRAWINGS

**GENERAL NOTES**  
 COPYRIGHT OVER ALL DESIGNS AND DRAWINGS SHALL REMAIN THE PROPERTY OF ARG DESIGN AND ANY PROVISION TO THE CONTRARY IN TERMS OF THE COPYRIGHT ACT No. 63 OF 1965 IS HEREBY SPECIFICALLY EXCLUDED.  
 ALL RELEVANT DETAILS, LEVELS AND DIMENSIONS ARE TO BE CHECKED ON SITE PRIOR TO COMMENCEMENT OF WORK. ANY DISCREPANCIES ARE TO BE BROUGHT TO THE ATTENTION OF THE ARCHITECT IMMEDIATELY.  
 THE ARCHITECT ACCEPTS NO RESPONSIBILITY FOR ERRORS RESULTING FROM MISINTERPRETATION OF THE DRAWINGS.  
 ALL WORK TO BE CARRIED OUT STRICTLY IN ACCORDANCE WITH NATIONAL BUILDING REGULATIONS, SANS 5400 AND LOCAL AUTHORITY REGULATIONS.  
 ALL DIMENSIONS ARE GIVEN IN MILLIMETERS.  
 DO NOT SCALE THE DRAWINGS.

**ARCHITECT**  
  
 114 De Waalsesteenweg  
 2018 Antwerpen, Belgium  
 T: +32 (0)3 237 448 2998  
 F: +32 (0)3 237 448 2999  
 E: info@argdesign.be  
 W: www.argdesign.be

INITIALS:	SIGNED:	APPROVED BY ENGINEER:
DESIGNED: KW	Kem Westler	PROJ. PRINCIPAL: (PRINT NAME)
DRAWN: TE	Teo Erasmus	PROJ. PRINCIPAL: (SIGNATURE)
CHECKED: KW	Ken Westler	DATE (DDMMYYYY):

DATE:	SIGNED:	APPROVED BY CLIENT:
NON-MOTORISED TRANSPORT APPROVAL		PROJ. PRINCIPAL: (PRINT NAME)
UNIVERSAL ACCESS APPROVAL		PROJ. PRINCIPAL: (SIGNATURE)
		DATE (DDMMYYYY):

**PROJECT**  
 RUSTENBURG RAPID TRANSPORT

**CLIENT**  
 RUSTENBURG LOCAL MUNICIPALITY

**STATION TYPE**  
 B

**PROJECT TITLE**  
 CONSTRUCTION OF RUSTENBURG RAPID TRANSPORT (RRT) STATION SUPER STRUCTURES ZONE B - CORRIDOR B: "NORTH-EAST (BOITEKONG) ROUTE"

**DRAWING DESCRIPTION**  
 Site Plan - Station 26 - Paardekraal Station

**PHASE**  
 I

**AS BUILT PLAN**  
 (Full signature)

CLIENT: \_\_\_\_\_ DATE: \_\_\_\_\_

ENGINEER: \_\_\_\_\_ DATE: \_\_\_\_\_

SCALE	SHEET	SIZE
1:200	1 of 1	A1 (1000x594)
CONTRACT No. RLM/DR10124/2017/18	PROJECT No. 0368	
DRAWING No. C/RR/AR/NE/101-C0	REV 0	